


V-5330
NGL FEED STORAGE BULLET

SERVICE: NGL
SIZE: 3,277 mm ID x 41,367 mm OAL
DESIGN: 1,724 kPa @ -40 / 260°C, C.A.: 0 mm, 103 kPa EXTERNAL
CAPACITY: 343 m³
MATERIAL: CS
MAKE: MAXFIELD INC.

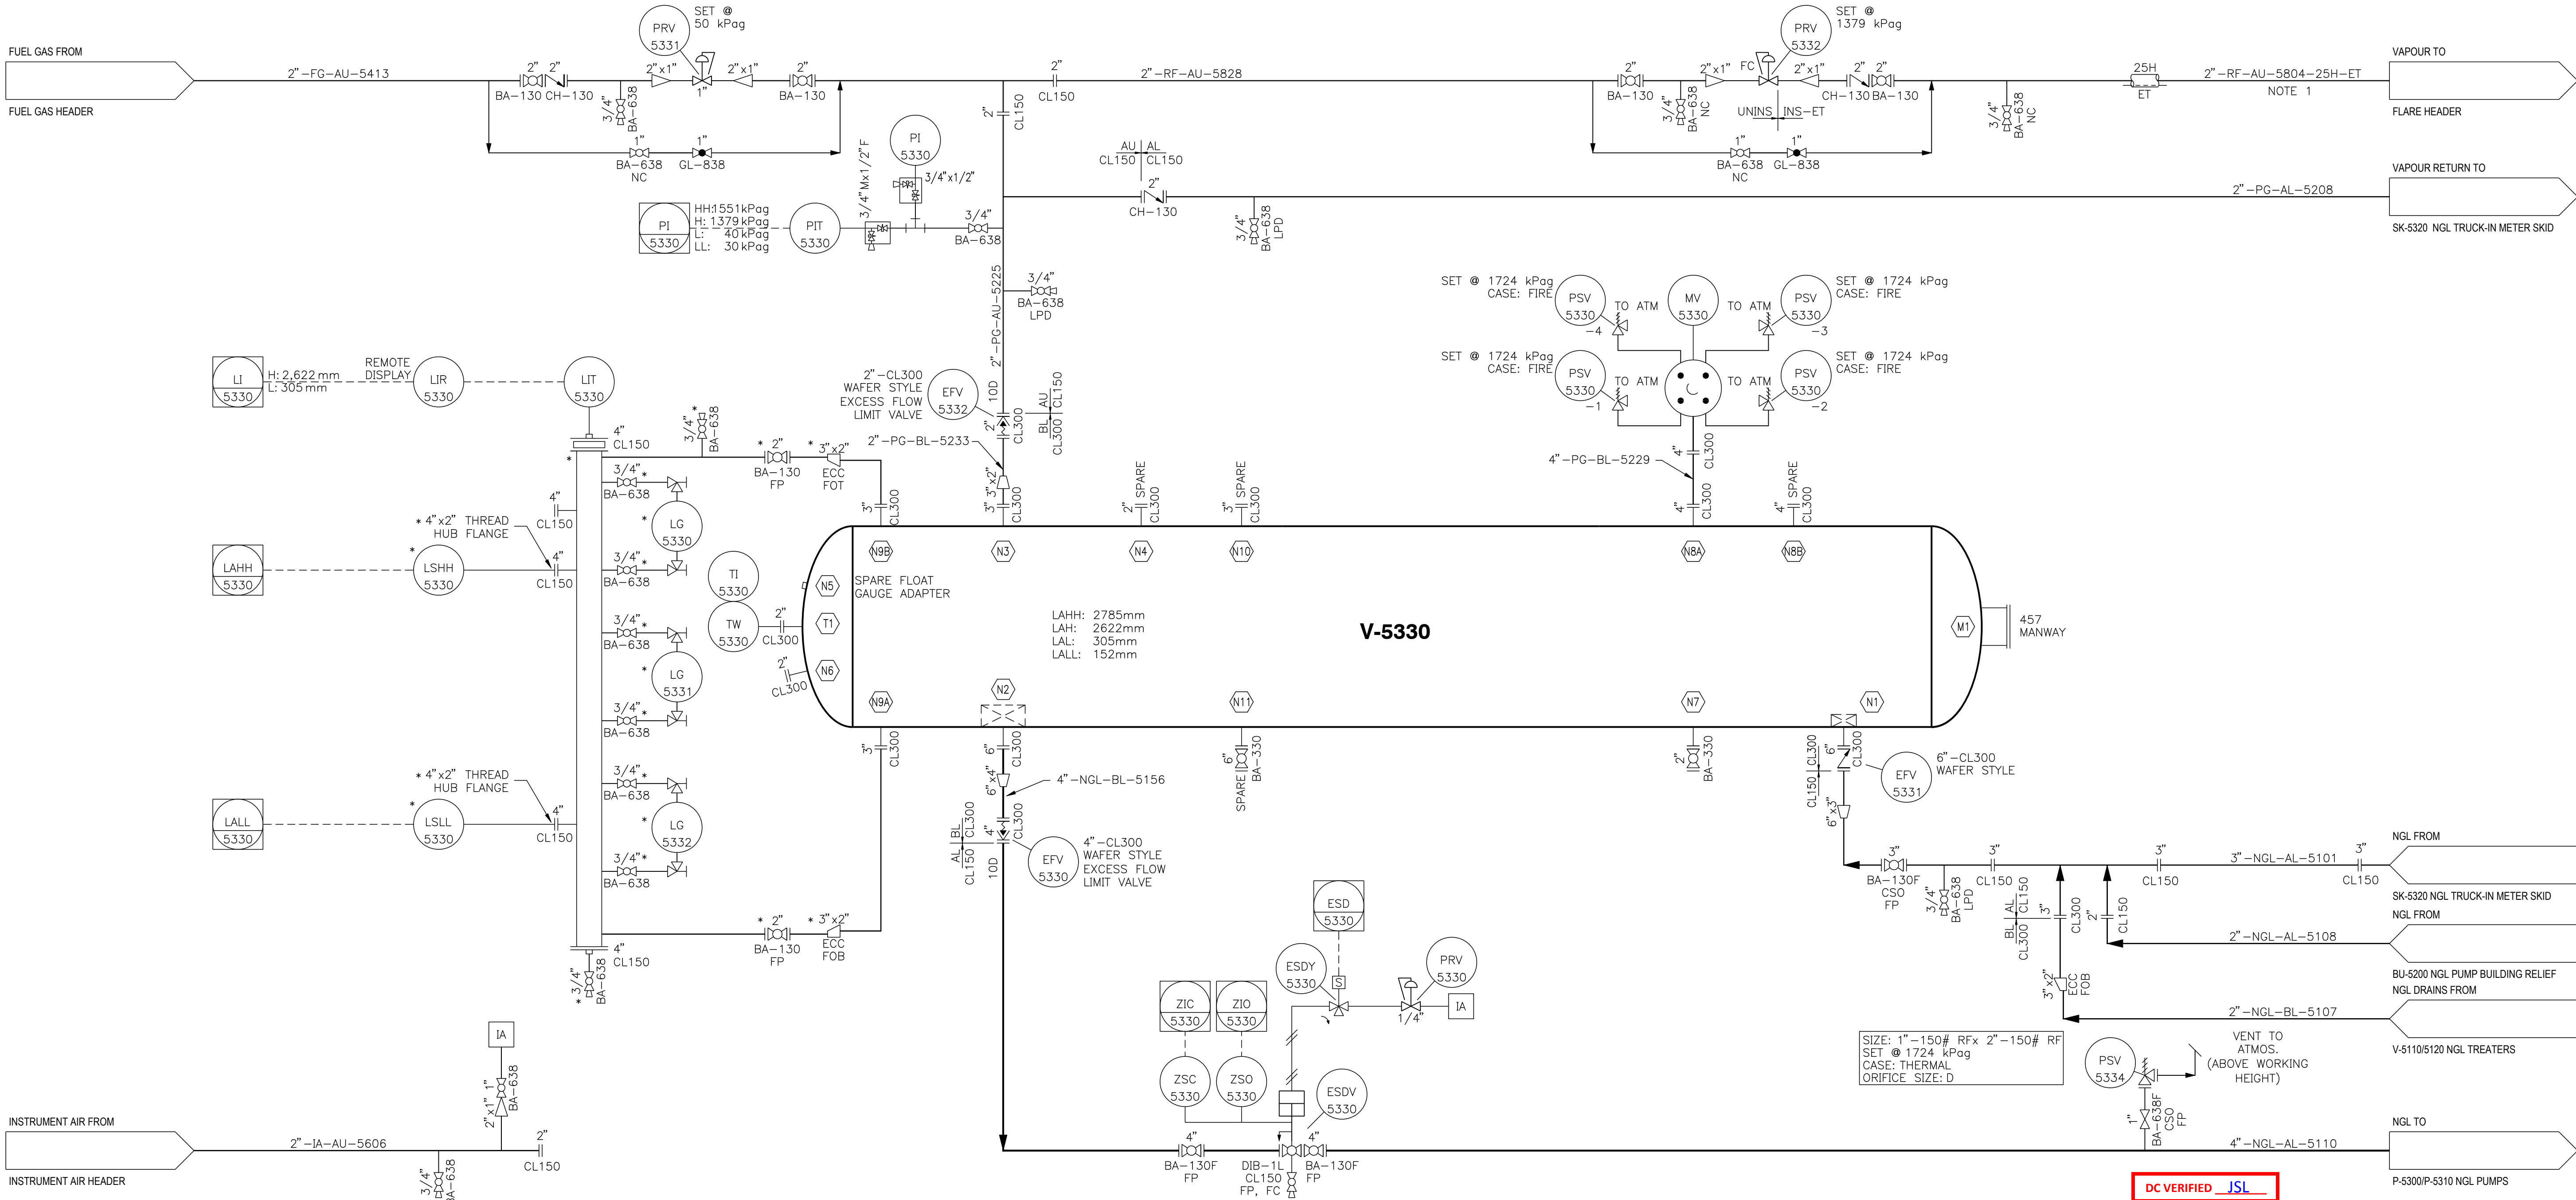


- NOTES:
1. VAPOUR LINES THAT ARE POCKETED ARE TO BE PROVIDED WITH HEAT TRACING.
 2. * INDICATES SUPPLIED BY VENDOR.


REV.	DATE: YY-MM-DD	BY	CHK'D DFTG	CHK'D ENG	APP'D PM	REVISION
0	22-06-30	DAA	YH	CS		



PERMIT:

PERMIT TO PRACTICE
GAS LIQUIDS ENGINEERING LTD.

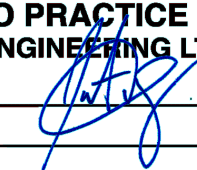RM SIGNATURE: 
RM APEGA ID #: 85378
DATE: 2022-Jul-05
PERMIT NUMBER: P004727
The Association of Professional Engineers and Geoscientists of Alberta (APEGA)

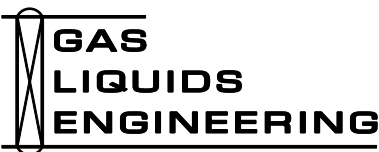

NGL FEED STORAGE BULLET
V-5330
PIPING & INSTRUMENTATION DIAGRAM

SCALE:	DRAWN BY:	DATE CREATED:	PROJECT NO.	DRAWING NO.	REV.
N.T.S.	VJ	21-12-10			0