


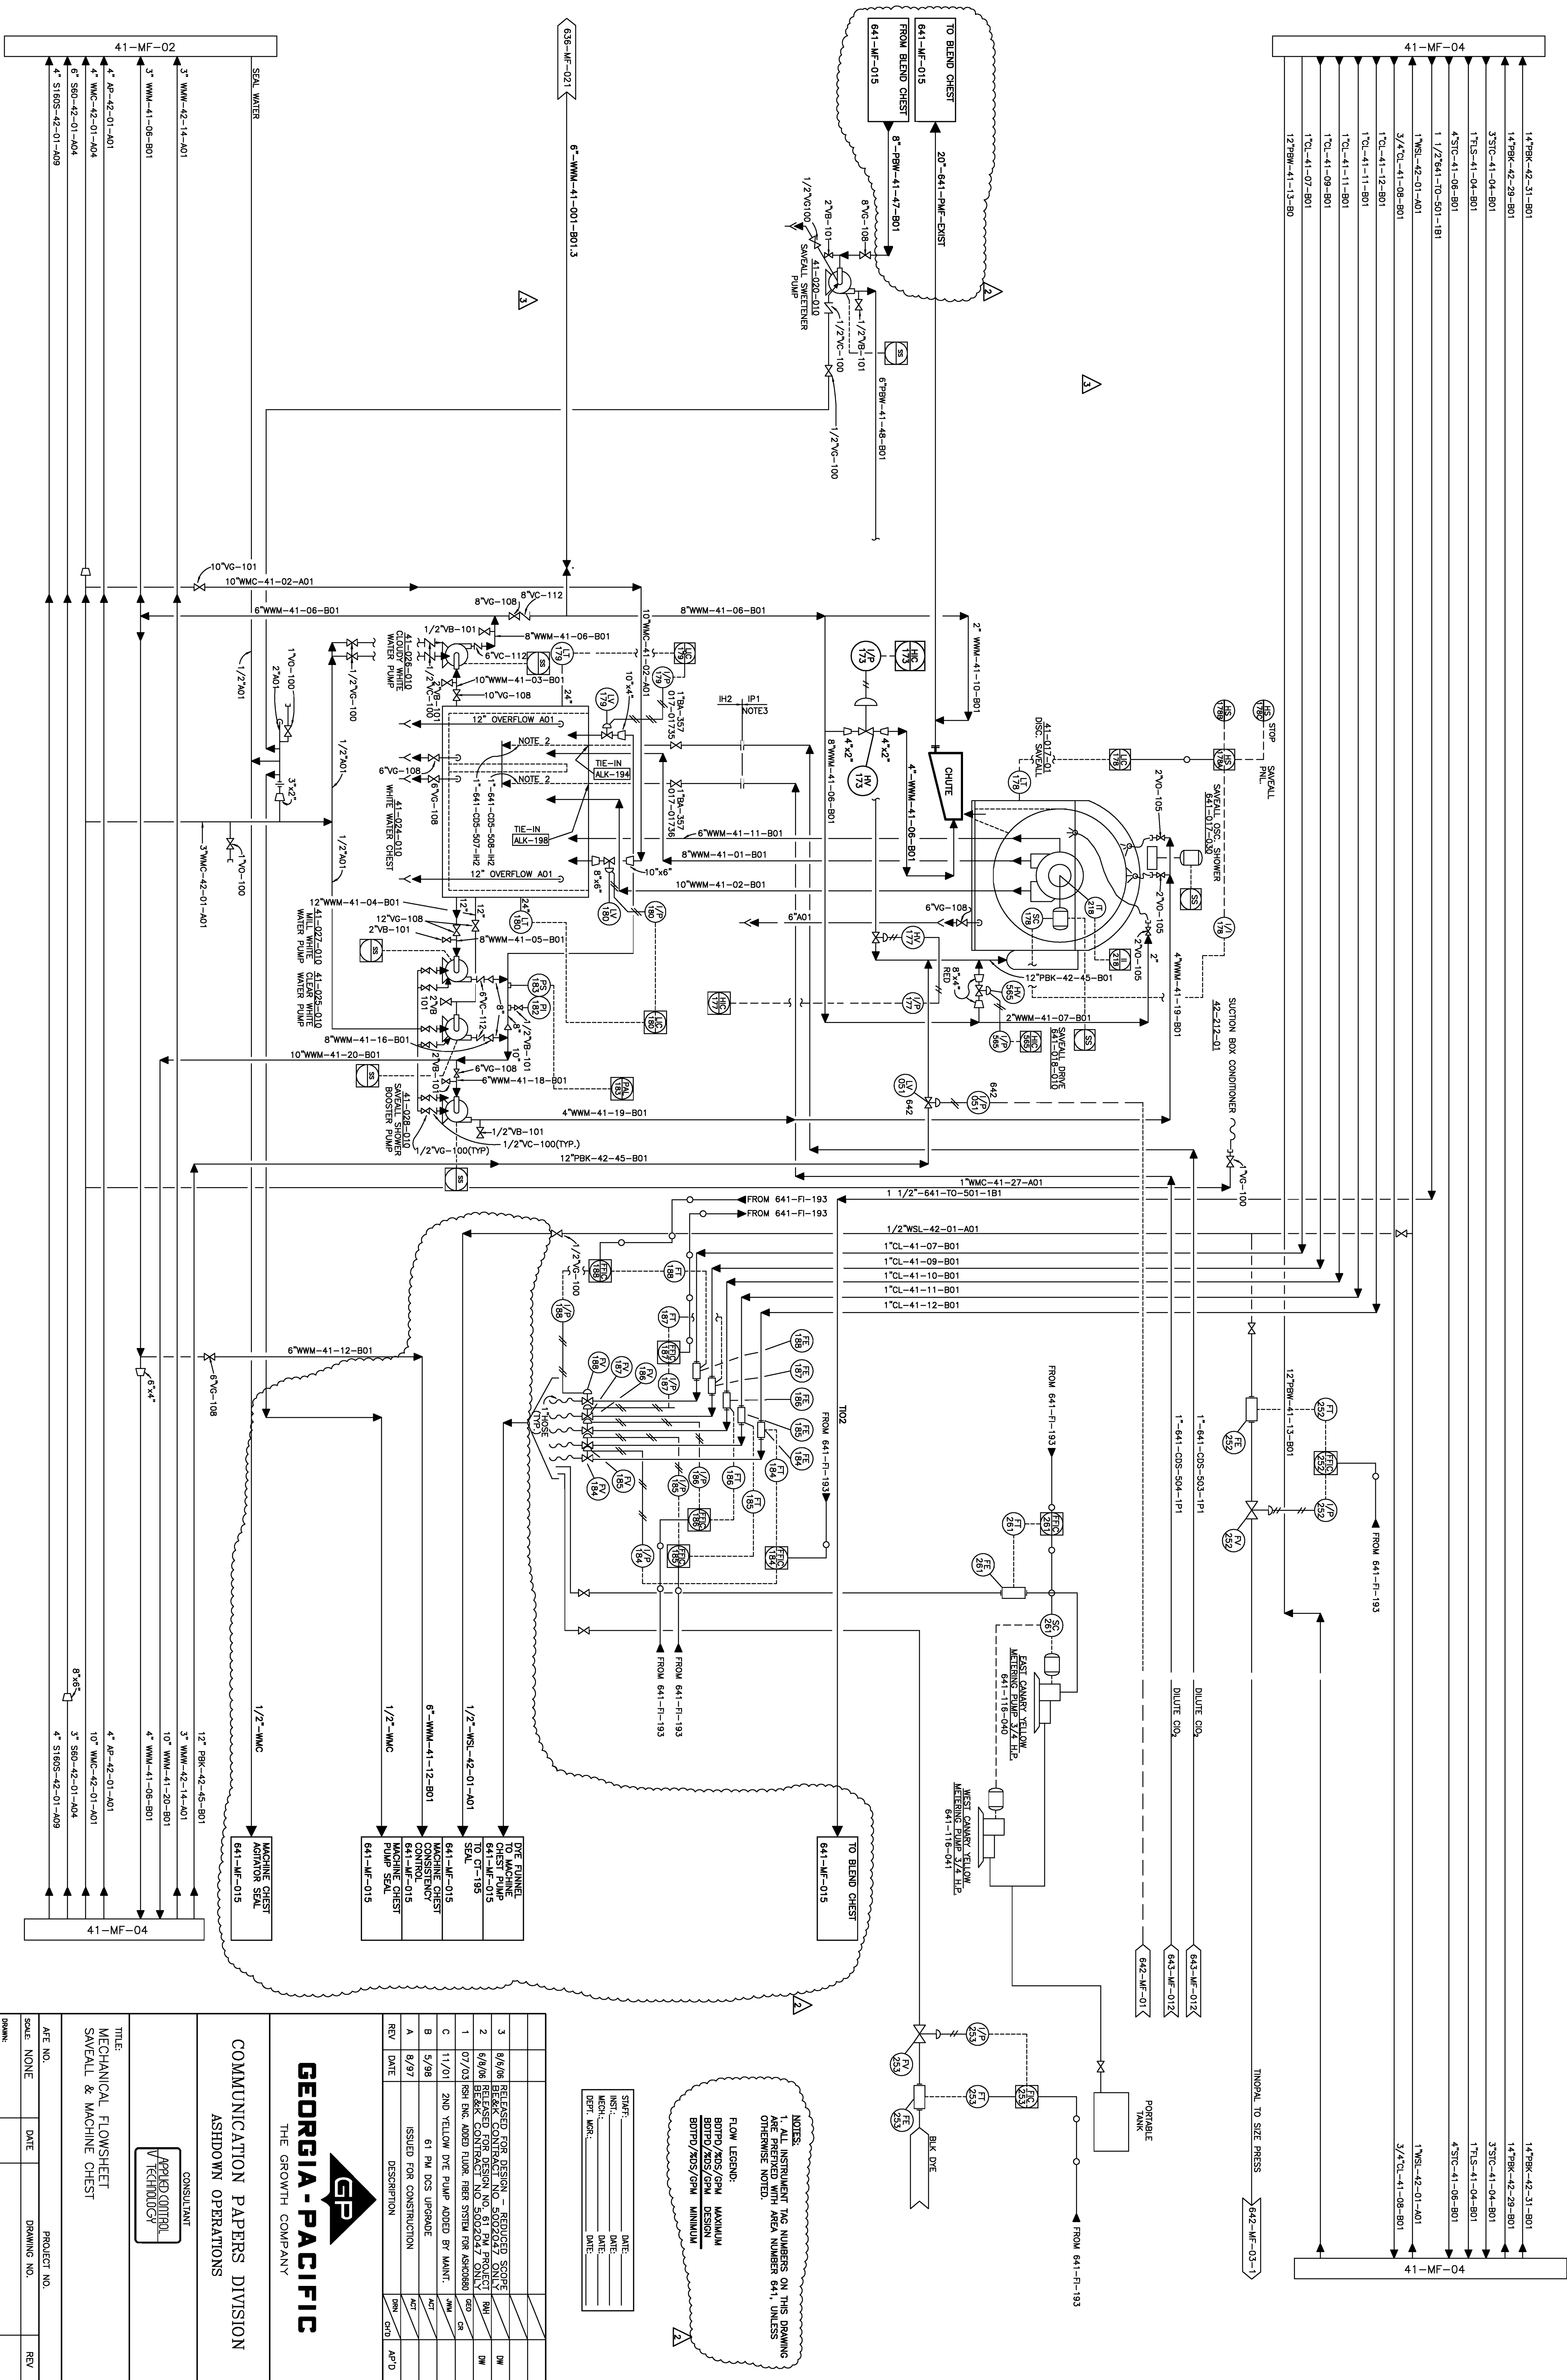

NOTES:
1. ALL INSTRUMENT TAG NUMBERS ON THIS DRAWING ARE PREFIXED WITH AREA NUMBER 641, UNLESS OTHERWISE NOTED.

FLOW LEGEND:
BOLD/2X/5/GPM MAXIMUM DESIGN
BOLD/2X/5/GPM MINIMUM

SWF: _____ DATE: _____
INST: _____ DATE: _____
MCH: _____ DATE: _____
DPT: _____ DATE: _____

3	6/6/06	RELEASED FOR DESIGN - REDUCED SCOPE			1W
2	6/6/06	RELEASED FOR DESIGN NO. 61 PM PROJECT			1W
1	07/03	BS&K CONTRACT NO. 5020247 ONLY			CR
C	11/01	2ND YELLOW DIE PUMP ADDED BY MAINT.			
B	5/98	61 PM DCS UPGRADE			
A	6/97	ISSUED FOR CONSTRUCTION			
REV	DATE	DESCRIPTION	BY	CHK	APP'D



COMMUNICATION PAPERS DIVISION
ASHDOWN OPERATIONS



CONSULTANT
APPLIED CONTROL
TECHNOLOGY

TITLE:
MECHANICAL FLOWSHEET
SAVEALL & MACHINE CHEST

AFE NO.	PROJECT NO.	REV
SCALE NONE	DRAWING NO.	
CHECKED:		
APPROVED:	641-MF-003	3
APPROVED:		
DISTRIBUTION:		

NOTES:
1. REDUCER ORIENTATION PER METSO PIPING INSTRUCTIONS.
2. ALL DIMENSIONS ARE IN FEET AND INCHES. ON THIS DRAWING, DIMENSIONS ARE PRESENTED WITH AREA NUMBERS 641, UNLESS OTHERWISE NOTED.

FLOW LEGEND:
BOPFD/KDS/GPM MAXIMUM
BOPFD/KDS/GPM DESIGN
BOPFD/KDS/GPM MINIMUM

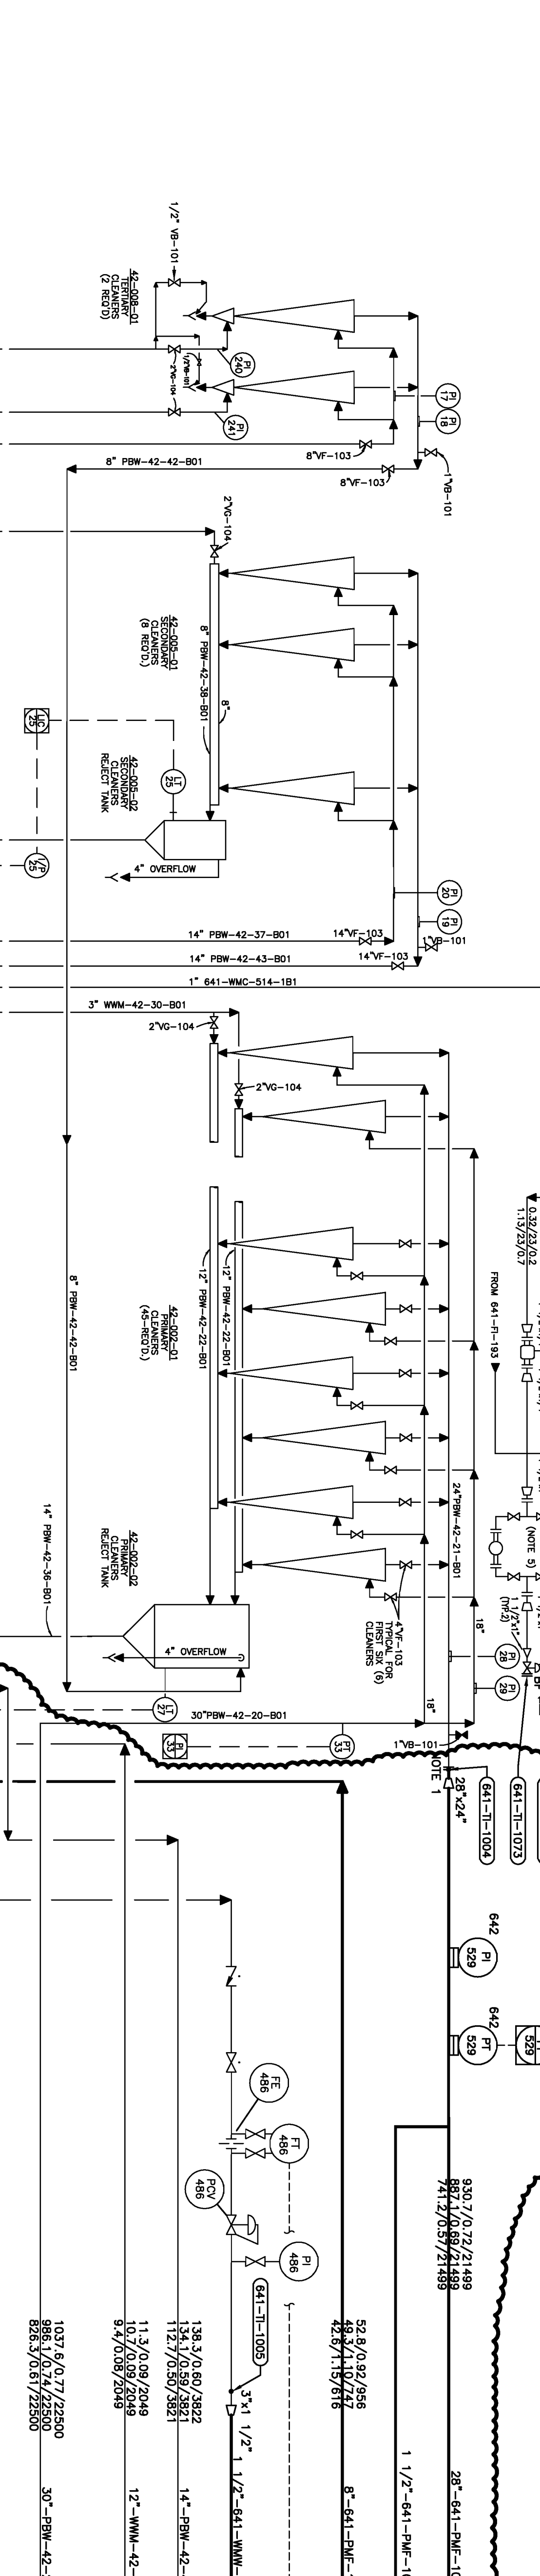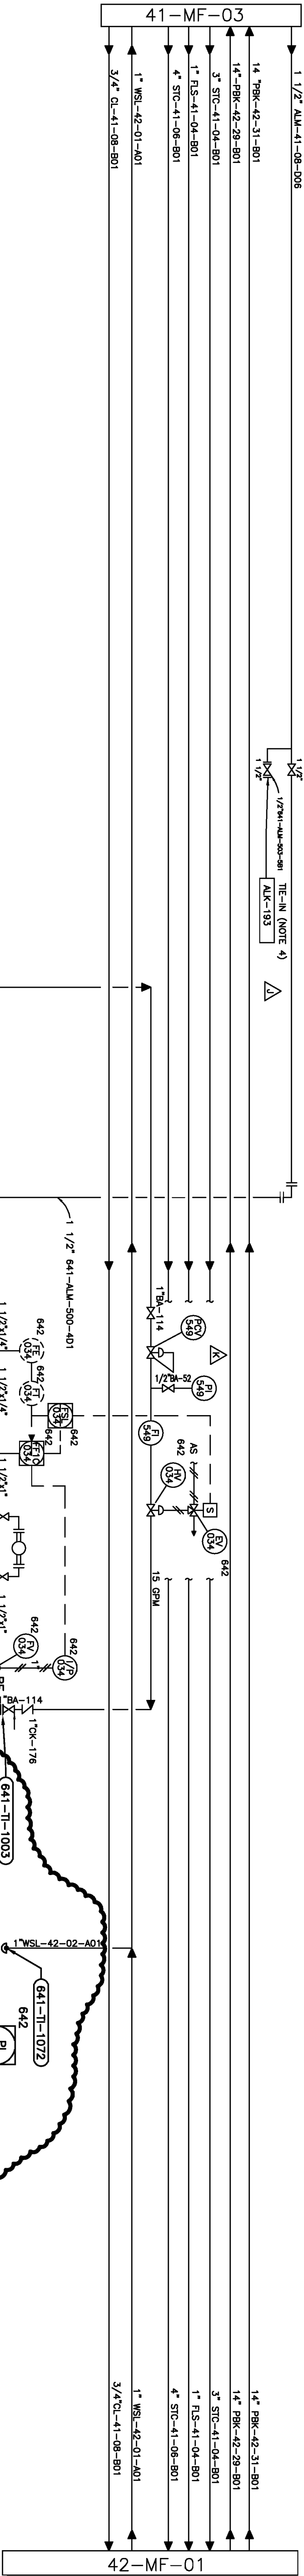

- * VENDOR SUPPLIED LOGIC
- NOTES:

1. * VENDOR SUPPLIED

2. PROVIDE SOLID U-DRAIN COVER AT COOKER FLUSH LINE PENETRATIONS.

3. STARCH COOKER PANEL (61SCP) LOGIC.

4. ALL PANEL MOUNTED INSTRUMENTS ARE LOCATED IN/ON THE STARCH COOKER PANEL (UNLESS OTHERWISE NOTED.

5. FOR DESIGN BASIS SEE DWG. 641-MF-006.

6. ALL INSTRUMENT TAG NUMBERS ON THIS DRAWING OTHERWISE NOTED.
- FLOW LEGEND (SLURRY)

BOLD 200S/GPM DESIGN

BOLD 200S/GPM MAXIMUM

FLOW LEGEND (G102)

#G102/DAY 9/1 CONC./GPM

12	10/26	Corrected sheet numbers	REV	DATE
11	1/26	61 PM DCS UPGRADE	REV	DATE
10	1/11/16	CONSTRUCTION (CEG 07-0647-01)	REV	DATE
9	1/11/16	GEN. REV. PER (CEG-07064701)	REV	DATE
8	1/11/16	ADDED NEW W.E. COOKED STARCH STORAGE TANK & WET END SUPPLY PUMP	REV	DATE
7	1/11/16	REMOVED EXIST. COOKED STARCH STORAGE TANK & WET END SUPPLY PUMP	REV	DATE
6	1/11/16	ADDED FLUSH & VENT VAS.	REV	DATE
5	1/11/16	ADDED STIM. TRAP	REV	DATE
4	1/11/16	CONSTRUCTION	REV	DATE
3	1/11/16	CONSTRUCTION	REV	DATE
2	1/11/16	CONSTRUCTION	REV	DATE
1	1/11/16	CONSTRUCTION	REV	DATE

GEORGIA-PACIFIC

THE GROWTH COMPANY

COMMUNICATION PAPERS DIVISION

ASHDOWN OPERATIONS

CONSULTANT

Brown & Root, Inc.

1800 Peachtree Street, N.E.

Atlanta, Georgia 30309

Phone: 404.261.1800

Fax: 404.261.1801

Web: www.brownroot.com

Project No.: JB-1877

TITLE:

ENGINEERING FLOW DIAGRAM

NO. 61 P.M. ADDITIVES

W.E. STARCH COOKING AND MACHINE SUPPLY

SCALE: NONE

DATE: 09-22-93

DRAWING NO.: 641-MF-009

PROJECT NO.: AA-142

APPROVED: SCV

DATE: 12-22-93

APPROVED: LDW


DATE: 12-22-93

APPROVED: RLF


DATE: 12-22-93

REV

12

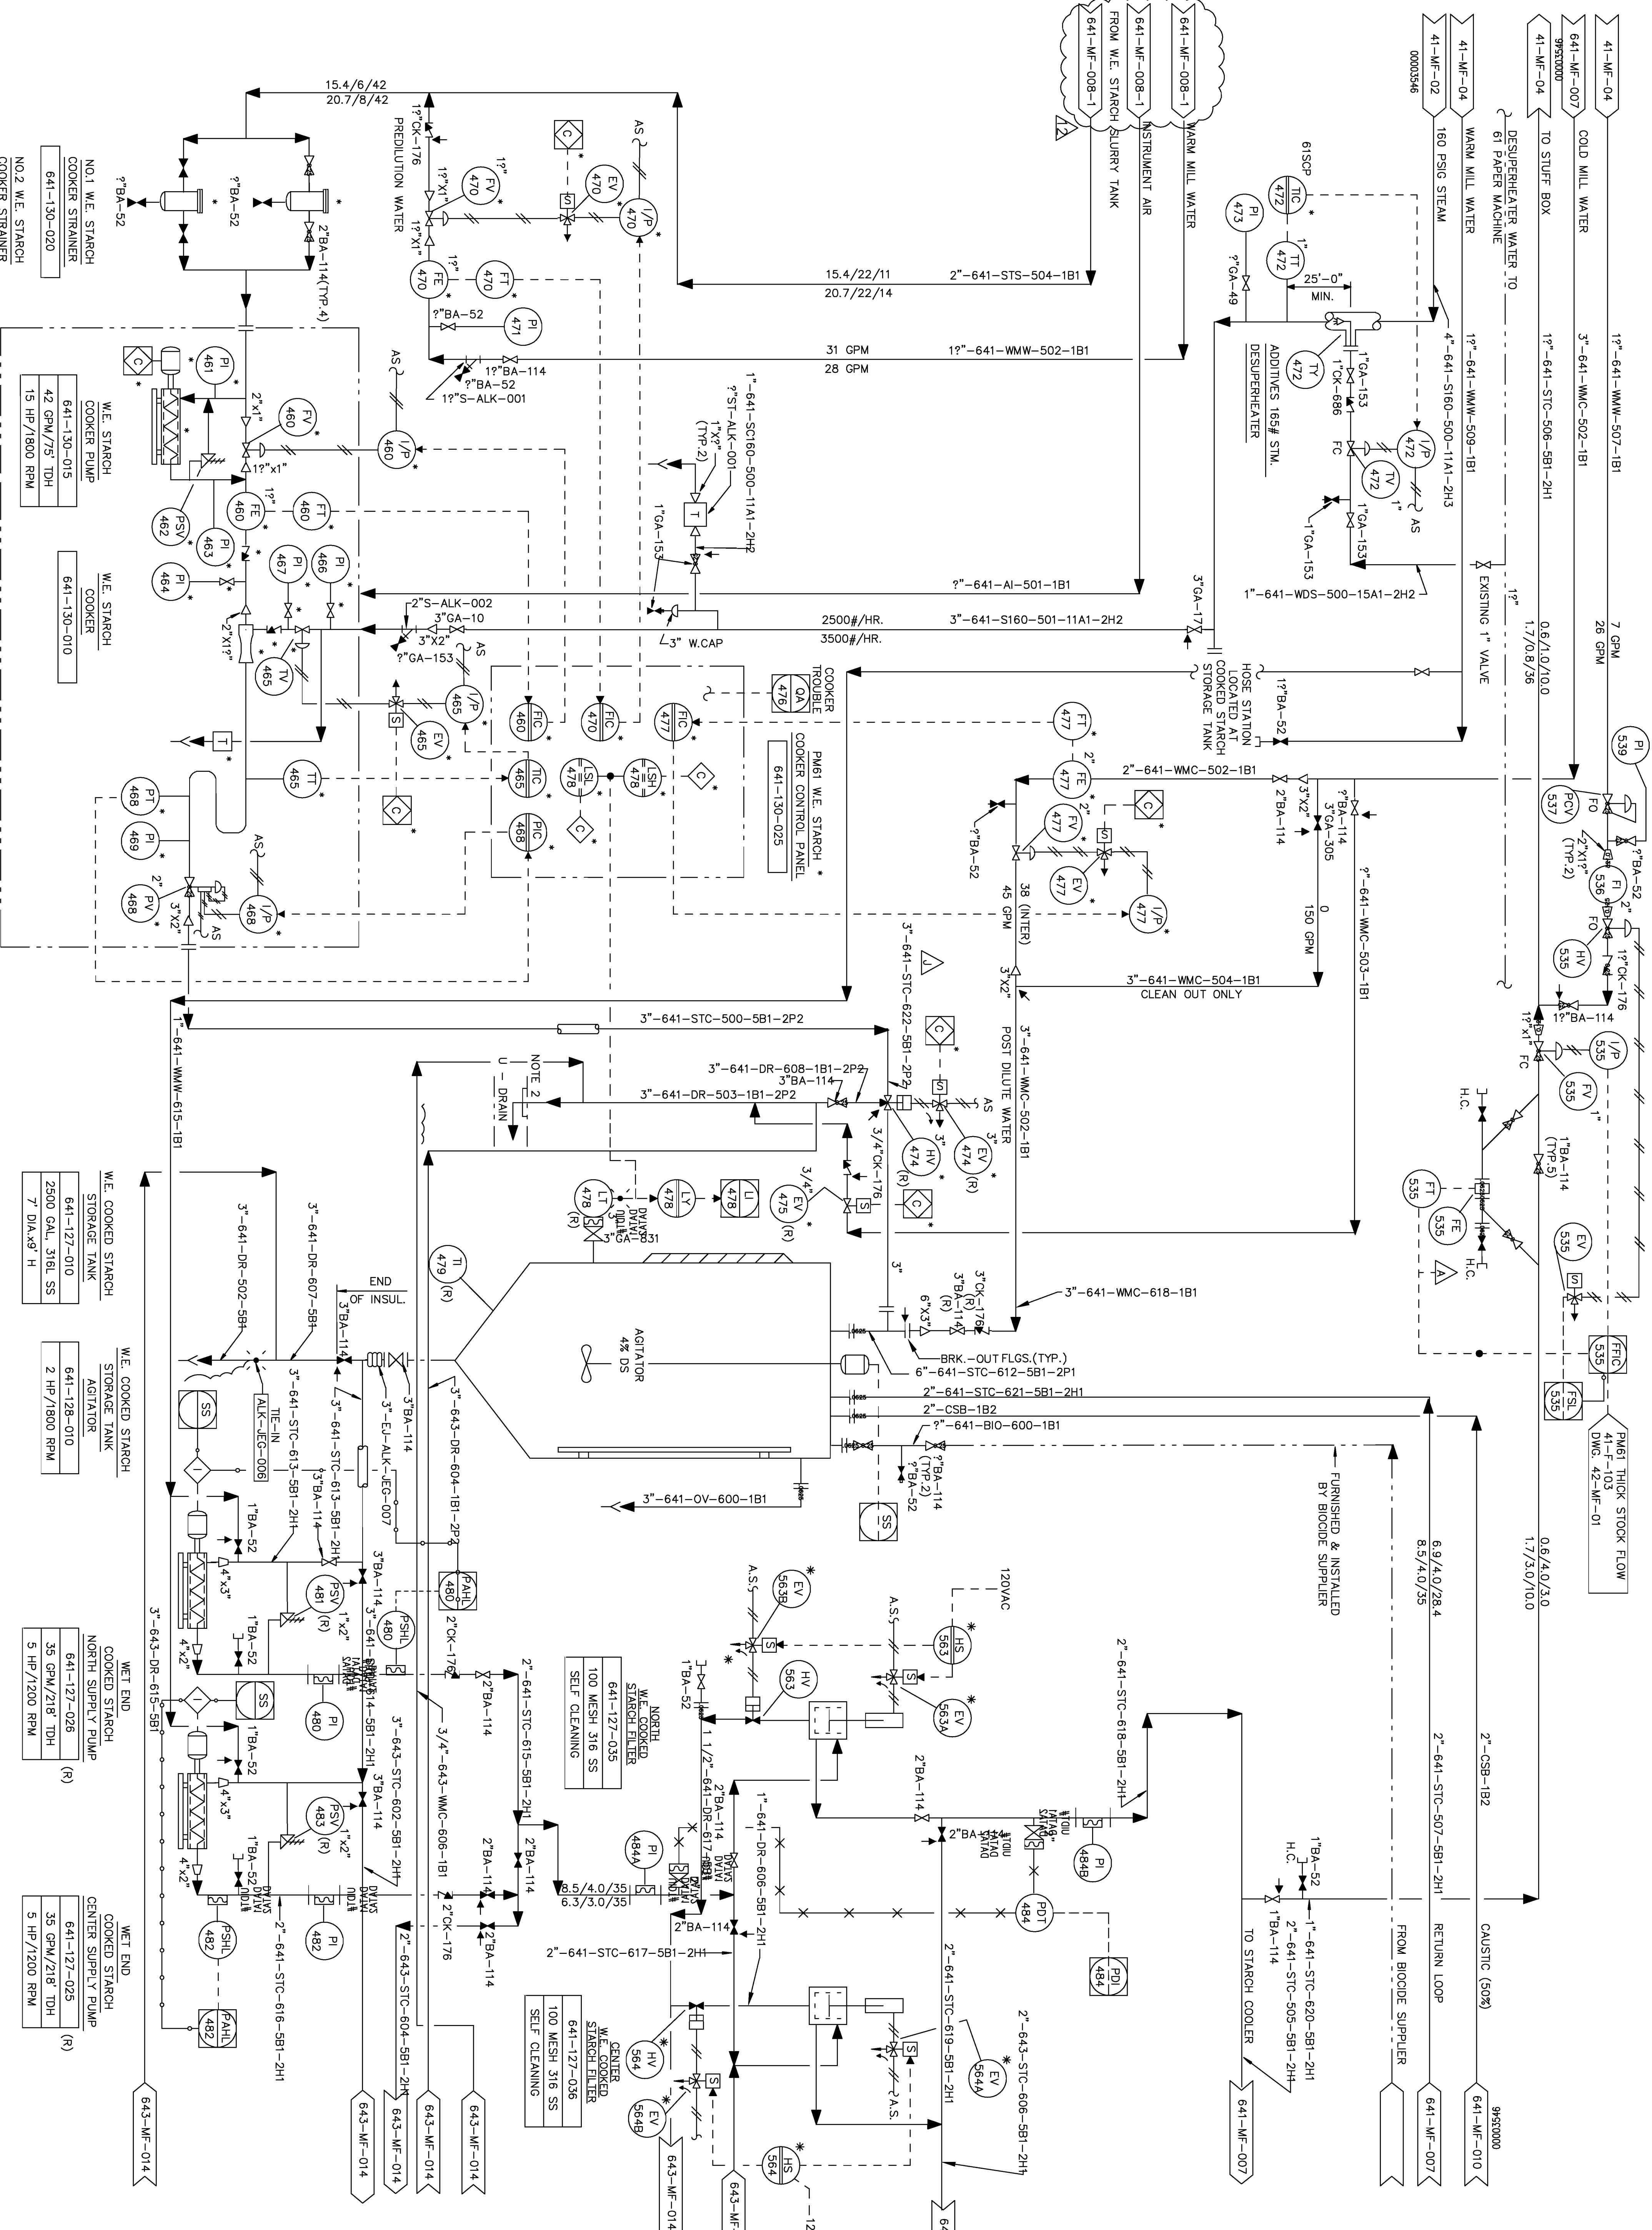

- NOTES:**
1.  STARCH COOKER PANEL (PLC) LOGIC.
 2. ALL PANEL MOUNTED INSTRUMENTS ARE LOCATED IN/ON THE STARCH COOKER PANEL (61SCP) UNLESS OTHERWISE NOTED.
 3. ALL INSTRUMENT TAG NUMBERS ON THIS DRAWING ARE PREFIXED WITH AREA NUMBER 641, UNLESS OTHERWISE NOTED.

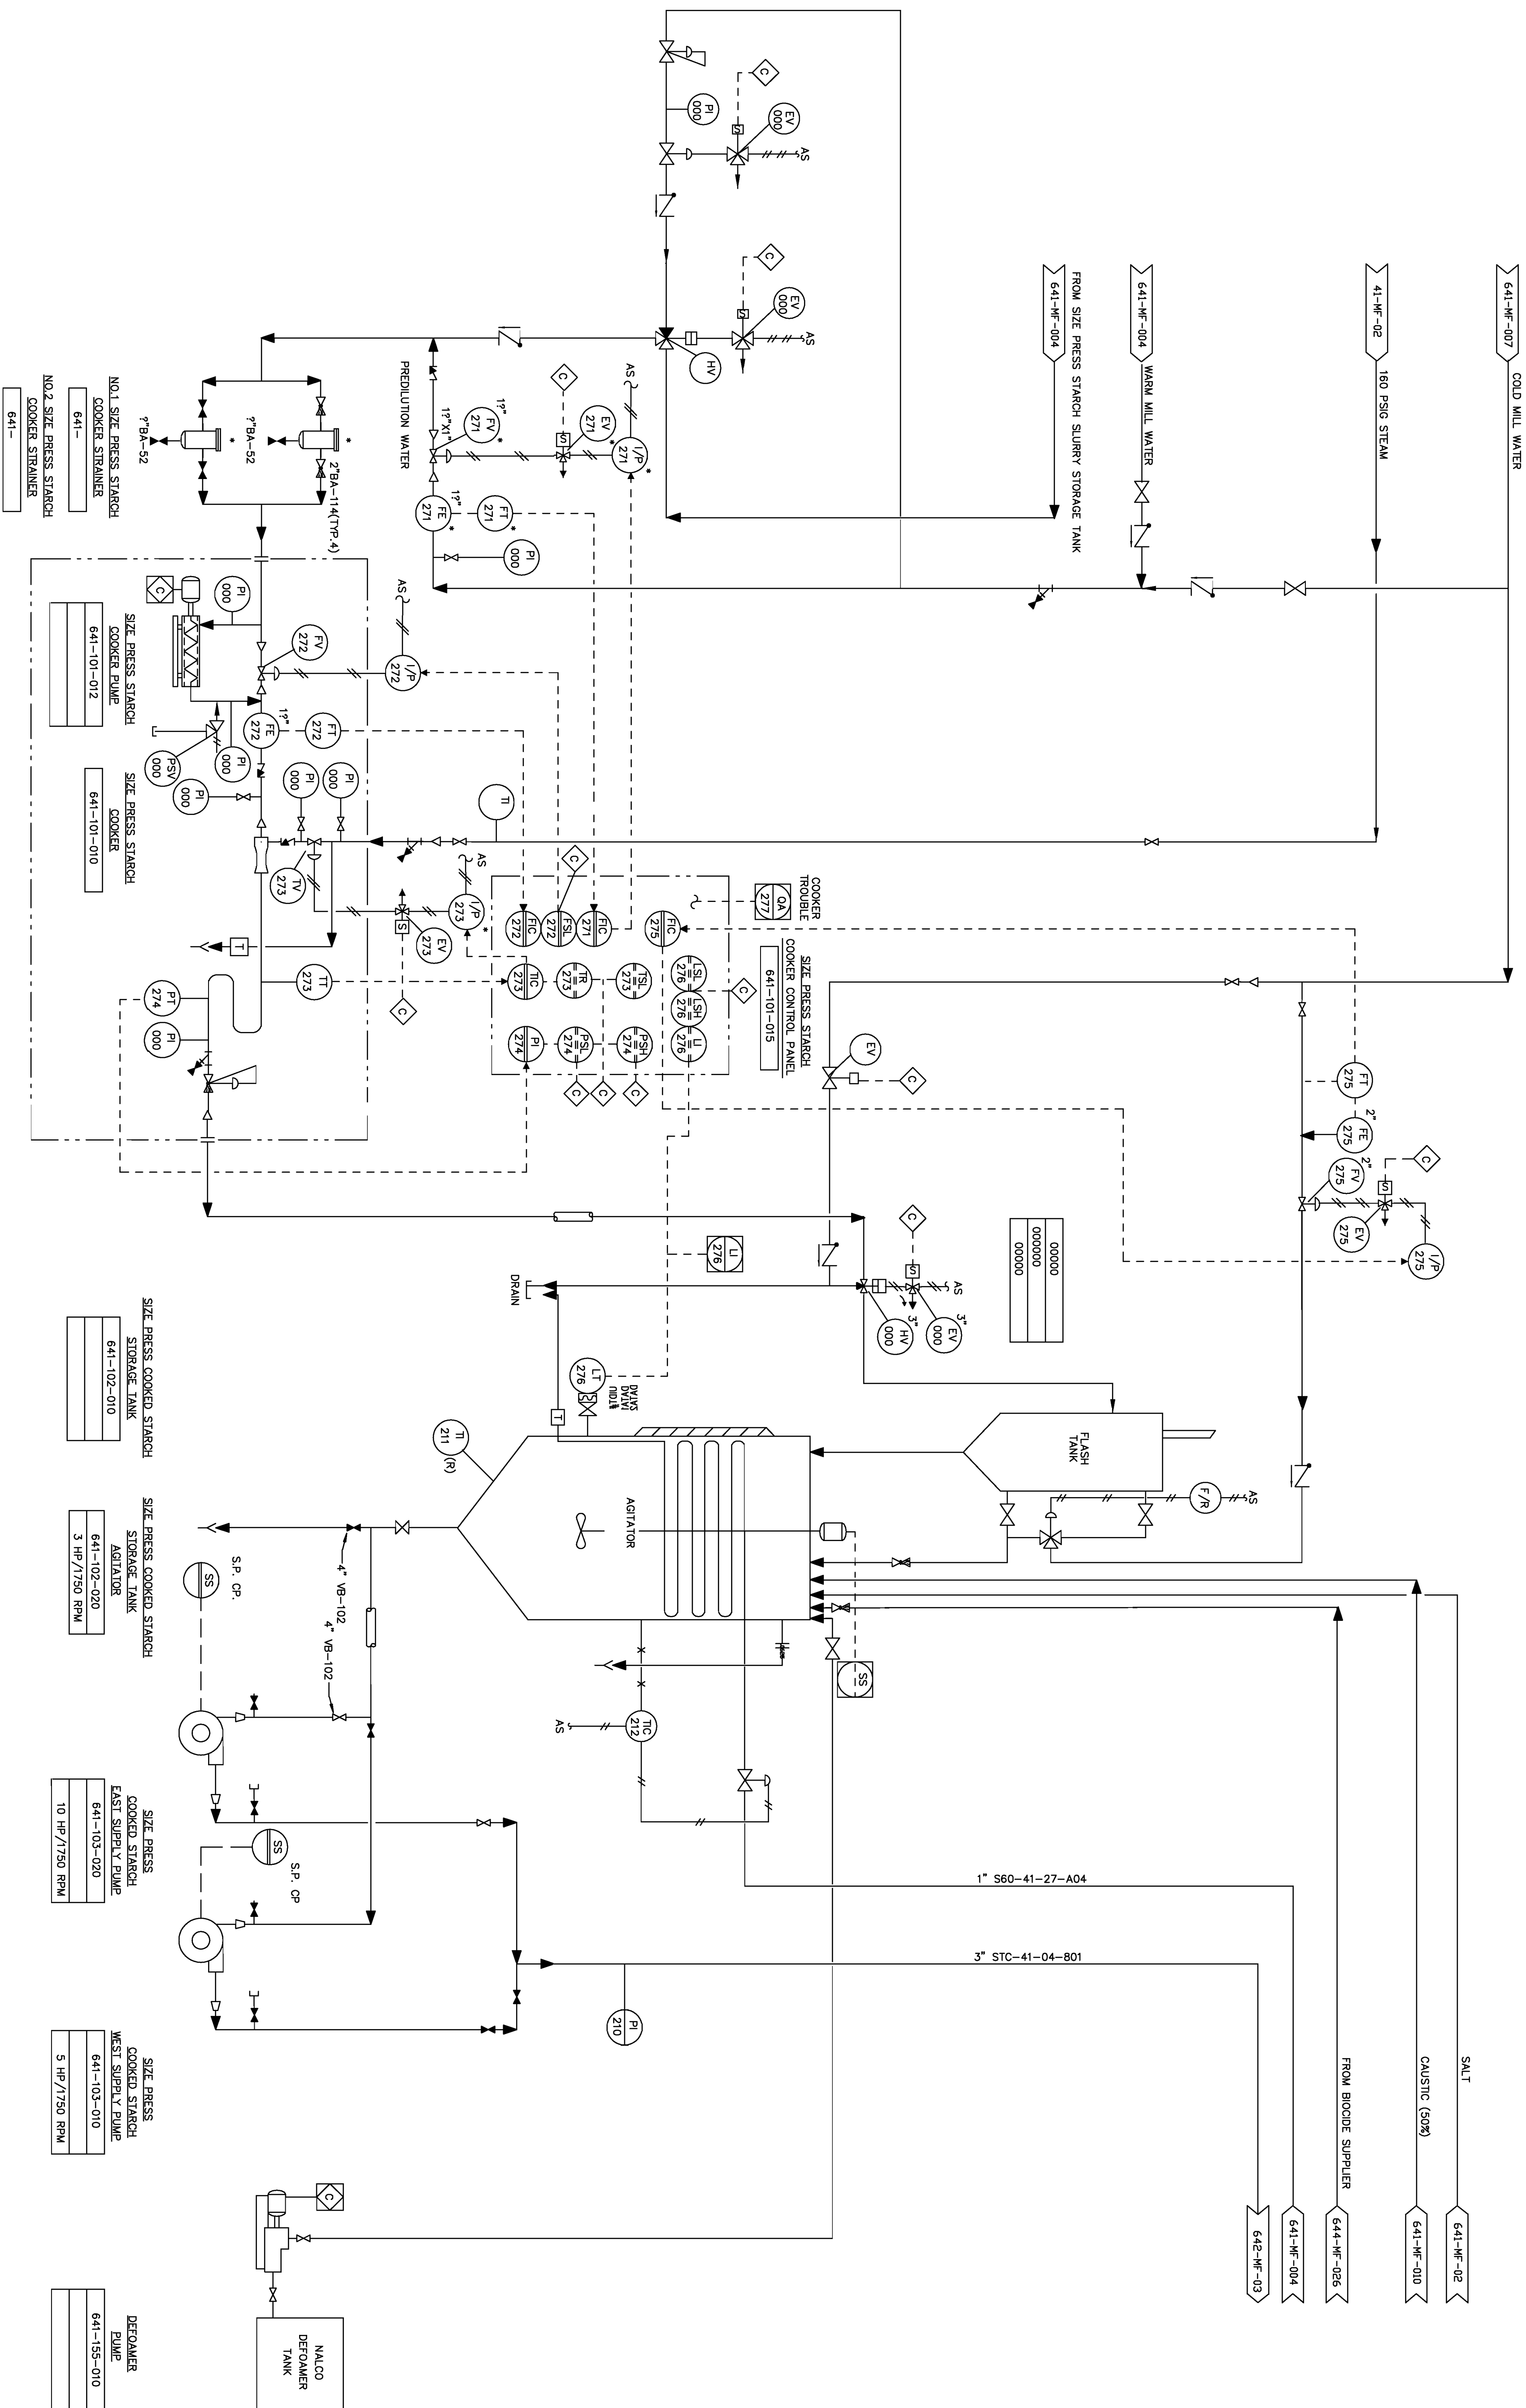

	REV	DATE	DESCRIPTION	BY	CHECKED BY	APPROVED
2	10/98		Corrected sheet number	REV		
1	5/98		61 PM DCS UPGRADE	MKT		
REV				DES		
				DTS		

GP
GEORGIA-PACIFIC
THE GROWTH COMPANY

COMMUNICATION PAPERS DIVISION
ASHDOWN OPERATIONS

CONSULTANT
APPLIED CONTROL
TECHNOLOGY

TITLE: ENGINEERING FLOW DIAGRAM

IND. 61 F.M. ADDITIVES SIZE PRESS STARCH COOKING AND MACHINE SUPPLY



A/E NO.		PROJECT NO.	
SCALE	NONE	DATE	DRAWING NO.

NAME	
ADDRESS	

APPROVED: _____

 Sheet ~~7~~ 2 of 2


STRIBUTION

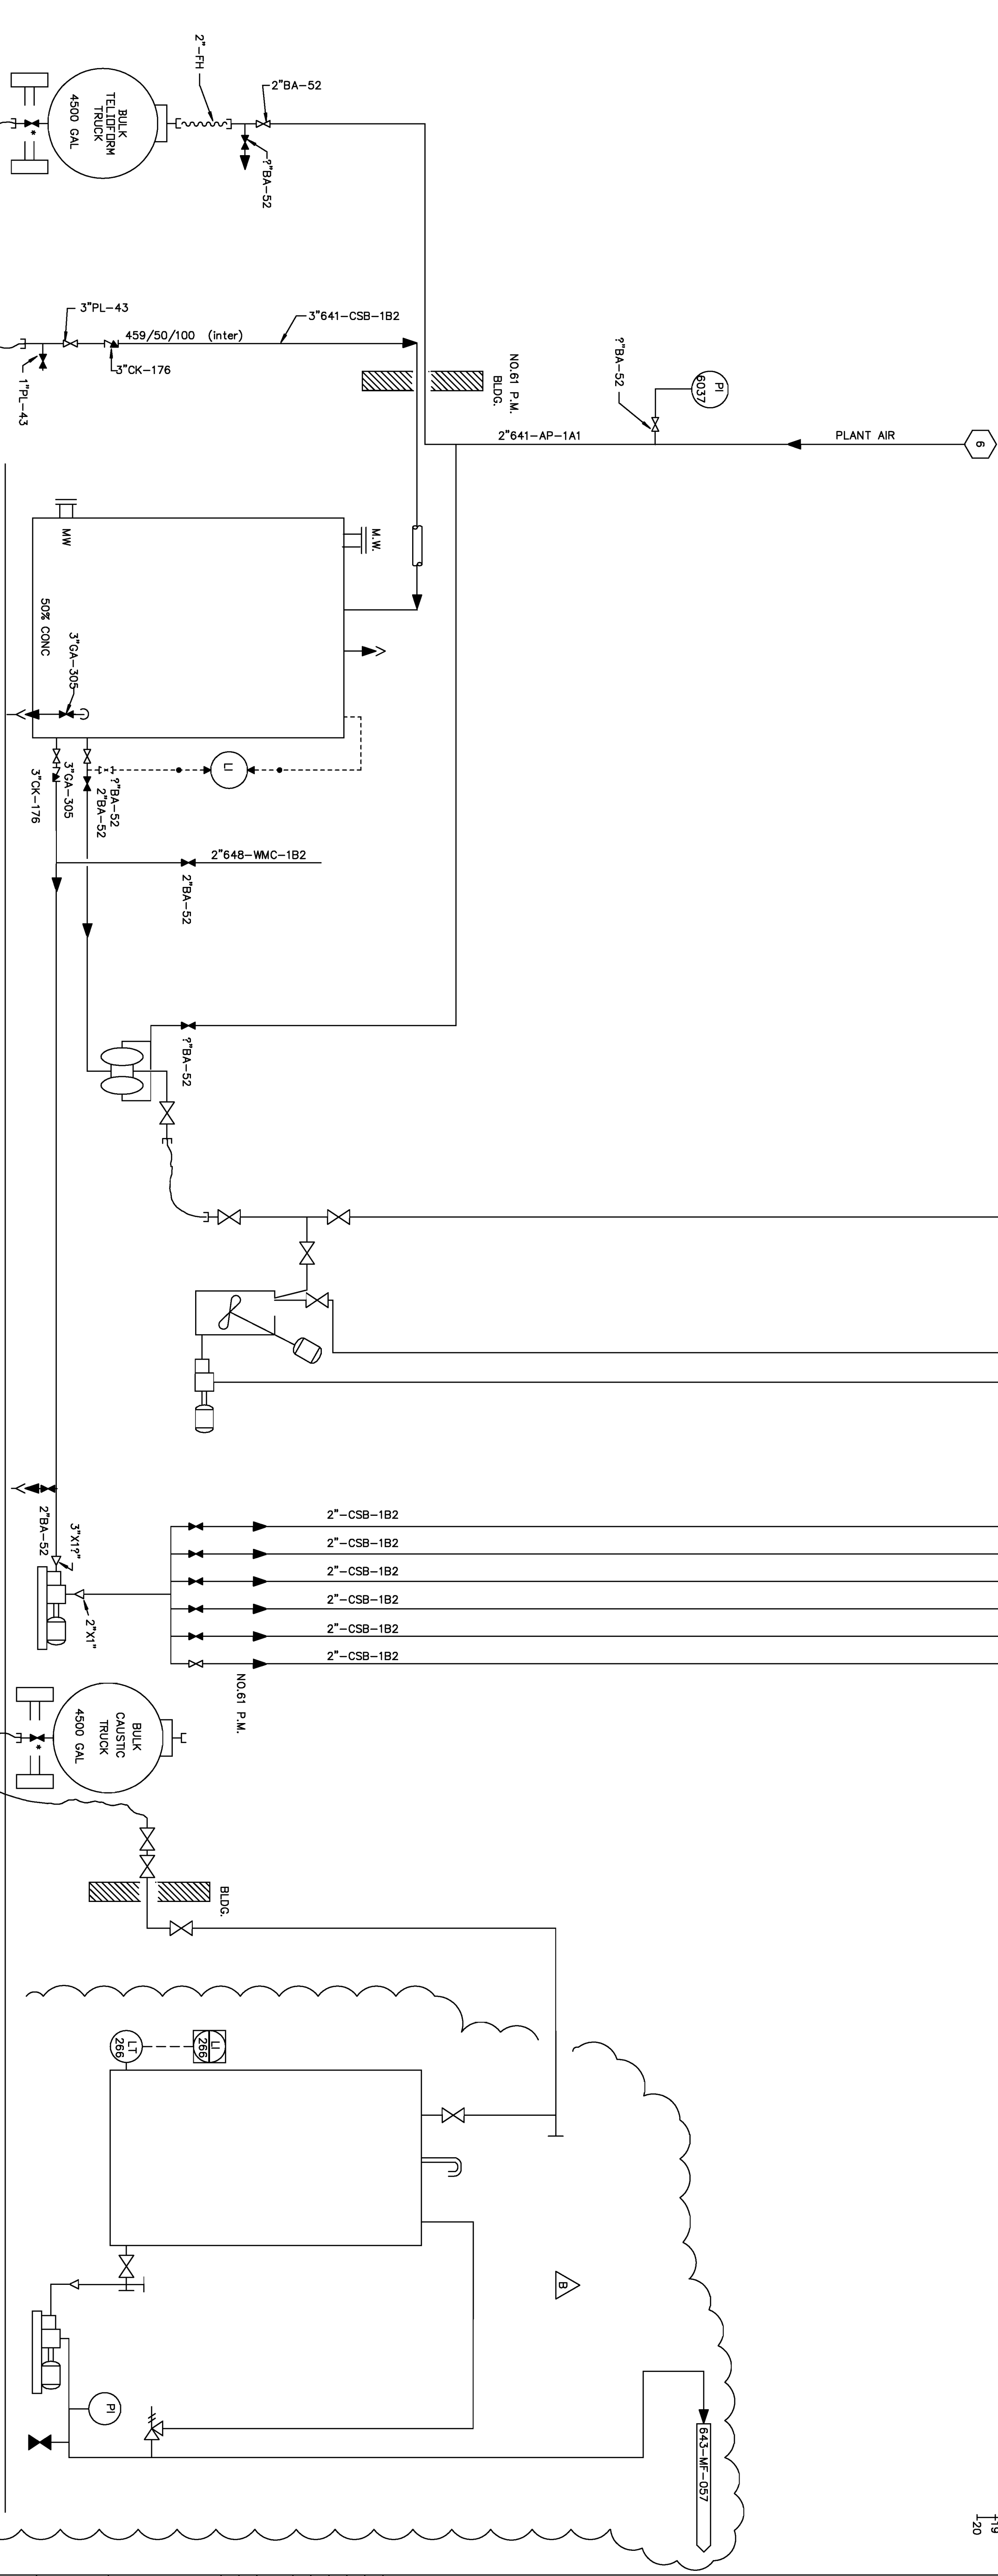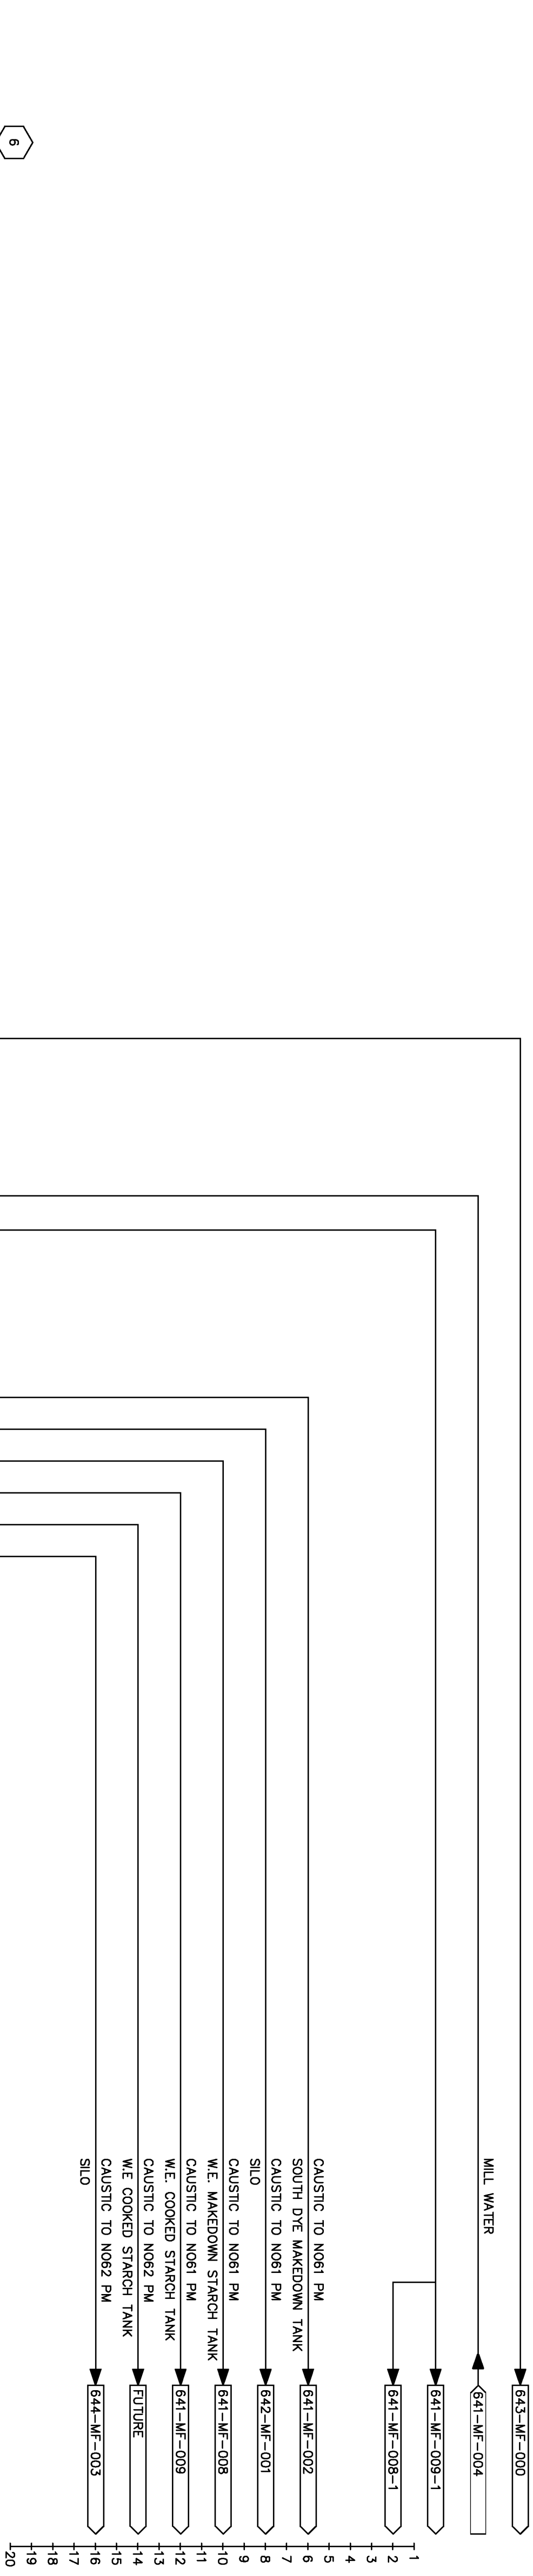


COMMUNICATION PAPERS DIVISION
ASHDOWN OPERATIONS

CONSULTANT
APPROVED
TECHNOLOGY

TITLE ENGINEERING FLOW DIAGRAM ADDITIVES-CAUSTIC & RETENTION AID UNLOADING, STORAGE AND TRANSFER			
DATE	PROJECT NO.	DATE	REV
11-28-95	641-WF-010		B
DRAWN	CHECKED	APPROVED	
J.B.M.			

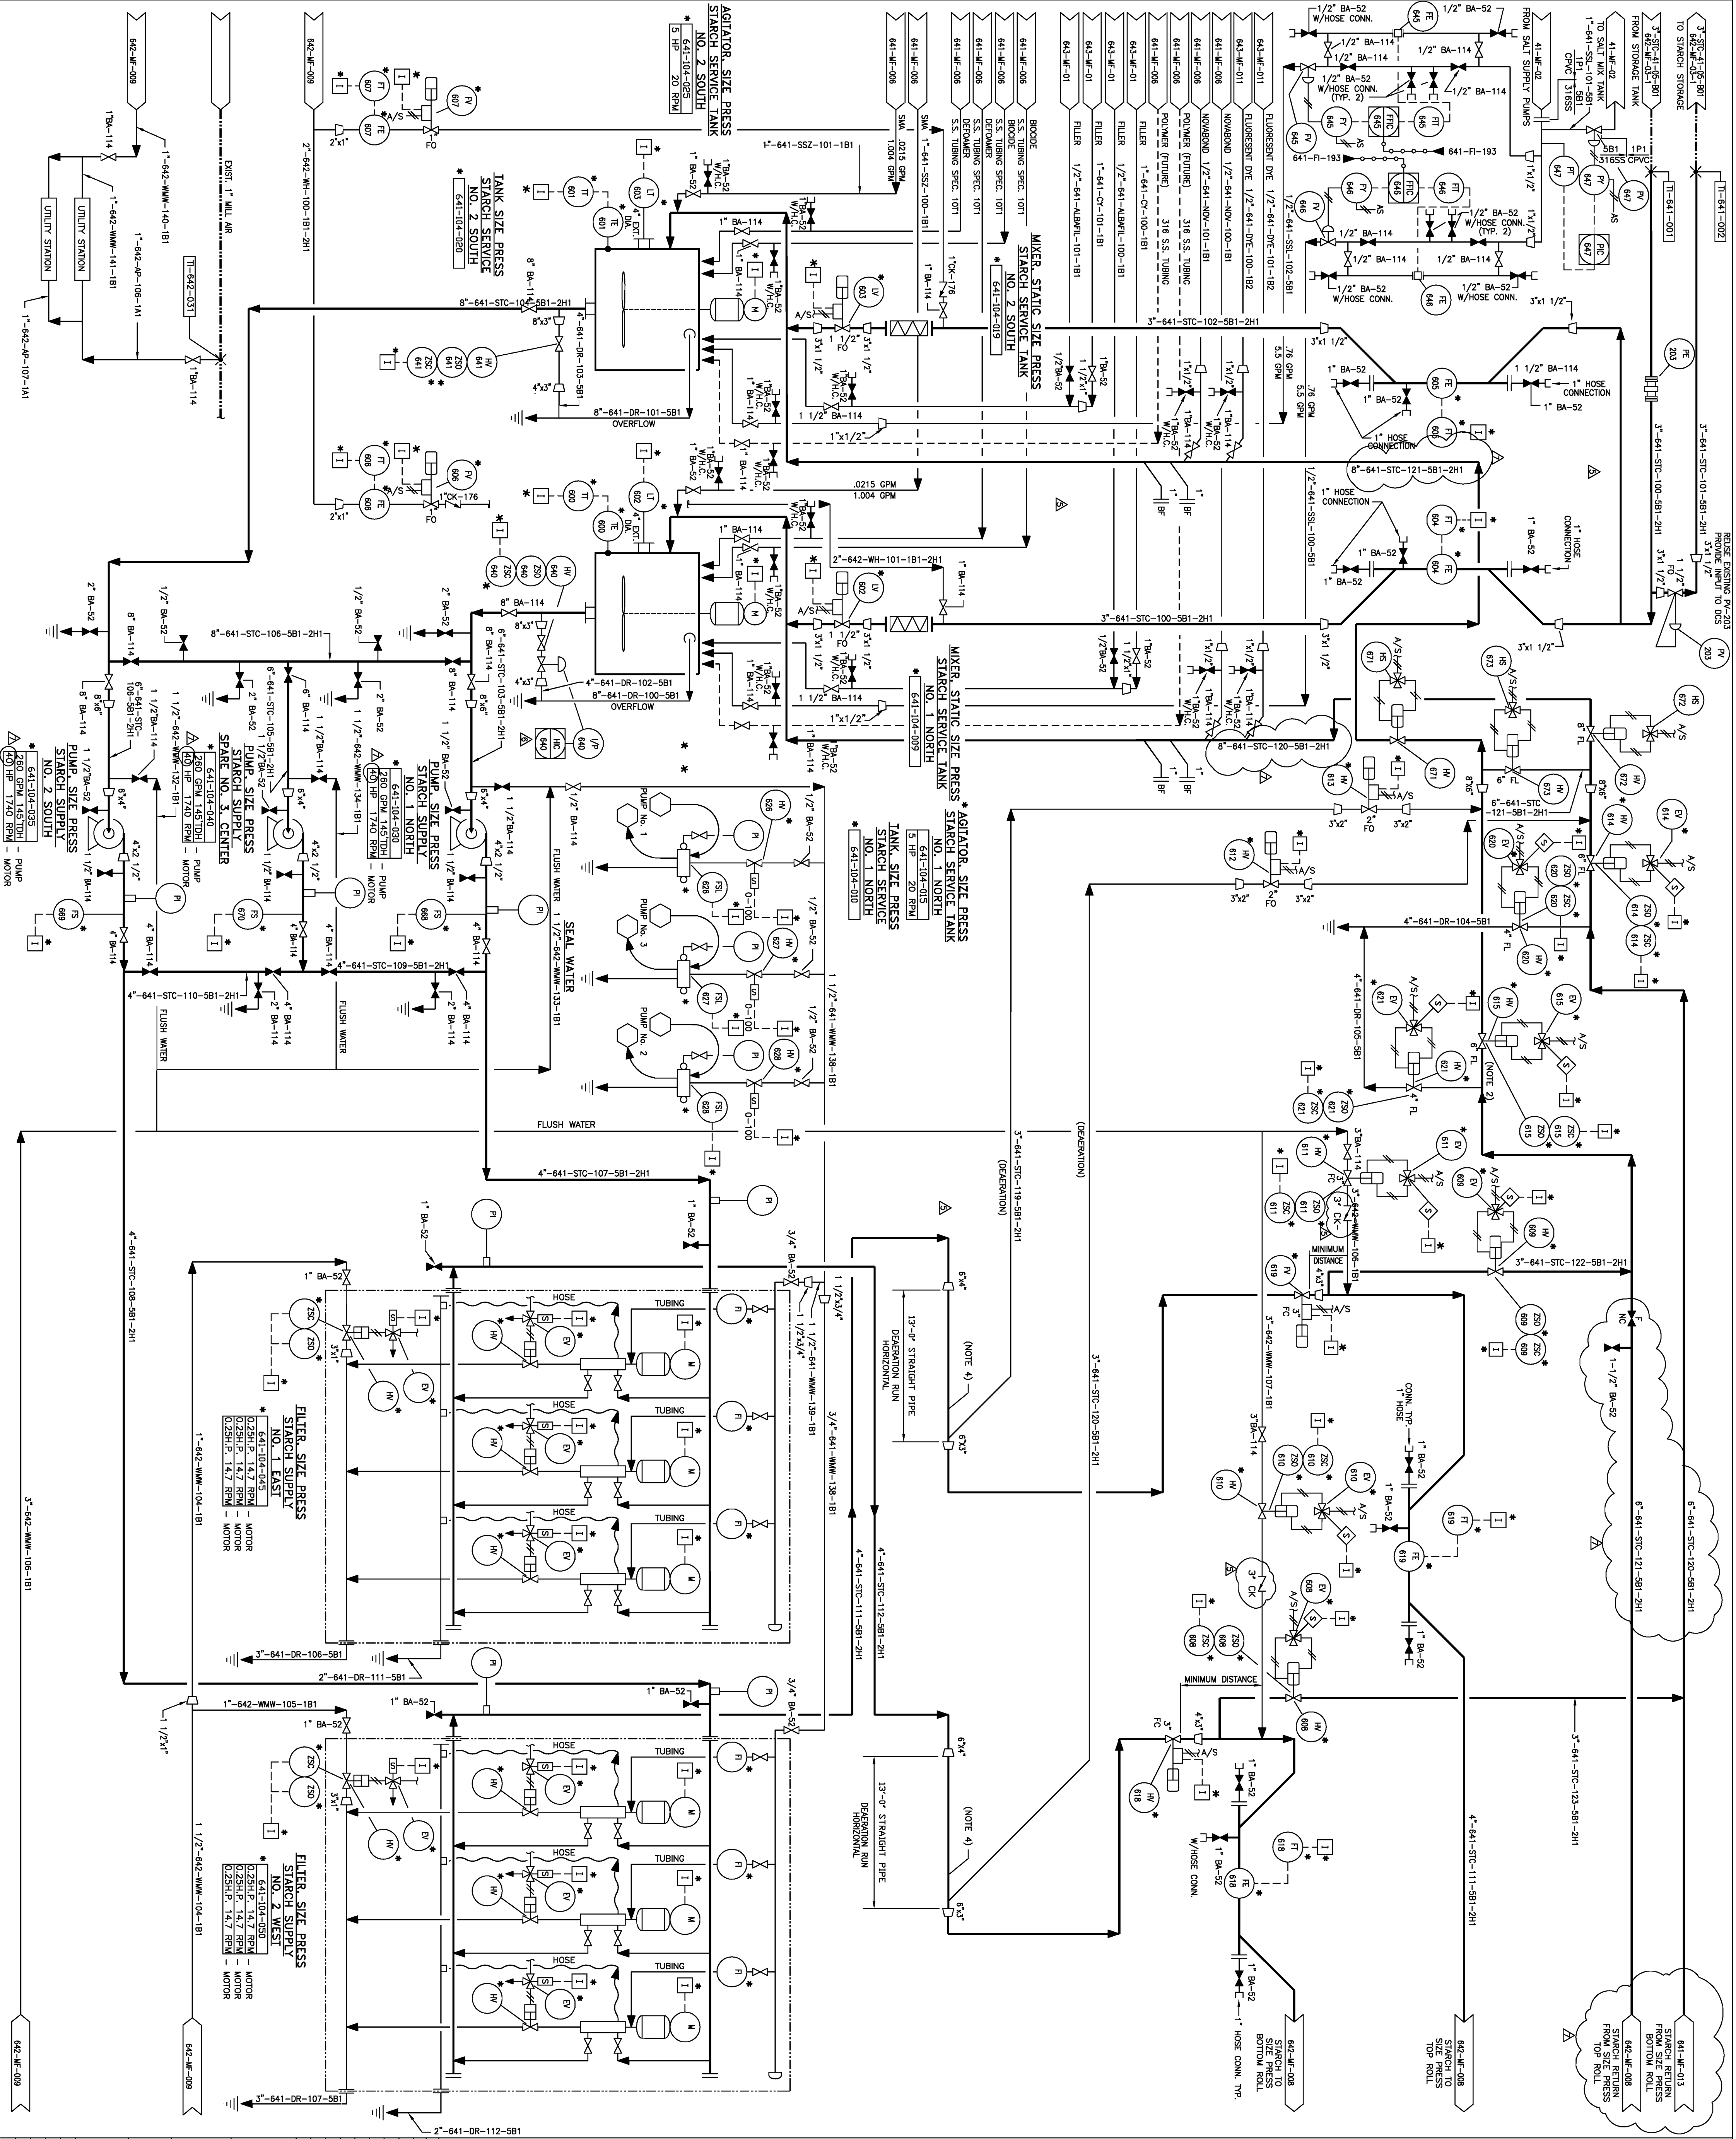

FLOW RATE (GPM)/CONSISTENCY (%)/STOCK TONNAGE (BONE DRY TONS/DAY)/TEMP. (°F)/LINE PRESSURE (PSIG)

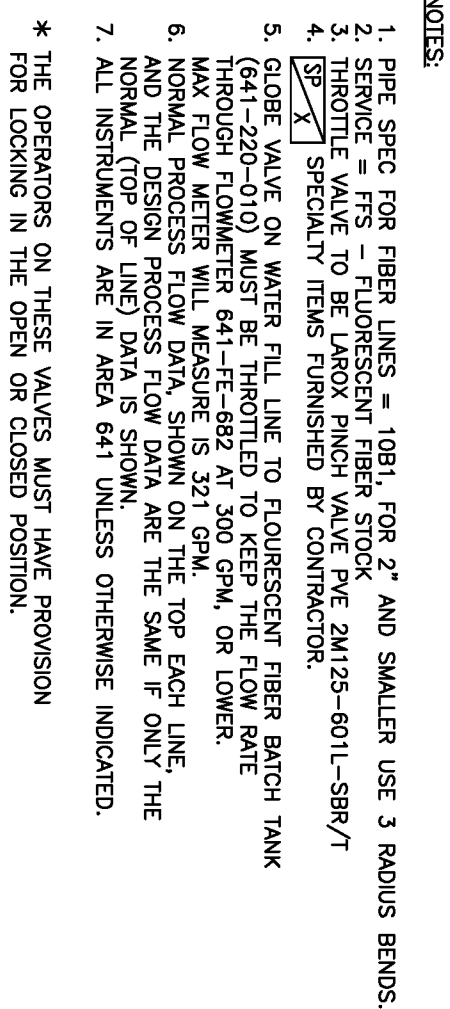


Donatar 


ASHDOWN MILL

R-S-H ENGINEERING, INC.

CAD FILE: 641-MF-012

TITLE:
NO. 61 PAPER MACHINE
PROCESS & INSTRUMENTATION DIAGRAM
FLUORESCENT FIBER SYSTEM

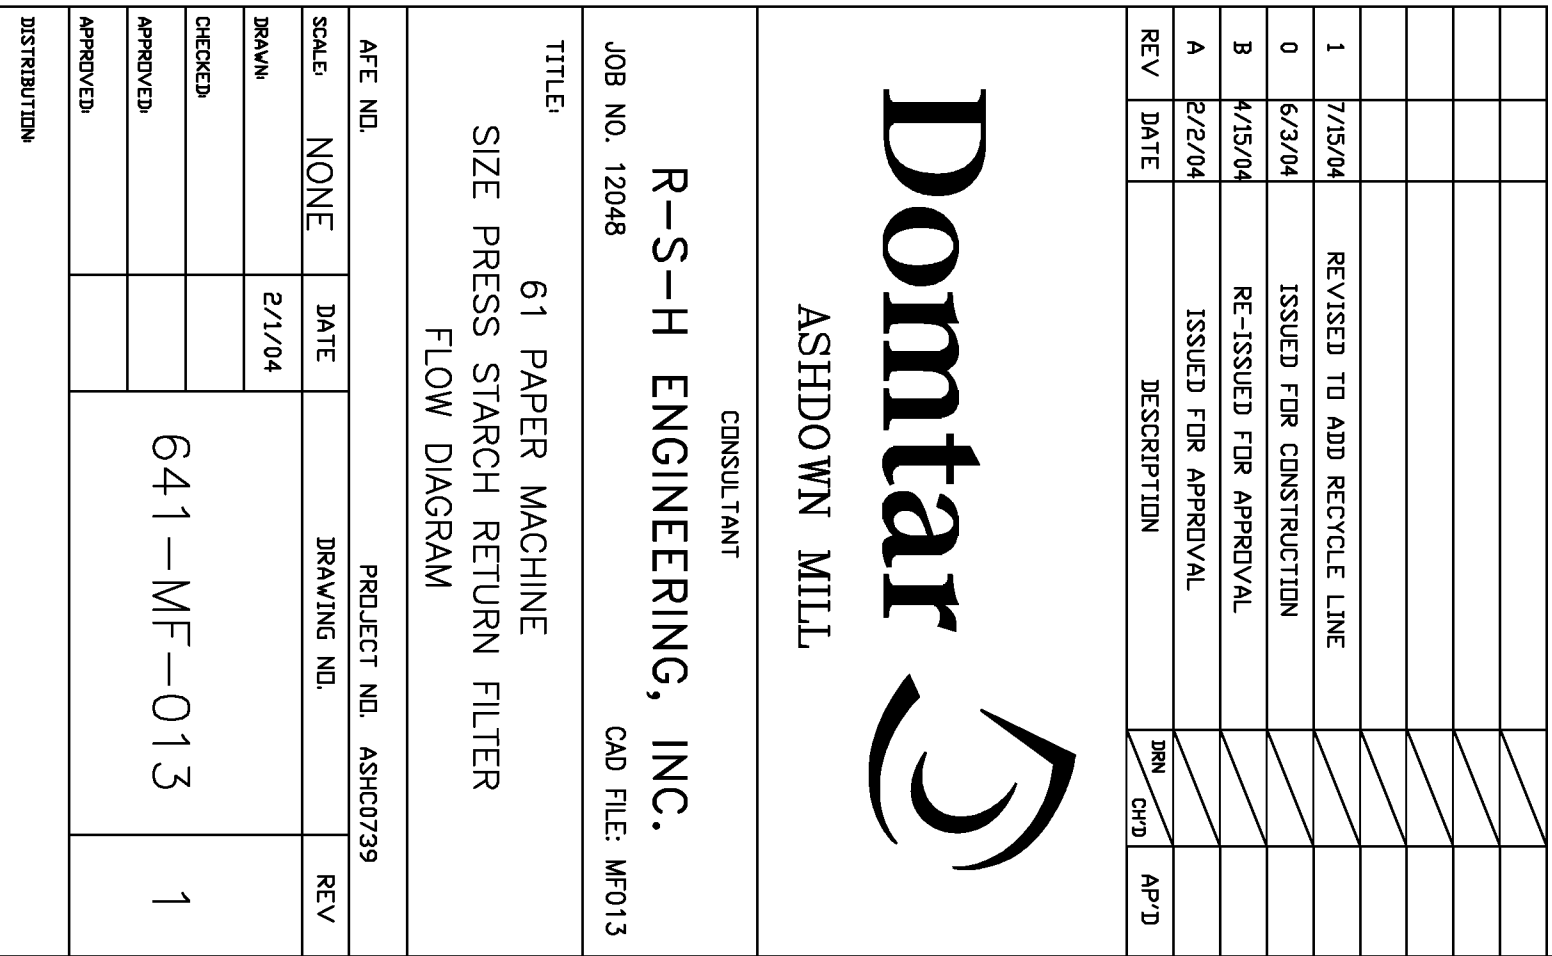

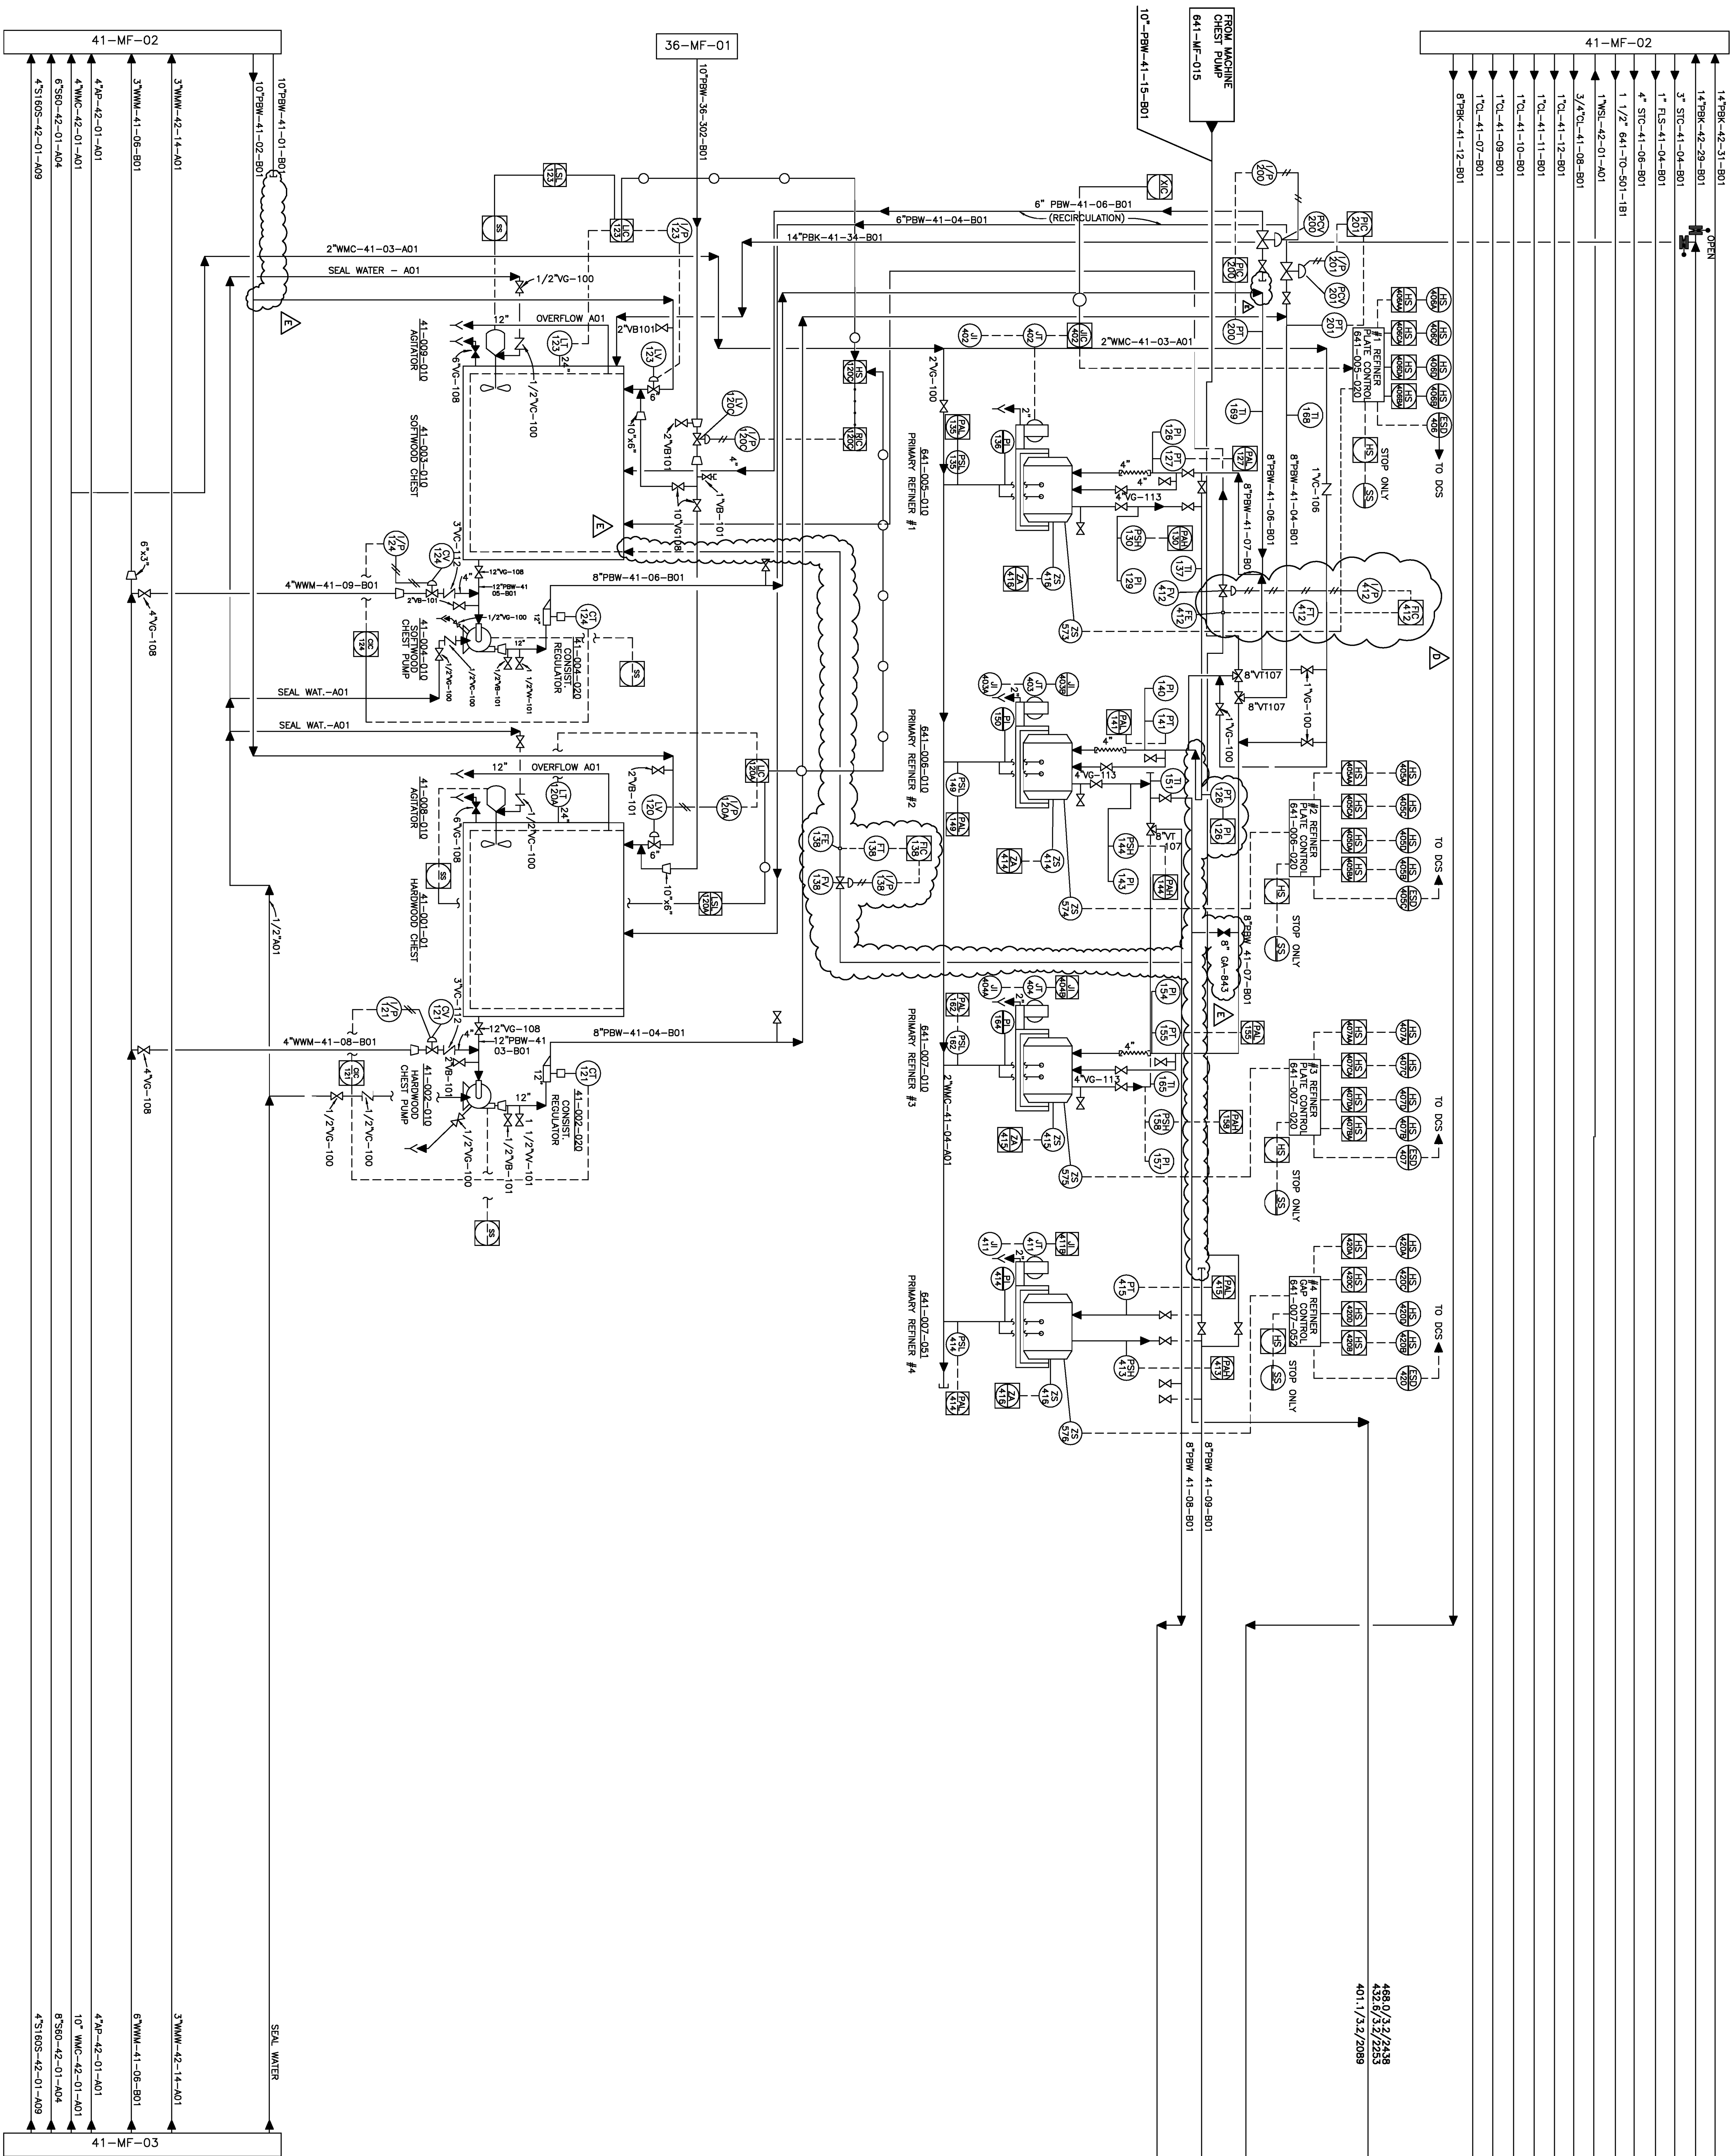

STAFF:	BOB BLUM	DATE:	8/7/08
INST.:	JK	DATE:	8/7/08
MECH.:	ROB JAMES	DATE:	8/7/08
DEPT. MGR.:	DET	DATE:	8/7/08

E	5/13	ISSUED REGULATION TO SENTRY LINE AND	JLT		
D	9/12	TRANSFERRED FE FROM LOOP 1170 TO LOOP 1412	JLT		
C	8/06	RELEASED FOR DESIGN NO. 61 PM PROJECT			DM
B	5/98	BEKK CONTRACT NO. 5002047 ONLY			
A	8/97	ISSUED FOR CONSTRUCTION	ACT		
REV	DATE	DESCRIPTION	DNM	CHD	APD



GEORGIA-PACIFIC
THE GROWTH COMPANY

COMMUNICATION PAPERS DIVISION
ASHDOWN OPERATIONS

CONSULTANT




TITLE:
MECHANICAL FLOWSHEET
REFINING AND BLEND CHEST

AFE NO.	PROJECT NO.
SCALE: NONE	DRAWING NO.

CHECKED:	641-MF-014	REV
APPROVED:		E

DISTRIBUTION:

- NOTES:
1. INSULATE PER SPECIFICATION 100-D-081-012.
 2. ALL INSTRUMENT TAG NUMBERS ON THIS DRAWING ARE PREFIXED WITH AREA NUMBER 641, UNLESS OTHERWISE NOTED.

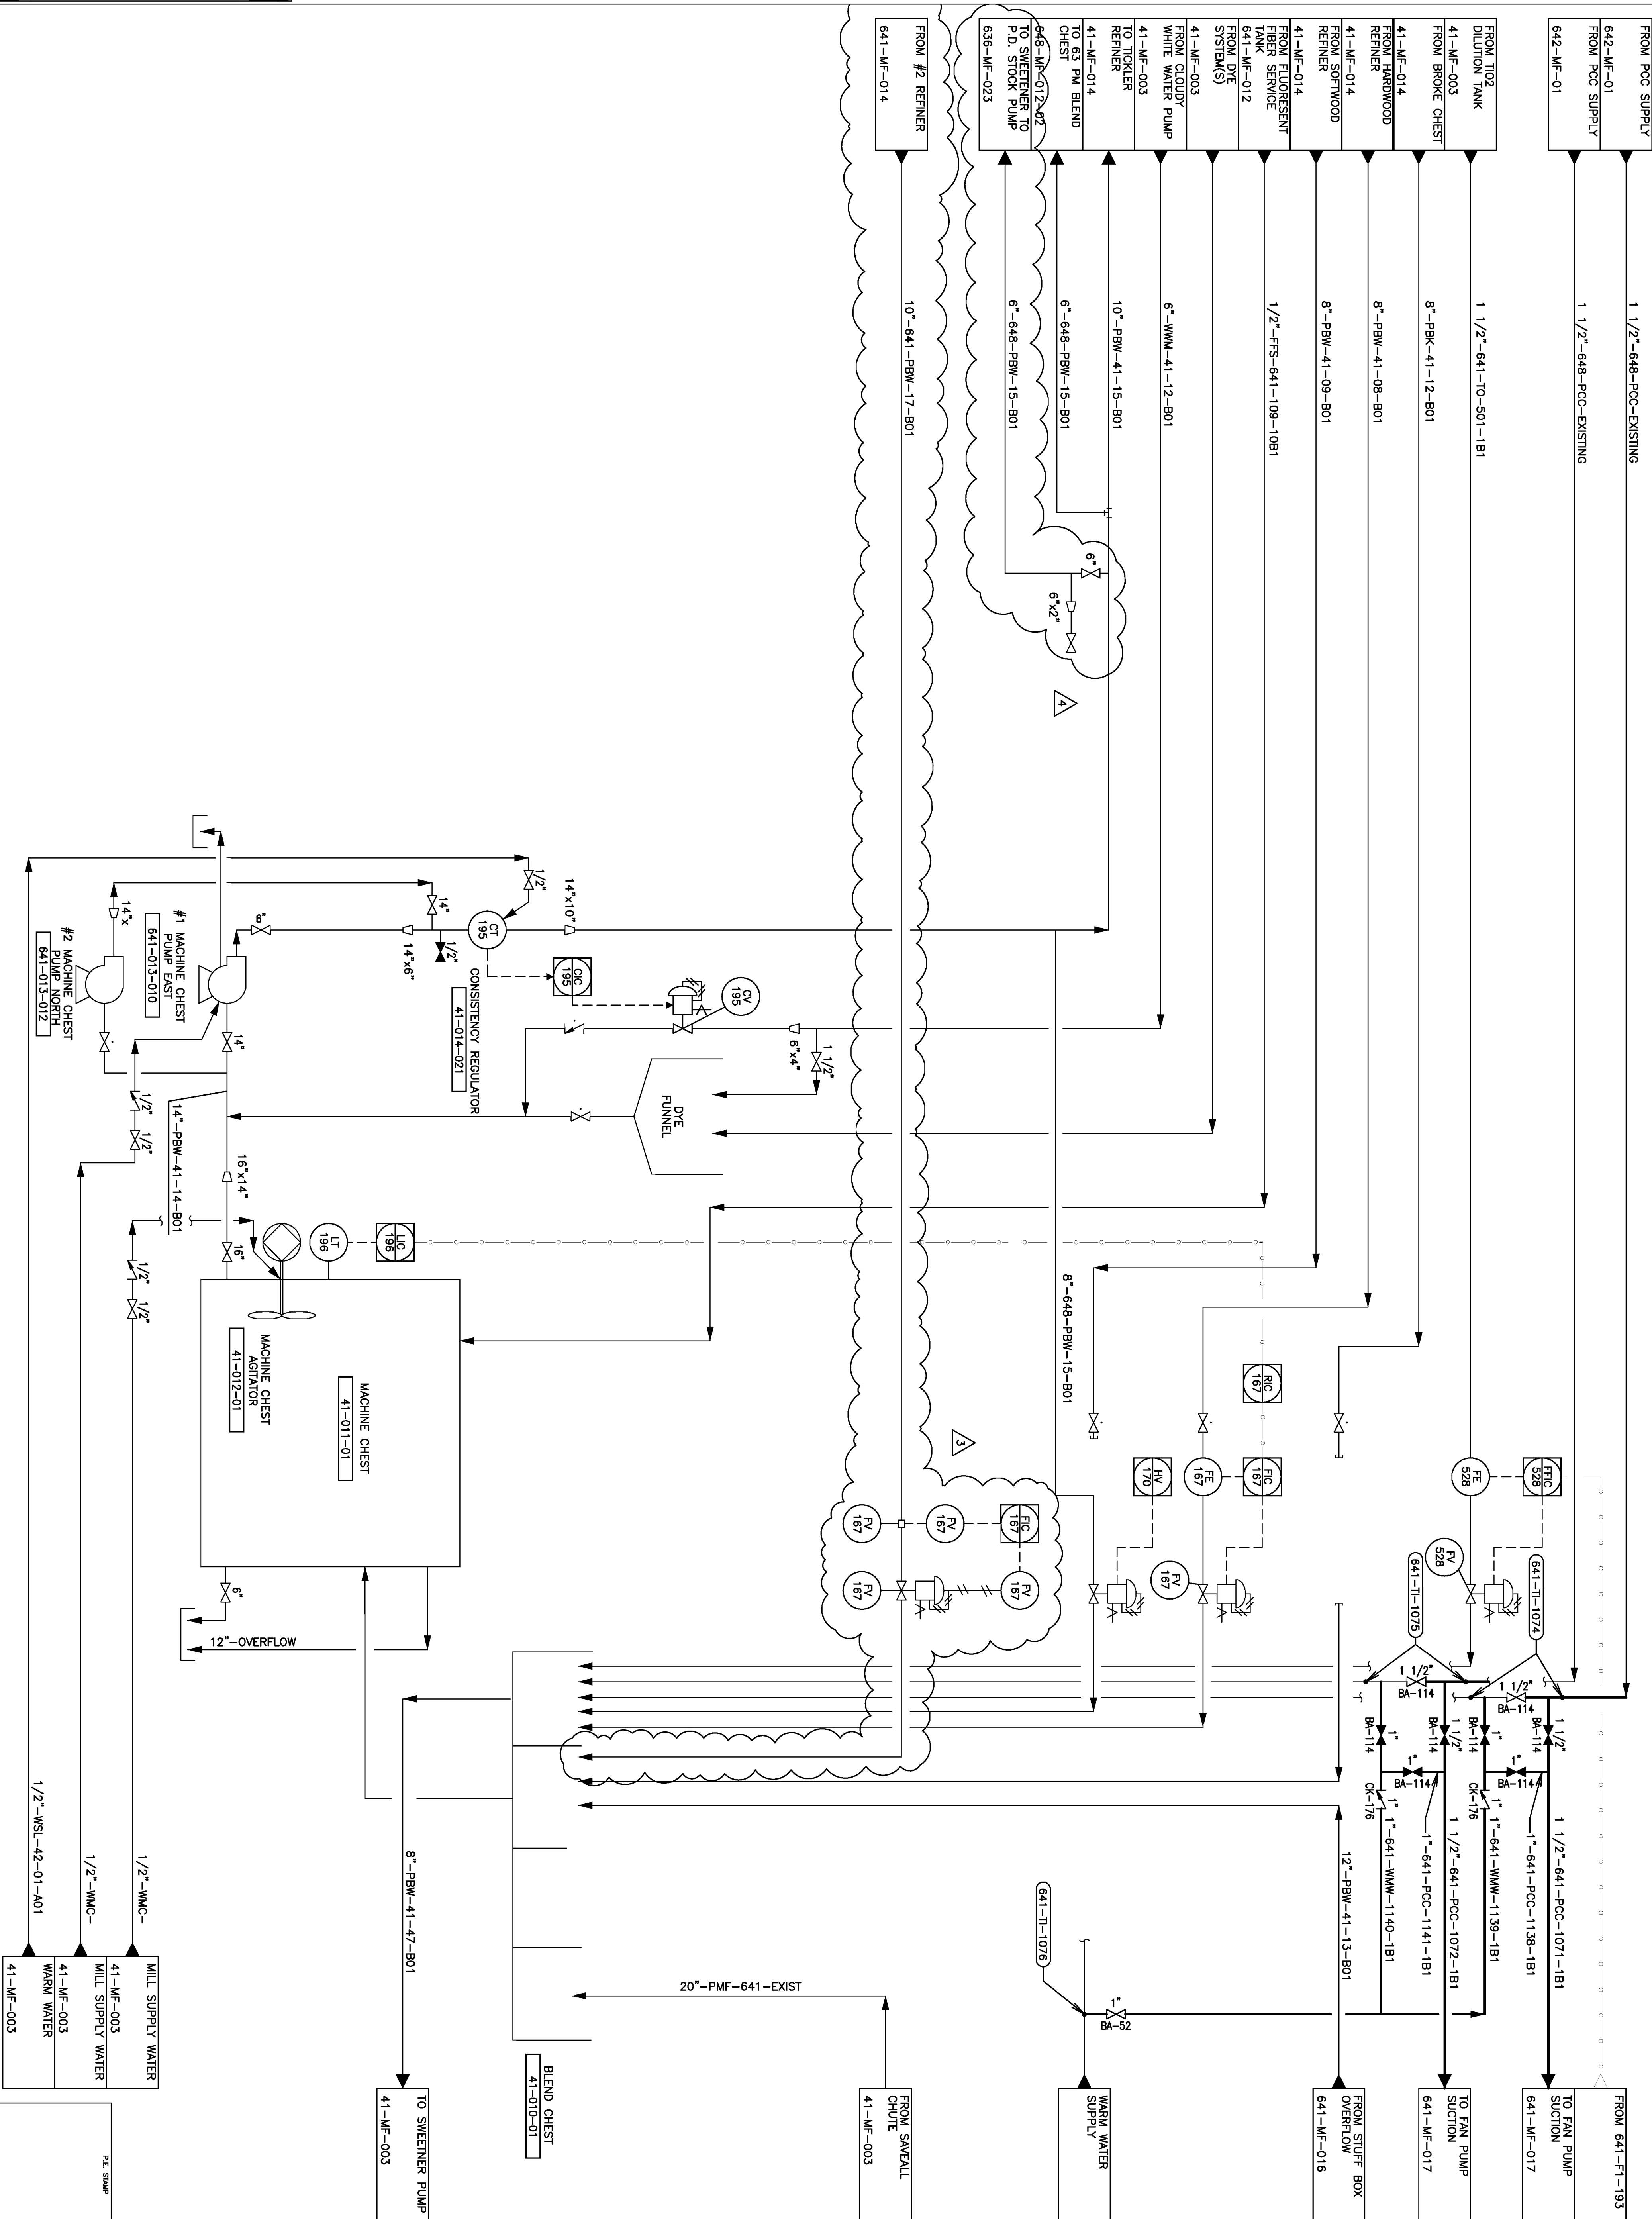

STAFF:	DATE:
INST.:	DATE:
MACH.:	DATE:
DEPT. MGR.:	DATE:


REV	DATE	DESCRIPTION	BY	CO	AP'D
0	7/06	RELEASED FOR DESIGN	WB		DW
1	8/06	REVISED WAVE CALLOUT	DW		
2	9/12	RELEASED FOR DESIGN - REDUCED SCOPE			
3	5/13	REMOVED LOOP 1171 AND FE FROM 1170	JLT		
4	1/14	LINE FROM MACH. CHEST PUMP TO SWING PUMP	JLT		

[illegible]

- NOTES:**

1. SENSODE PRESSURE PULSATION MEASUREMENT CONNECTION WITH VALVE AND PLUG SUPPLIED BY METSO.
2. REDUCER ORIENTATION PER METSO PIPING INSTRUCTIONS.
3. SLOPE UP IN DIRECTION OF FLOW PER METSO PIPING INSTRUCTIONS.
4. SECONDARY PCC ADDITION POINT, PRIMARY ADDITION POINT TO BLEND CHEST / MACHINE CHEST.
5. BENTONITE FILTER, FEED INSTRUMENTS AND PIPING LOCATED ON GROUND FLOOR NEAR PRIMARY SCREEN ADDITION POINT.
6. RELOCATE RETENTION AID FILTER TO AREA NEAR TAN PUMP ADDITION POINT.
7. SEAL WATER PRESSURE REQUIRED > 85 PSI.
8. ELECTROPOURISH PIPE FINISH, FIELD WELDS COTTONBALL FINISH, METAL TO METAL FLANGES.
9. DEFOMER ADDITION POINT (IF REQUIRED).
10. CAMELOCK TYPE QUICK DISCONNECT.
11. ALL INSTRUMENT TAG NUMBERS ON THIS DRAWING ARE PREPARED WITH AREA NUMBER 641, UNLESS OTHERWISE NOTED.
12. TEN DIAMETERS MINIMUM PIPE LENGTH.

 LEGEND:




FLOW LEGEND

BDTPD/%DS/GPM	MAXIMUM
BDTPD/%DS/GPM	DESIGN
BDTPD/%DS/GPM	MINIMUM

STAFF: _____	BOB BLOUNT	DATE: 11/29/06
INST.: _____	JK	DATE: 11/29/06
MECH.: _____	ROB HATES	DATE: 11/29/06
DEPT. MGR.: _____	DEI	DATE: 11/29/06

[illegible]

5002047

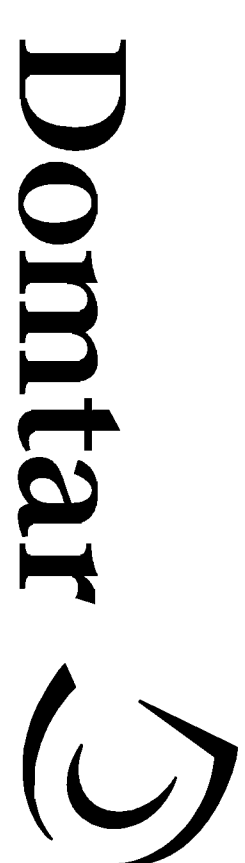

COMMUNICATION PAPERS DIVISION
ASHDOWN MILL

NO. 61 PAPER MACHINE
PROCESS & INSTRUMENTATION DIAGRAM
PRIMARY & HEADBOX DILUTION SCREEN

PROJECT NO.	
DRAWING NO.	
DATE	
SCALE:	NONE
DRBNM:	DJT
CHECKED:	
APPROVED:	
APPROVED:	

641-MF-017

SHEET 1 OF 1

NOTES:


1. ALL INSTRUMENT TAG NUMBERS ON THIS DRAWING ARE PREFIXED WITH AREA NUMBER 641, UNLESS OTHERWISE NOTED.

LEGEND:

VENDOR SUPPLIED INSTRUMENT


FLOW LEGEND:

BDTPD/%DS/GPM	MAXIMUM
BDTPD/%DS/GPM	DESIGN
BDTPD/%DS/GPM	MINIMUM

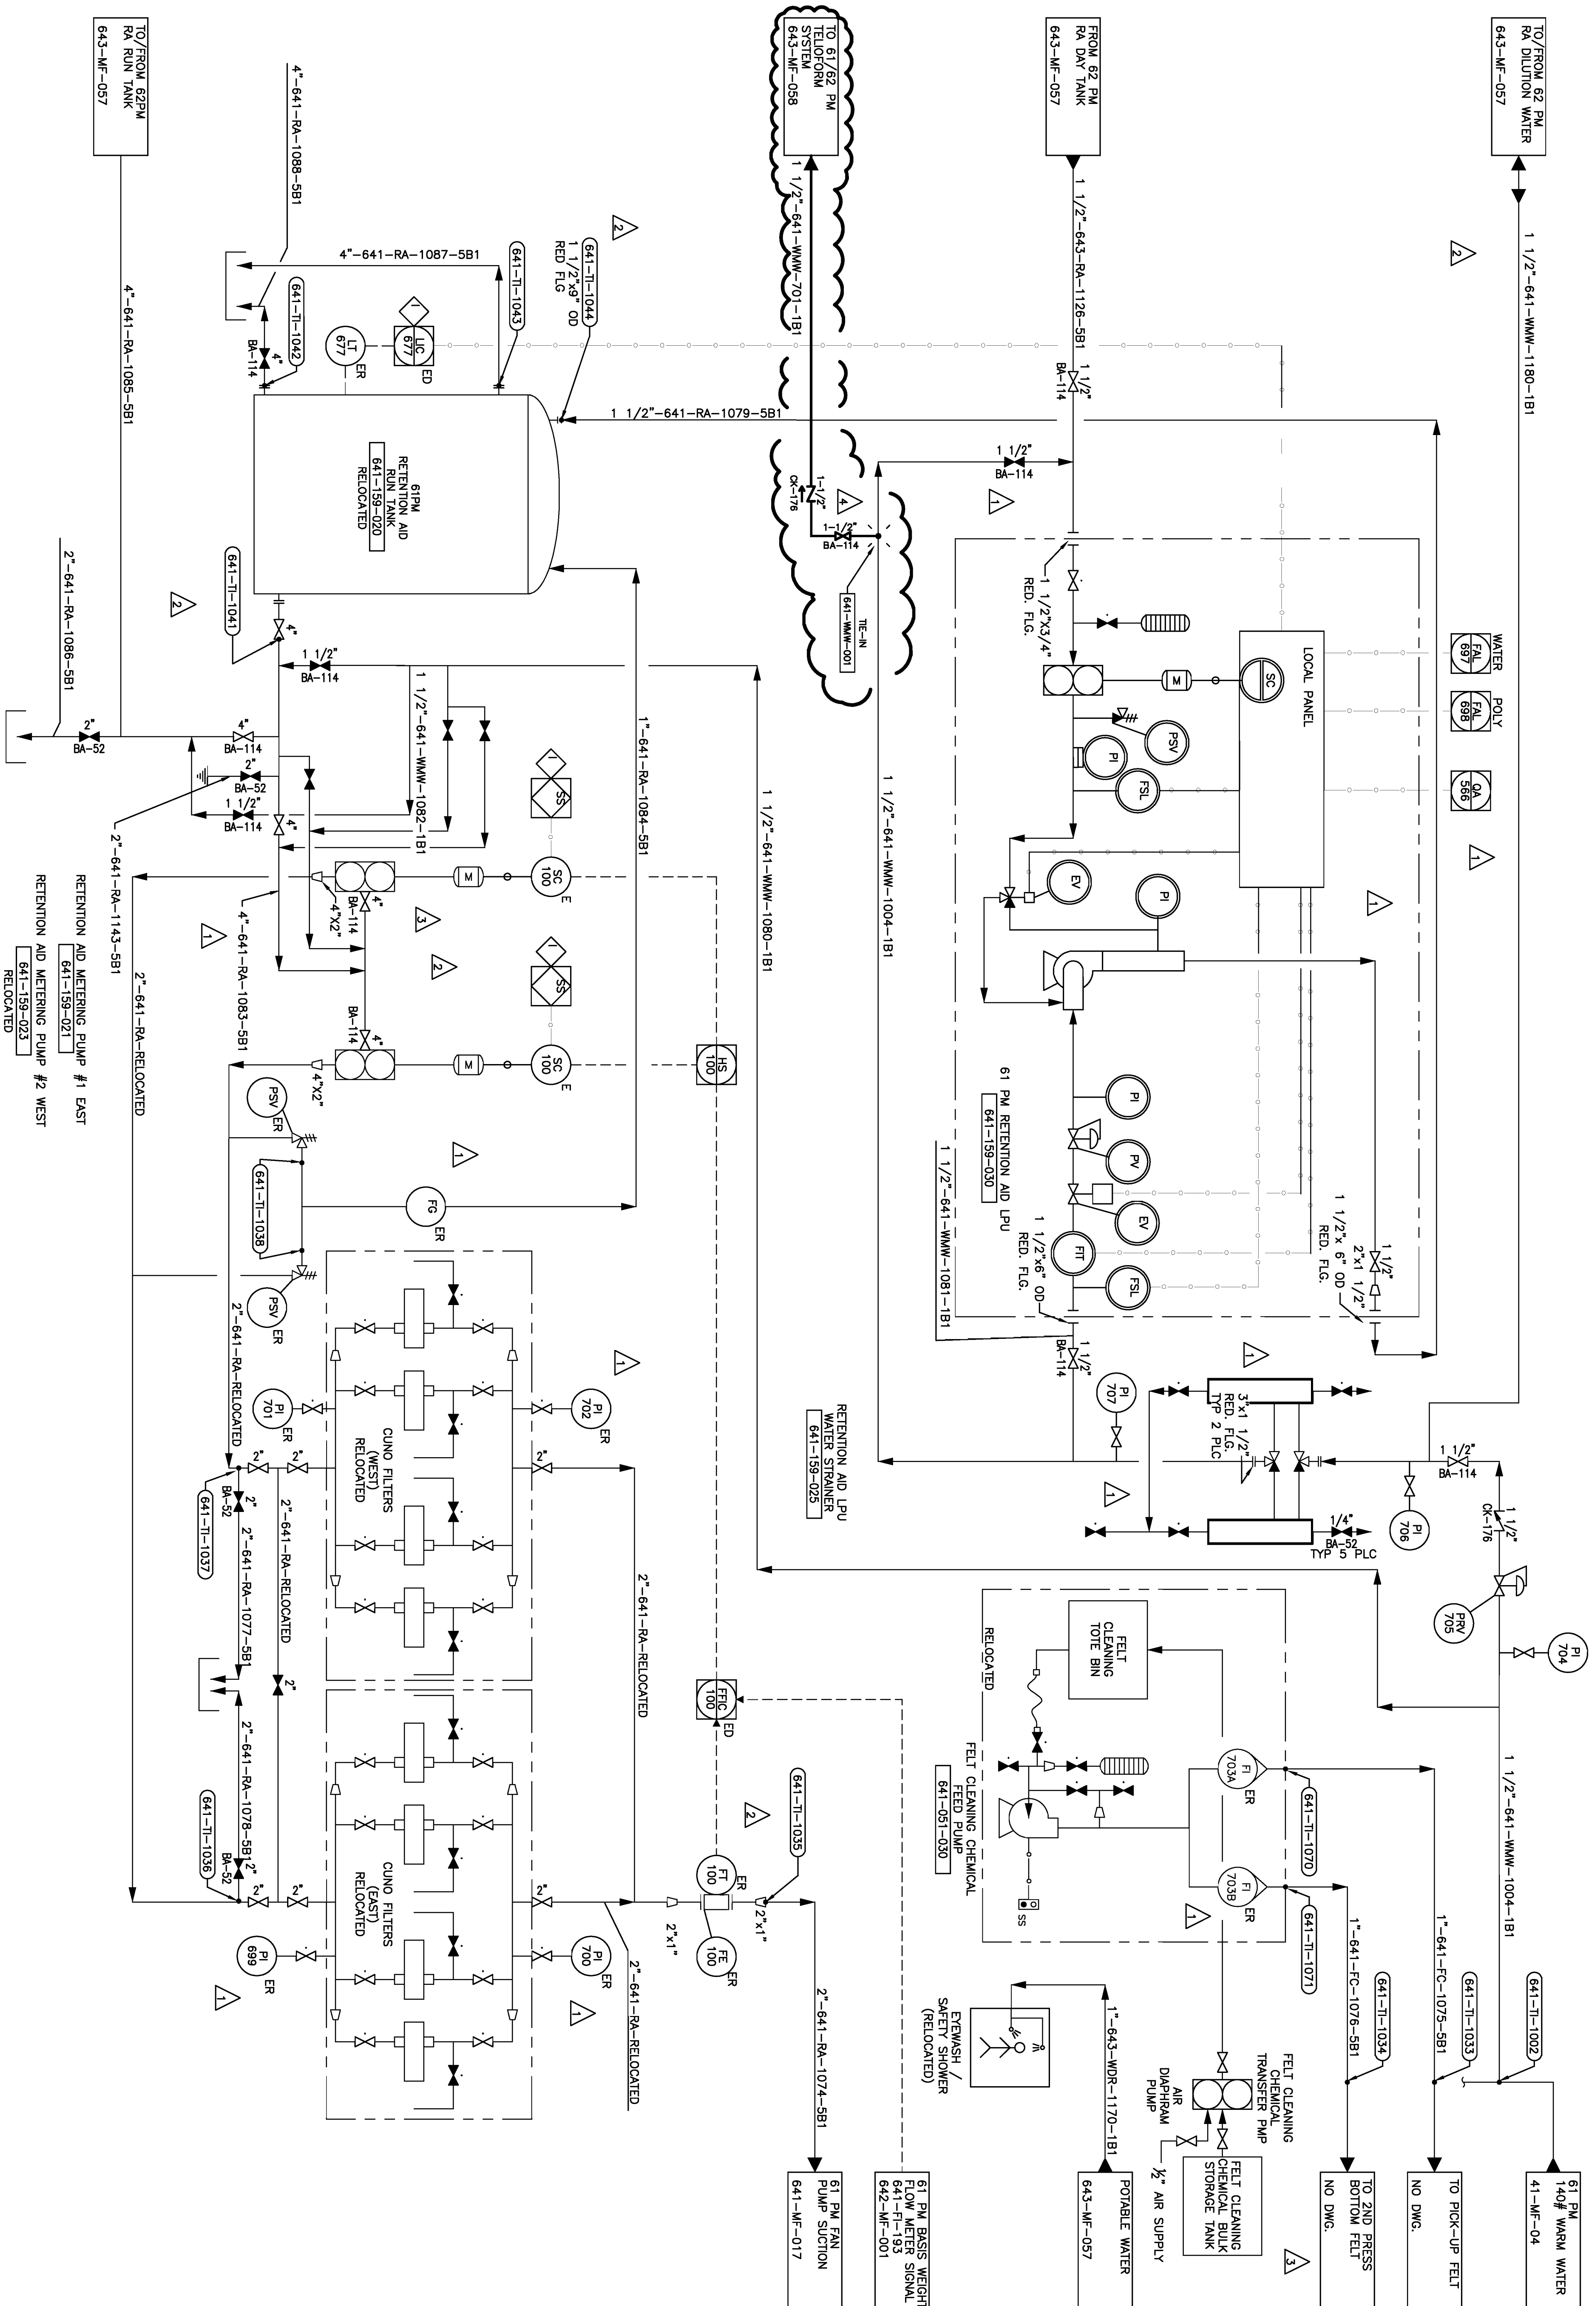


STAFF:	BOB BLOUNT	DATE:	11/29/06
INST.:	JK	DATE:	11/29/06
MECH:	ROB HAYES	DATE:	11/29/06
DEPT. MGR.:	DFT	DATE:	11/29/06

4	10/2/09	WATER TIE-IN FOR TELEPHONE RET. AND	DW	DW		
3	11/29/08	AS BUILT REVISION	RW	DW		
2		RA FILTER ADDITION		DW		
1	08/06	REV INSTR. & PIPING	DW			
0	7/06	RELEASED FOR DESIGN	WB	DW		
REV	DATE	DESCRIPTION	DW	CO	APD	

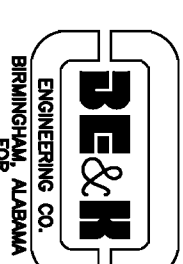

5002047

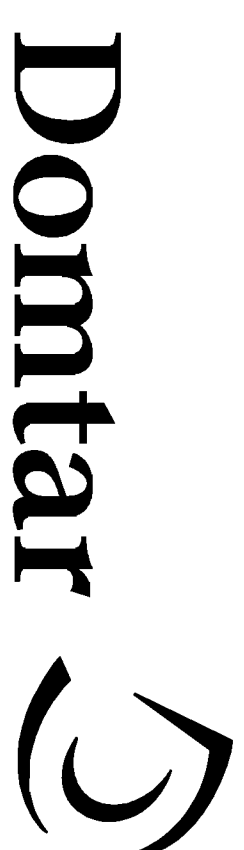


COMMUNICATION PAPERS DIVISION
ASHDOWN MILL

NO. 61 PAPER MACHINE
PROCESS & INSTRUMENTATION DIAGRAM
RETENTION AID SYSTEM



P.E. STAMP		PROJECT NO.	
AR NO.			REV
SCALE:	NONE	DATE	
DRAWN:		641-MF-018	4
CHECKED:			
APPROVED:			
APPROVED:			

NOTES

1 ALL INSTRUMENT LOOP NUMBERS SHALL HAVE PREFIX 641, EXCEPT WHERE SHOWN OTHERWISE

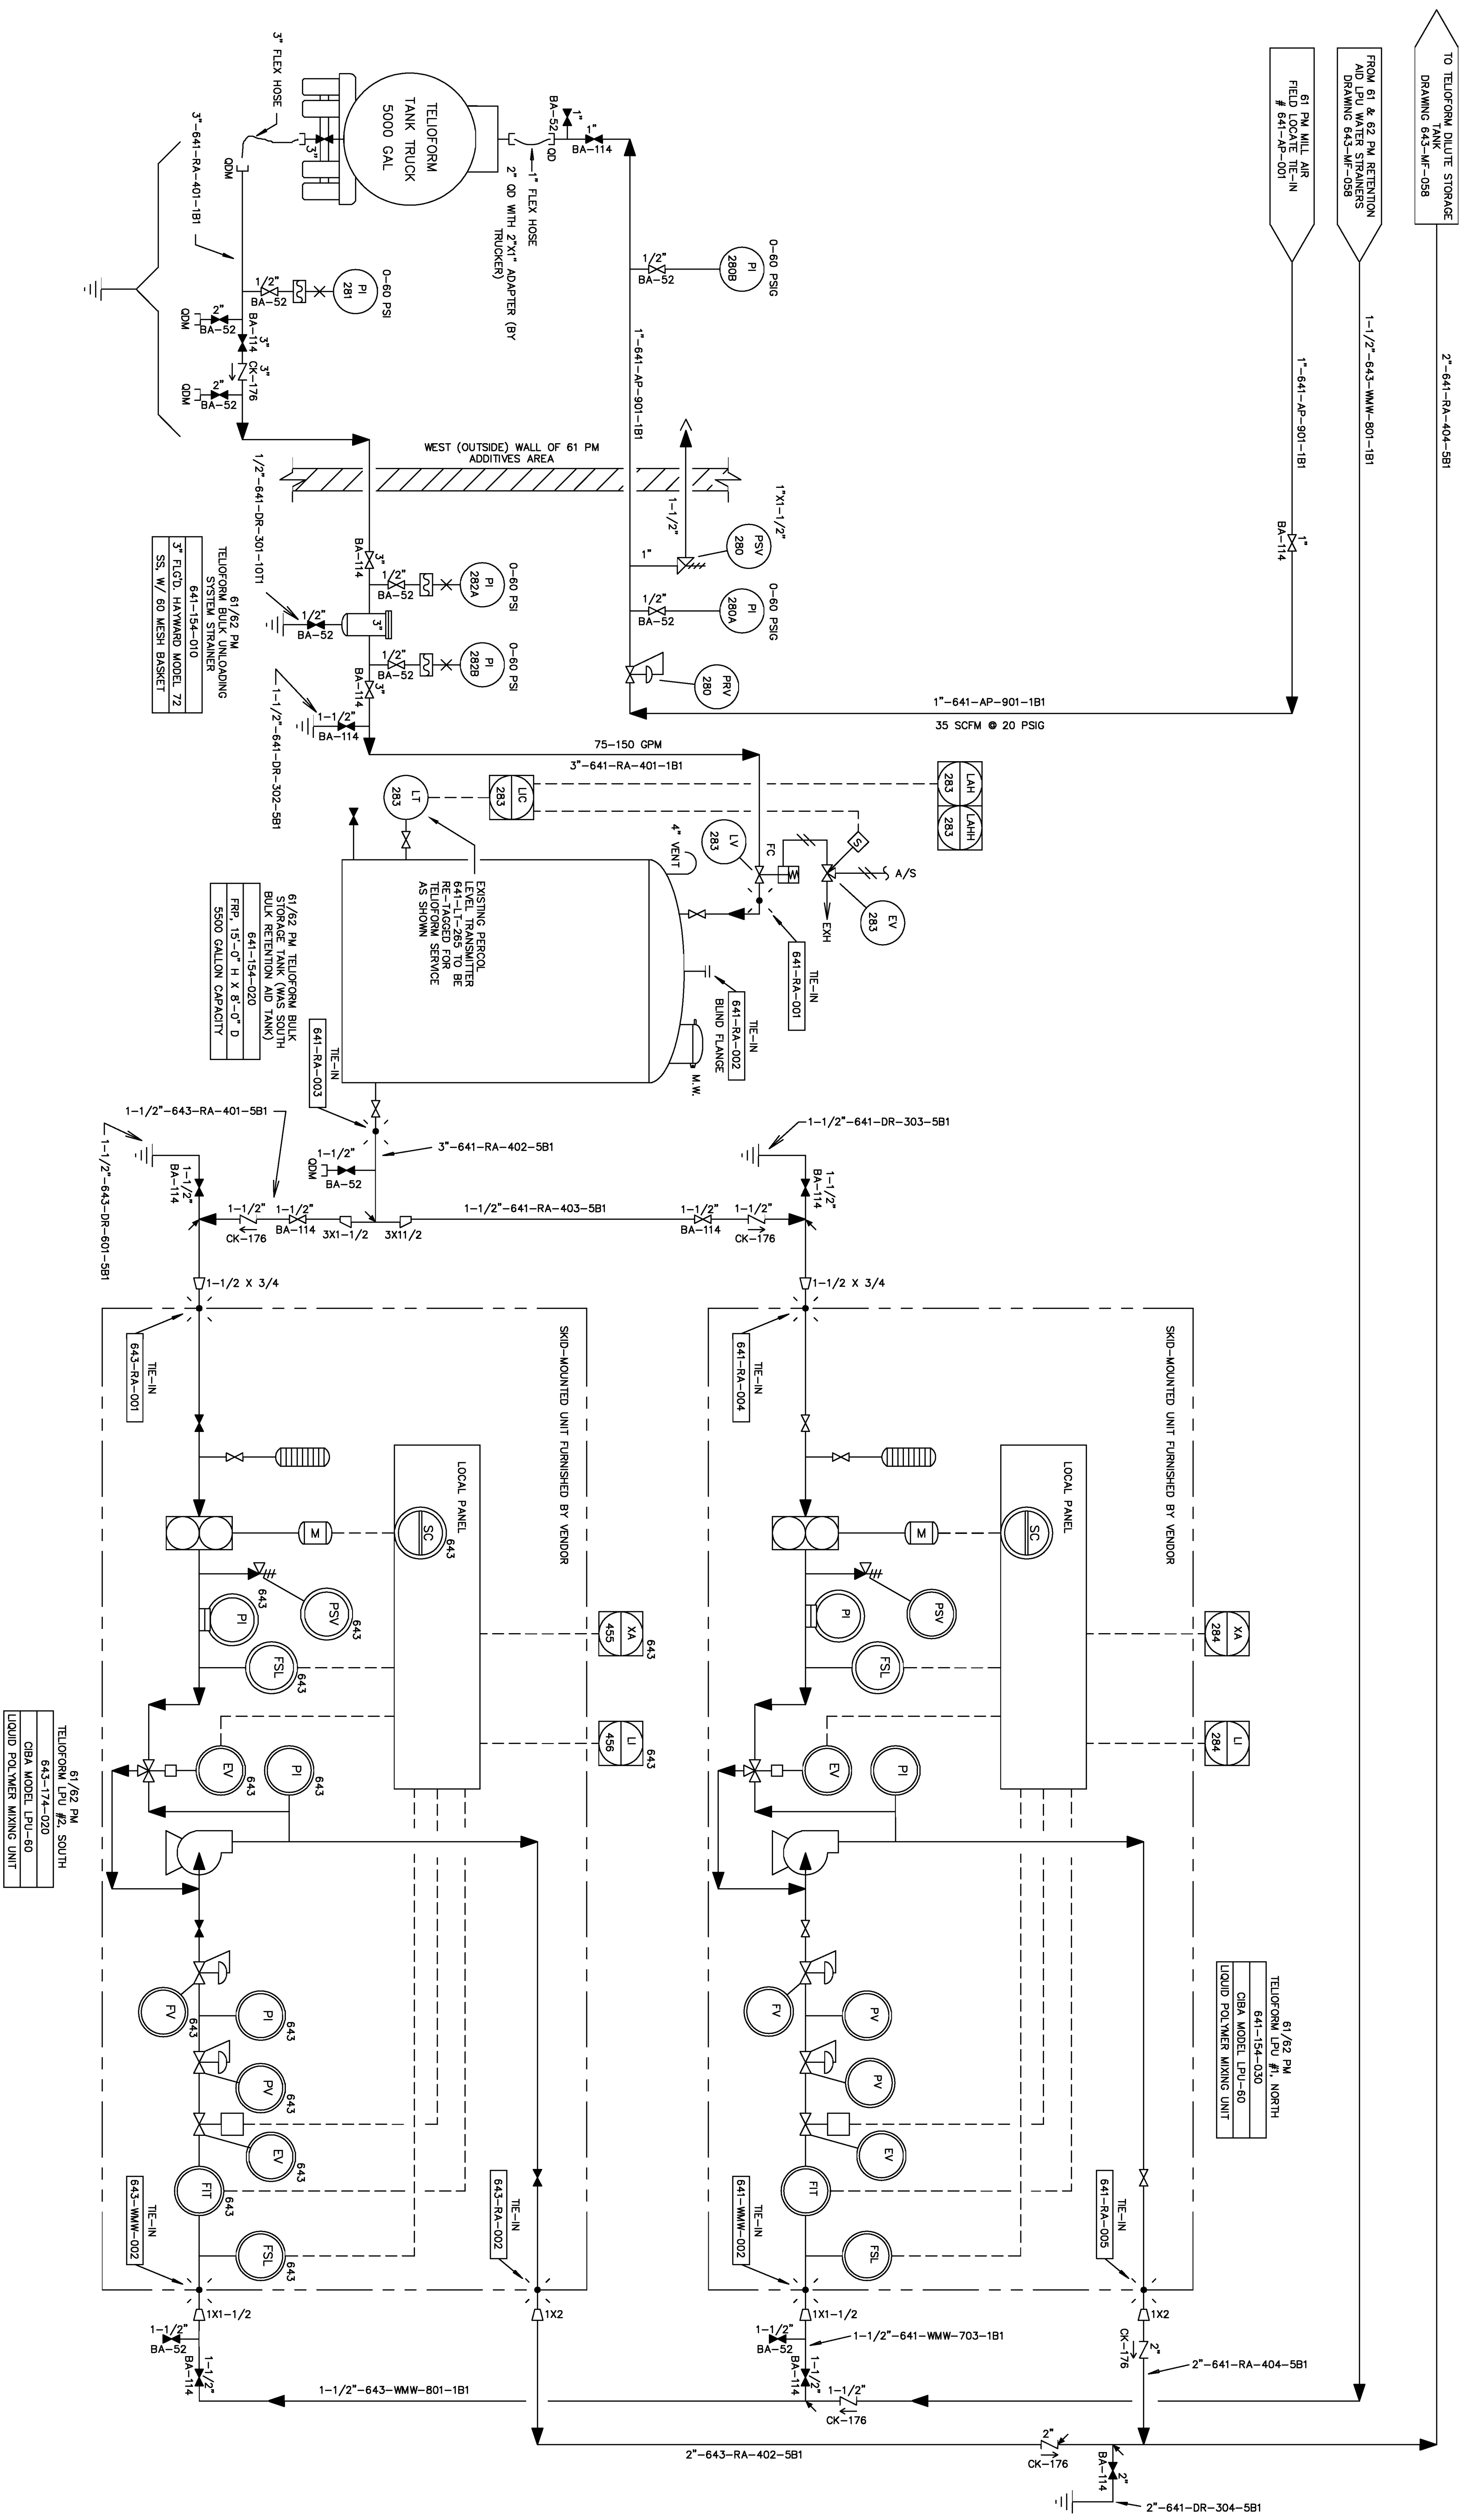

DOMTAR CORPORATION ASHDOWN MILL			
NO. 61 & 62 PAPER MACHINES PROCESS & INSTRUMENTATION DIAGRAM TELEFORM BULK STG. & LPU SYSTEMS			
AS NO.	PROJECT NO.		
SCALE:	NONE	DATE	DRAWING NO.
DRAWN:	DJM	11/3/09	
CHECKED:			
APPROVED:			
APPROVED:			
641-MF-019		A	
SHEET 1 OF 1			

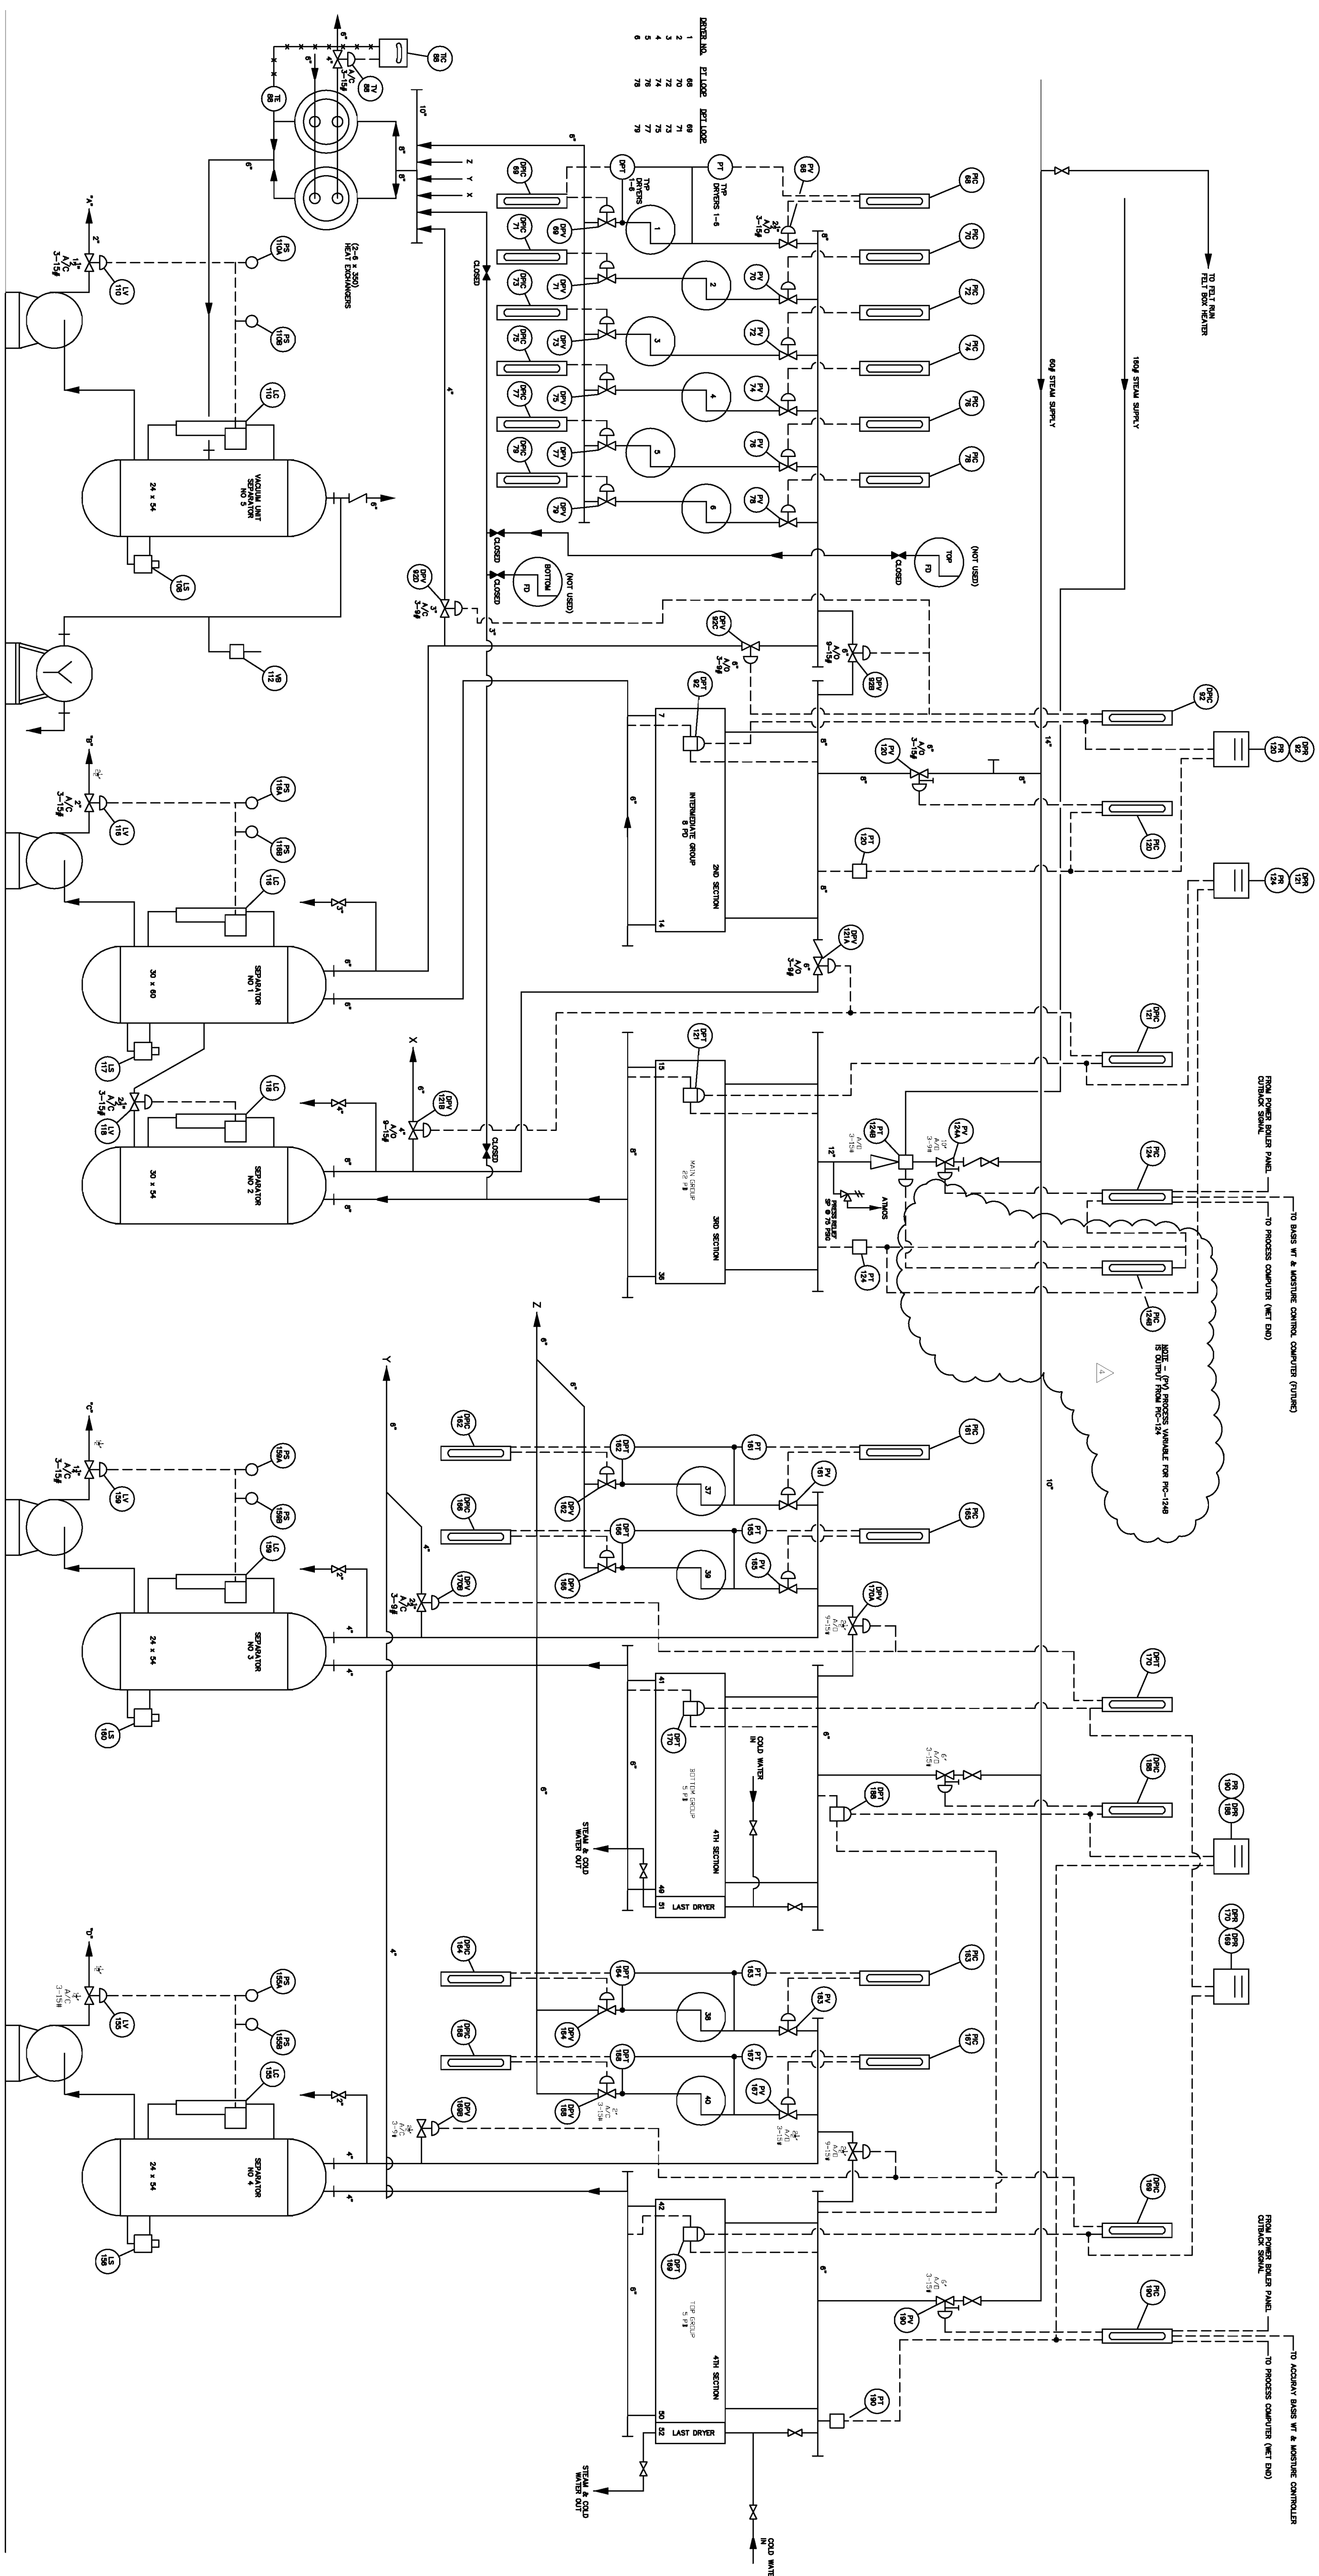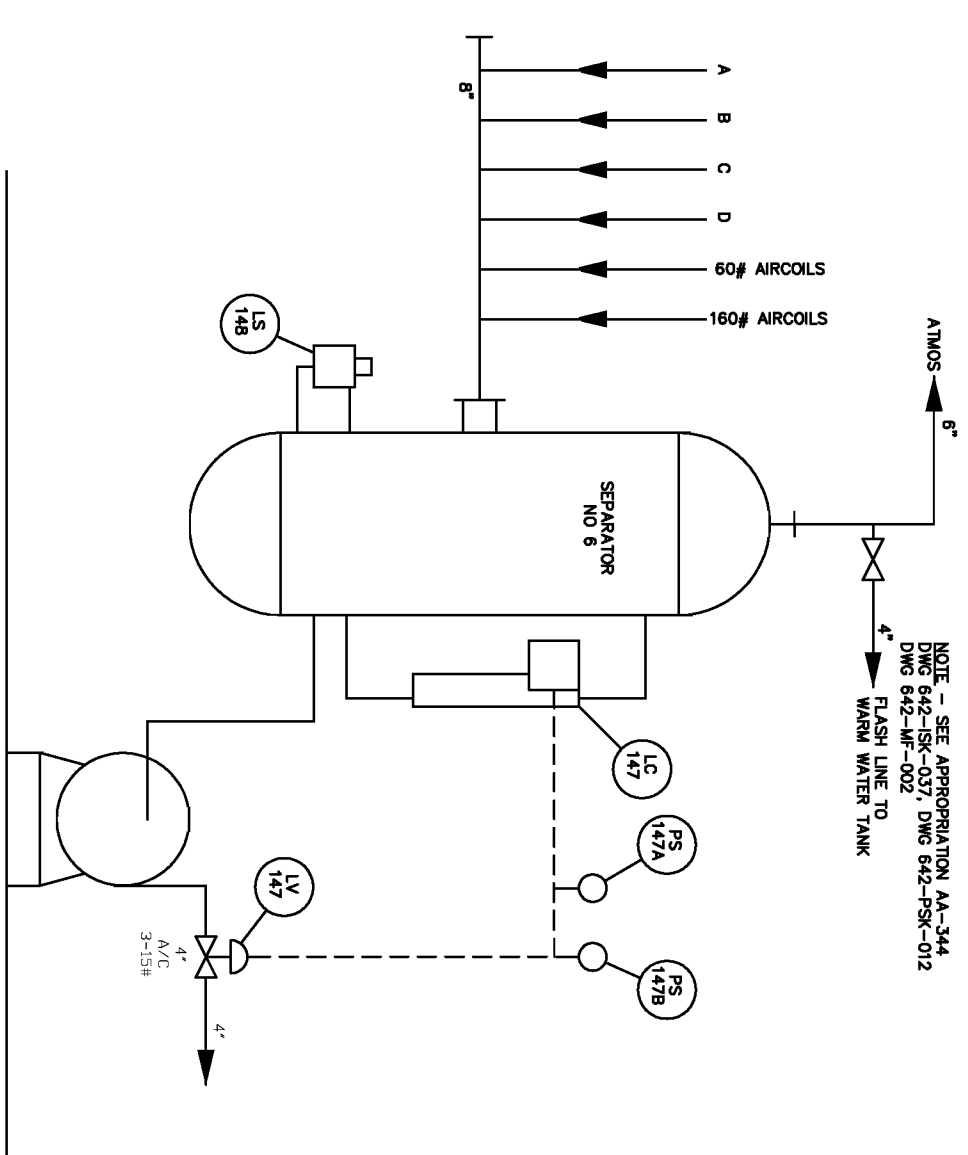

NOTE -
REFERENCE: ROSS MIDWEST FULTON
DWG NO B-15443-2

REV	DATE	DESCRIPTION	BY	CHKD	APPROV
4	8/18/04	ADDED PIC 1248, REDRAWN ON CAD	SPC		
3	10/8/03	CHG HEADER SIZES, 4TH SECTION	TRP		
2	4/25/86	DELETED ITEM NOS. AND LOOP NOS	TRP		
1	2/28/79	ADDED REF. NOTE	SM		
			REV	CHKD	APPROV




COMMUNICATION PAPERS DIVISION
ASHDOWN MILL



Brown & Root, Inc.
Engineers • Constructors
Houston, Texas USA

No 61 PAPER MACHINE DRYER STEAM & DRAINAGE SYSTEM

PROJECT NO.			REV
A/E NO.			
SCALE:	NITS	DATE	
DRAWN:	B GILES	6/27/73	
CHECKED:			
APPROVED:	642-MF-006		4
APPROVED:	SHEET 1 OF 2		
DISTRIBUTION:			

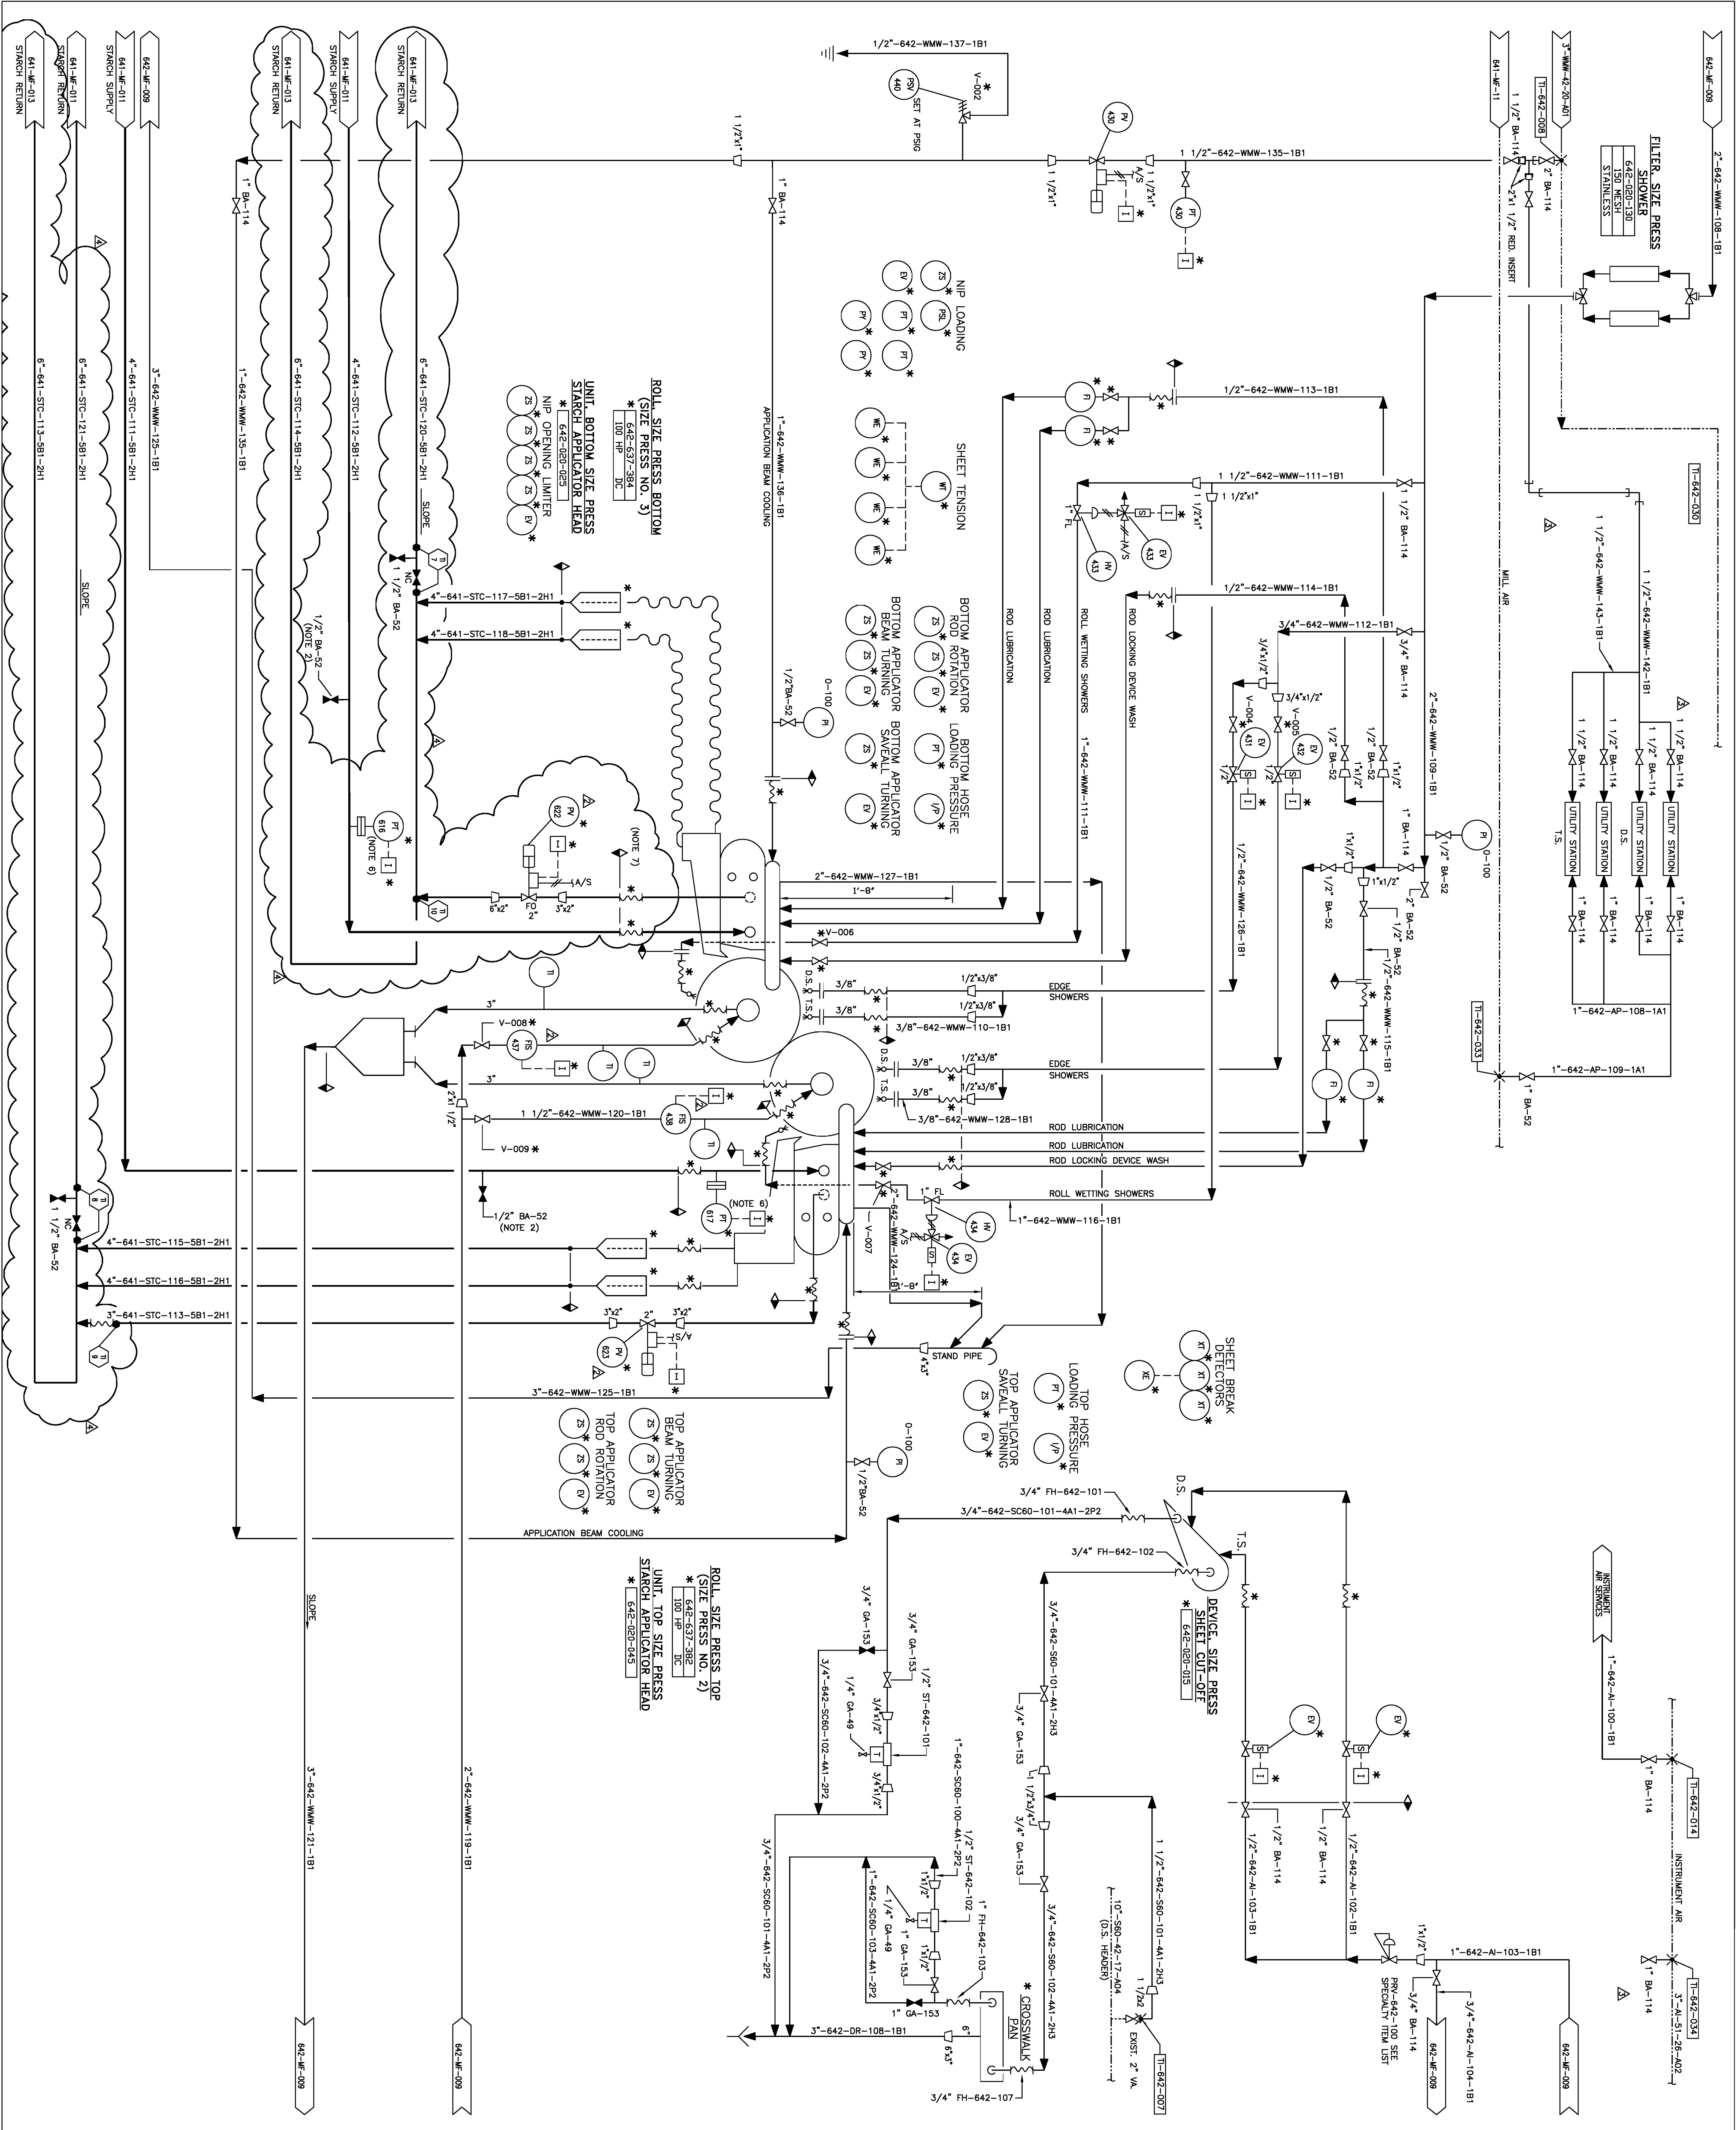

- NOTES:
1. VENDOR PIPING TERMINAL POINT
 2. PIPING TERMINAL POINT
 3. PIPING TERMINAL POINT
 4. PIPING TERMINAL POINT
 5. PIPING TERMINAL POINT
 6. PIPING TERMINAL POINT
 7. PIPING TERMINAL POINT
 8. PIPING TERMINAL POINT

Georgia-Pacific

THE GROWTH COMPANY

COMMUNICATION PAPERS DIVISION

61 PM METERING SIZE PRESS
ENGINEERING FLOW DIAGRAM
SIZE PRESS

DATE	BY	DATE	BY	DATE	BY
06/03/04	NDNE	07/09/98	NDNE	07/09/98	NDNE
02/02/04	NDNE	07/09/98	NDNE	07/09/98	NDNE
11/24/98	NDNE	07/09/98	NDNE	07/09/98	NDNE
10/28/98	NDNE	07/09/98	NDNE	07/09/98	NDNE
10/19/98	NDNE	07/09/98	NDNE	07/09/98	NDNE

R-S-H ENGINEERING, INC.
MONROE, LA
TEL: (318)253-4009
FAX: (318)367-4828
JOB NO: 12048

61 PM METERING SIZE PRESS
ENGINEERING FLOW DIAGRAM
SIZE PRESS

DATE	BY	DATE	BY	DATE	BY
06/03/04	NDNE	07/09/98	NDNE	07/09/98	NDNE
02/02/04	NDNE	07/09/98	NDNE	07/09/98	NDNE
11/24/98	NDNE	07/09/98	NDNE	07/09/98	NDNE
10/28/98	NDNE	07/09/98	NDNE	07/09/98	NDNE
10/19/98	NDNE	07/09/98	NDNE	07/09/98	NDNE

NOTES:

1 - HV-449 & HV-450 WILL CLOSE AND NOT OPEN IF
THE ASSOCIATED FELT SPEED IS LESS THAN
GRWM SPEED OR MORE THAN 1000 RPM. PUMP
WILL STOP AND NOT START UNLESS AT LEAST ONE
OF THE DRYER FELT SPEEDS IS ABOVE GRWM SPEED
OFF TO START PUMP. UNLESS AT LEAST ONE
VALUE EITHER HV-449 OR HV-450 IS OPEN
AND THE PUMP HAS BEEN RUNNING 2 MINUTES,
THE PUMP WILL STOP.

LEGEND:
NORMAL FLOW (GPM)/PRESSURE (PSIG)/TEMPERATURE (°F)
DESIGN FLOW (GPM)/PRESSURE (PSIG)/TEMPERATURE (°F)

STAFF: BOB BLOUNT	DATE: 11/29/06
INST: JK	DATE: 11/29/06
MECH: ROB HAYES	DATE: 11/29/06
DEPT. MGR: DET	DATE: 11/29/06


6	11/29/06	RELEASED THE SECTION TO DESIGN PROJECT	1W
5	06/06	RELEASED THE SECTION TO DESIGN PROJECT	1W
4	6/6/06	RELEASED THE SECTION TO DESIGN PROJECT	1W
3	10/26/98	ADDED INSTRUCTIONS & NOTATIONS	MS
2	5/6/98	DESIGNED AS NOTED	ALL
1	1/21/98	ISSUED FOR CONSTRUCTION	MM
0	11/6/96	ISSUED FOR CONSTRUCTION	MM
REV	DATE	DESCRIPTION	BY
R-S-H ENGINEERING, INC.			
MONROE, LA. TEL. (318)233-4009			
www.rsheng.com FAX (318)367-4828			
JOB NO: 11074 CAD FILE: 642W010			

Georgia-Pacific
THE GROWTH COMPANY

COMMUNICATION PAPERS DIVISION
ASHDOWN OPERATIONS

TITLE
NO. 61 PAPER MACHINE
PROCESS & INSTRUMENTATION DIAGRAM
DRYER FELT SHOWER SYSTEM

DRAWN: NONE	DATE: 11/29/98	SP. PROJ. NO. AA-436	DRAWING NO.	REV
CHECKED: B. BAILL	DATE: 11/11/98		642-MF-010	6
APPROVED: C. RAND, JR.	DATE: 11/11/98		SHEET 1 OF 1	
APPROVED:			APP. NO.	

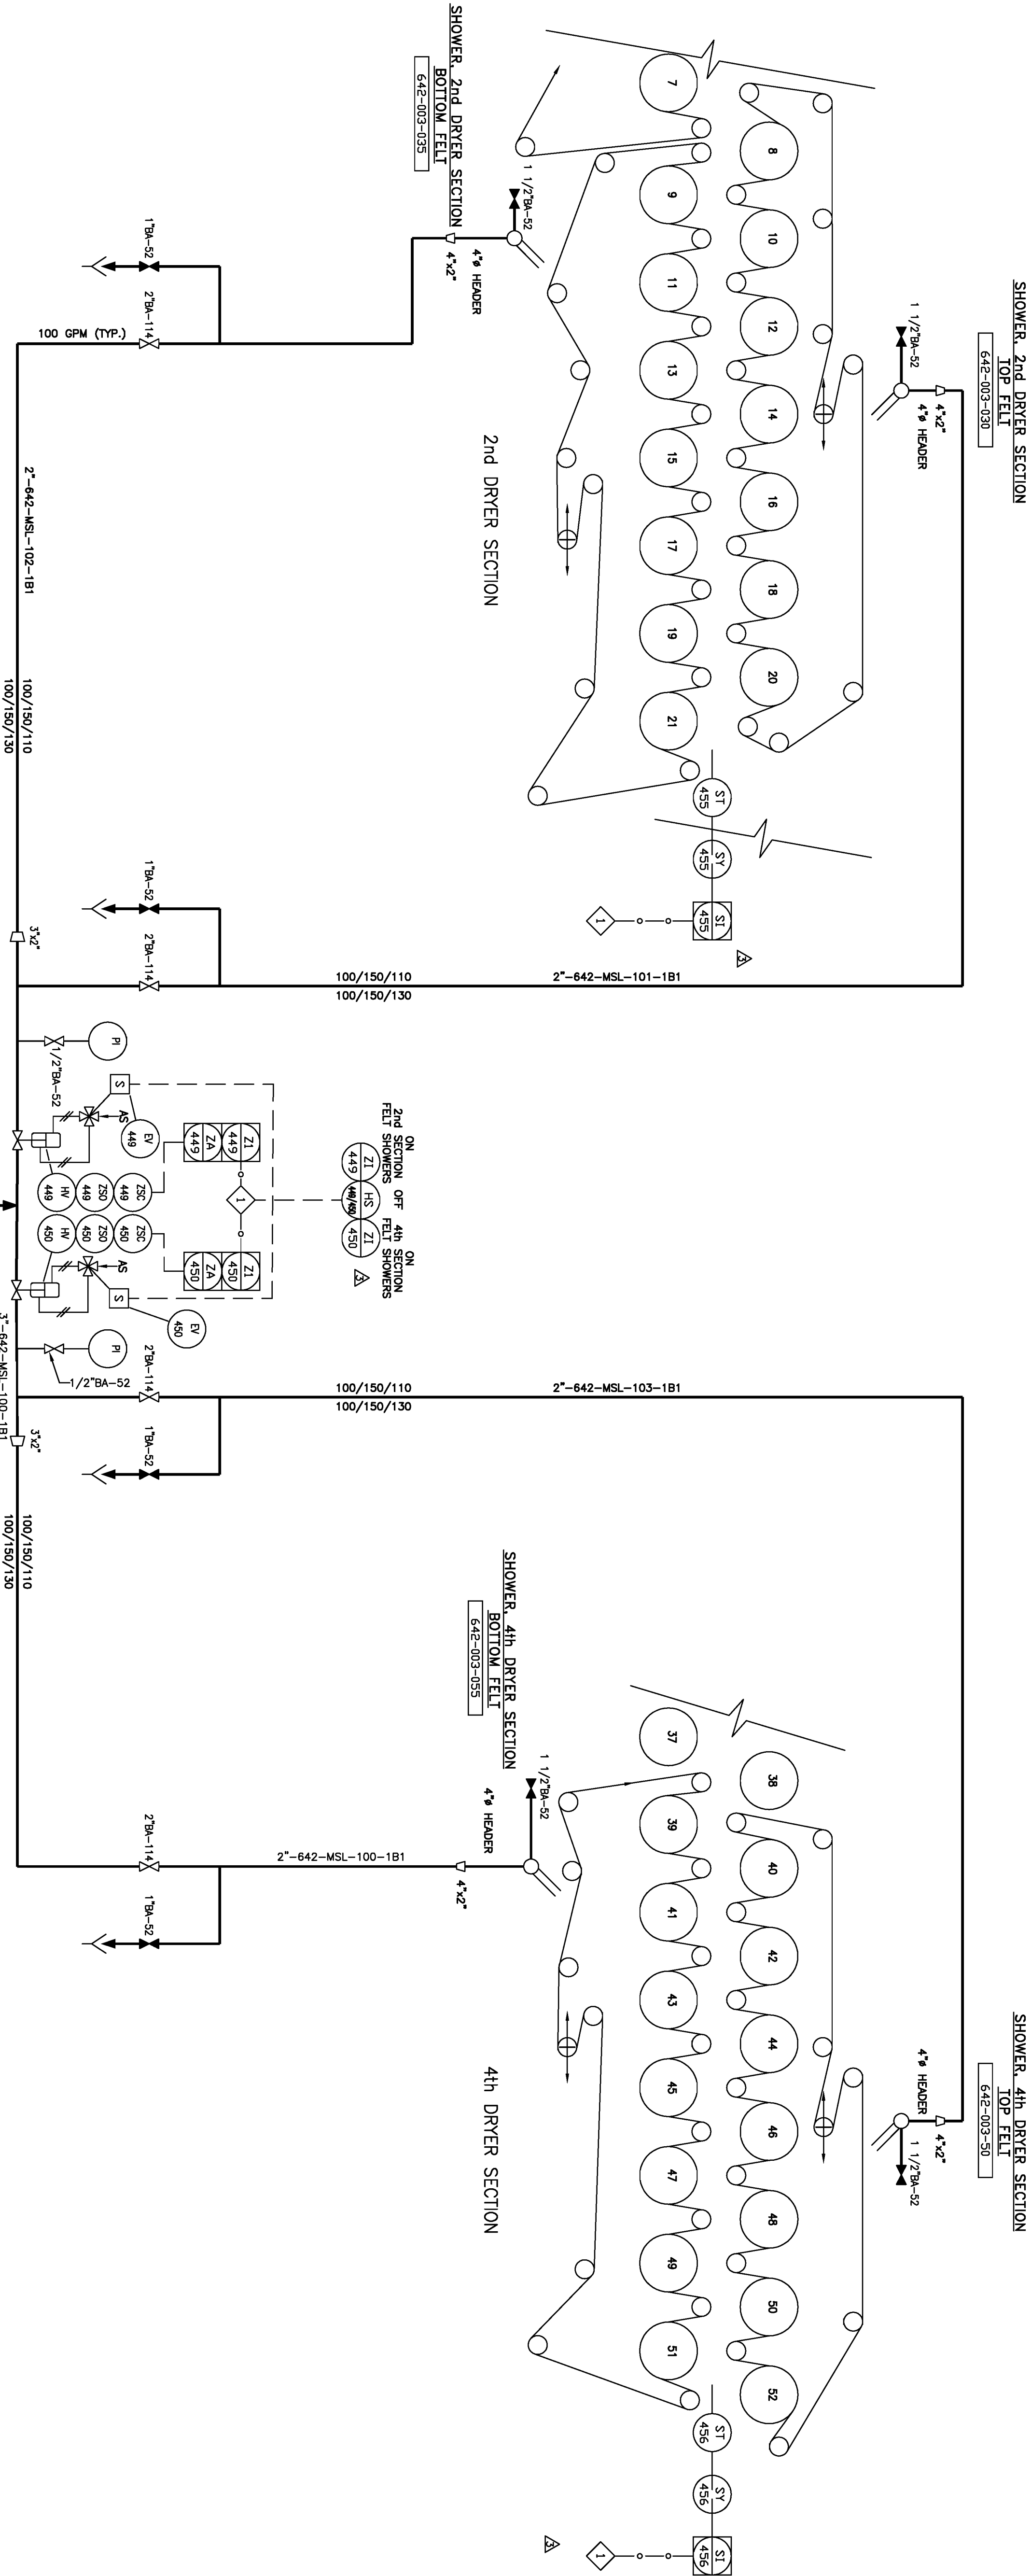

DRY FELT SHOWER SYSTEM
642-003-000

MAX. HORIZONTAL RUN BETWEEN TRAPS (FEET)												
STEAM PRESSURE (PSIG)												
PIPE SIZE (IN.)	10	20	50	100	200	300	400					
UNDER 6	500	500	500	500	500	500	500					
6	500	500	480	410	340	310	280					
8	490	410	320	270	230	205	190					
10	350	280	230	190	160	150	140					
12	280	235	180	155	130	120	110					
14	220	185	150	125	105	100	100					
16	170	140	110	100	100	100	100					
18	135	110	100	100	100	100	100					
OVER 18	100	100	100	100	100	100	100					

- NOTES:
- STEAM TRAPS TO BE LOCATED AT ALL CHANGE IN DIRECTION AND PER CHART BELOW.
 - A. 1/2" STEAM TRAP YARWAY-SERIES 720 OR ABOVE WITH 1/2" INLET AND 1/2" OUTLET TO PREVENT FREEZING. INTEGRAL STRAINER WITH BLOW-DOWN. B. PIPING TO BE PER APPLICABLE SPECIFICATION. C. FOR HIGH CONDENSATE LOAD, CHECK TRAP SIZE REQUIREMENT.

- FIELD TO ROUTE AIR VENT EXHAUST PORT TO A SAFE DISCHARGE LOCATION.
- FIELD TO ROUTE DRAIN HEADER TO A SAFE LOCATION AS DIRECTED BY GEORGIA-PACIFIC PERSONNEL.

LEGEND

- * SUPPLIED BY THERMAL SYSTEM GROUP
- W— FLEX CONNECTION
- VB VACUUM BREAKER
- AV AIR VENT
- T TRAP

REV	DATE	DESCRIPTION	BY	APPROVED	DATE
0	11/02/00	RELEASED FOR CONSTRUCTION	BR	AL	JC






COMMUNICATION PAPERS DIVISION
ASHDOWN OPERATIONS










TITLE: NO. 61 PAPER MACHINE
DRY END AIR MAKE-UP UNIT
P&ID

A/E NO.		PROJECT NO.		REV	
SCALE	N/A	DATE		DRAWING NO.	
DRAWN	DV	9/00			
CHECKED	AL	9/00			
APPROVED	M.B.	9/00			

PROCESS CONDENSATE
REMOVAL MODULE *
642-061-125
003-00662

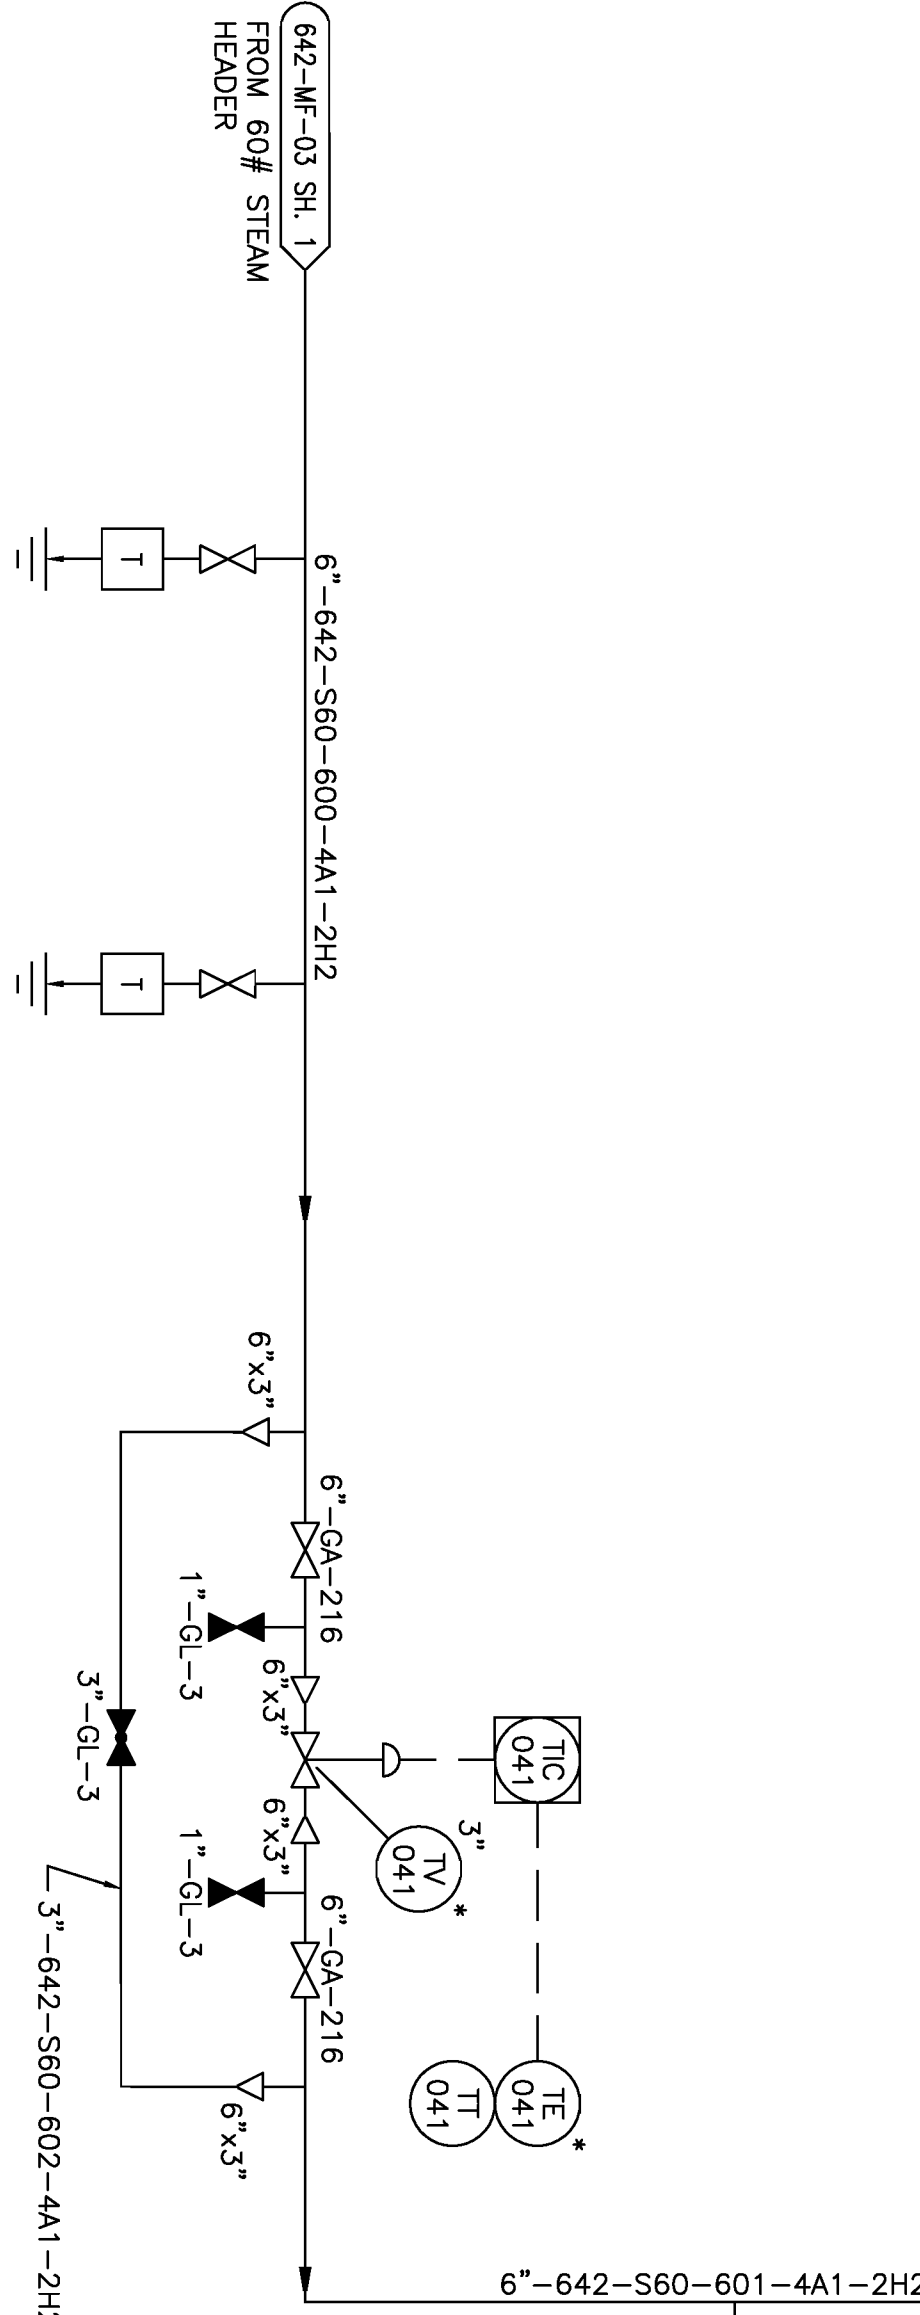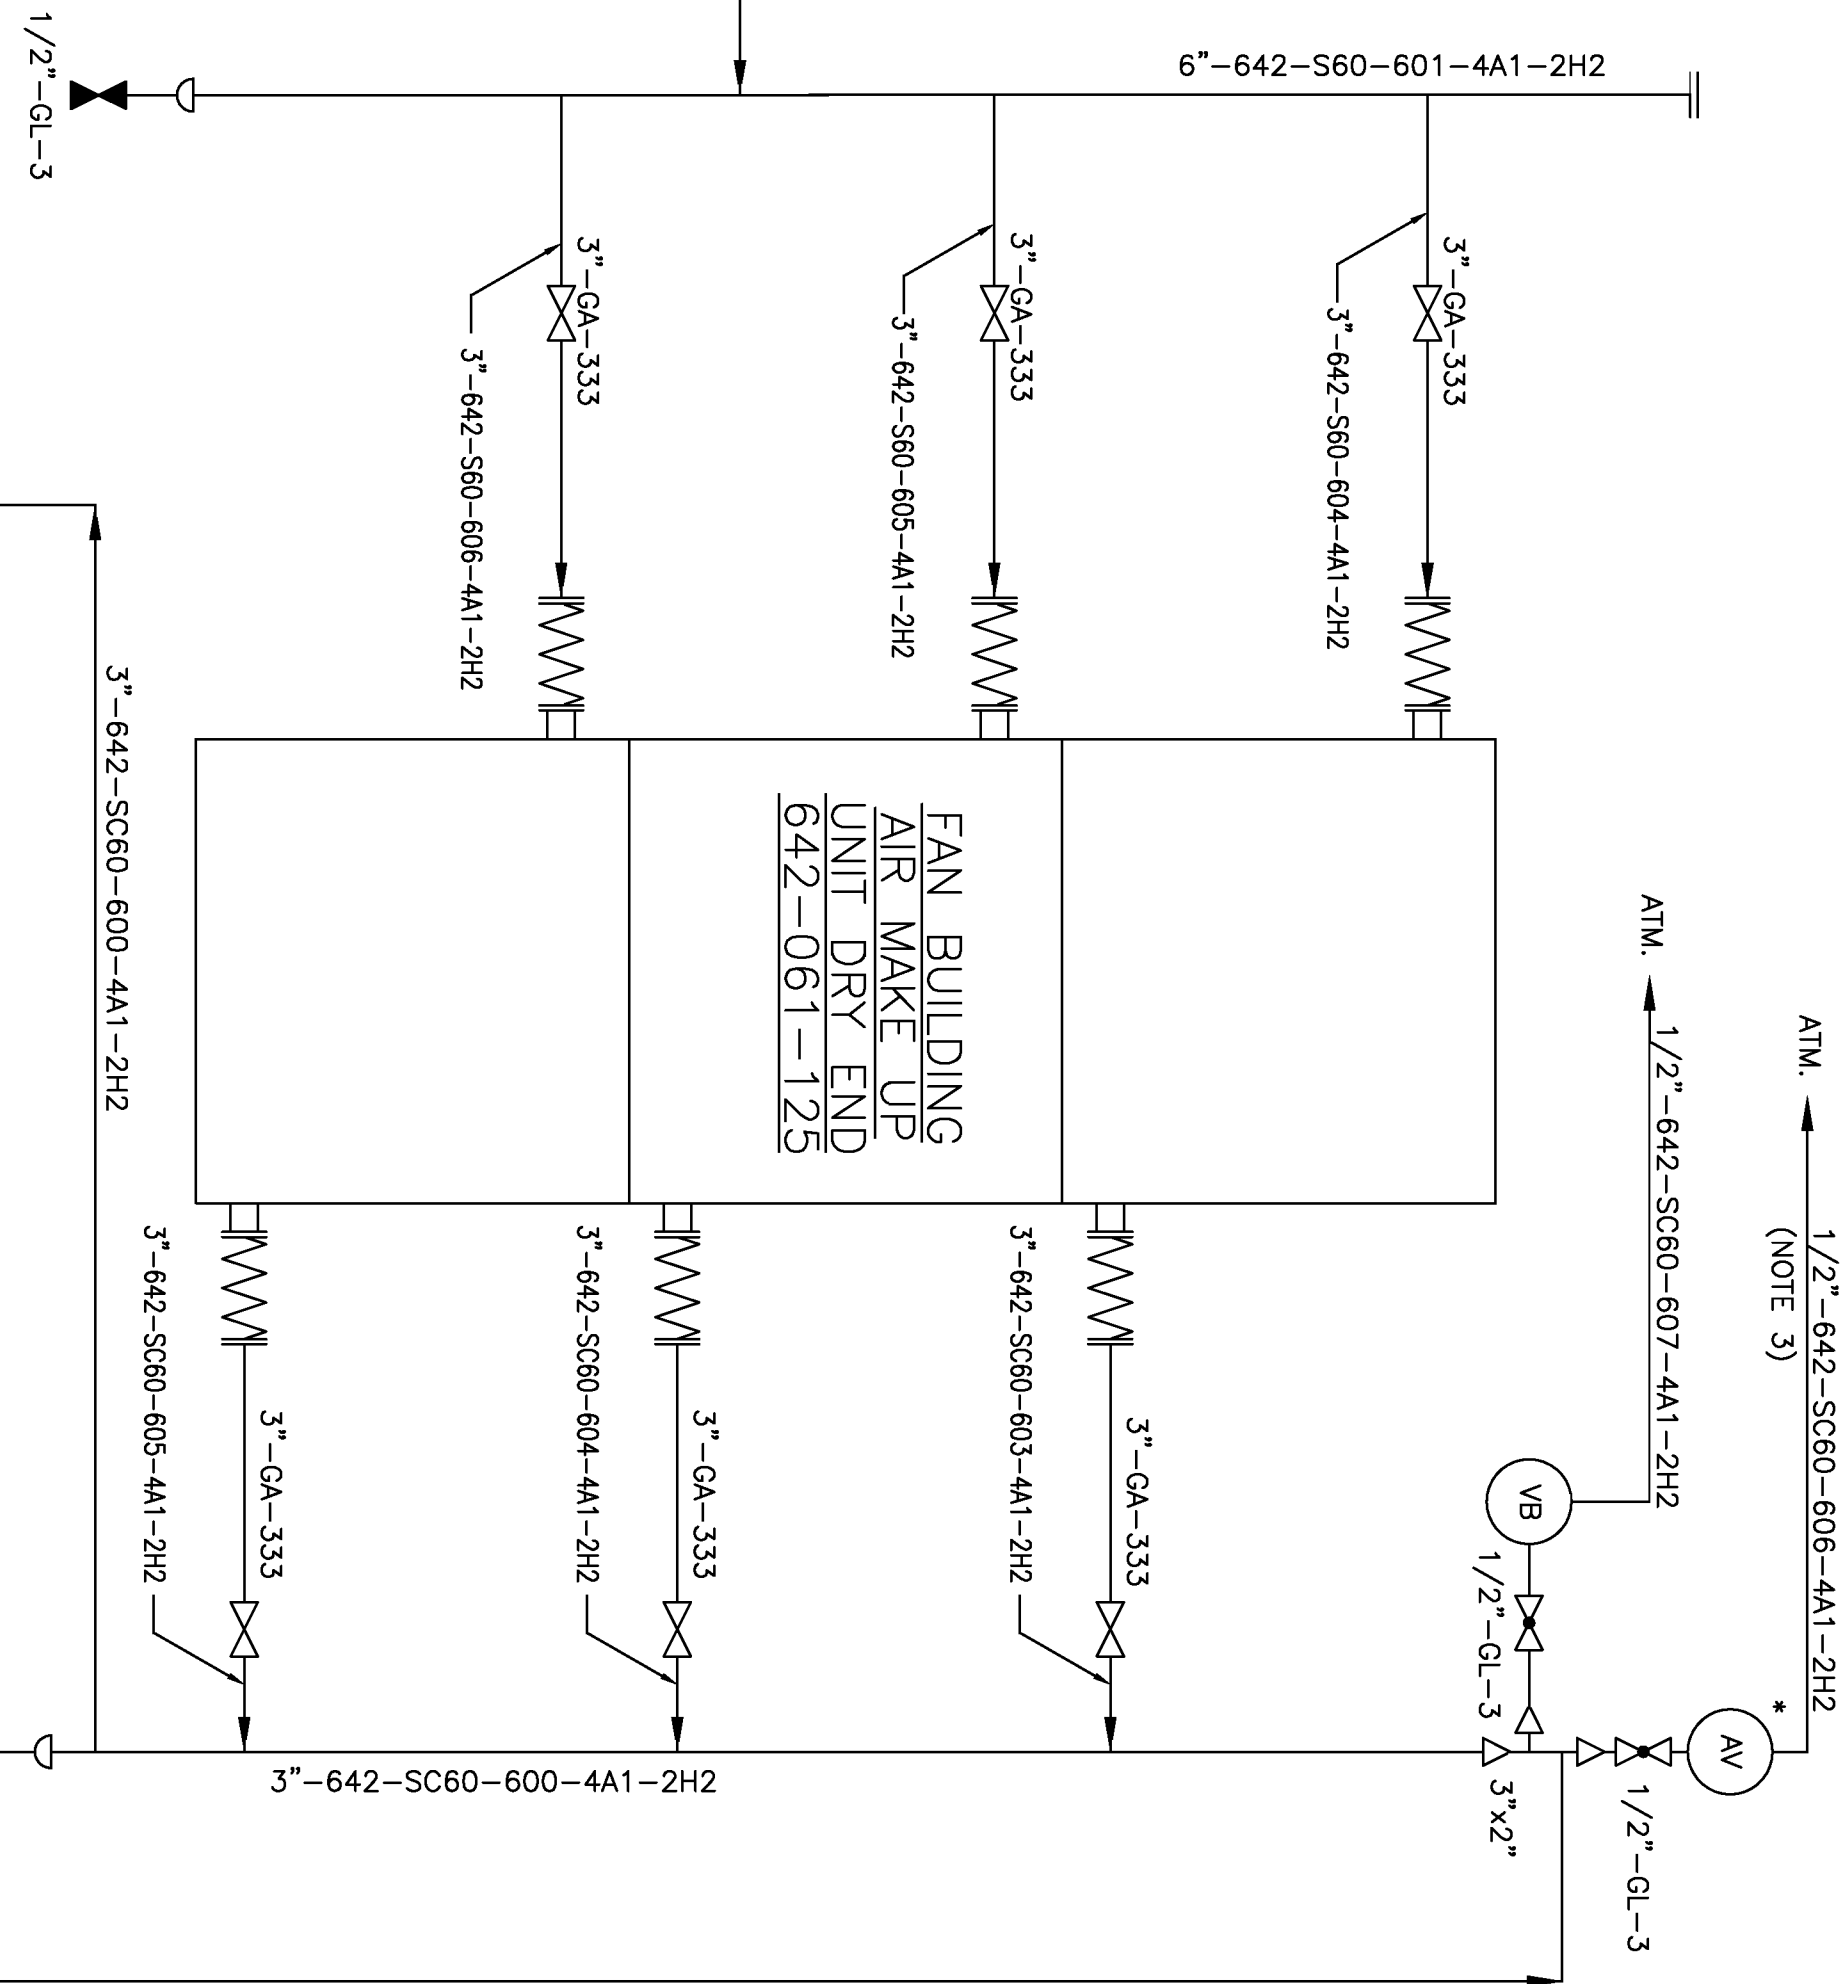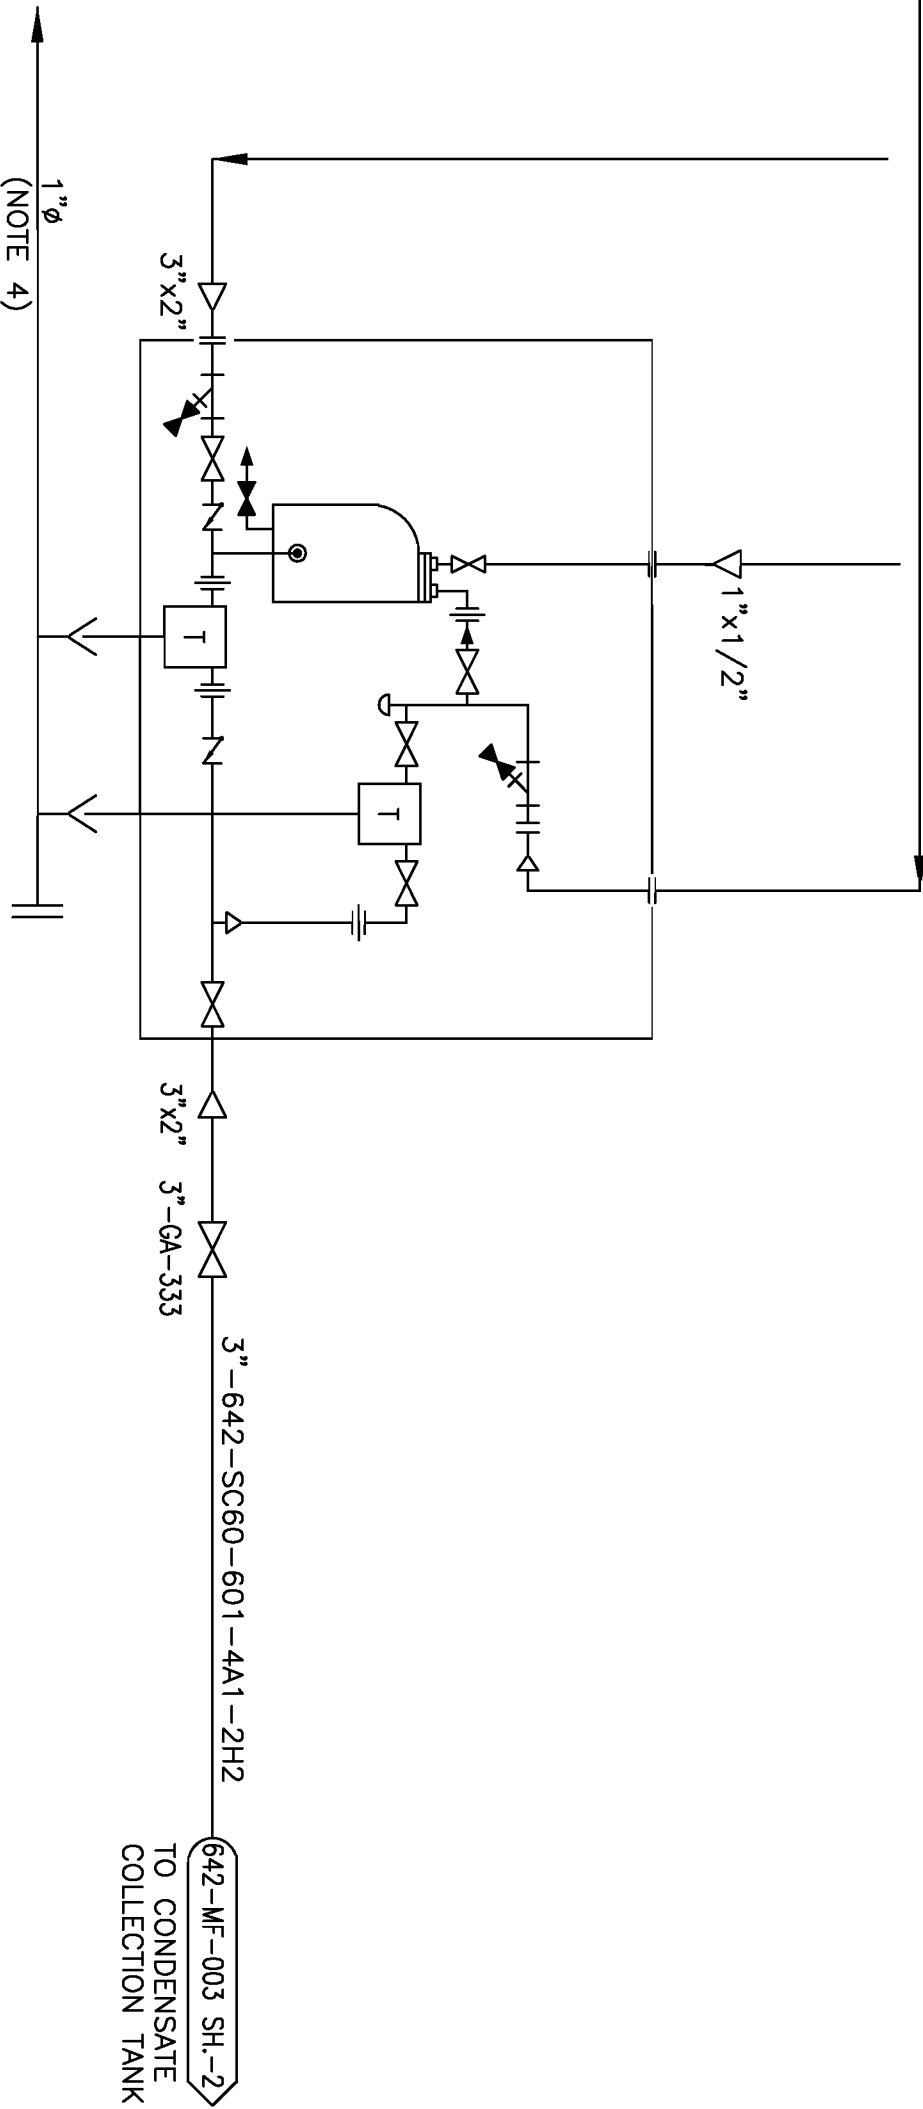

RELEASED FOR CONSTRUCTION
BY J.C. DATE 11/02/00

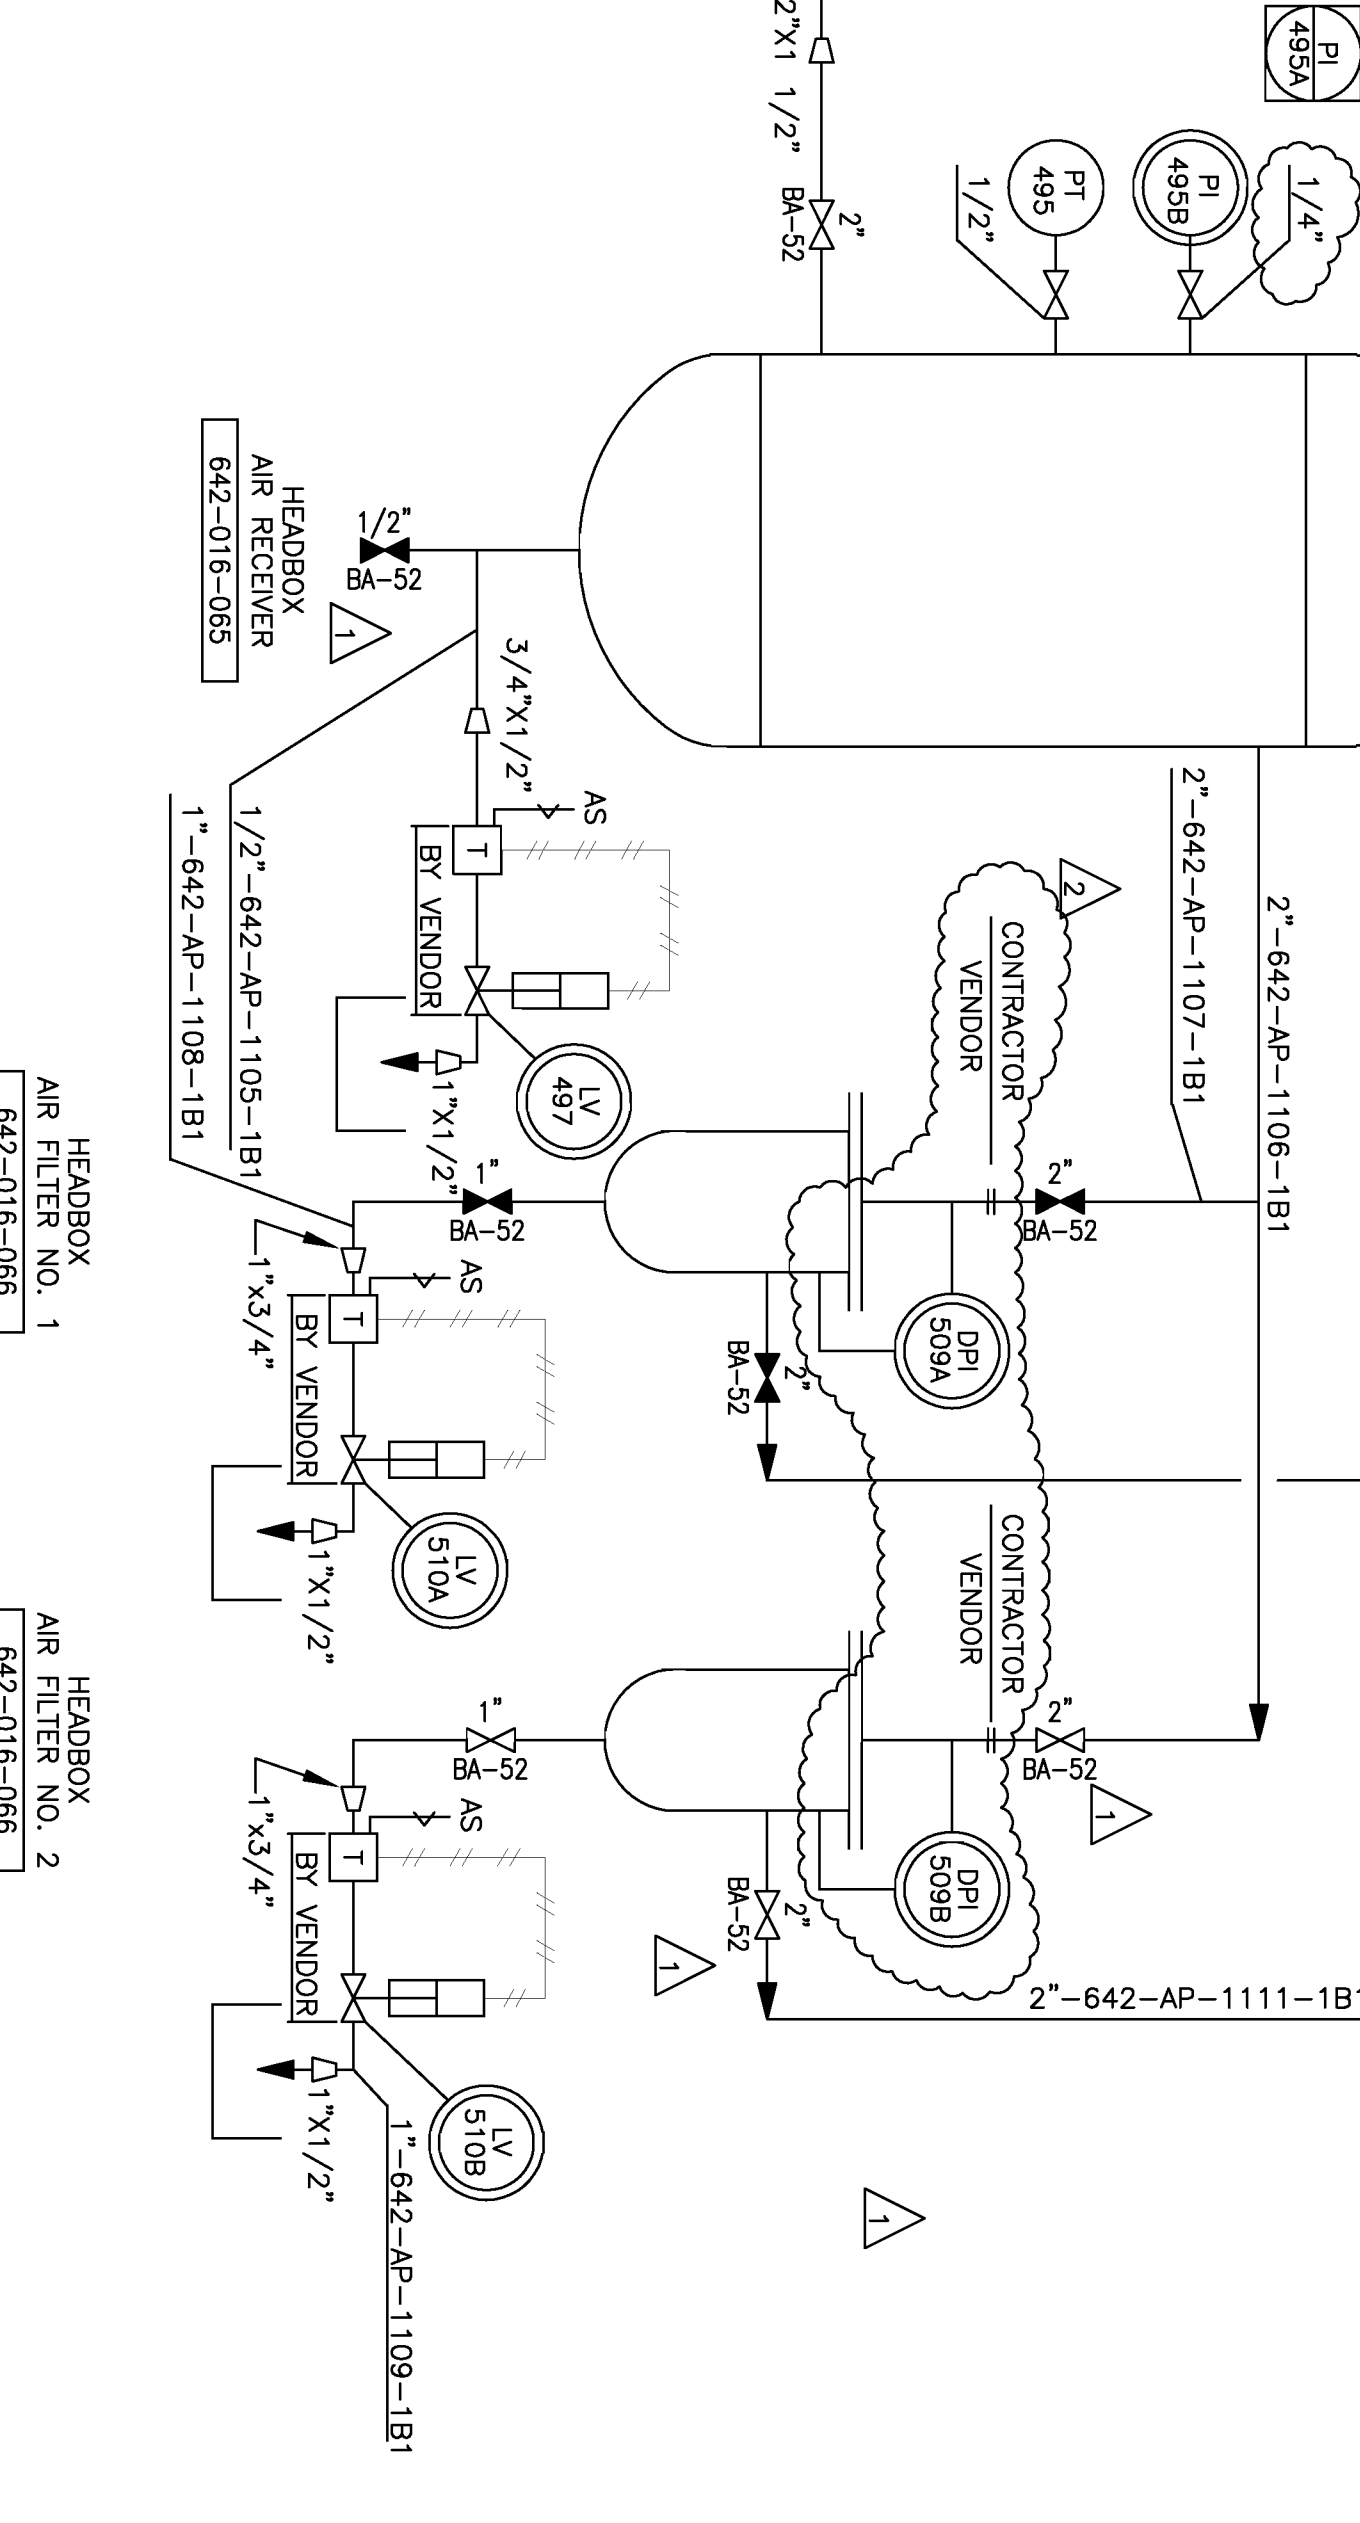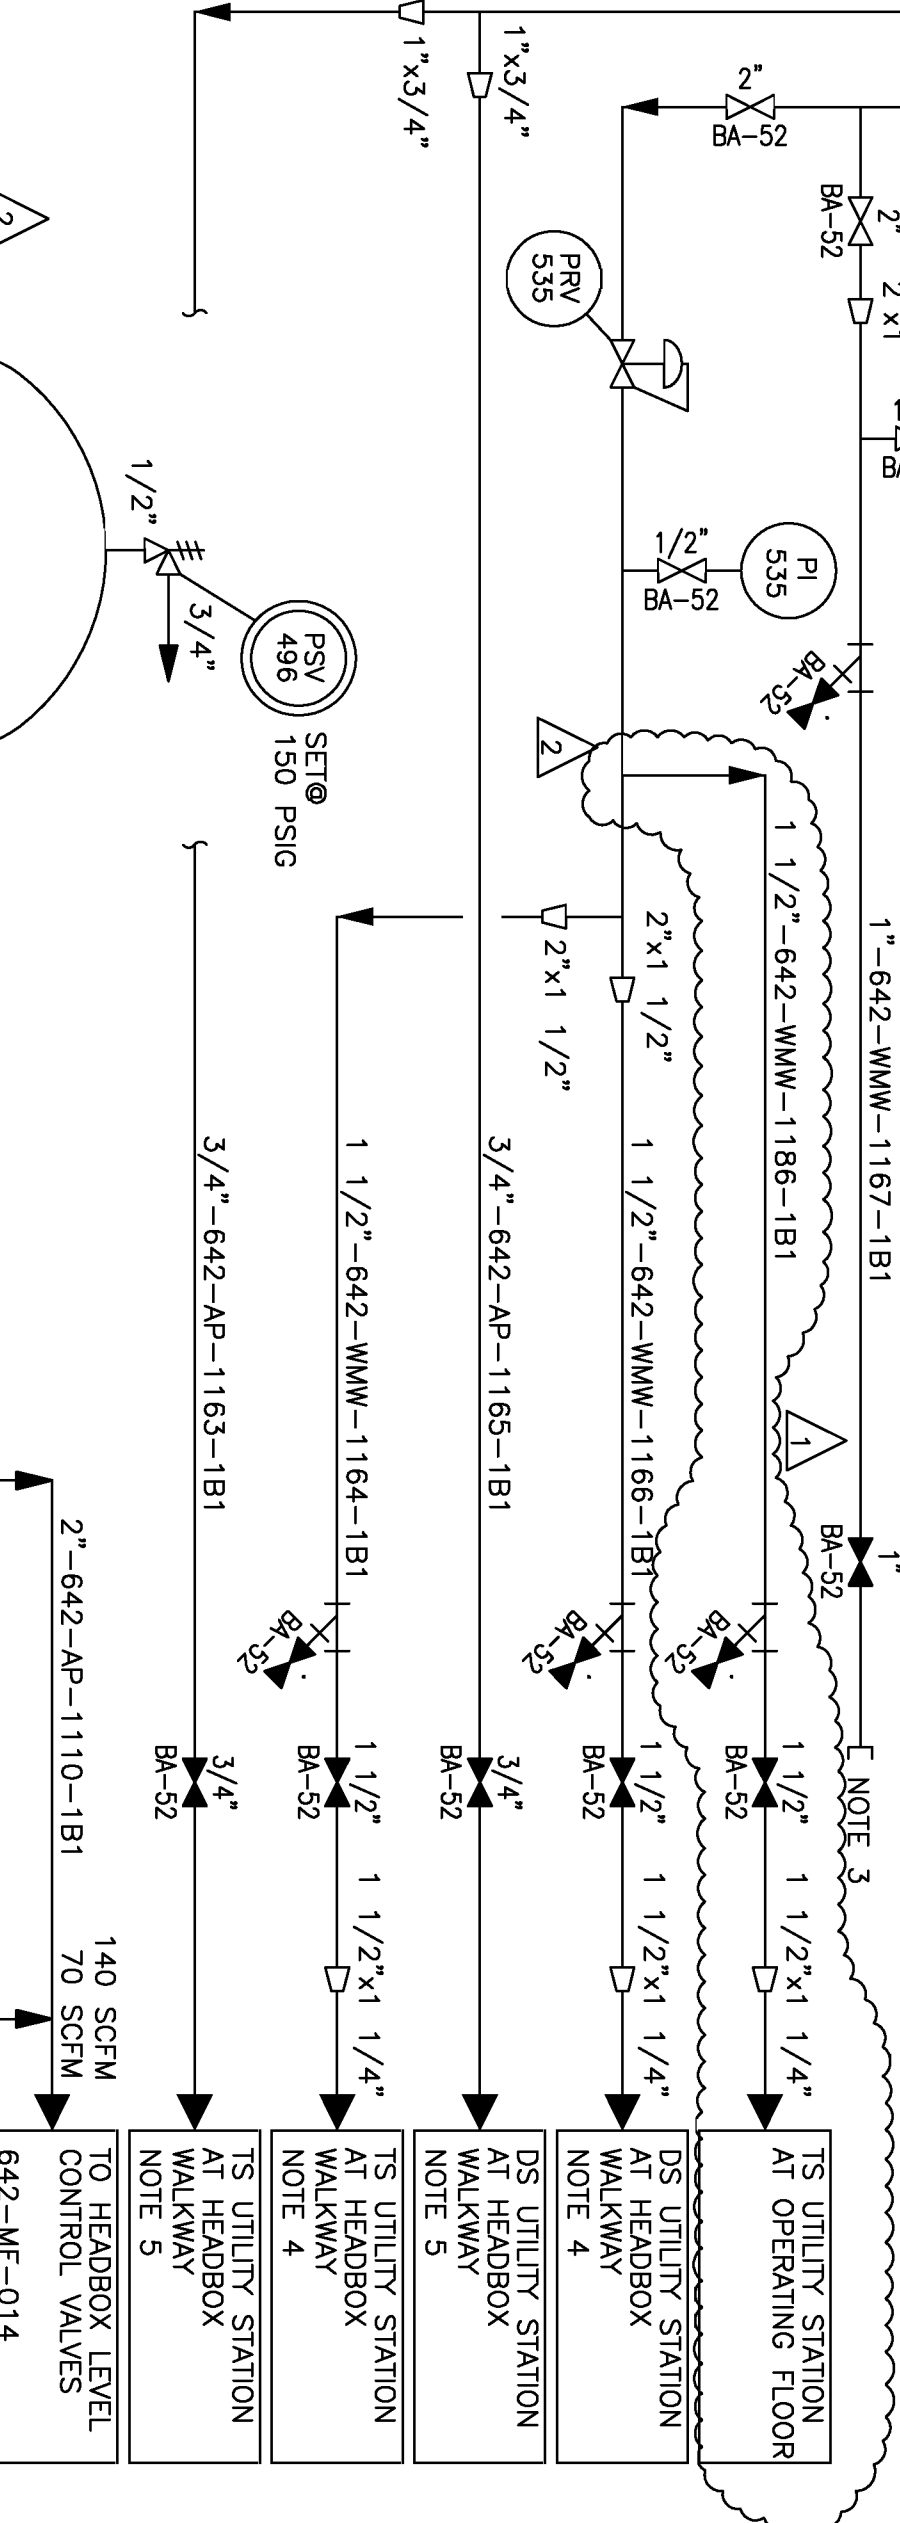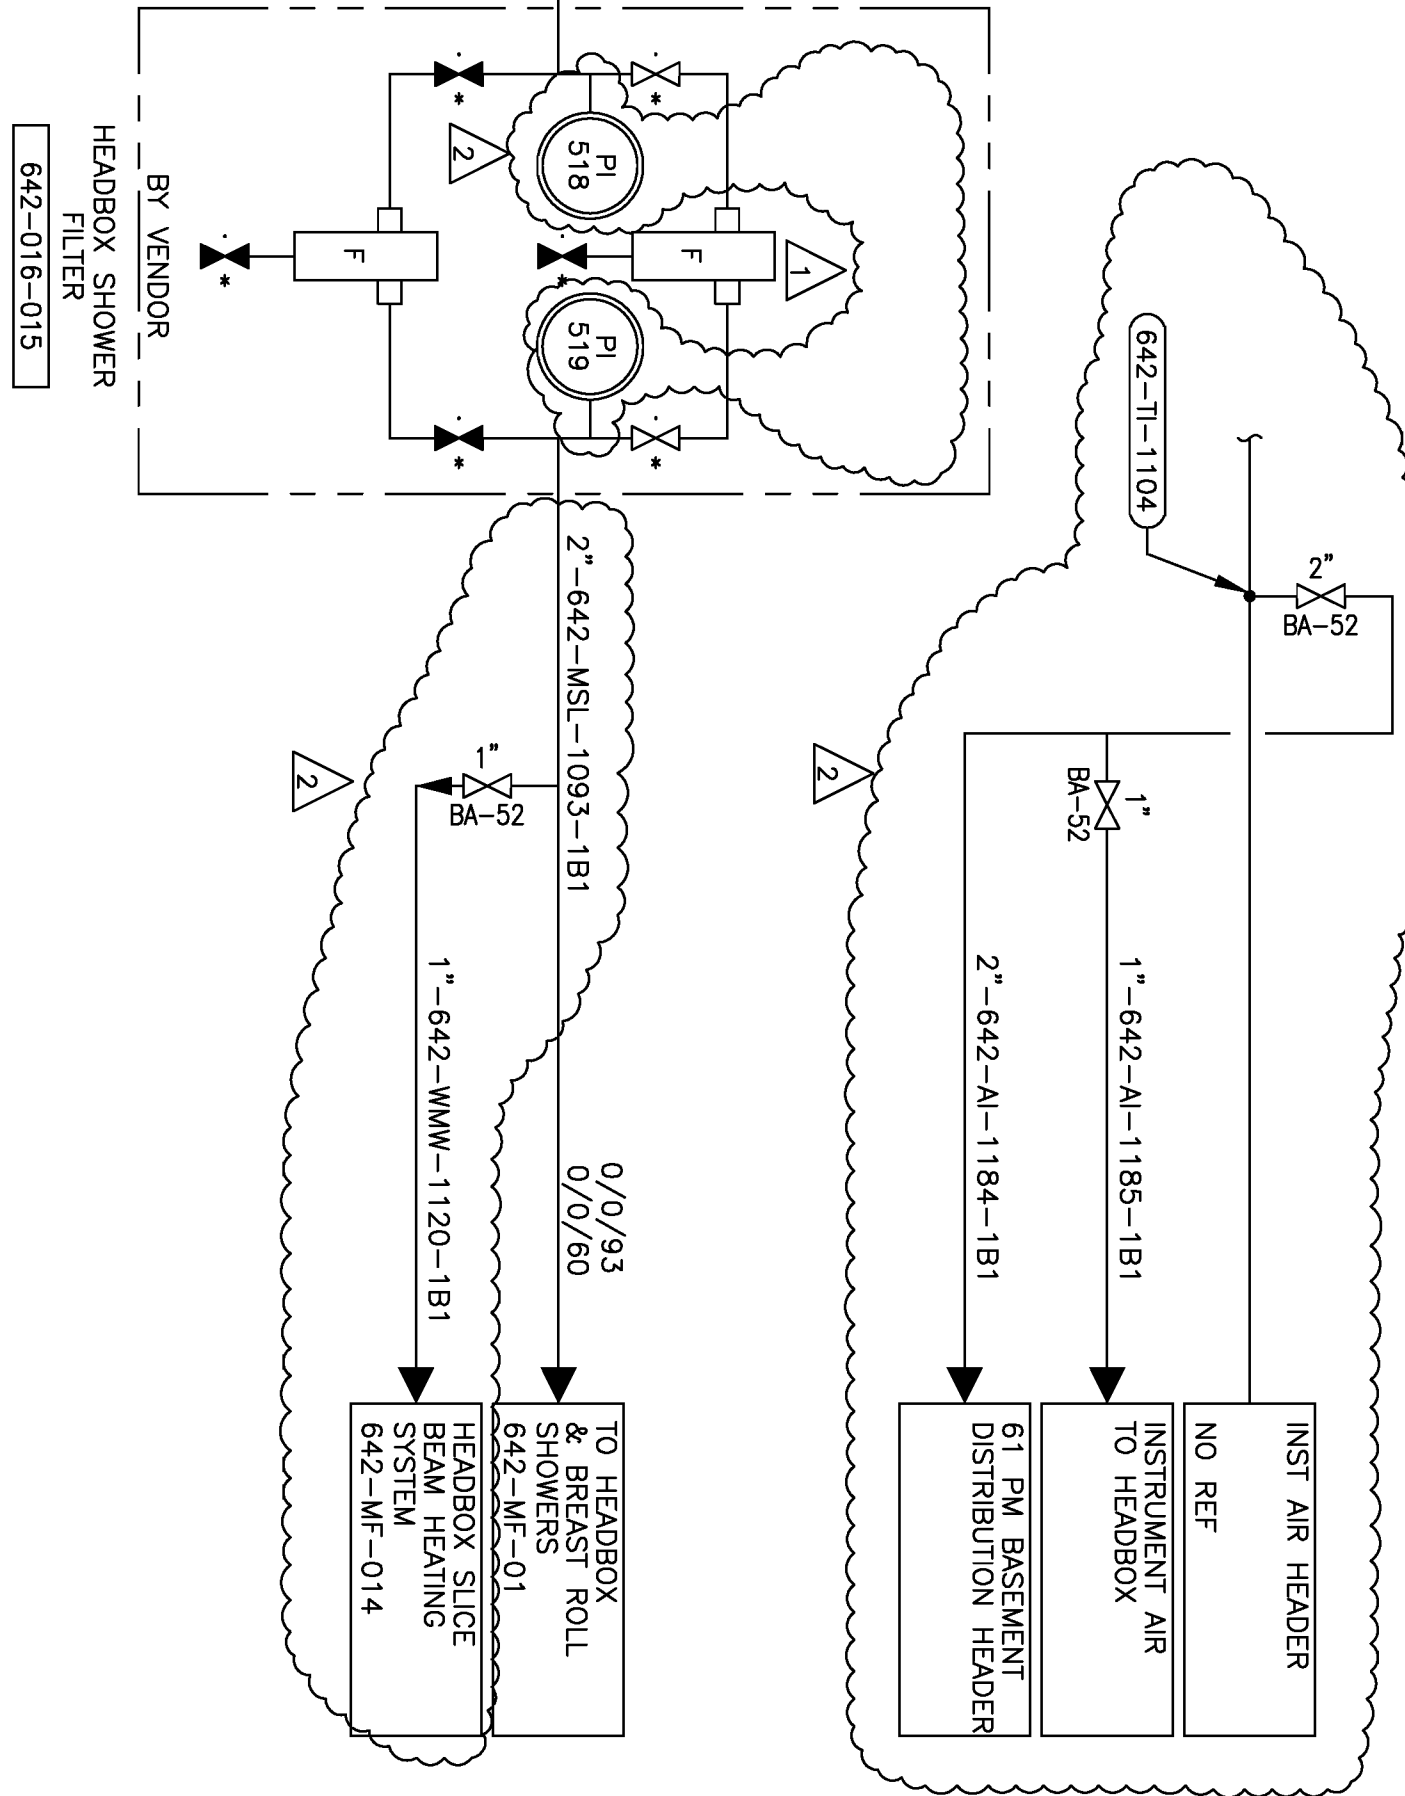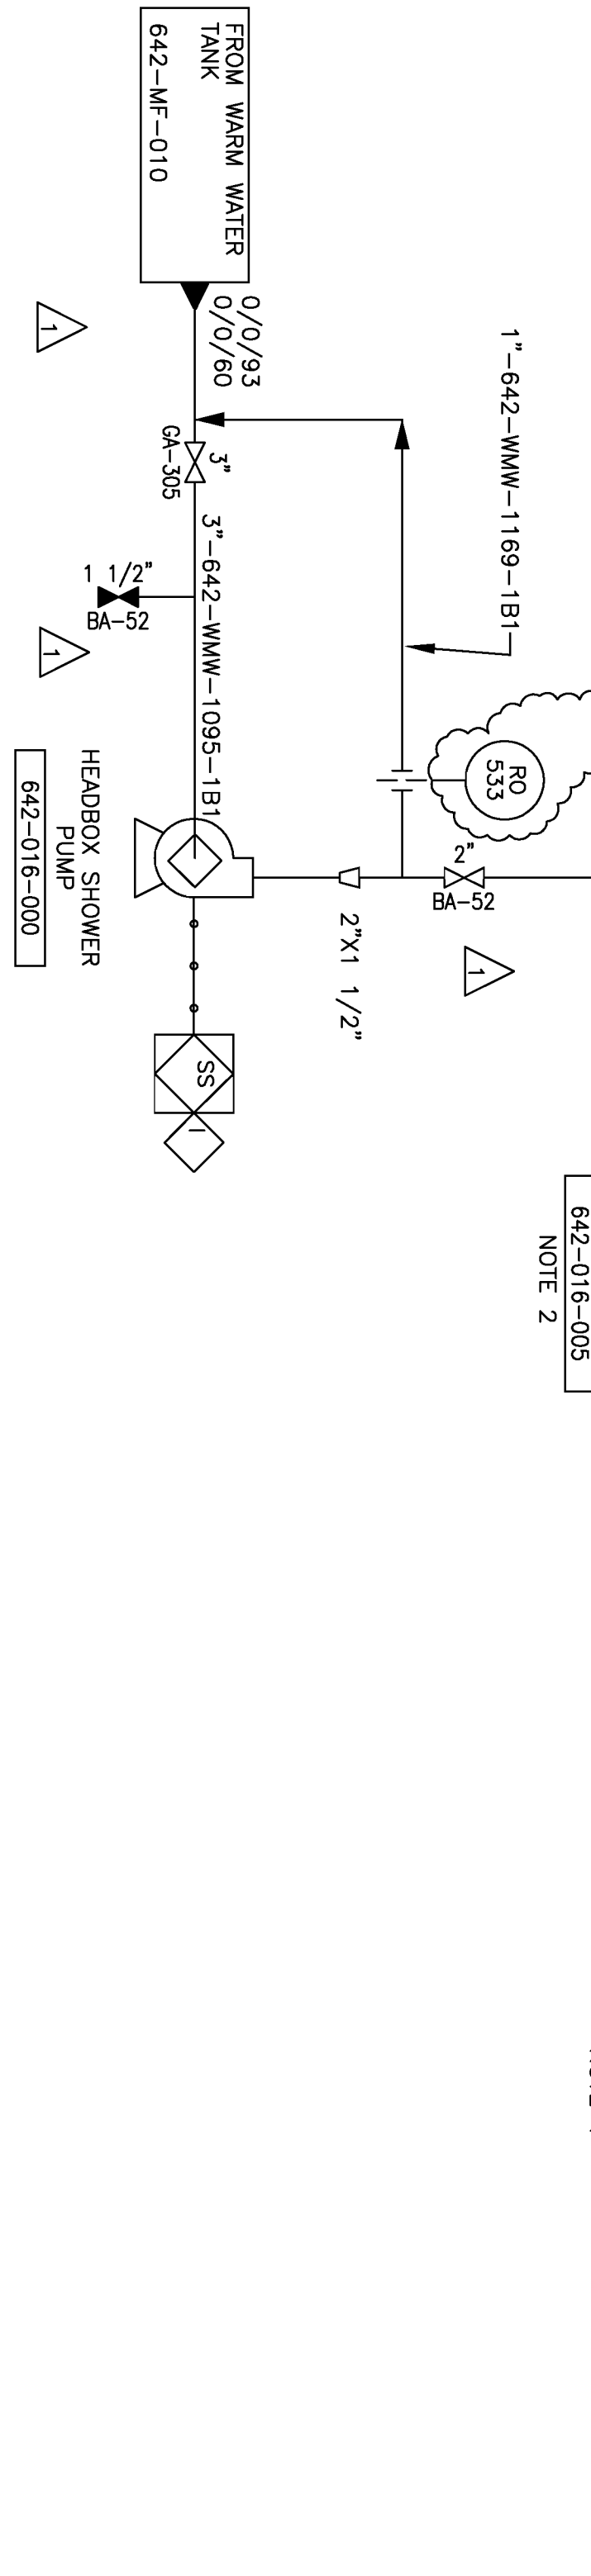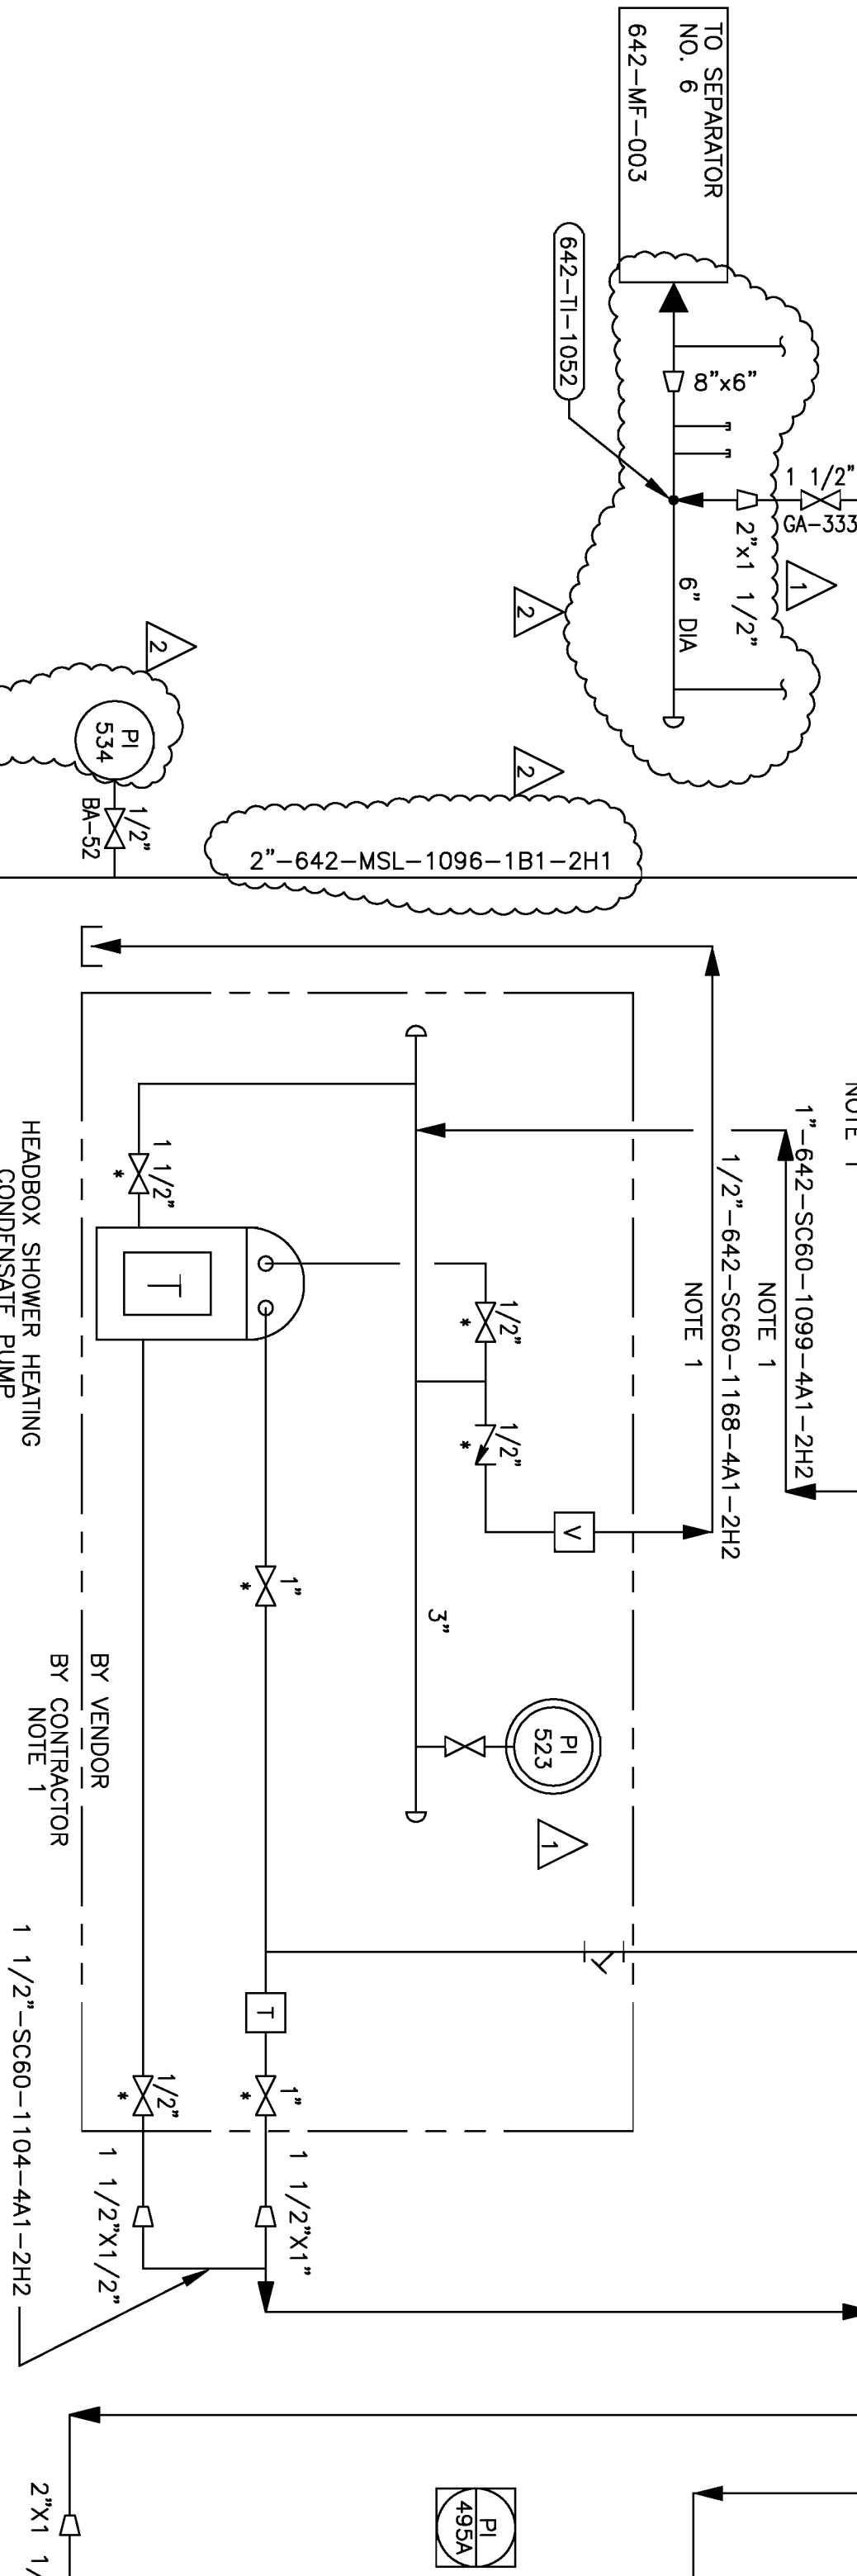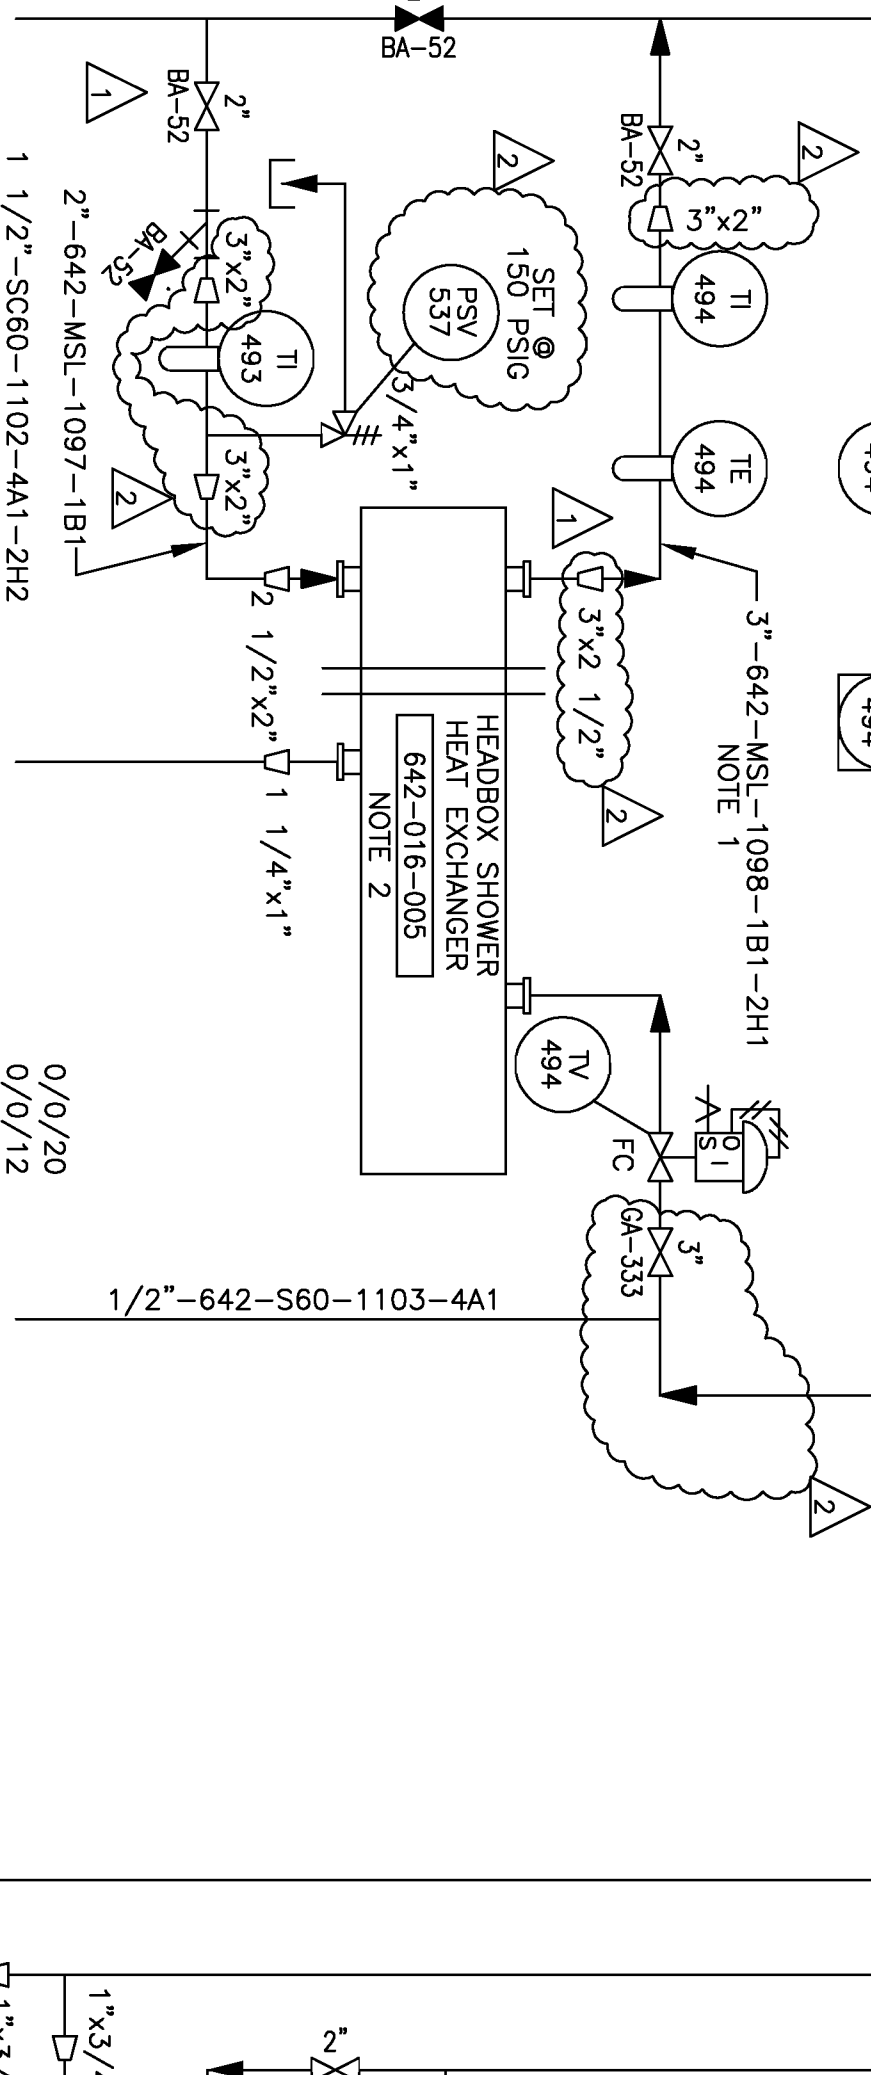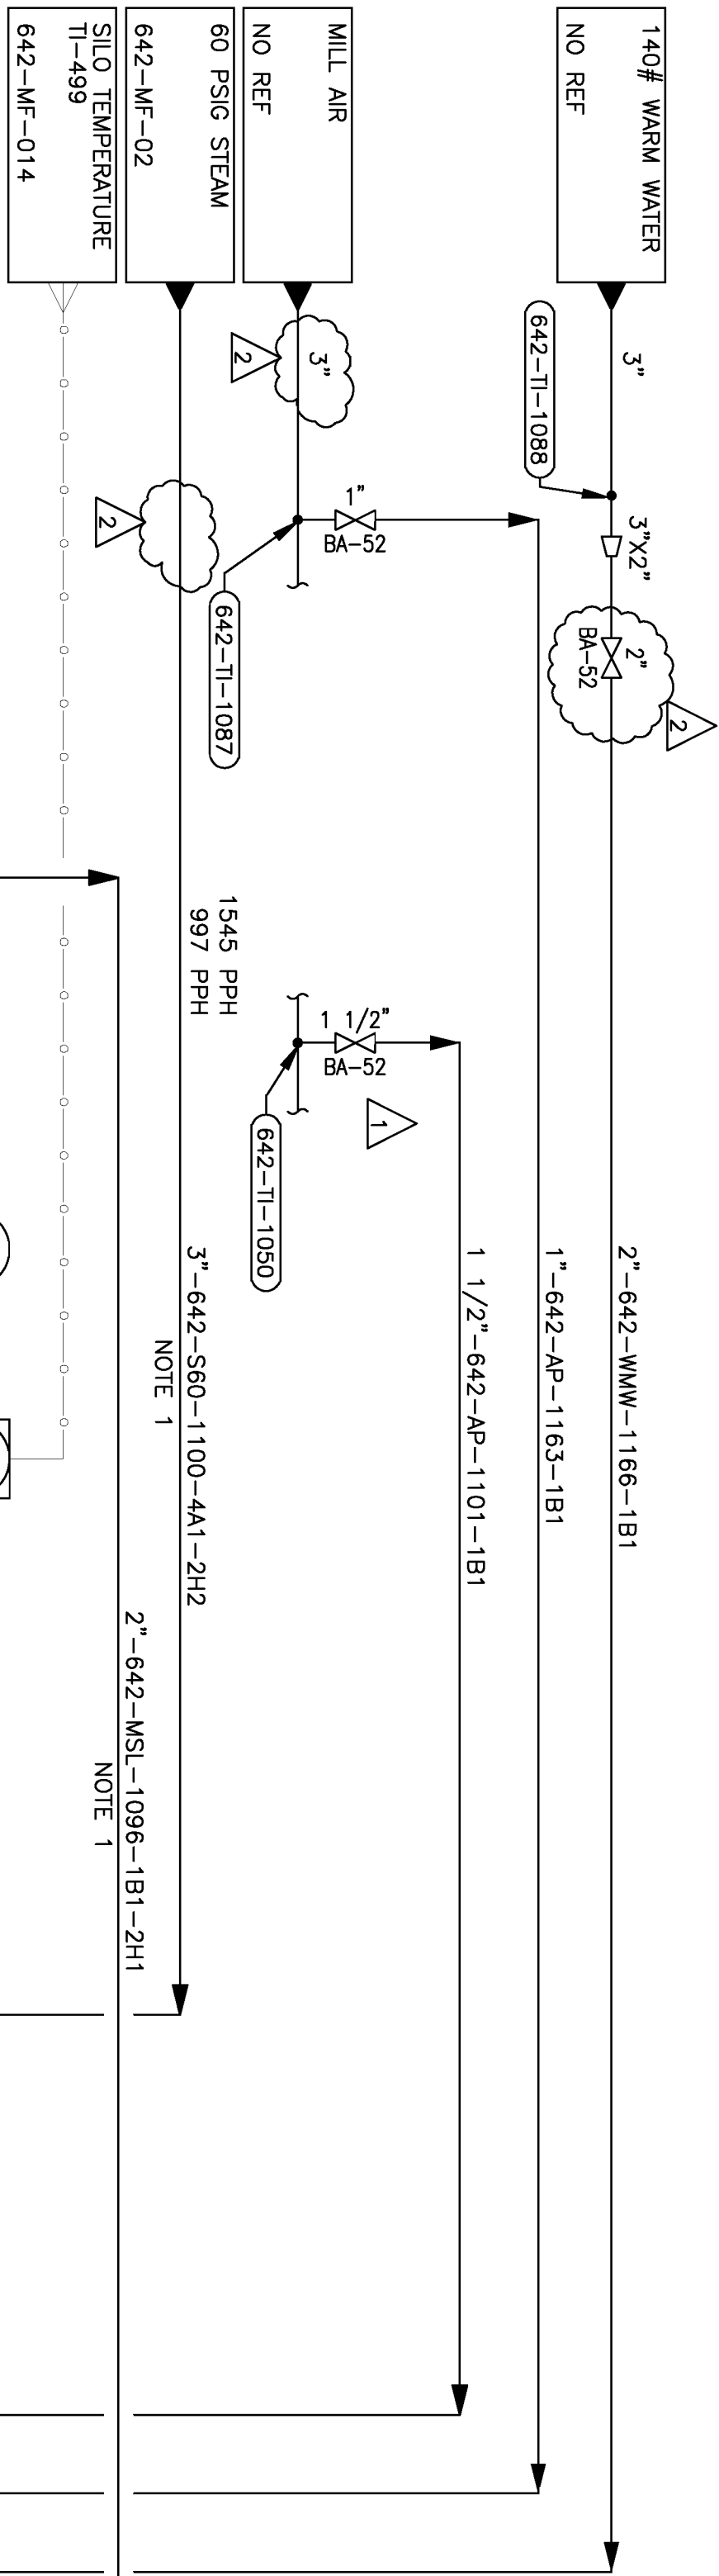

- NOTES:
1. INSULATE PER SPECIFICATION 100-D-081-012.
 2. INSULATE WITH REUSABLE INSULATION JACKET, 1 INCH THICK FIBERGLASS MAT, PTFE COATED FIBERGLASS INNER AND OUTER FABRIC.
 3. LOCKING CAMLOCK QUICK DISCONNECT WITH DUST PLUG, LOCATED ON TENDING SIDE AT OPERATING FLOOR LEVEL.
 4. HOSE RACK & 1-1/4" DIA HOSE, 50 FEET LONG, B.F. COUPLER TO PAPER MILL HOSE COUPLER. SEE DRAWING FOR UTILITY STATION LOCATIONS.
 5. HOSE REEL, AND 3/4" DIA HOSE, 50 FT LONG.
 6. HOSE REEL, 83000 OLS OR EQUAL.
 7. HOSE: RETELCRAFT 601026-50 OR EQUAL.
 8. BUMPER: RETELCRAFT 3-HS-2004-3.
 9. SEE DWG FOR UTILITY STATION LOCATIONS.
 10. ALL INSTRUMENT TAG NUMBERS ON THIS DRAWING ARE PREFIXED WITH AREA NUMBER 642, UNLESS OTHERWISE NOTED.

LEGEND:

○ VENDOR SUPPLIED INSTRUMENT

FLOW LEGEND:

BDTPD /ZDS/GPM MAXIMUM
BDTPD /ZDS/GPM DESIGN
BDTPD /ZDS/GPM MINIMUM

STAFF:	ROB BLOUNT	DATE: 11/29/06
INST:	JK	DATE: 11/29/06
MECH:	ROB HAYES	DATE: 11/29/06
DEPT. MGR.:	DFT	DATE: 11/29/06

REV	DATE	DESCRIPTION	BY	CHK	APP
1	11/29/06	GENERAL INVISION			
2	11/29/06	REV INSTR. & PIPING & VALVE CALLOUTS			
0	7/06	RELEASED FOR DESIGN			

BE&K	ENGINEERING CO.	BRUNNEN FOR ALBAMA
5002047		

Domtar


COMMUNICATION PAPERS DIVISION
ASHDOWN MILL

NO. 61 PAPER MACHINE
PROCESS & INSTRUMENTATION
HEADBOX UTILS & SHWR SYS

AR NO.	SCALE	DATE	PROJECT NO.	DRAWING NO.	REV
NONE	NONE				
DRAWN:					
CHECKED:					
APPROVED:					
642-WF-013					2
SHEET 1 OF 1					


NOTES:

1. ALL INSTRUMENT TAG NUMBERS ON THIS DRAWING ARE
PREFIXED WITH AREA NUMBER 642, UNLESS OTHERWISE
NOTED.

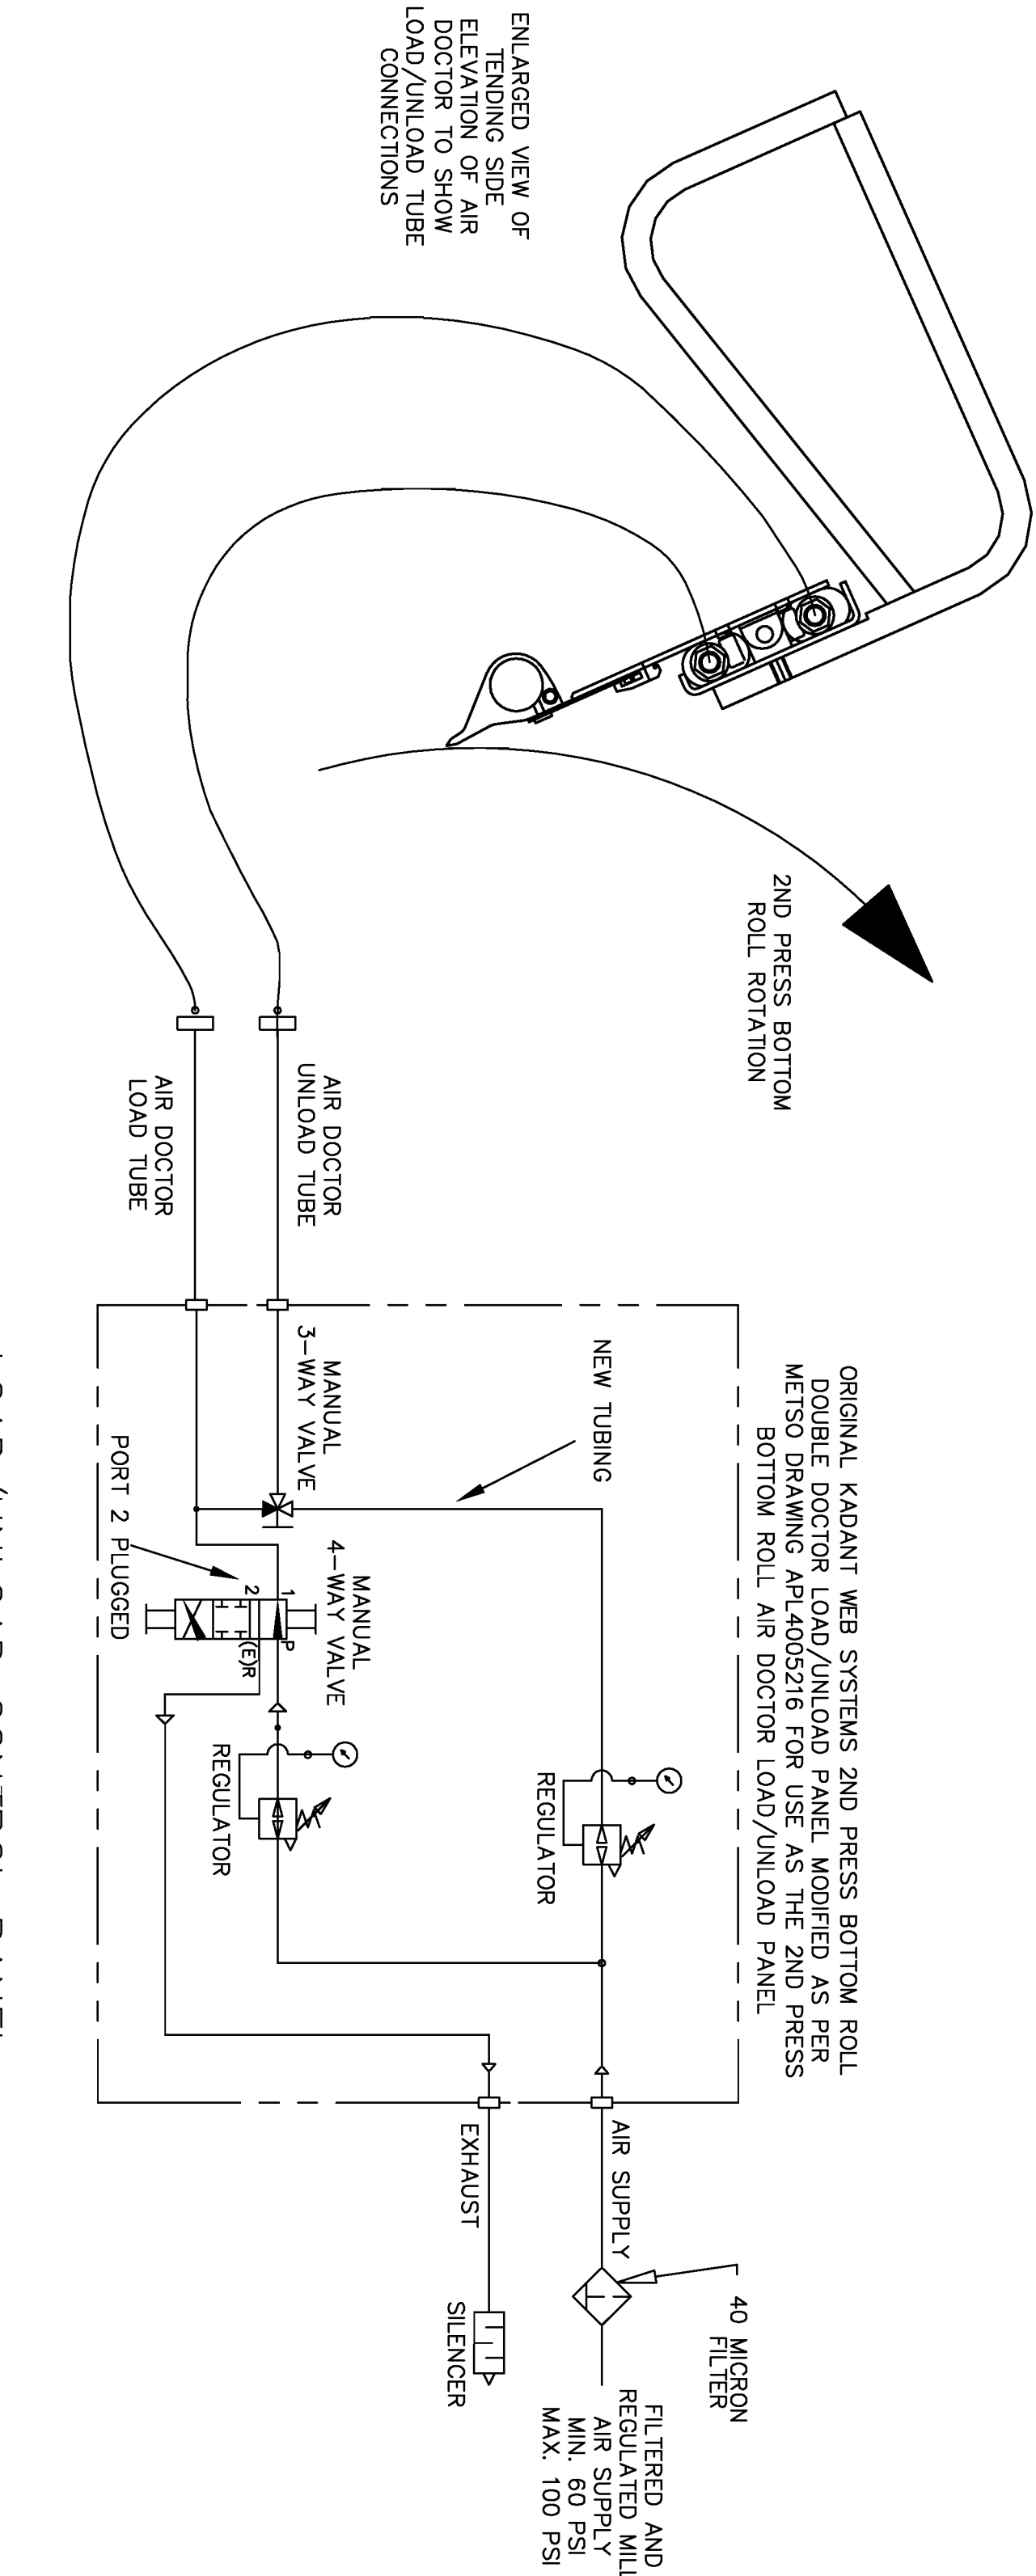

DRIVE SIDE ELEVATION
2ND PRESS

TENDING SIDE ELEVATION
2ND PRESS

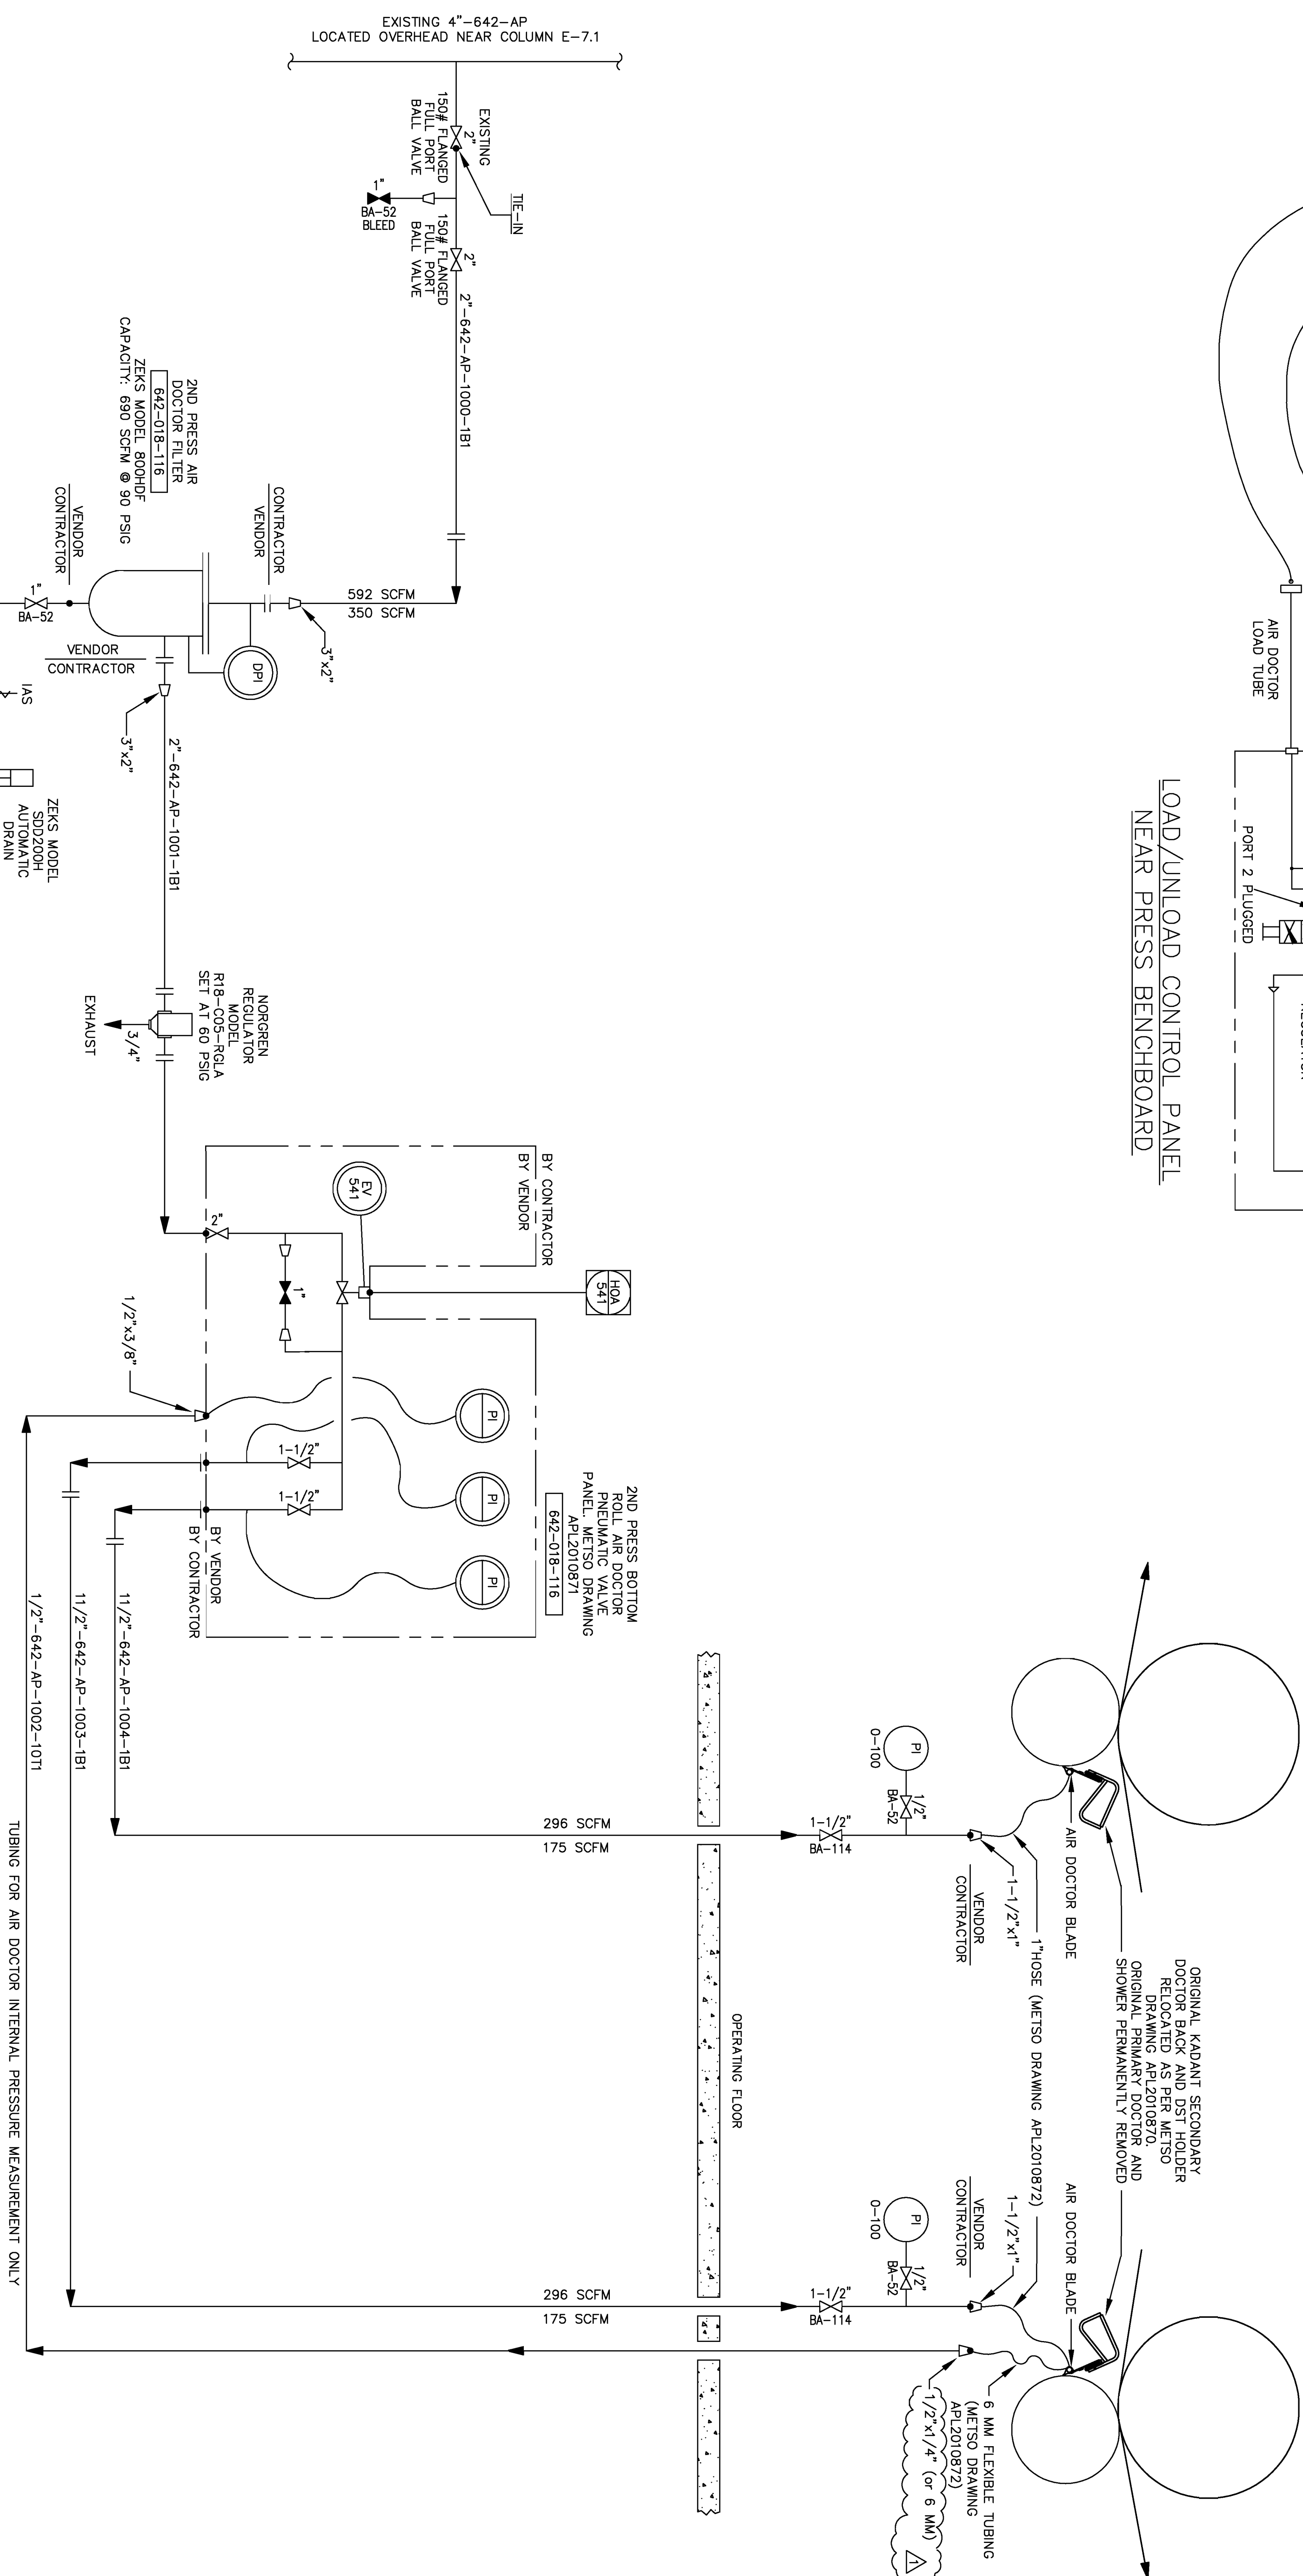

1	4/7/09	AS BUILT	DWG		
0	2/3/09	ISSUED FOR CONSTRUCTION	DWG	DWG	
REV	DATE	DESCRIPTION	BY	CHKD	APP'D

Domtar 

COMMUNICATION PAPERS DIVISION
ASHDOWN MILL

NO. 61 PAPER MACHINE
PROCESS & INSTRUMENTATION DIAGRAM
2ND PRESS BOTTOM ROLL AIR DOCTOR

AR NO. ASHC0984	PROJECT NO.	
SCALE: NONE	DRAWING NO.	REV
DRAWN: DLM	1/15/09	
CHECKED:		
APPROVED:		
APPROVED:		