


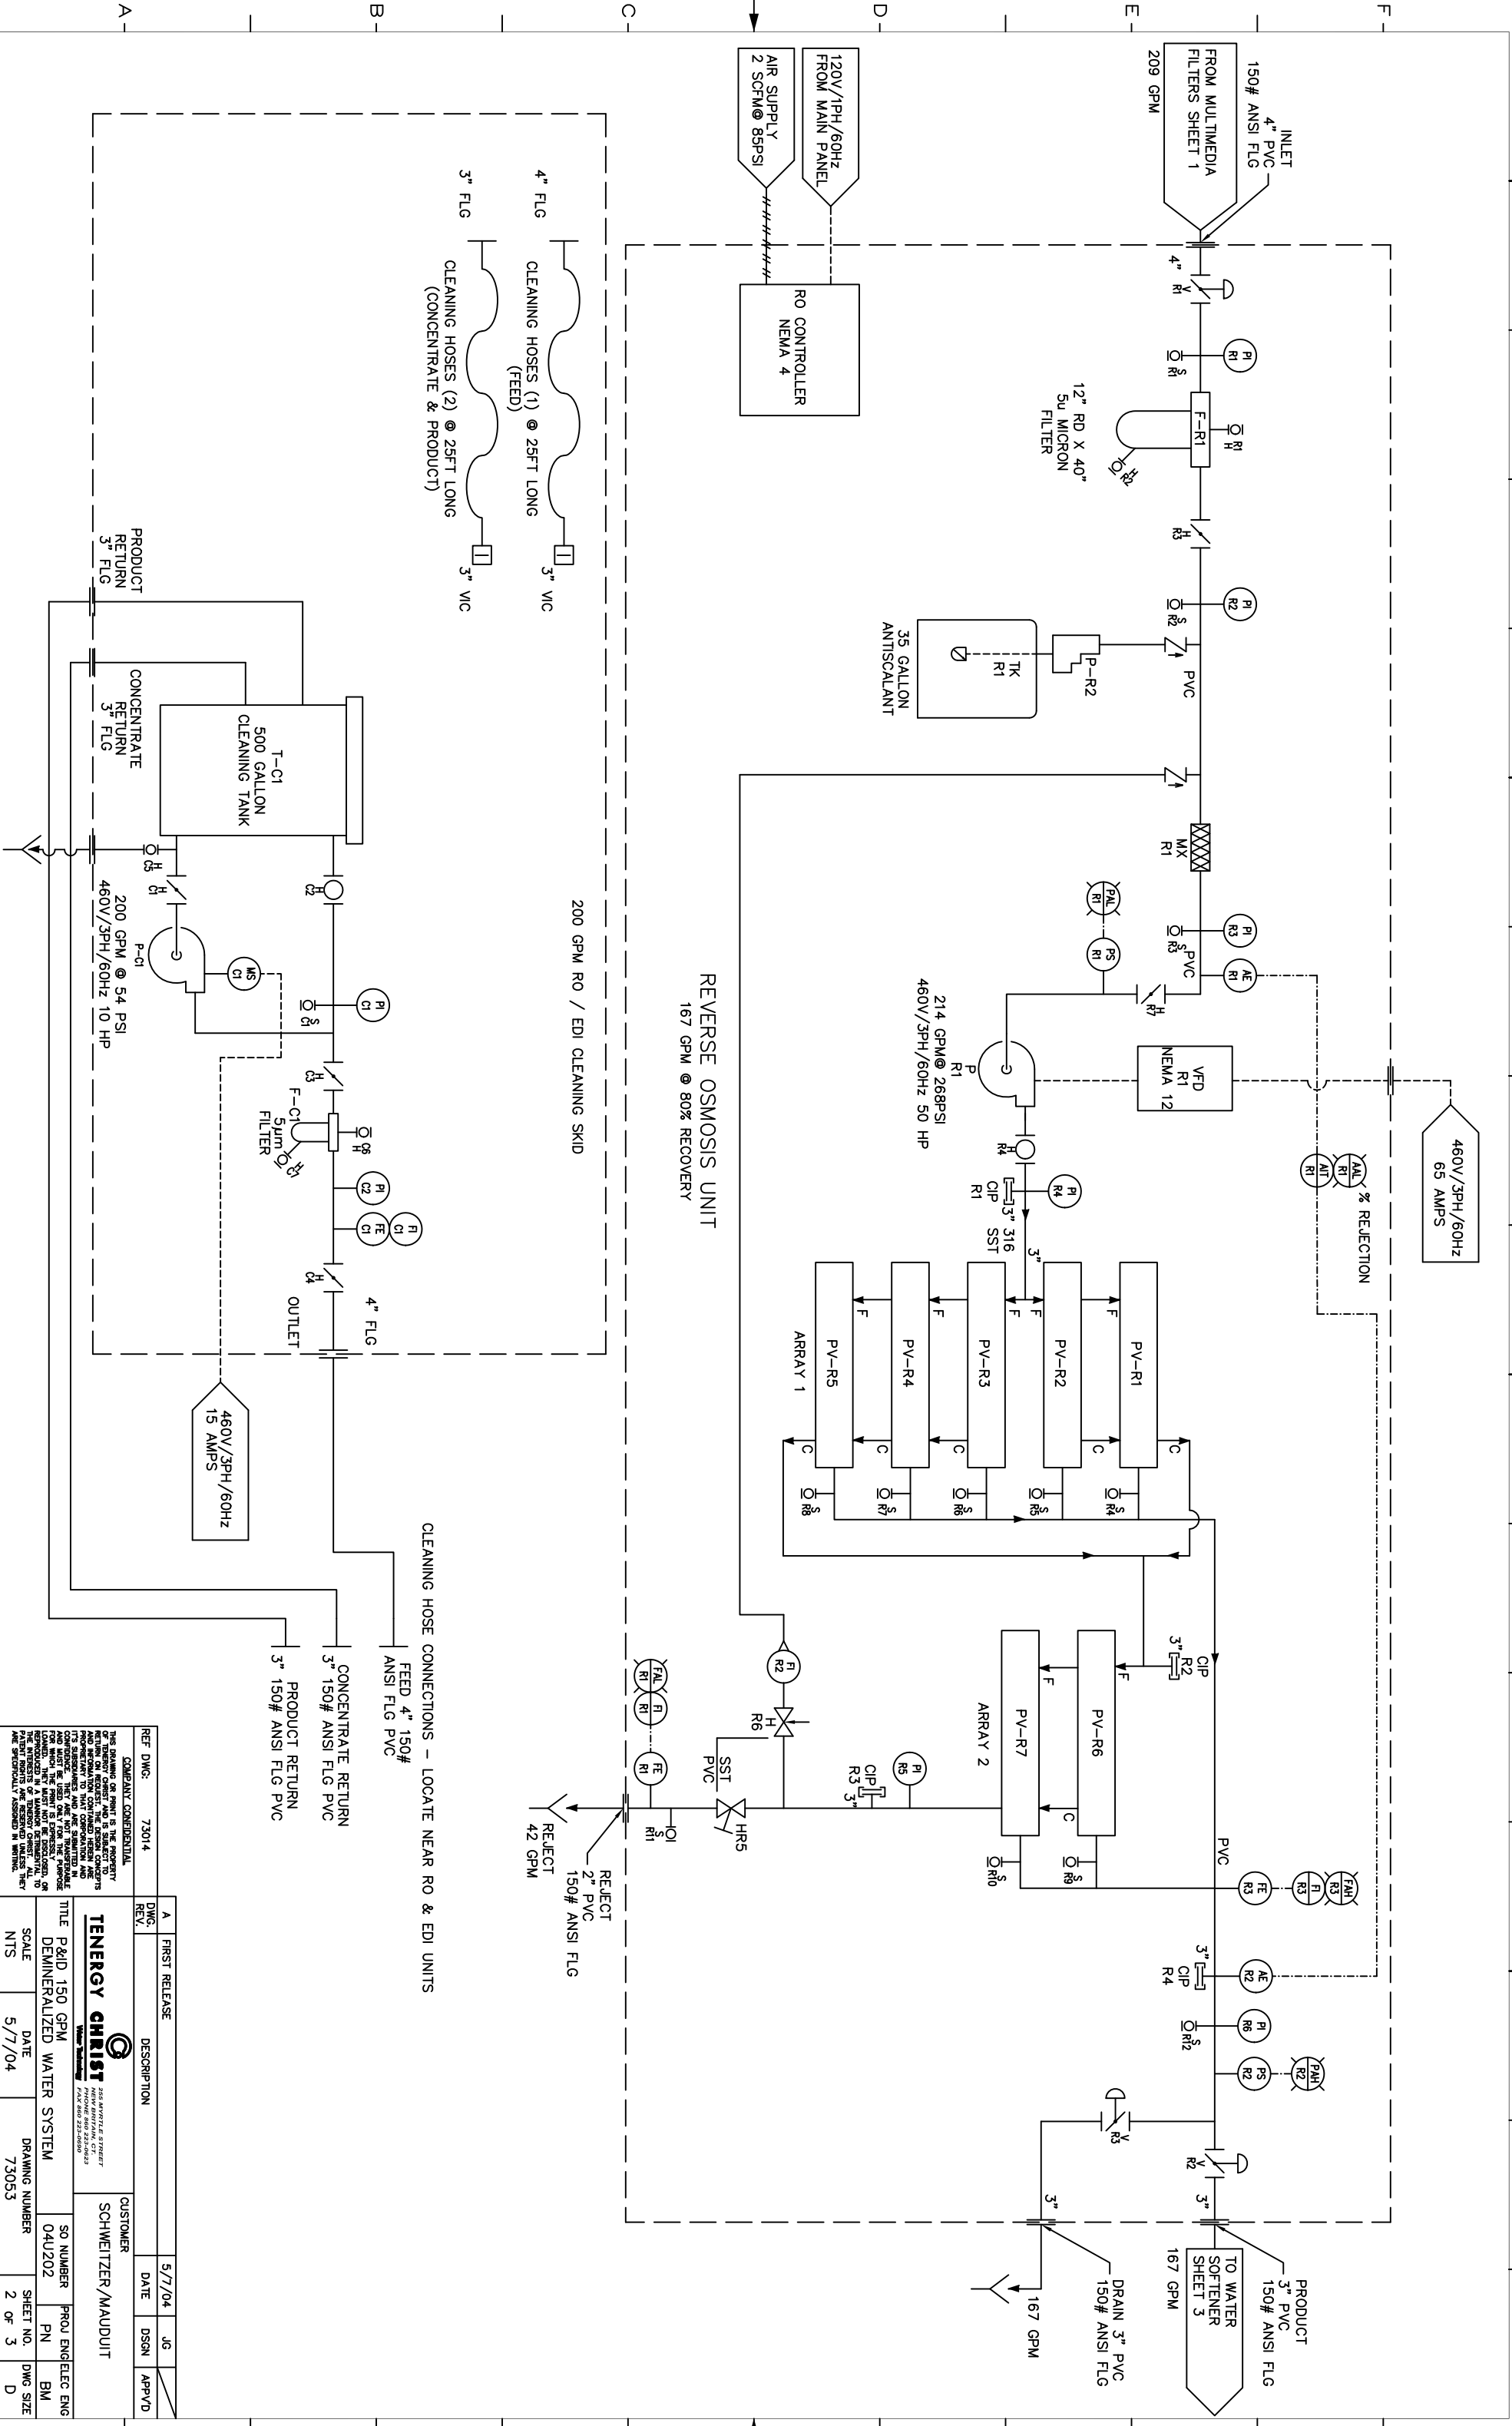

REF DWG:		73014		A		FIRST RELEASE		5/7/04		JG		APVD	
COMPANY CONFIDENTIAL				DWG. REV.		DESCRIPTION		DATE		DSGN			
THIS DRAWING OR PRINT IS THE PROPERTY OF TENERGY CHRIST AND IS LOANED TO YOU FOR YOUR INFORMATION ONLY. IT IS NOT TO BE REPRODUCED OR COPIED IN ANY MANNER WITHOUT THE WRITTEN PERMISSION OF TENERGY CHRIST. IT IS TO BE RETURNED TO TENERGY CHRIST WHEN NO LONGER NEEDED. IT IS NOT TO BE USED FOR ANY OTHER PURPOSE. THE PRINT IS EXPRESSLY FORWARDED TO YOU FOR YOUR INFORMATION ONLY. IT IS NOT TO BE REPRODUCED OR COPIED IN ANY MANNER WITHOUT THE WRITTEN PERMISSION OF TENERGY CHRIST. IT IS TO BE RETURNED TO TENERGY CHRIST WHEN NO LONGER NEEDED. IT IS NOT TO BE USED FOR ANY OTHER PURPOSE.													
TENERGY CHRIST						THE HAYES & BERNET WATER BROTLYN, CT 06232 TEL 860 293-2609		CUSTOMER		SCHWEITZER/MAUDUIT			
TITLE				P&ID 150 GPM		SO NUMBER		PROJ ENG		ELEC ENG			
DENIMERALIZED				WATER SYSTEM		04U202		PN		BM			
SCALE				DATE		DRAWING NUMBER		73053		SHEET NO.		DWG SIZE	
NTS				5/7/04		73053		2		OF 3		D	