

CLIENT:

PROJECT TITLE: USP 797 / USP 800 CLEANROOMS

DESIGN / BUILD CLEANROOM MANUFACTURER:

CLEAN AIR TECHNOLOGY, INC.

41105 CAPITAL, CANTON, MI 48187
PHONE: (734) 459-6320
FAX: (734) 459-9437
www.cleanairtechnology.com

PROJECT /JOB # 18-142

INDEX TO DRAWINGS

PROCESS

- CR-001 AREA OF CLEANROOM CONSTRUCTION WITHIN EXISTING BUILDING
- CR-100 CLEANROOM FLOOR PLAN
- CR-101 CLEANROOM REFLECTED CEILING PLAN
- CR-110 TYPICAL CLEANROOM CONSTRUCTION DETAILS

SECTIONS AND ELEVATIONS

- CR-200 CLEANROOM SECTION VIEWS
- CR-201 PARTIAL ELEVATION, SOUTH EXTERIOR OF BUILDING

MECHANICAL

- CR-300 CLEANROOM MECHANICAL EQUIPMENT AND DUCTWORK ON TOP DECK
- CR-301 DUCTWORK BELOW DECK IN PLENUM
- CR-302 CHILLED WATER PIPING AND CHILLER AREA
- CR-303 HUMIDIFIER AND DRAIN PIPING
- CR-304 800 AREA EXHAUST SYSTEM
- CR-310 MECHANICAL EQUIPMENT SCHEDULES AND TYPICAL MECHANICAL DETAILS

ELECTRICAL

- CR-400 ELECTRICAL FLOOR PLAN
- CR-401 ELECTRICAL LIGHTING
- CR-402 DOOR INTERLOCKS
- CR-403 MECHANICAL EQUIPMENT ELECTRICAL

STRUCTURAL

- CR-900 WALL FRAME NUMBERING PLAN
- CR-901 DECK FRAME NUMBERING PLAN
- CR-902 SEISMIC BRACING PLAN

CONTROLS


- C-1 CONTROL DEVICE LAYOUT, HOLES IN PANEL FACE FOR DEVICES, USP 800 AREAS
- C-2 CONTROL WIRING SCHEMATIC, USP 800 AREAS
- C-3 CONTROL DEVICE LAYOUT, HOLES IN PANEL FACE FOR DEVICES, USP 797 AREAS
- C-4 CONTROL WIRING SCHEMATIC, USP 797 AREAS

FIRE PROTECTION

(FOR REFERENCE ONLY, DRAWING BY NORTHWEST FIRE PROTECTION, INC.)

CLEAN AIR ROOMS

CLEAN AIR TECHNOLOGY, INC.
Decades of Experience Building America's Cleanrooms
41105 Capital, Canton, MI 48187 Tel 734-459-6320 Fax 734-459-9437
www.cleanairtechnology.com

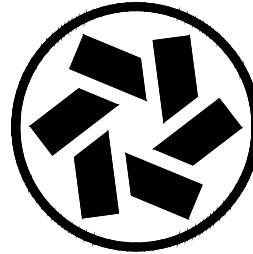

THIS DRAWING CONTAINS DESIGNS AND OTHER INFORMATION WHICH ARE THE PROPERTY OF CLEAN AIR TECHNOLOGY, INC. THIS DRAWING MAY NOT BE REPRODUCED, COPIED, OR IN PART, BE LOANED, RENTED, REPRODUCED, OR OTHERWISE USED WITHOUT THE WRITTEN PERMISSION OF CLEAN AIR TECHNOLOGY, INC. ANY COPIES OF THIS DRAWING WHICH ARE NOT RETURNED TO CLEAN AIR TECHNOLOGY, INC. UNDER THE TERMS OF A CONTRACT OR OTHERWISE, ARE TO BE RETURNED TO CLEAN AIR TECHNOLOGY, INC. ON REQUEST. CLEAN AIR TECHNOLOGY, INC. WILL ELECT TO TAKE ALL NECESSARY ACTION TO ENFORCE ITS RIGHTS TO THIS PROPRIETARY INFORMATION.


REV. NUM.	REV. DATE	REVISION DESCRIPTION	BY
A	05-10-18	REVISED	DWS
B	05-15-18	REVISED	DWS
C	07-11-18	BEGIN REDESIGN USING NEW COMPONENTS	DWS
D	07-25-18	REVISED	DWS
E	08-01-18	REVISED	DWS
F	08-22-18	REVISED	DWS
G	08-24-18	REVISED	DWS
H	08-26-18	REVISED	DWS
I	08-28-18	REVISED	DWS
J	08-28-18	REVISED	DWS
K	08-28-18	REVISED	DWS
L	09-07-18	REVISED	DWS
M	09-10-18	REVISED	DWS
N	09-11-18	ELECTRICAL REVISIONS	DWS
O	09-11-18	RELOCATED ELECTRICAL REVISIONS	DWS
P	09-20-18	RELOCATED ELECTRICAL REVISIONS (NO LOAD CHANGES)	DWS
00	09-21-18	ISSUED FOR CONSTRUCTION	DWS

DEFINITIONS OF STANDARD TERMINOLOGY USED IN THIS DRAWING PACKAGE:	
C.A.T. - CLEAN AIR TECHNOLOGY, INC. CLEANROOM - AN ENCLOSED CONTROLLED ENVIRONMENT, WITHIN WHICH, AIR IS FILTERED TO CONTAIN NO MORE THAN A SPECIFIED QUANTITY OF FOREIGN PARTICLES, AND MAY ALSO INCLUDE TEMPERATURE AND HUMIDITY CONTROL. S/A - SUPPLY AIR R/A - RETURN AIR M/A - MAKE-UP AIR RAHU - RECIRCULATING AIR HANDLING UNIT AHU - AIR HANDLING UNIT RF - RECIRCULATION FAN CHW - CHILLED WATER DX - DIRECT-EXPANSION REFRIGERANT HW - HOT WATER HEPA - HIGH EFFICIENCY PARTICULATE AIR (FILTER)	

LATEST REVISION(S) TO SET: 2/5/20

AS-BUILT DRAWING SET

CUSTOMER	
PROJECT TITLE USP 797 / USP 800 CLEANROOMS	
PROJECT LOCATION	
C.A.T. JOB NUMBER	18-142
ORIGINAL DATE:	05-08-18
DRAWN BY:	DWS
SCALE:	NONE
DESCRIPTION: TITLE PAGE INDEX TO DRAWINGS	
DRAWING #:	TITLE

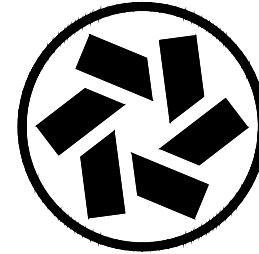

CLEAN AIR TECHNOLOGY, INC.
Decades of Experience Building America's Cleanrooms
41105 Capital, Canton, MI 48187 Tel 734-459-6320 Fax 734-459-9437
www.cleanairtechnology.com

THIS DRAWING CONTAINS DESIGNS AND OTHER INFORMATION
PREPARED BY OR FOR CLEAN AIR TECHNOLOGY, INC. (CATI).
THIS DRAWING MAY NOT BE REPRODUCED OR TRANSMITTED
IN ANY FORM OR BY ANY MEANS, ELECTRONIC OR MECHANICAL,
INCLUDING PHOTOCOPYING, RECORDING, OR BY ANY INFORMATION
SYSTEM, WITHOUT PERMISSION IN WRITING FROM CATI.
CATI ASSUMES NO LIABILITY FOR ANY DAMAGE OR LOSS OF
PROPERTY OR PERSONAL INJURY, INCLUDING REASONABLE
CONSEQUENTIAL DAMAGES, ARISING OUT OF OR IN CONNECTION
WITH THE USE OF THIS DRAWING. CATI SHALL NOT BE
RESPONSIBLE FOR ANY DAMAGE OR LOSS OF PROPERTY OR
PERSONAL INJURY, INCLUDING REASONABLE CONSEQUENTIAL
DAMAGES, ARISING OUT OF OR IN CONNECTION WITH THE
USE OF THIS DRAWING. CATI SHALL NOT BE RESPONSIBLE
FOR ANY DAMAGE OR LOSS OF PROPERTY OR PERSONAL
INJURY, INCLUDING REASONABLE CONSEQUENTIAL
DAMAGES, ARISING OUT OF OR IN CONNECTION WITH
THE USE OF THIS DRAWING. CATI SHALL NOT BE
RESPONSIBLE FOR ANY DAMAGE OR LOSS OF PROPERTY
OR PERSONAL INJURY, INCLUDING REASONABLE
CONSEQUENTIAL DAMAGES, ARISING OUT OF OR IN
CONNECTION WITH THE USE OF THIS DRAWING.

REV.	NUM.	DATE	DESCRIPTION	BY
00	01	02-25-18	ISSUED FOR CONSTRUCTION	DWS
01	01	07-26-19	AS-BUILT	DWS
02	01			
03	01			
04	01			
05	01			
06	01			
07	01			
08	01			
09	01			
10	01			
11	01			
12	01			
13	01			
14	01			
15	01			
16	01			
17	01			
18	01			
19	01			
20	01			
21	01			
22	01			
23	01			
24	01			
25	01			
26	01			
27	01			
28	01			
29	01			
30	01			

CUSTOMER

PROJECT TITLE
USP 797 / USP 800
CLEANROOMS

PROJECT LOCATION

C.A.T. JOB NUMBER 18-142


ORIGINAL DATE: 07-20-18

DRAWN BY: DWS


SCALE: 3/16" = 1'-0"


DESCRIPTION:
AREA OF CLEANROOM
CONSTRUCTION WITHIN
EXISTING BUILDING

DRAWING #: CR-001

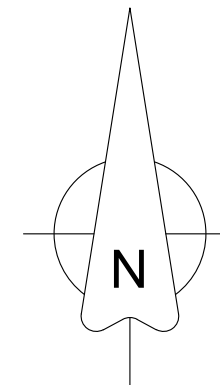

AS-BUILT DRAWING SET

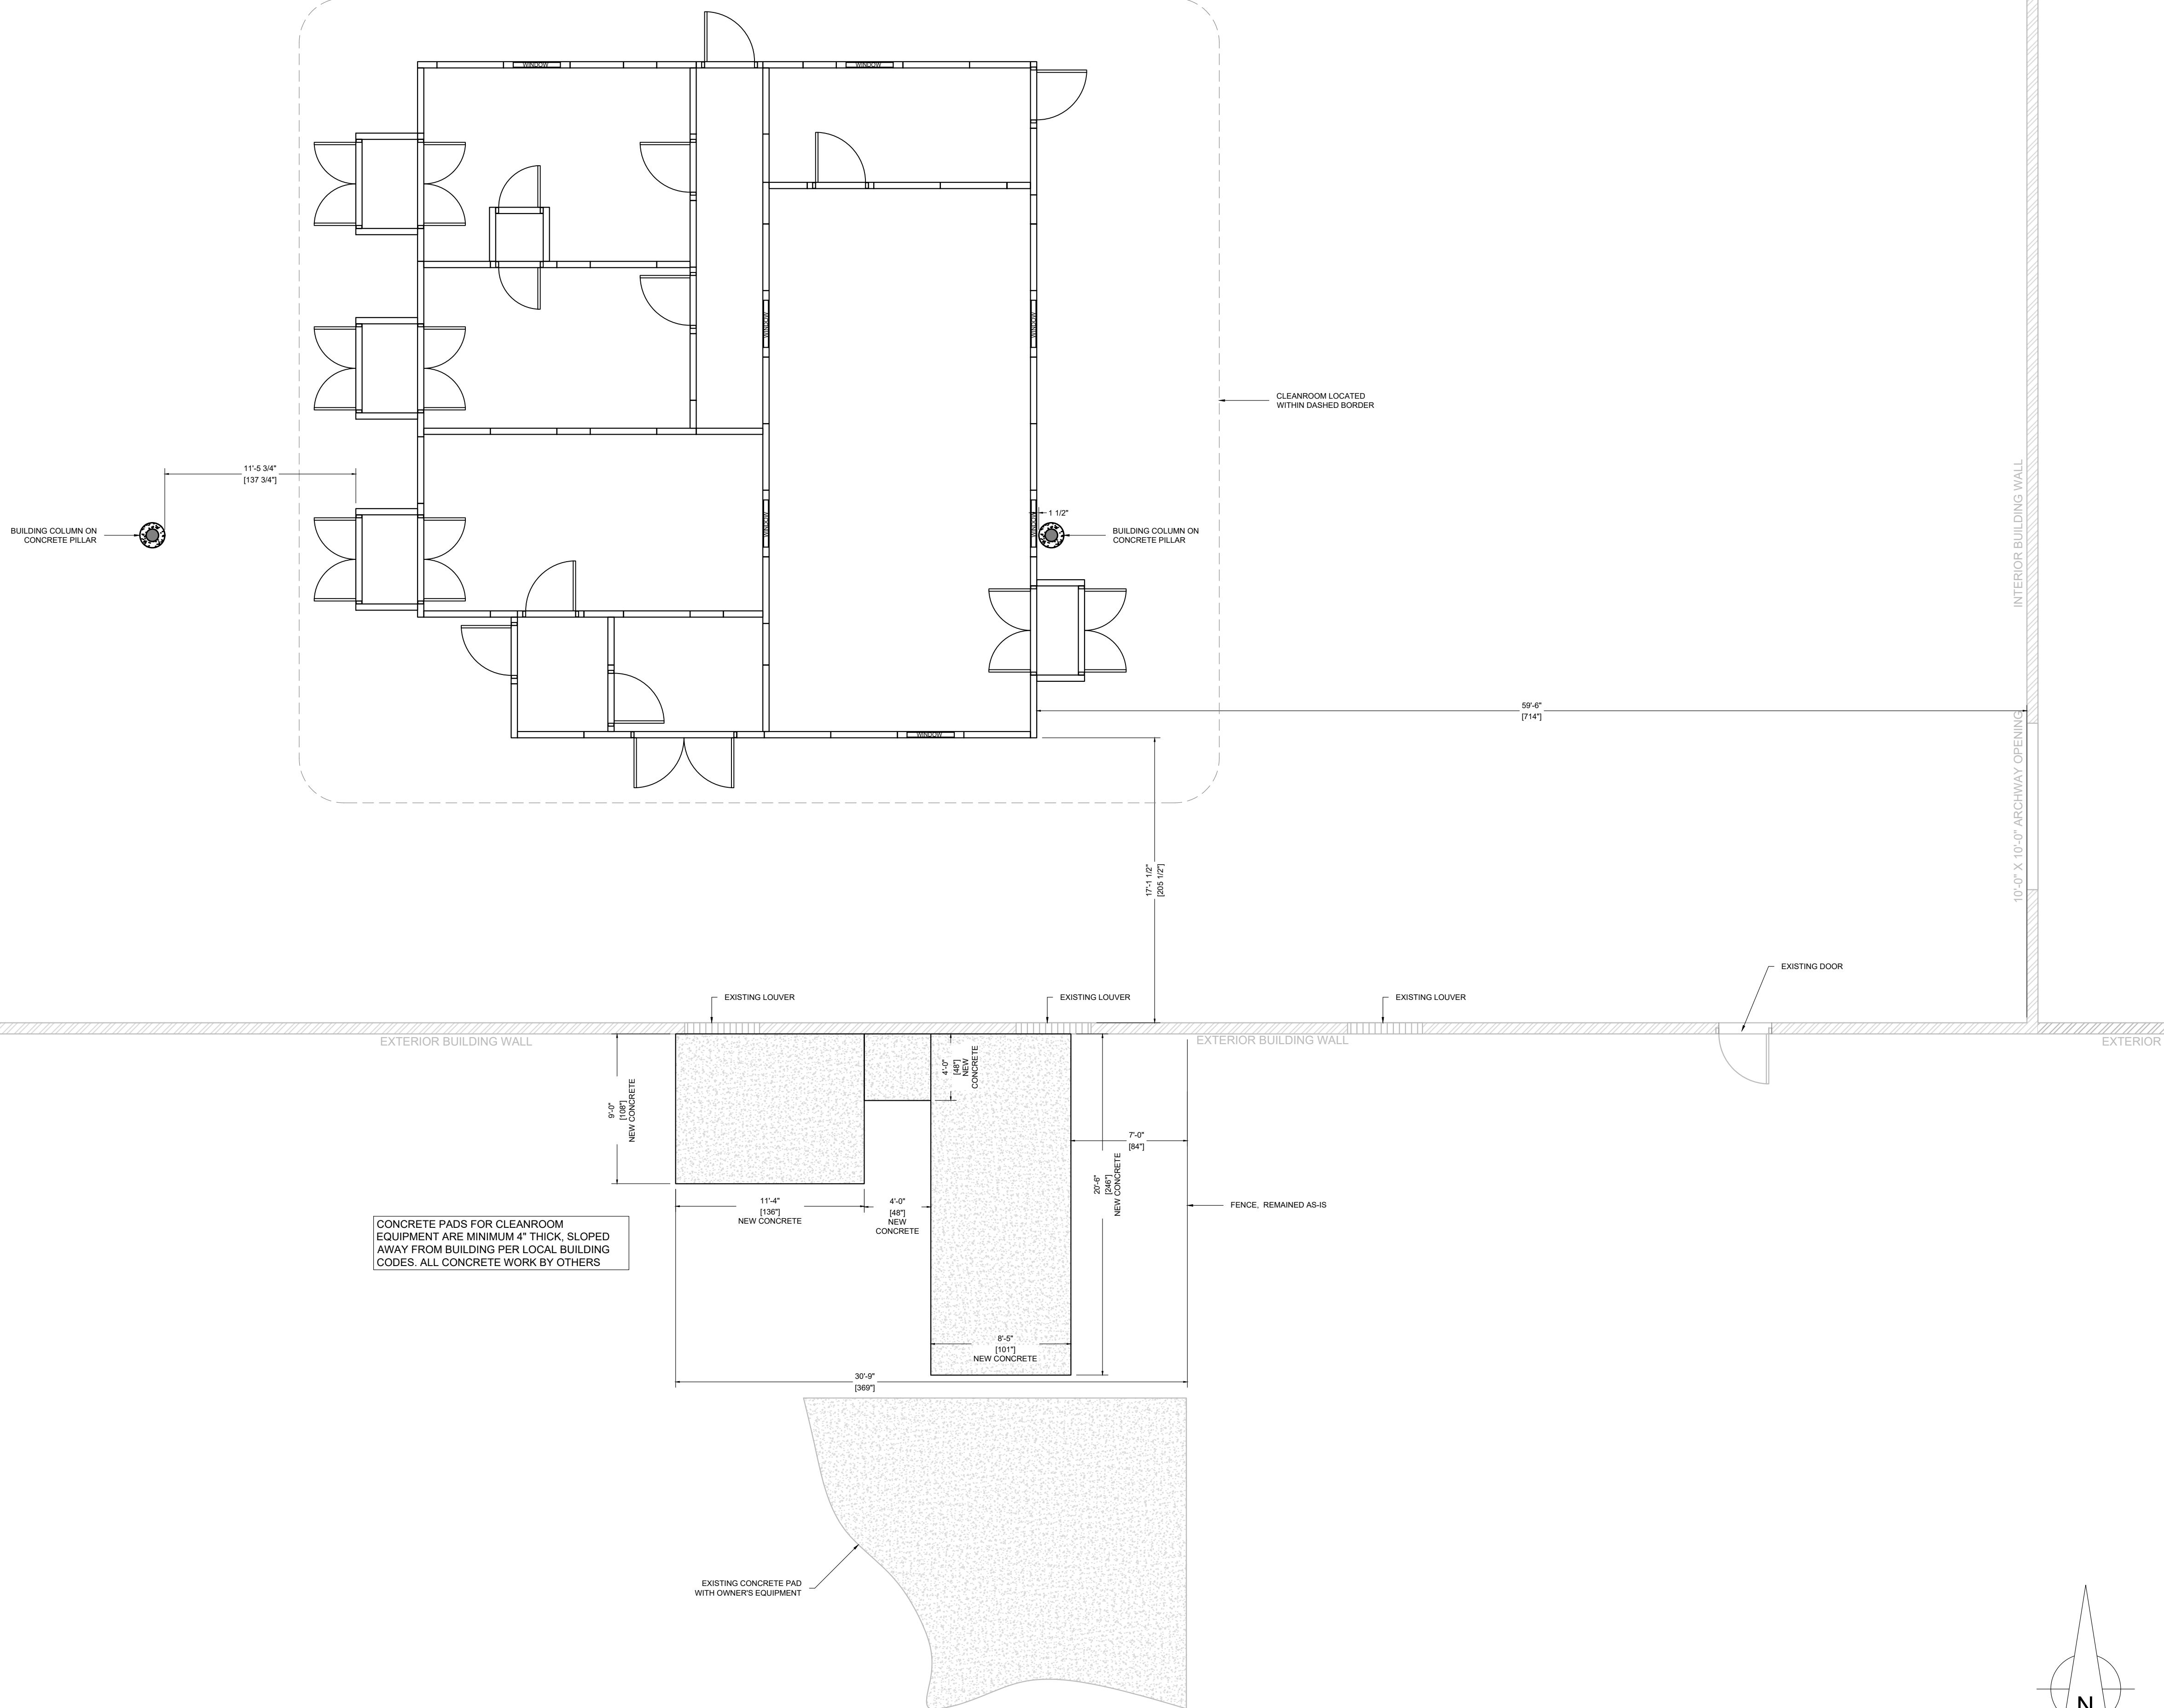

 

LEGEND	
	ILLUMINATED EXIT SIGN, WITH SIDE-MOUNTED SPOTLIGHTS, 90 MINUTE EMERGENCY BATTERY BACKUP
	36" X 36" DUAL-PANE WINDOW IN CLEANROOM WALL, CLEAR SAFETY GLASS.
	ANODIZED ALUMINUM AIR RETURN FACE GRILLE.
SEE CHART, THIS DRAWING, FOR QUANTITIES AND SIZES OF R/A GRILLES.	

Cleanroom Return air Data					
Room Name	Design Airflow Volume (CFM)	Wall Depth (in.)	Grille Size	Quantity	Velocity Up R/A Wall Chases (FPM)
Cream Room	4410	4	18x18	13	509
Cream Room Gownrom	560	4	10x18	2	420
Cart Pass-Thru-1	100	4	10x18	1	150
Sample Room	490	4	18x18*	2	368
Sample Room Gownroom	300	4	10x18	1	450
Gownroom	700	4	10x18	3	350
Concentrate Room	1755	4	18x18	5	527
V-Blend Room	1240	4	18x18	4	465
Fill/Pack Room	1395	4	18x18	4	523
Cart Pass-Thru-2	100	4	10x18	1	150
Cart Pass-Thru-3	100	4	10x18	1	150
Cart Pass-Thru-4	100	4	10x18	1	150

*= 1 @ 18x18 & 1 @ 10x18



PRESSURE CHART	
Room Name	Pressure (" W.C.)
Cream Room	0.06
Cream Room Gownrom	0.03
Cart Pass-Thru-1	0.03
Sample Room	-0.01
Sample Room Gownroom	0.015
Gownroom	0.02
Concentrate Room	0.00
V-Blend Room	0.00
Fill/Pack Room	0.00
Cart Pass-Thru-2	0.01
Cart Pass-Thru-3	0.01
Cart Pass-Thru-4	0.01

18-142 DOOR SCHEDULE																			NEW OR RE-USED FROM MIAMI, FL FACILITY
DOOR NUMBER	WIDTH	HEIGHT	SWING	FRAME DEPTH	FINISH	HALF OR FULL GLASS	GLASS COLOR	HARDWARE TYPE	DUMMY CYLINDER	CLOSER ON ACTIVE LEAF	GASKETED FRAME STOPS	HINGE QUANTITY	SWEEP	THRESHOLD	MANUFACTURER	INTERLOCKED	ASTRAGAL ON INACTIVE LEAF	FLUSHBOLTS ON INACTIVE LEAF	
01	36"	84"	RH	STANDARD	ALUMINUM ANODIZED	HALF-GLASS	CLEAR	PUSH-PULL HARDWARE	YES	YES	YES	3	YES	NO	RAMCO	NO	N/A	N/A	RE-USED
02	36"	84"	RH	STANDARD	ALUMINUM ANODIZED	HALF-GLASS	CLEAR	PUSH-PULL HARDWARE	YES	YES	YES	3	YES	NO	RAMCO	NO	N/A	N/A	RE-USED
03	36"	84"	RH	STANDARD	ALUMINUM ANODIZED	HALF-GLASS	CLEAR	PUSH-PULL HARDWARE	YES	YES	YES	3	YES	NO	RAMCO	NO	N/A	N/A	RE-USED
04	36"	84"	LH	STANDARD	ALUMINUM ANODIZED	HALF-GLASS	CLEAR	PUSH-PULL HARDWARE	YES	YES	YES	3	YES	NO	RAMCO	NO	N/A	N/A	NEW
05	36"	84"	LH	STANDARD	ALUMINUM ANODIZED	HALF-GLASS	CLEAR	PUSH-PULL HARDWARE	YES	YES	YES	3	YES	NO	RAMCO	NO	N/A	N/A	RE-USED
06	60"	84"	DOUBLE	STANDARD	ALUMINUM ANODIZED	FULL-GLASS	CLEAR	PUSH-PULL HARDWARE	YES	YES	YES	6	YES	NO	RAMCO	YES, WITH 07	YES	NO	NEW
07	60"	84"	DOUBLE	STANDARD	ALUMINUM ANODIZED	FULL-GLASS	CLEAR	PUSH-PULL HARDWARE	YES	YES	YES	6	YES	NO	RAMCO	YES, WITH 08	YES	NO	NEW
08	60"	84"	DOUBLE	STANDARD	ALUMINUM ANODIZED	FULL-GLASS	CLEAR	PUSH-PULL HARDWARE	YES	YES	YES	6	YES	NO	RAMCO	YES, WITH 09	YES	NO	RE-USED
09	60"	84"	DOUBLE	STANDARD	ALUMINUM ANODIZED	FULL-GLASS	CLEAR	PUSH-PULL HARDWARE	YES	YES	YES	6	YES	NO	RAMCO	YES, WITH 08	YES	NO	NEW
10	36"	84"	RH	STANDARD	ALUMINUM ANODIZED	HALF-GLASS	CLEAR	PUSH-PULL HARDWARE	YES	YES	YES	3	YES	NO	RAMCO	NO	N/A	N/A	NEW
11	60"	84"	DOUBLE	STANDARD	ALUMINUM ANODIZED	FULL-GLASS	CLEAR	PUSH-PULL HARDWARE	YES	YES	YES	6	YES	NO	RAMCO	YES, WITH 12	YES	NO	RE-USED
12	60"	84"	DOUBLE	STANDARD	ALUMINUM ANODIZED	FULL-GLASS	CLEAR	PUSH-PULL HARDWARE	YES	YES	YES	6	YES	NO	RAMCO	YES, WITH 11	YES	NO	RE-USED
13	36"	84"	LH	STANDARD	ALUMINUM ANODIZED	HALF-GLASS	CLEAR	PUSH-PULL HARDWARE	YES	YES	YES	3	YES	NO	RAMCO	NO	N/A	N/A	NEW
14	36"	84"	RH	STANDARD	ALUMINUM ANODIZED	HALF-GLASS	CLEAR	PUSH-PULL HARDWARE	YES	YES	YES	3	YES	NO	RAMCO	NO	N/A	N/A	NEW
15	30"	60"	LH	STANDARD	ALUMINUM ANODIZED	HALF-GLASS	CLEAR	PUSH-PULL HARDWARE	YES	YES	YES	3	YES	NO	RAMCO	YES, WITH 16	N/A	N/A	NEW
16	30"	60"	RH	STANDARD	ALUMINUM ANODIZED	HALF-GLASS	CLEAR	PUSH-PULL HARDWARE	YES	YES	YES	3	YES	NO	RAMCO	YES, WITH 15	N/A	N/A	NEW
17	60"	84"	DOUBLE	STANDARD	ALUMINUM ANODIZED	FULL-GLASS	CLEAR	PUSH-PULL HARDWARE	YES	YES	YES	6	YES	NO	RAMCO	YES, WITH 18	YES	NO	NEW
18	60"	84"	DOUBLE	STANDARD	ALUMINUM ANODIZED	FULL-GLASS	CLEAR	PUSH-PULL HARDWARE	YES	YES	YES	6	YES	NO	RAMCO	YES, WITH 17	YES	NO	NEW
19	72"	84"	DOUBLE	STANDARD	ALUMINUM ANODIZED	HALF-GLASS	CLEAR	PUSH-PULL HARDWARE	YES	YES	YES	6	YES	NO	RAMCO	NO	YES	YES	NEW

REV.	NUM.	DATE	REVISION DESCRIPTION	BY
	A	05-15-18	REVISED	DWS
	B	07-12-18	REDISIGN USING NEW COMPONENTS	DWS
	C	07-12-18	REVISED	DWS
	D	07-25-18	REVISED	DWS
	E	08-22-18	REVISED	DWS
	F	08-26-18	REVISED	DWS
	G	08-29-18	REVISED	DWS
	H	08-29-18	REVISED	DWS
	I	08-29-18	REVISED	DWS
	J	08-29-18	REVISED	DWS
	K	09-10-18	REVISED	DWS
	00	09-21-18	ISSUED FOR CONSTRUCTION	DWS
	01	01-28-19	AS-BUILT	DWS
	02	02-05-19	ADDED PRESSURE CHART	DWS
	--	--	--	--
	--	--	--	--
	--	--	--	--
	--	--	--	--

<u>CUSTOMER</u>	
<u>PROJECT TITLE</u> USP 797 / USP 800 CLEANROOMS	
<u>PROJECT LOCATION</u>	
C.A.T. JOB NUMBER	18-142
ORIGINAL DATE:	05-08-18
DRAWN BY:	DWS
SCALE:	1/4" = 1'-0"
DESCRIPTION:	
CLEANROOM FLOOR PLAN	
DRAWING #:	CR-100

AS-BUILT DRAWING SET

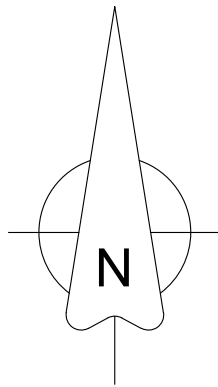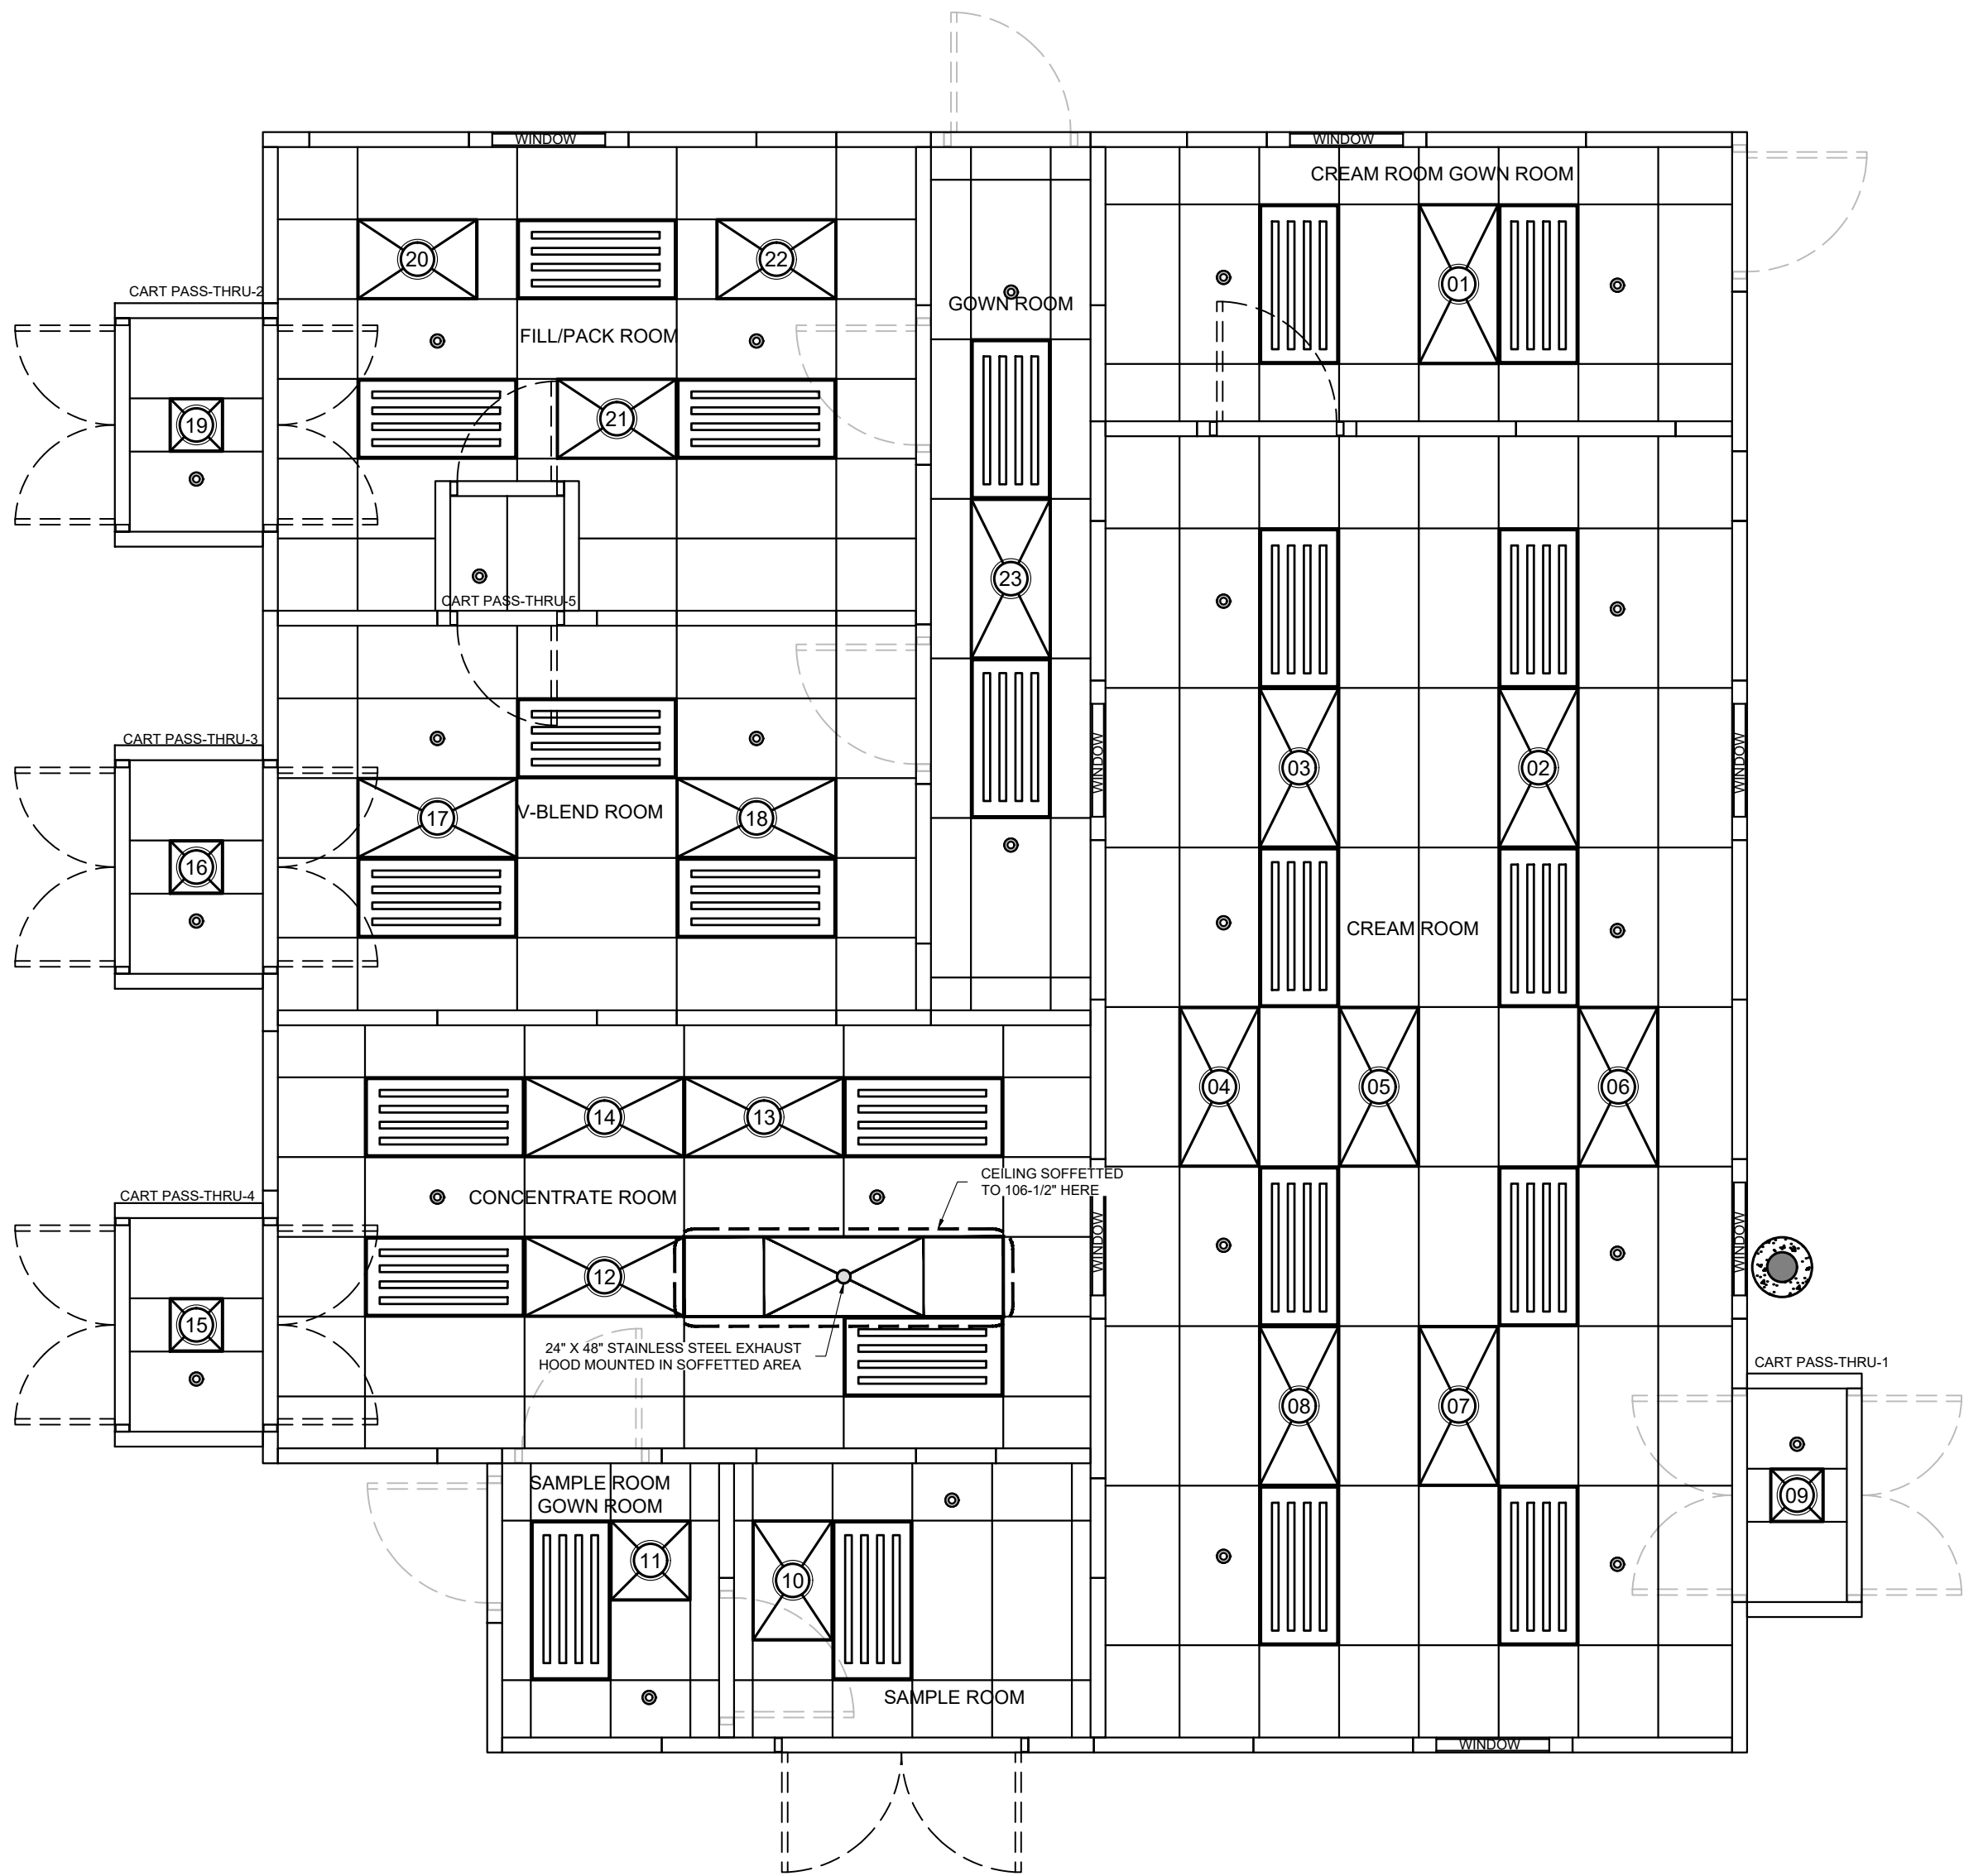

- NOTES:
1. NEW CLEANROOM WALLS ARE 11'-6" TALL
 2. ALL CART PASS-THRU'S ARE CLASS ISO-8

LEGEND

24" X 48" SEALED 4-TUBE CLEANROOM GRADE FLUORESCENT LIGHT FIXTURE. 128W, .46A @ 277V, 1.1A @ 120V(DUAL VOLTAGE BALLAST)

CEILING GRID MOUNTED TERMINAL HEPA FILTER MODULE. SEE CHART, THIS DRAWING, FOR FILTER SIZES AND AIRFLOW SPECIFICS

● LOCATION OF FIRE-SUPPRESSION SPRINKLER HEAD

Cleanroom Area Volume and Supply air Data												
Room Name	Class	Area (sq')	Ceiling Height (in.)	Volume (Cu')	Target ACH	Target Airflow Volume (CFM)	HEPA Filter Size	HEPA Filter Quantity	Airflow Per Filter	Face Velocity (FPM)	Design Airflow Volume (CFM)	Design ACH
Cream Room	ISO-7	512	102.00	4,352	60	4,352	24 x 48	7	630	91.57	4,410	60.80
Cream Room Gownrom	ISO-8	108	96.00	864	30	432	24 x 48	1	560	81.40	560	38.89
Cart Pass-Thru-1	ISO-8	13	96.00	104	30	52	16 x 16	1	100	79.18	100	57.69
Sample Room	ISO-7	61	96.00	488	60	488	24 x 36	1	490	97.26	490	60.25
Sample Room Gownroom	ISO-7	37	96.00	296	60	296	24 x 24	1	300	93.93	300	60.81
Gownroom	ISO-7	87	96.00	696	60	696	24 x 48	1	700	101.74	700	60.34
Concentrate Room	ISO-7	216	96.00	1,728	60	1,728	24 x 48	3	585	85.03	1,755	60.94
V-Blend Room	ISO-7	154	96.00	1,232	60	1,232	24 x 48	2	620	90.12	1,240	60.39
Fill/Pack Room	ISO-7	174	96.00	1,392	60	1,392	24 x 36	3	465	92.30	1,395	60.13
Cart Pass-Thru-2	ISO-8	18	96.00	144	30	72	16 x 16	1	100	79.18	100	41.67
Cart Pass-Thru-3	ISO-8	18	96.00	144	30	72	16 x 16	1	100	79.18	100	41.67
Cart Pass-Thru-4	ISO-8	18	96.00	144	30	72	16 x 16	1	100	79.18	100	41.67

18-142 HEPA FILTER SERIAL NUMBERS	
HEPA FILT. NUM.	SERIAL NUMBER
01	H095210-005
02	H095210-001
03	H095210-012
04	H095210-015
05	H095210-011
06	H095210-010
07	H095210-007
08	H095210-009
09	H093537-001
10	H095215-001
11	H090051-005
12	H095210-003
13	H095210-013
14	H095210-006
15	H093537-003
16	H093537-004
17	H095210-014
18	H095210-005
19	H093537-002
20	H095215-004
21	H095215-003
22	H095215-002
23	H095210-002

REV	NUM	REV DATE	REVISION DESCRIPTION
A	01	05-15-18	REDESIGN
B	02	07-12-18	REDESIGN USING NEW COMPONENTS
C	03	07-17-18	REDESIGN
00	04	09-21-18	ISSUED FOR CONSTRUCTION
01	05	09-21-18	ISSUED FOR CONSTRUCTION
02	06	09-31-20	AS-BUILT REVISIONS
03	07	02-05-20	AS-BUILT REVISIONS
04	08	02-05-20	AS-BUILT REVISIONS
05	09	02-05-20	AS-BUILT REVISIONS
06	10	02-05-20	AS-BUILT REVISIONS
07	11	02-05-20	AS-BUILT REVISIONS
08	12	02-05-20	AS-BUILT REVISIONS
09	13	02-05-20	AS-BUILT REVISIONS
10	14	02-05-20	AS-BUILT REVISIONS
11	15	02-05-20	AS-BUILT REVISIONS
12	16	02-05-20	AS-BUILT REVISIONS
13	17	02-05-20	AS-BUILT REVISIONS
14	18	02-05-20	AS-BUILT REVISIONS
15	19	02-05-20	AS-BUILT REVISIONS
16	20	02-05-20	AS-BUILT REVISIONS
17	21	02-05-20	AS-BUILT REVISIONS
18	22	02-05-20	AS-BUILT REVISIONS
19	23	02-05-20	AS-BUILT REVISIONS

CUSTOMER

PROJECT TITLE
USP 797 / USP 800
CLEANROOMS

PROJECT LOCATION

C.A.T. JOB NUMBER18-142

ORIGINAL DATE:05-08-18

DRAWN BY:DWS

SCALE:1/4" = 1'-0"


DESCRIPTION:
CLEANROOM REFLECTED
CEILING PLAN












DRAWING #:CR-101


AS-BUILT DRAWING SET

THIS DRAWING CONTAINS DESIGNS AND OTHER INFORMATION WHICH ARE THE PROPERTY OF CLEAN AIR TECHNOLOGY, INC. THIS DRAWING MAY NOT BE REPRODUCED, COPIED, OR IN PART, BE USED FOR ANY OTHER PROJECT WITHOUT THE WRITTEN PERMISSION OF CLEAN AIR TECHNOLOGY, INC. ANY COPIES OF THIS DRAWING OR ANY PART THEREOF, INCLUDING ANY REVISIONS, ARE TO BE RETURNED TO CLEAN AIR TECHNOLOGY, INC. ON REQUEST. CLEAN AIR TECHNOLOGY, INC. WILL ELECT TO TAKE ALL NECESSARY ACTION TO ENFORCE ITS RIGHTS TO THIS PROPRIETARY INFORMATION.

CLEAN AIR TECHNOLOGY, INC.
Decades of Experience Building America's Cleanrooms
41105 Capital, Canton, MI 48187 Tel 734-459-6320 Fax 734-459-9437
www.cleanairtechnology.com

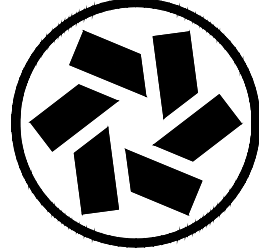

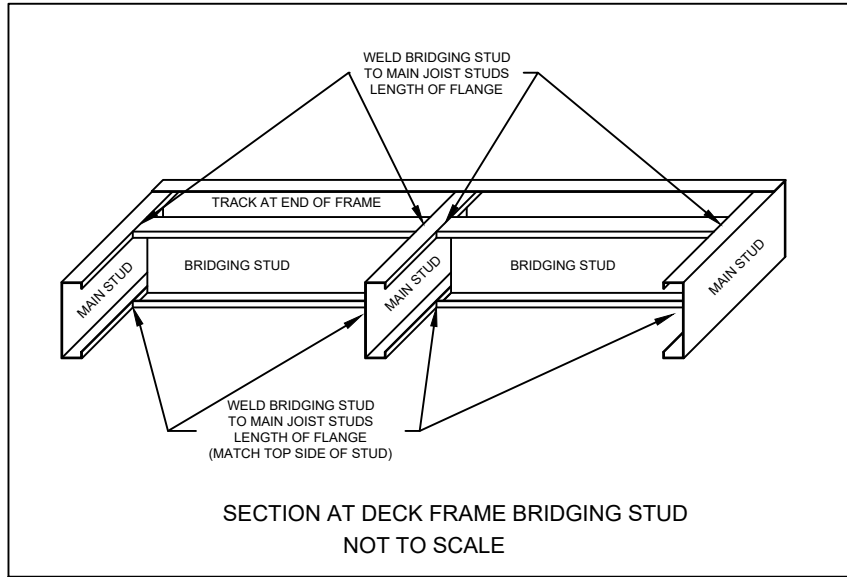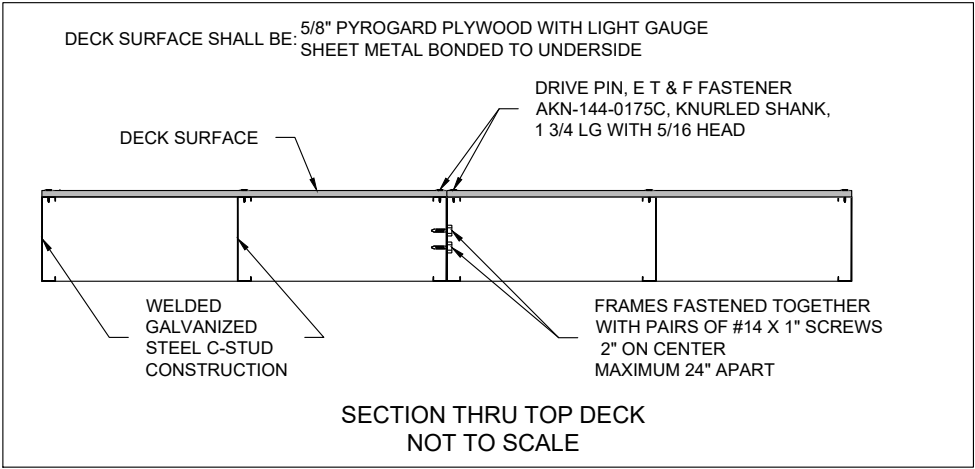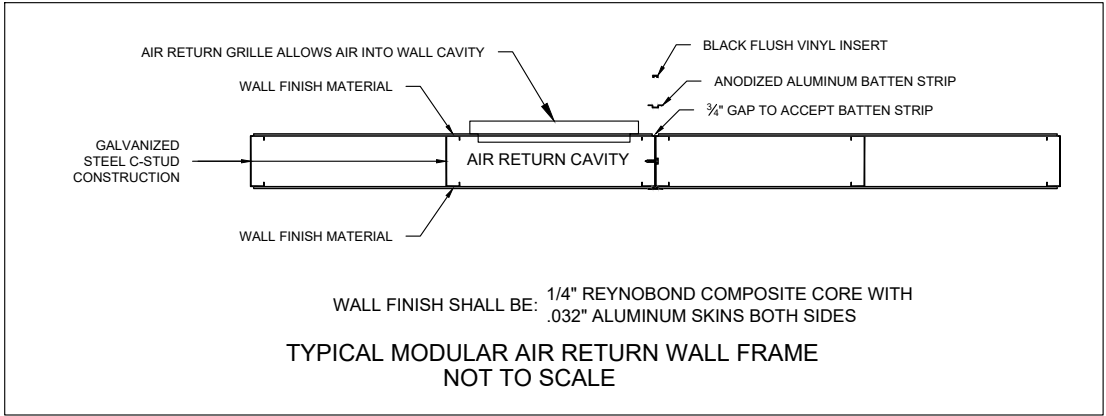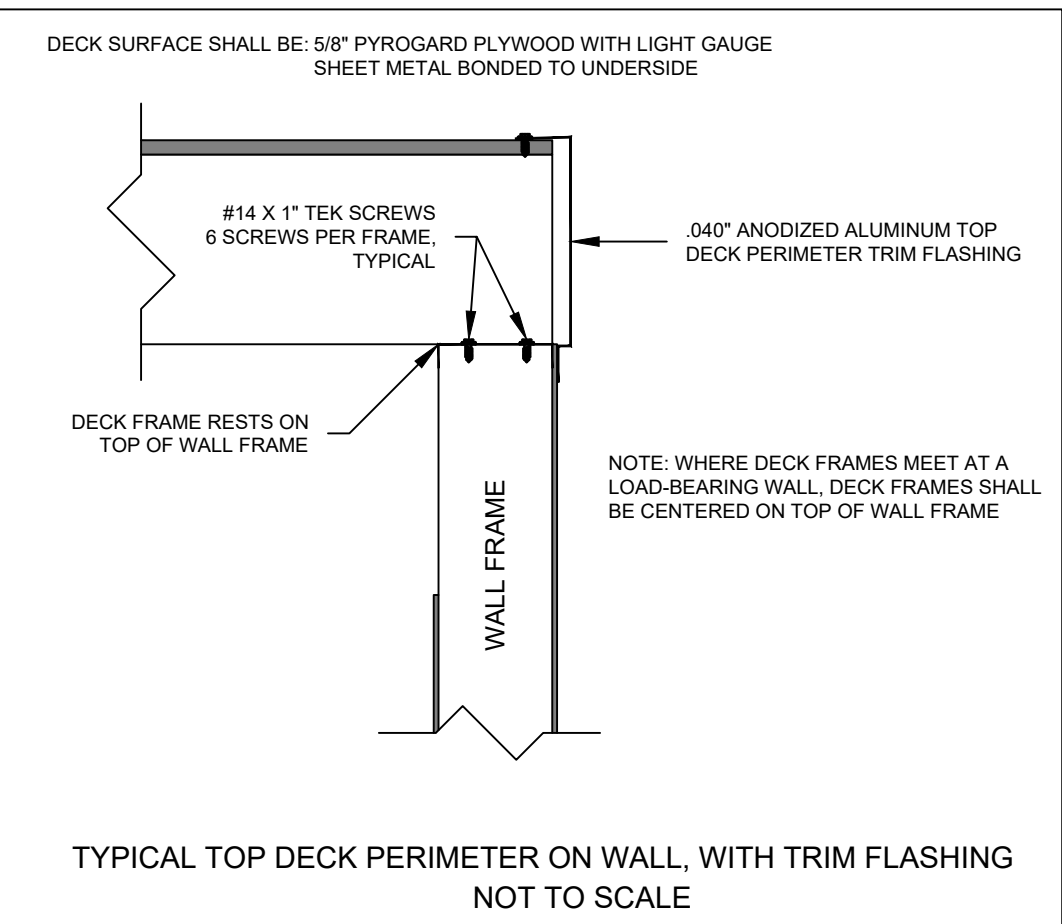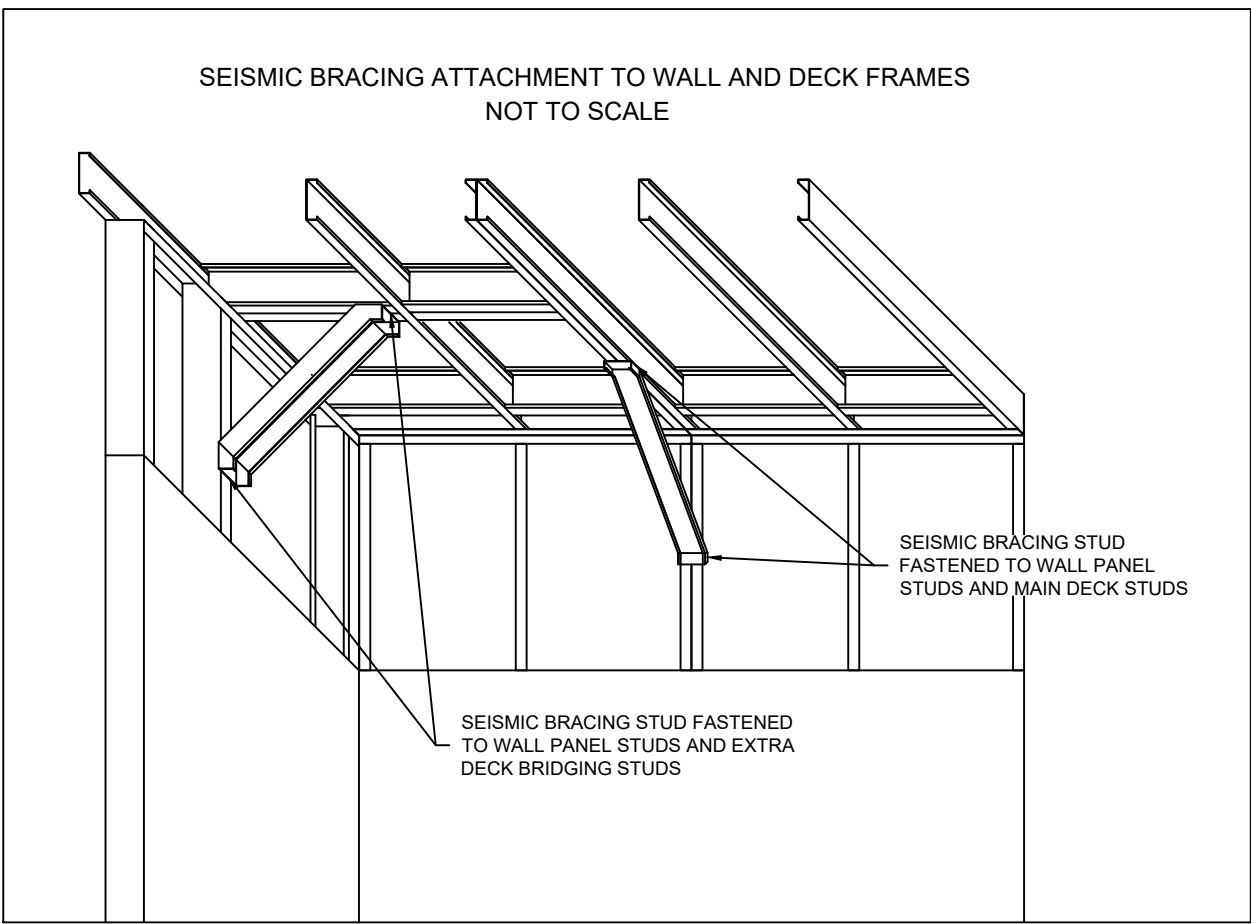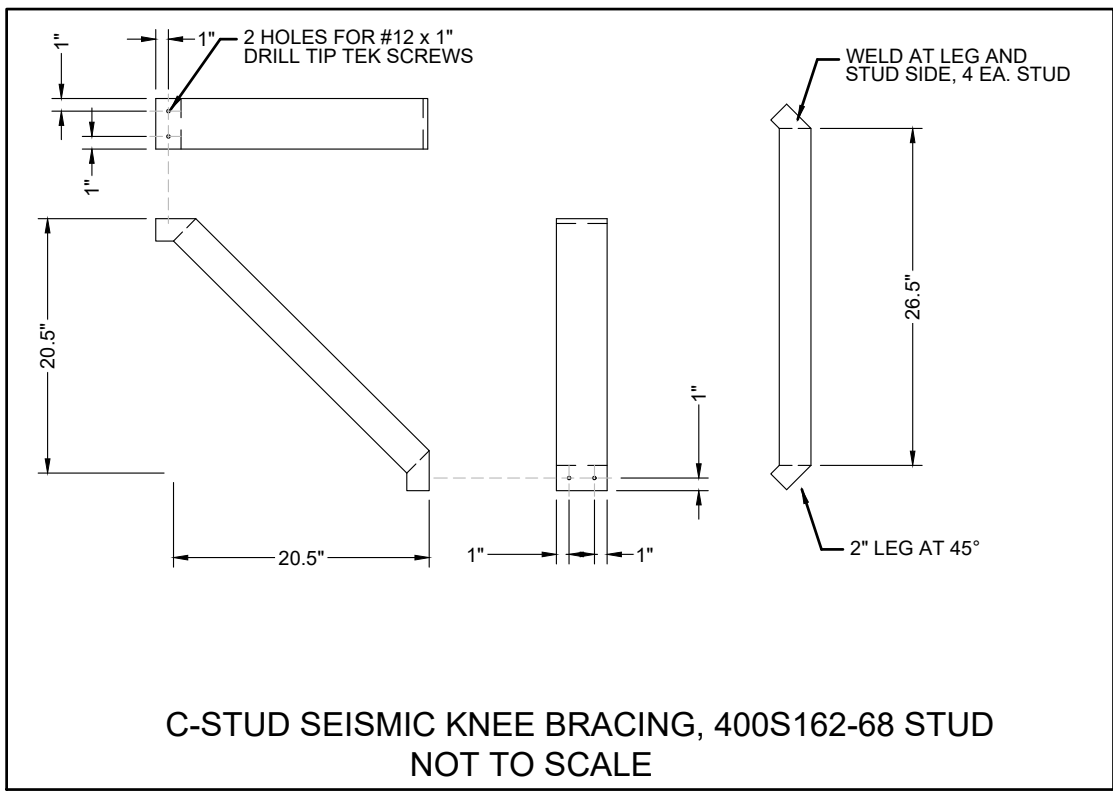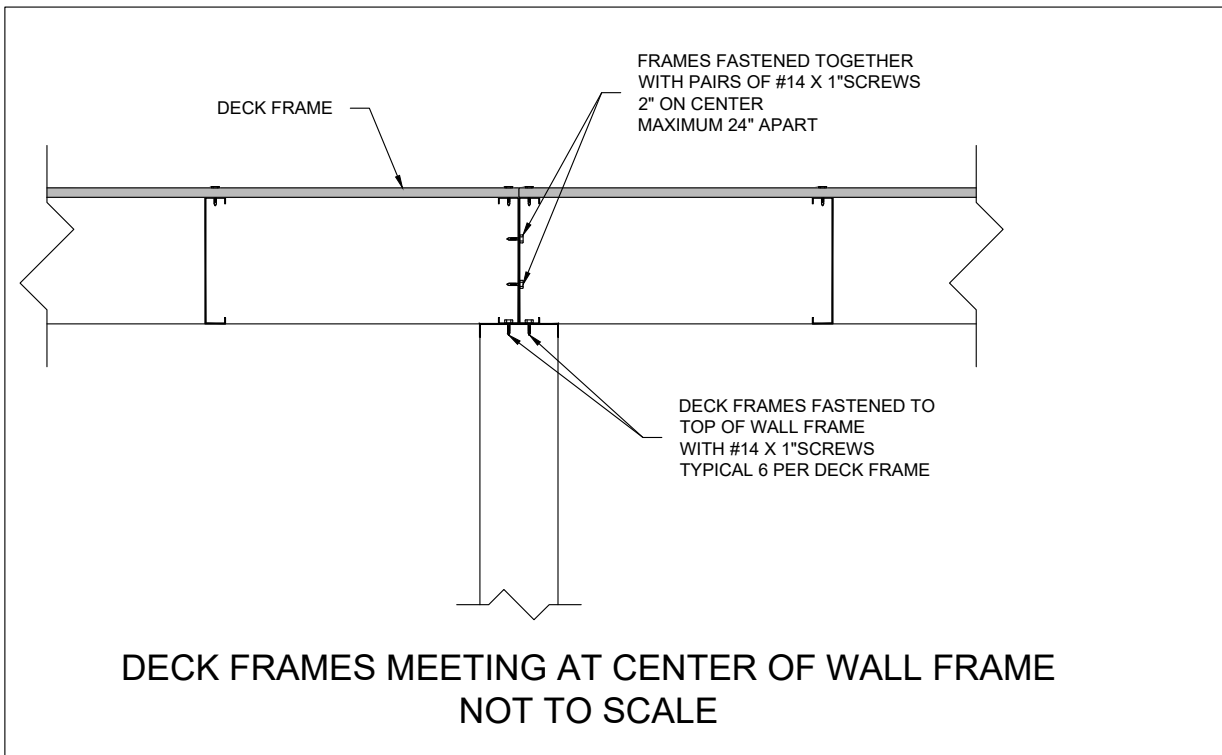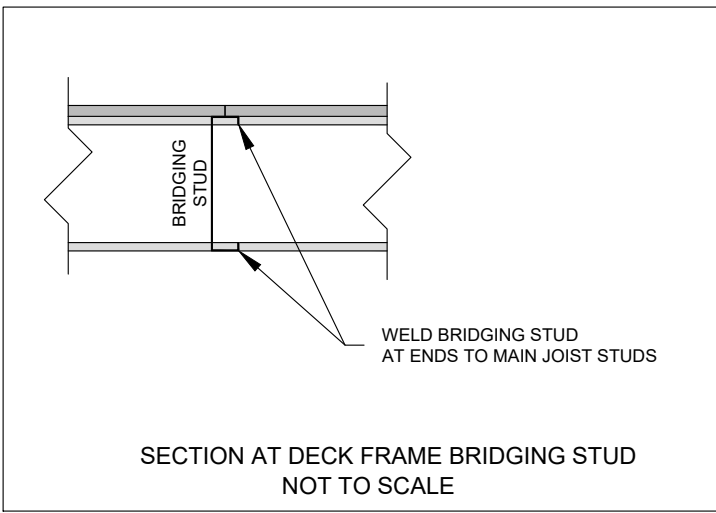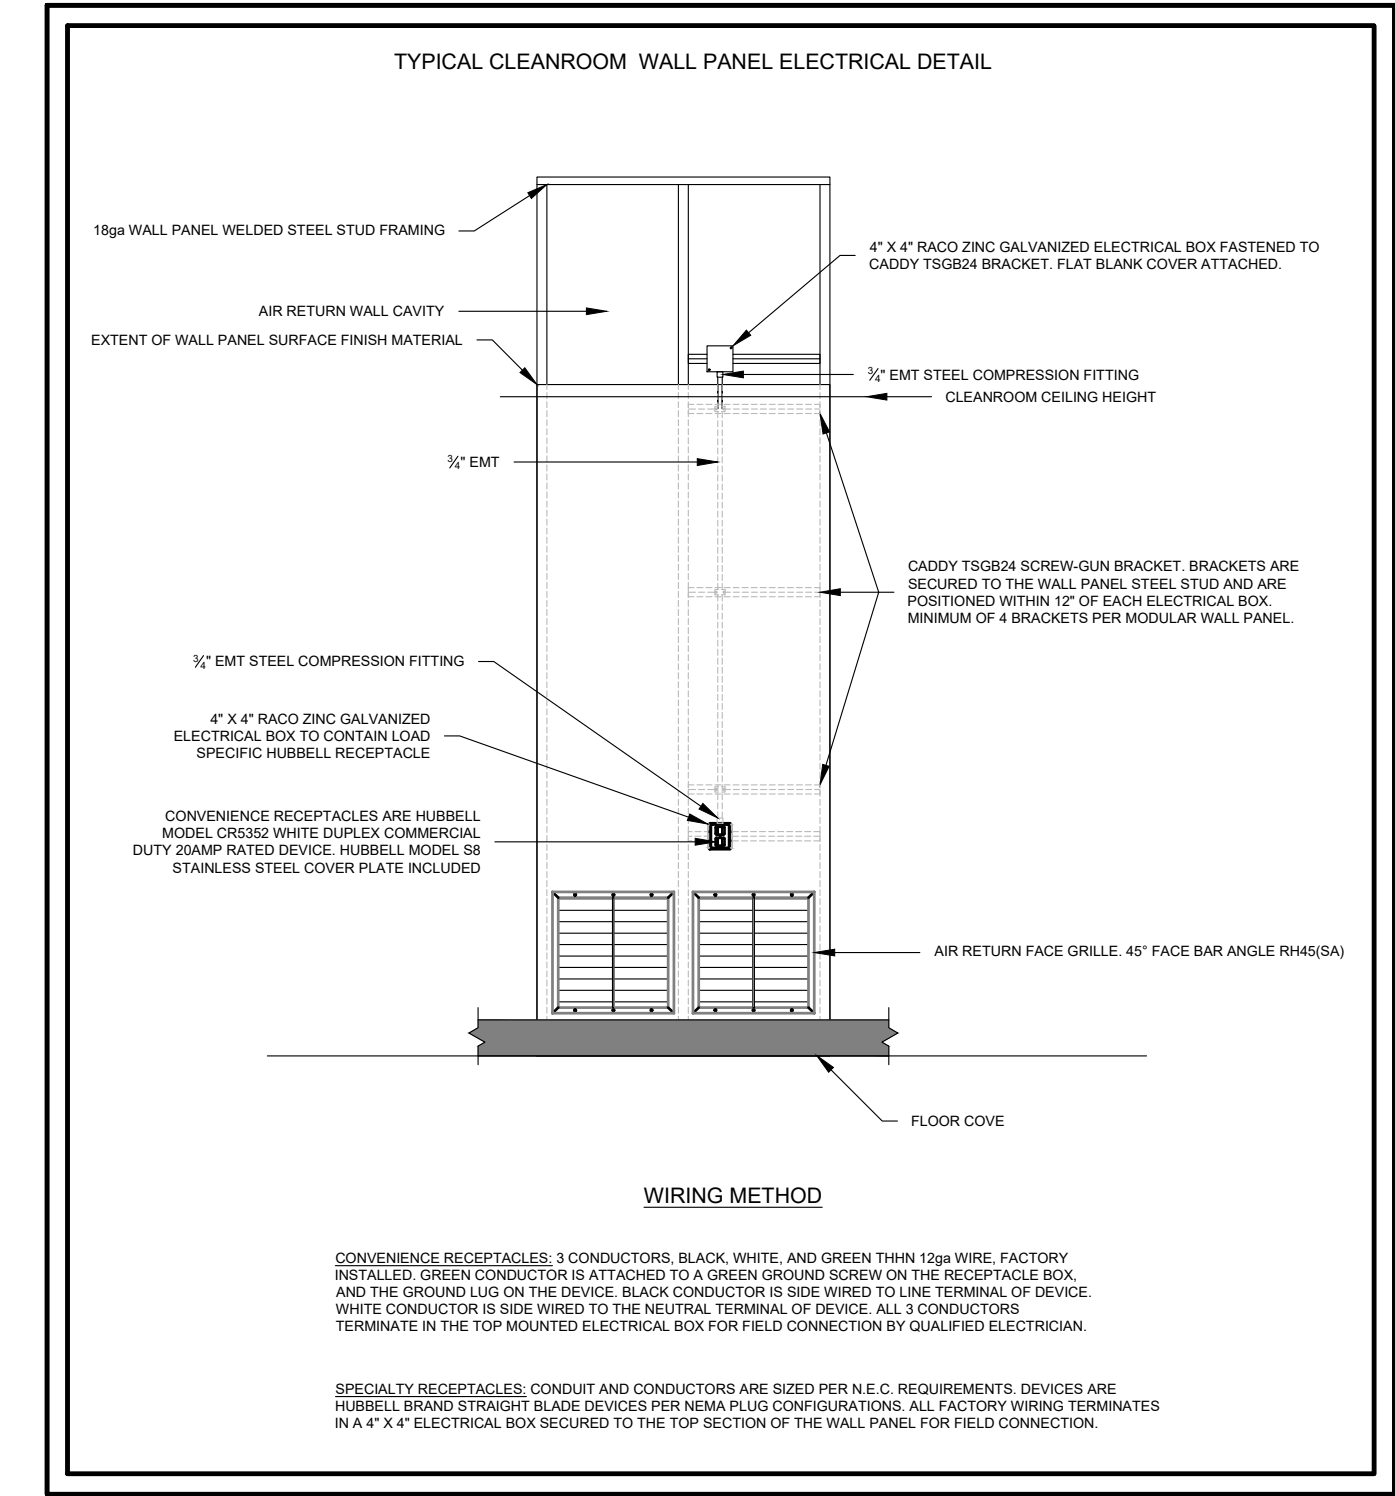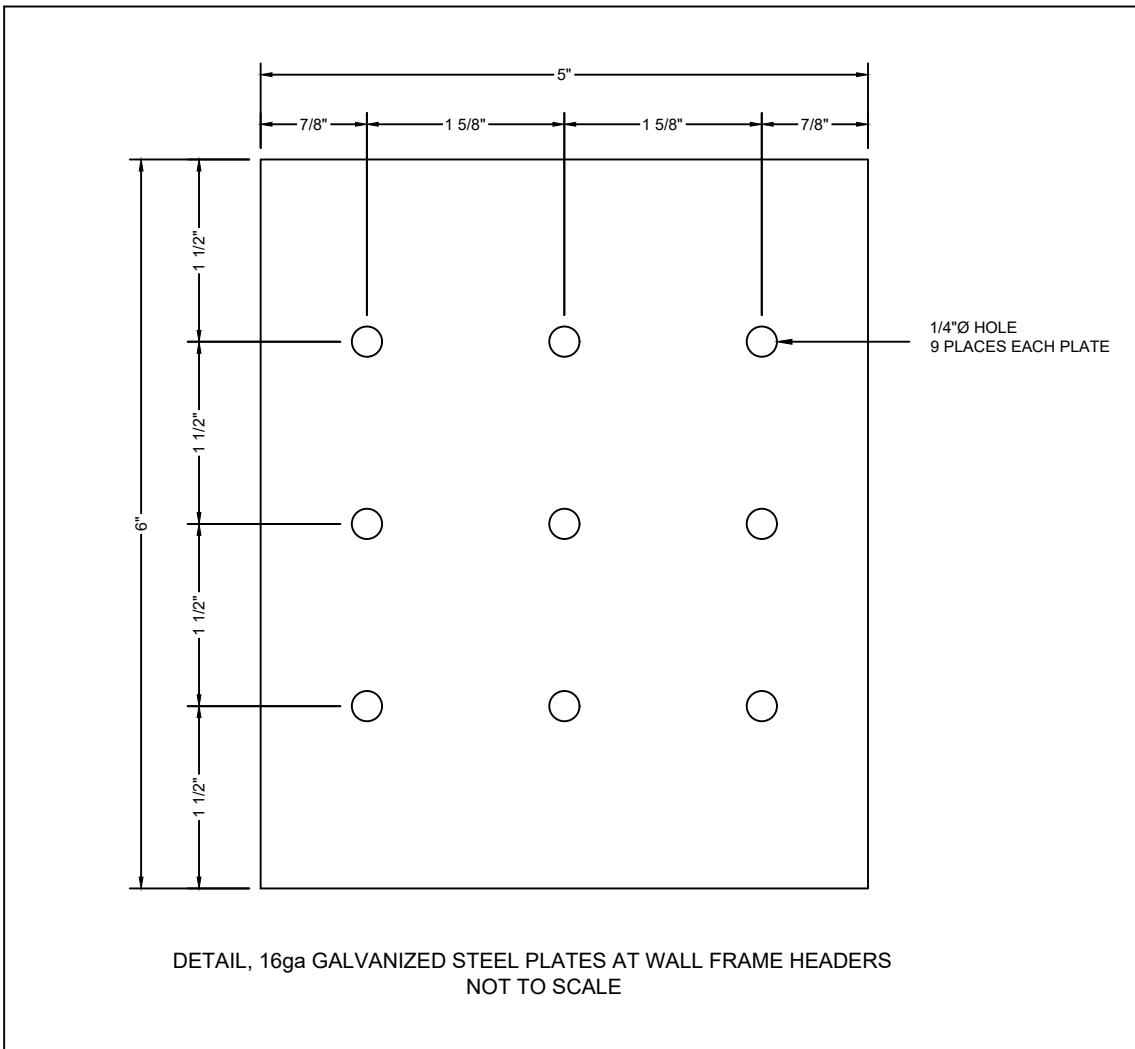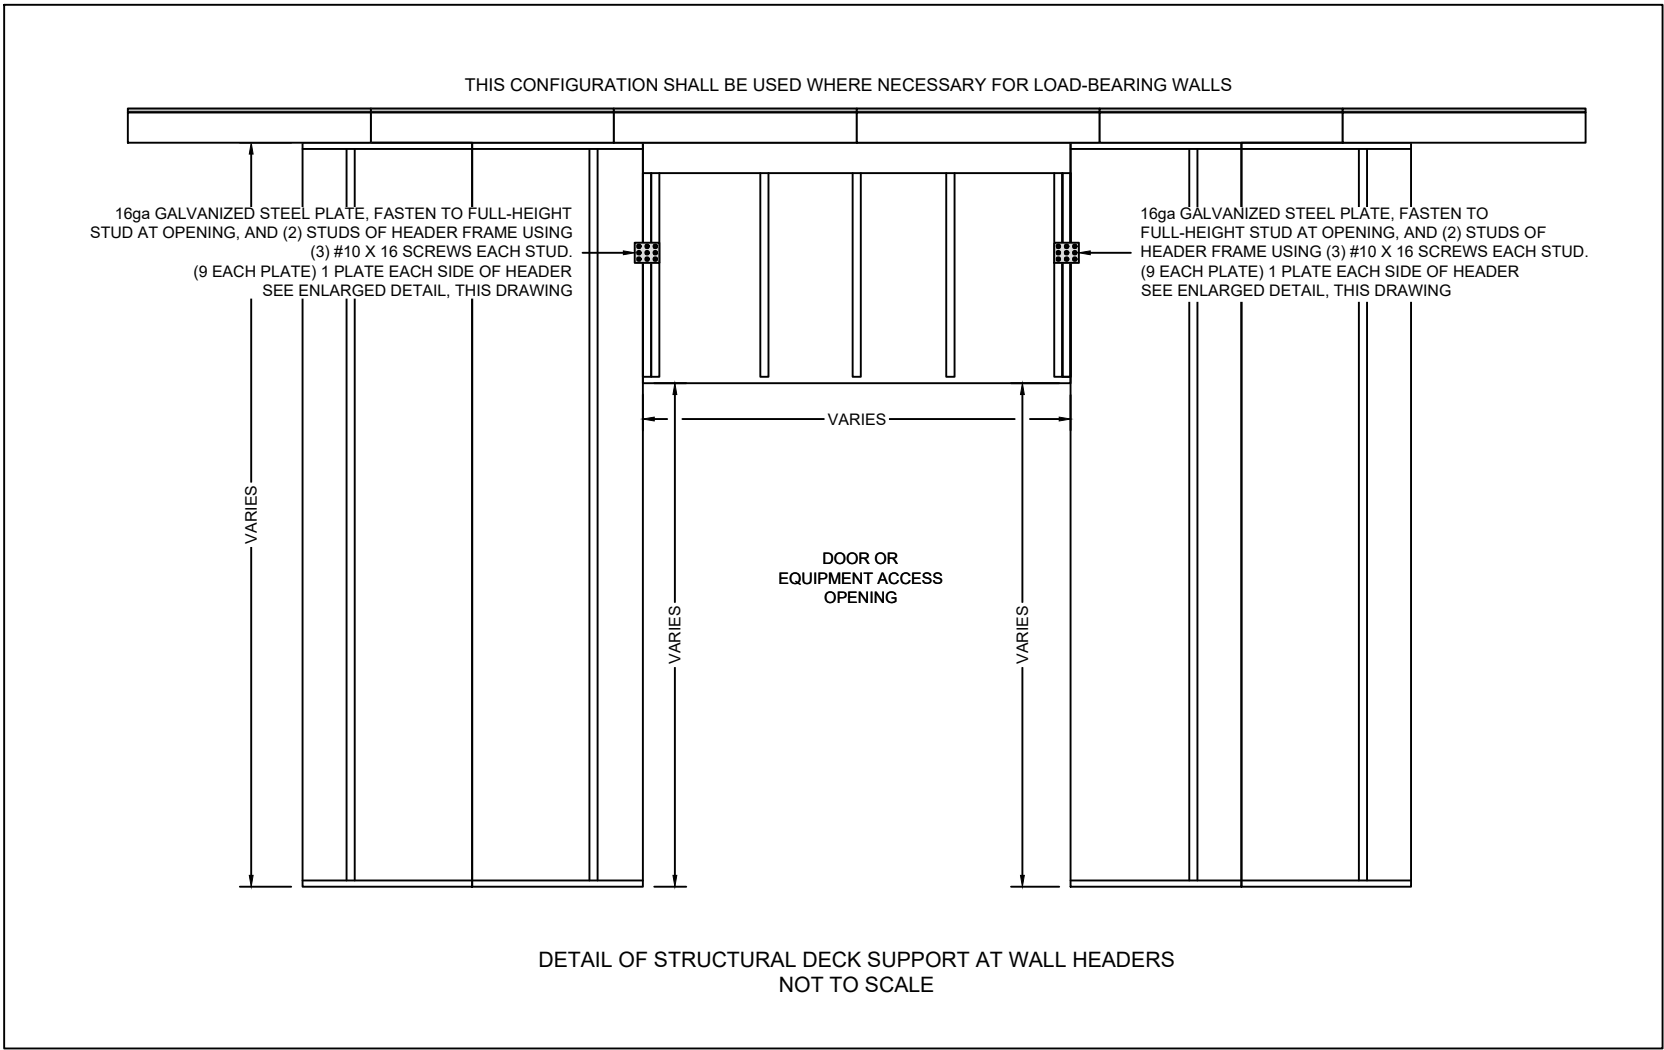

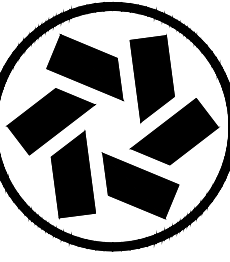

CLEAN AIR TECHNOLOGY, INC.

Decades of Experience Building America's Cleanrooms

41105 Capital, Canton, MI 48187 Tel 734-459-6320 Fax 734-459-9437

www.cleanairtechnology.com

THIS DRAWING CONTAINS DESIGNS AND OTHER INFORMATION THAT ARE THE PROPERTY OF CLEAN AIR TECHNOLOGY, INC. THIS DRAWING MAY NOT BE REPRODUCED, COPIED, OR IN PART, BE USED FOR ANY OTHER PROJECT WITHOUT THE WRITTEN PERMISSION OF CLEAN AIR TECHNOLOGY, INC. ANY COPIES OF THIS DRAWING OR OTHER INFORMATION CONTAINED HEREIN, IF REQUESTED, WILL BE RETURNED TO CLEAN AIR TECHNOLOGY, INC. ON REQUEST. UNDER THE TERMS OF A CONTRACT OR OTHERWISE, ARE TO BE RETURNED TO CLEAN AIR TECHNOLOGY, INC. IF REQUESTED. CLEAN AIR TECHNOLOGY, INC. WILL ELECT TO TAKE ALL NECESSARY ACTION TO ENFORCE ITS RIGHTS TO THIS PROPRIETARY INFORMATION.

REV.	NUM.	DATE	DESCRIPTION	BY	CHKD	APP'D
01	01	07-18-18	ISSUED FOR CONSTRUCTION	DWS		
02	02	07-18-18	ISSUED FOR CONSTRUCTION	DWS		
03	03	07-18-18	ISSUED FOR CONSTRUCTION	DWS		
04	04	07-18-18	ISSUED FOR CONSTRUCTION	DWS		
05	05	07-18-18	ISSUED FOR CONSTRUCTION	DWS		
06	06	07-18-18	ISSUED FOR CONSTRUCTION	DWS		
07	07	07-18-18	ISSUED FOR CONSTRUCTION	DWS		
08	08	07-18-18	ISSUED FOR CONSTRUCTION	DWS		
09	09	07-18-18	ISSUED FOR CONSTRUCTION	DWS		
10	10	07-18-18	ISSUED FOR CONSTRUCTION	DWS		
11	11	07-18-18	ISSUED FOR CONSTRUCTION	DWS		
12	12	07-18-18	ISSUED FOR CONSTRUCTION	DWS		
13	13	07-18-18	ISSUED FOR CONSTRUCTION	DWS		
14	14	07-18-18	ISSUED FOR CONSTRUCTION	DWS		
15	15	07-18-18	ISSUED FOR CONSTRUCTION	DWS		
16	16	07-18-18	ISSUED FOR CONSTRUCTION	DWS		
17	17	07-18-18	ISSUED FOR CONSTRUCTION	DWS		
18	18	07-18-18	ISSUED FOR CONSTRUCTION	DWS		
19	19	07-18-18	ISSUED FOR CONSTRUCTION	DWS		
20	20	07-18-18	ISSUED FOR CONSTRUCTION	DWS		

CUSTOMER

PROJECT TITLE
USP 797 / USP 800
CLEANROOMS

PROJECT LOCATION

C.A.T. JOB NUMBER
18-142

ORIGINAL DATE:
07-18-18


DRAWN BY:
DWS

SCALE:
NONE


DESCRIPTION:
TYPICAL CLEANROOM
CONSTRUCTION DETAILS

DRAWING #:
CR-110


AS-BUILT DRAWING SET

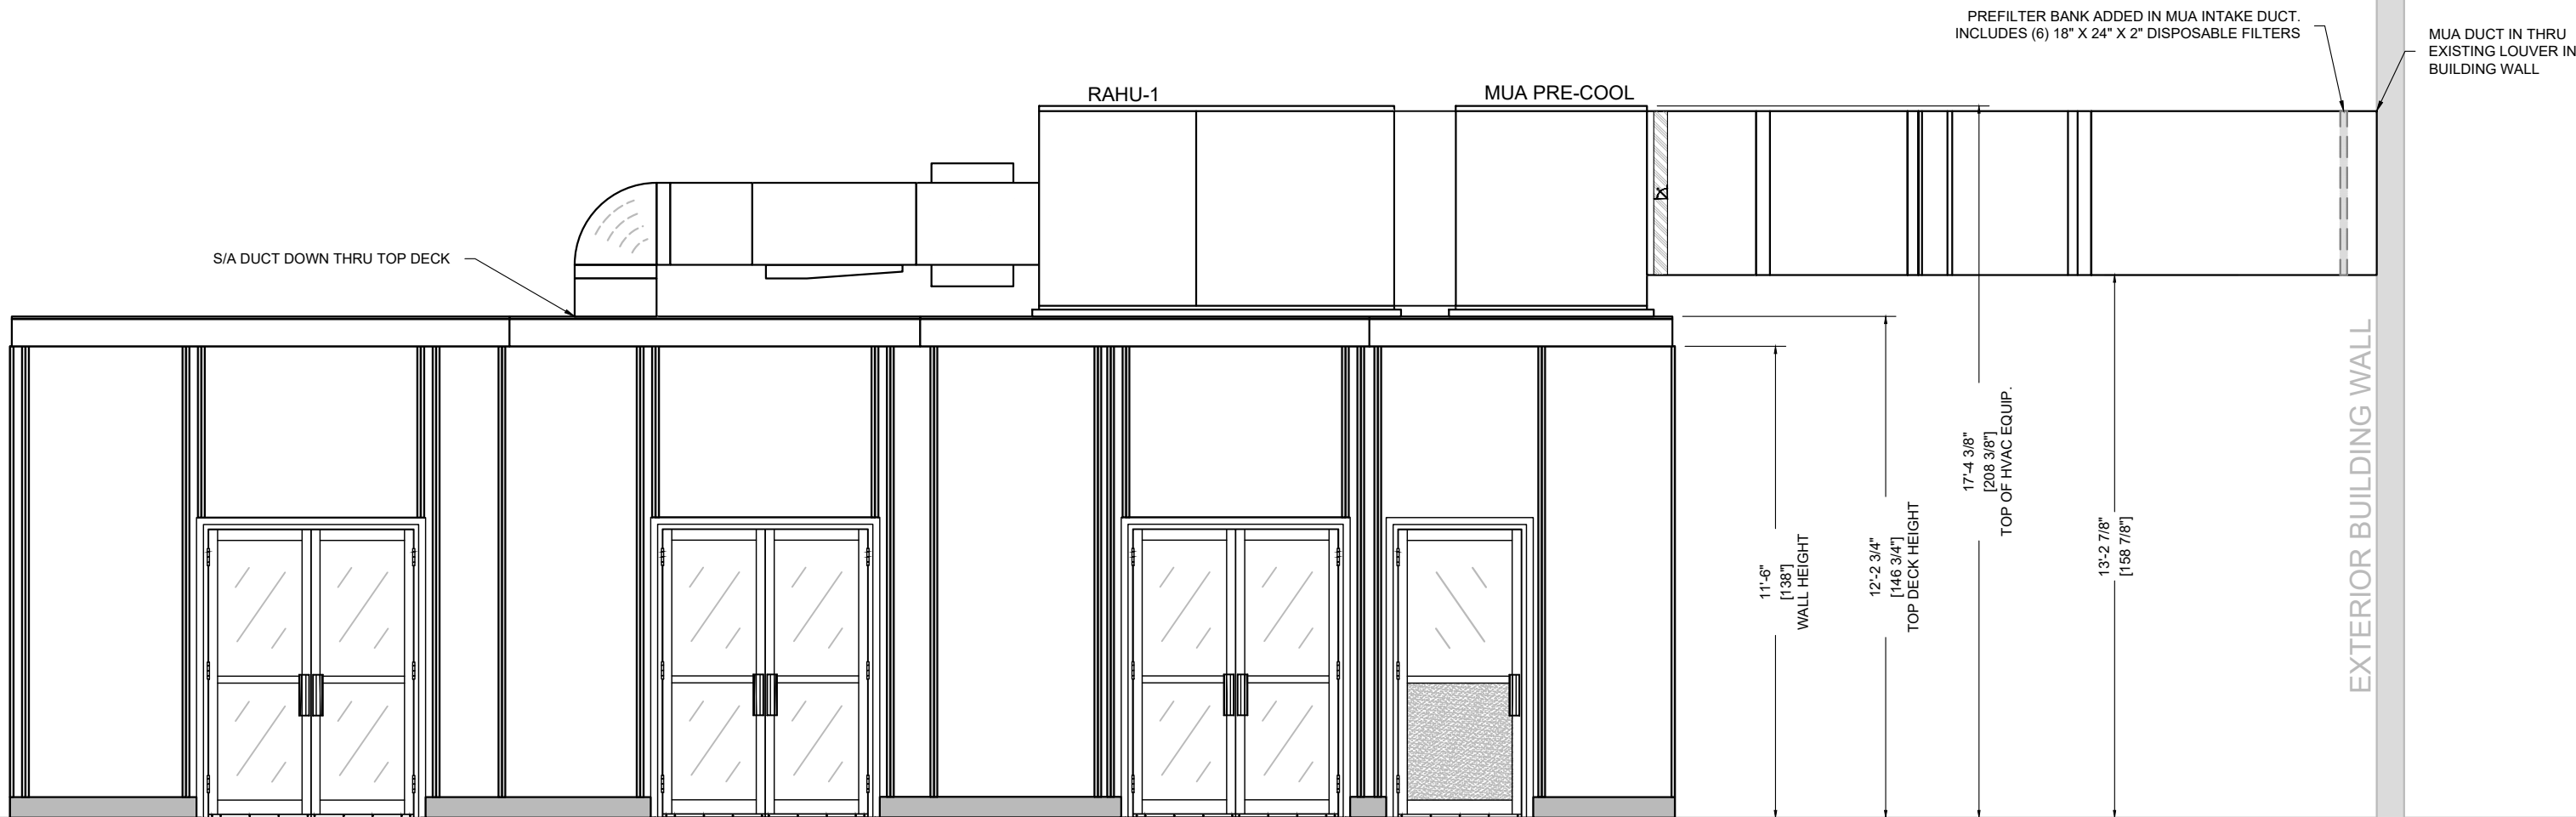

A-A
CR-100, CR-300

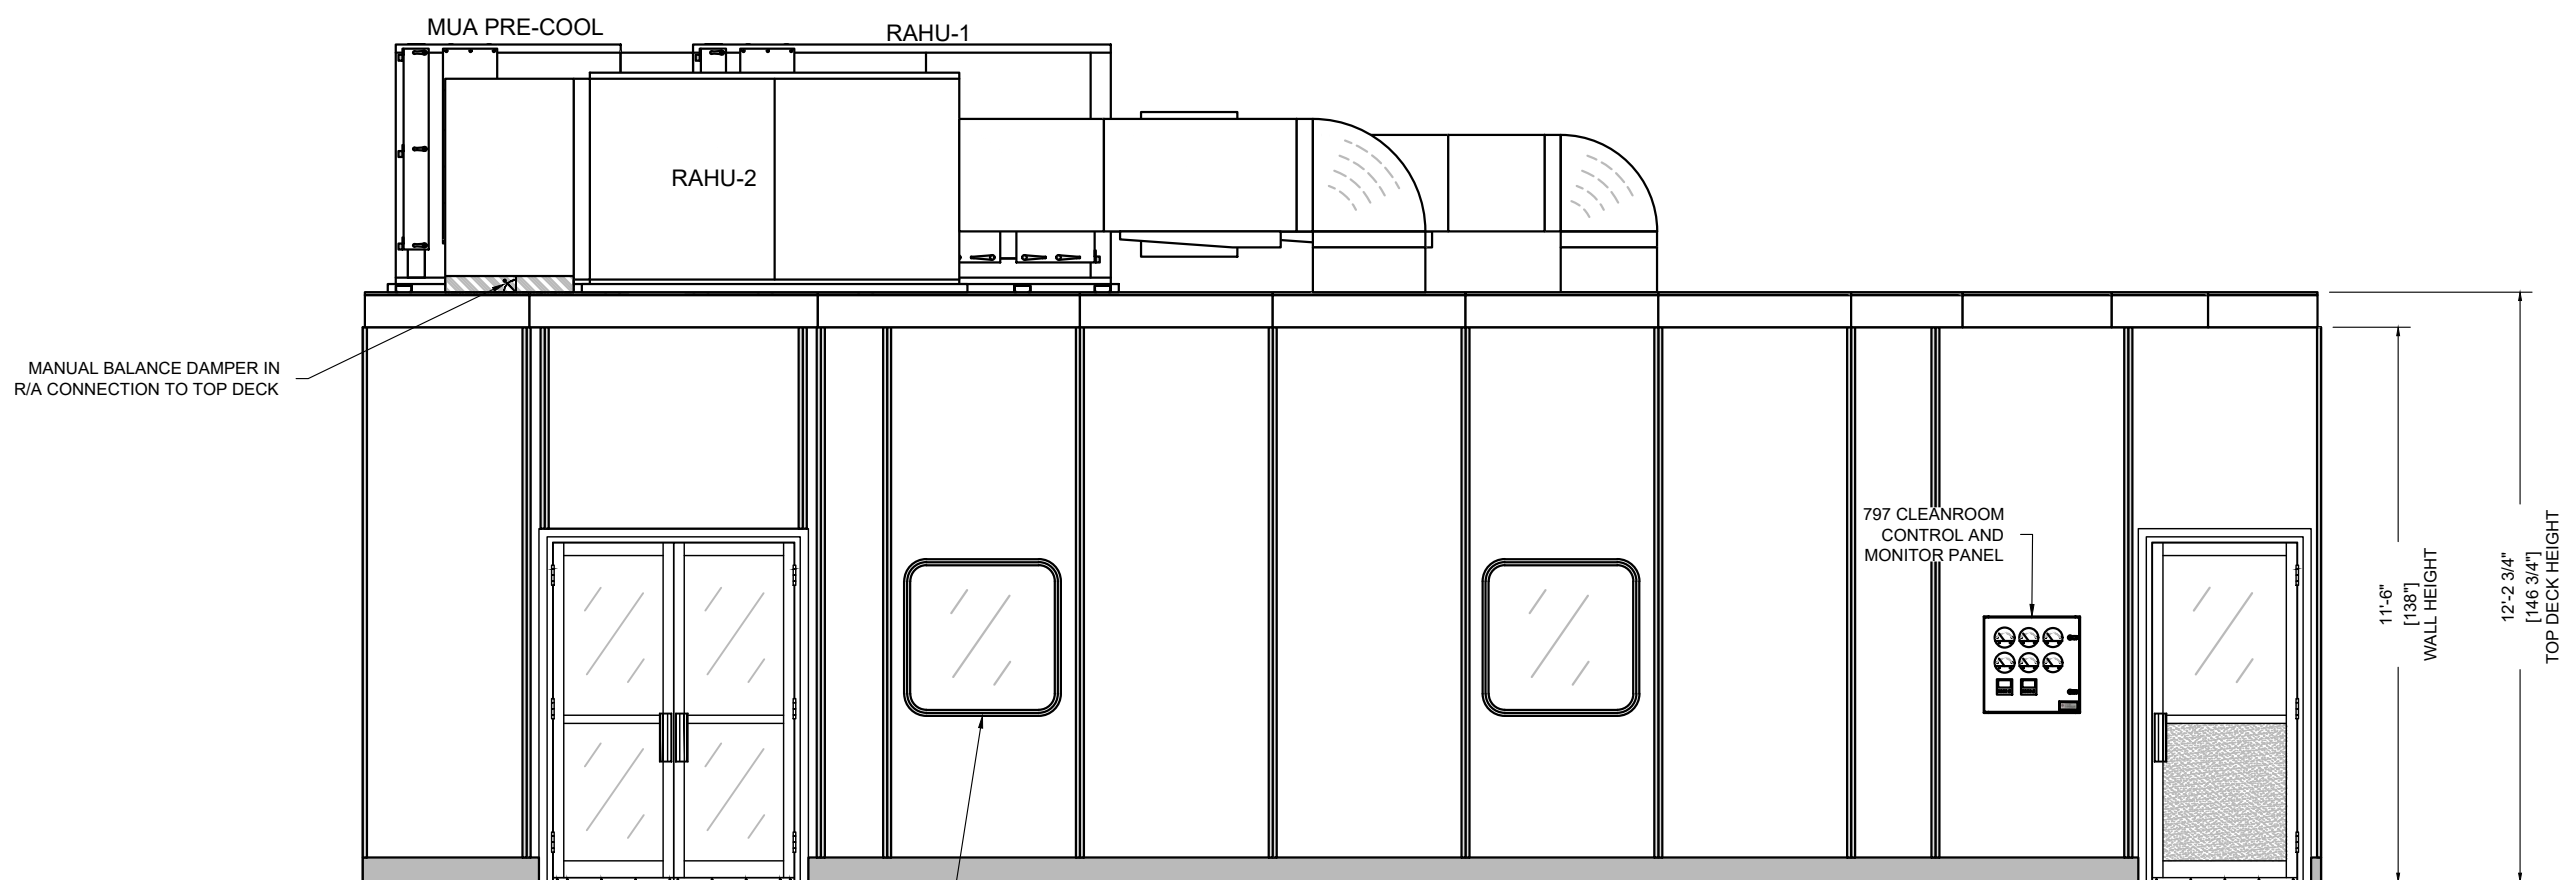


B-B
CR-100, CR-300

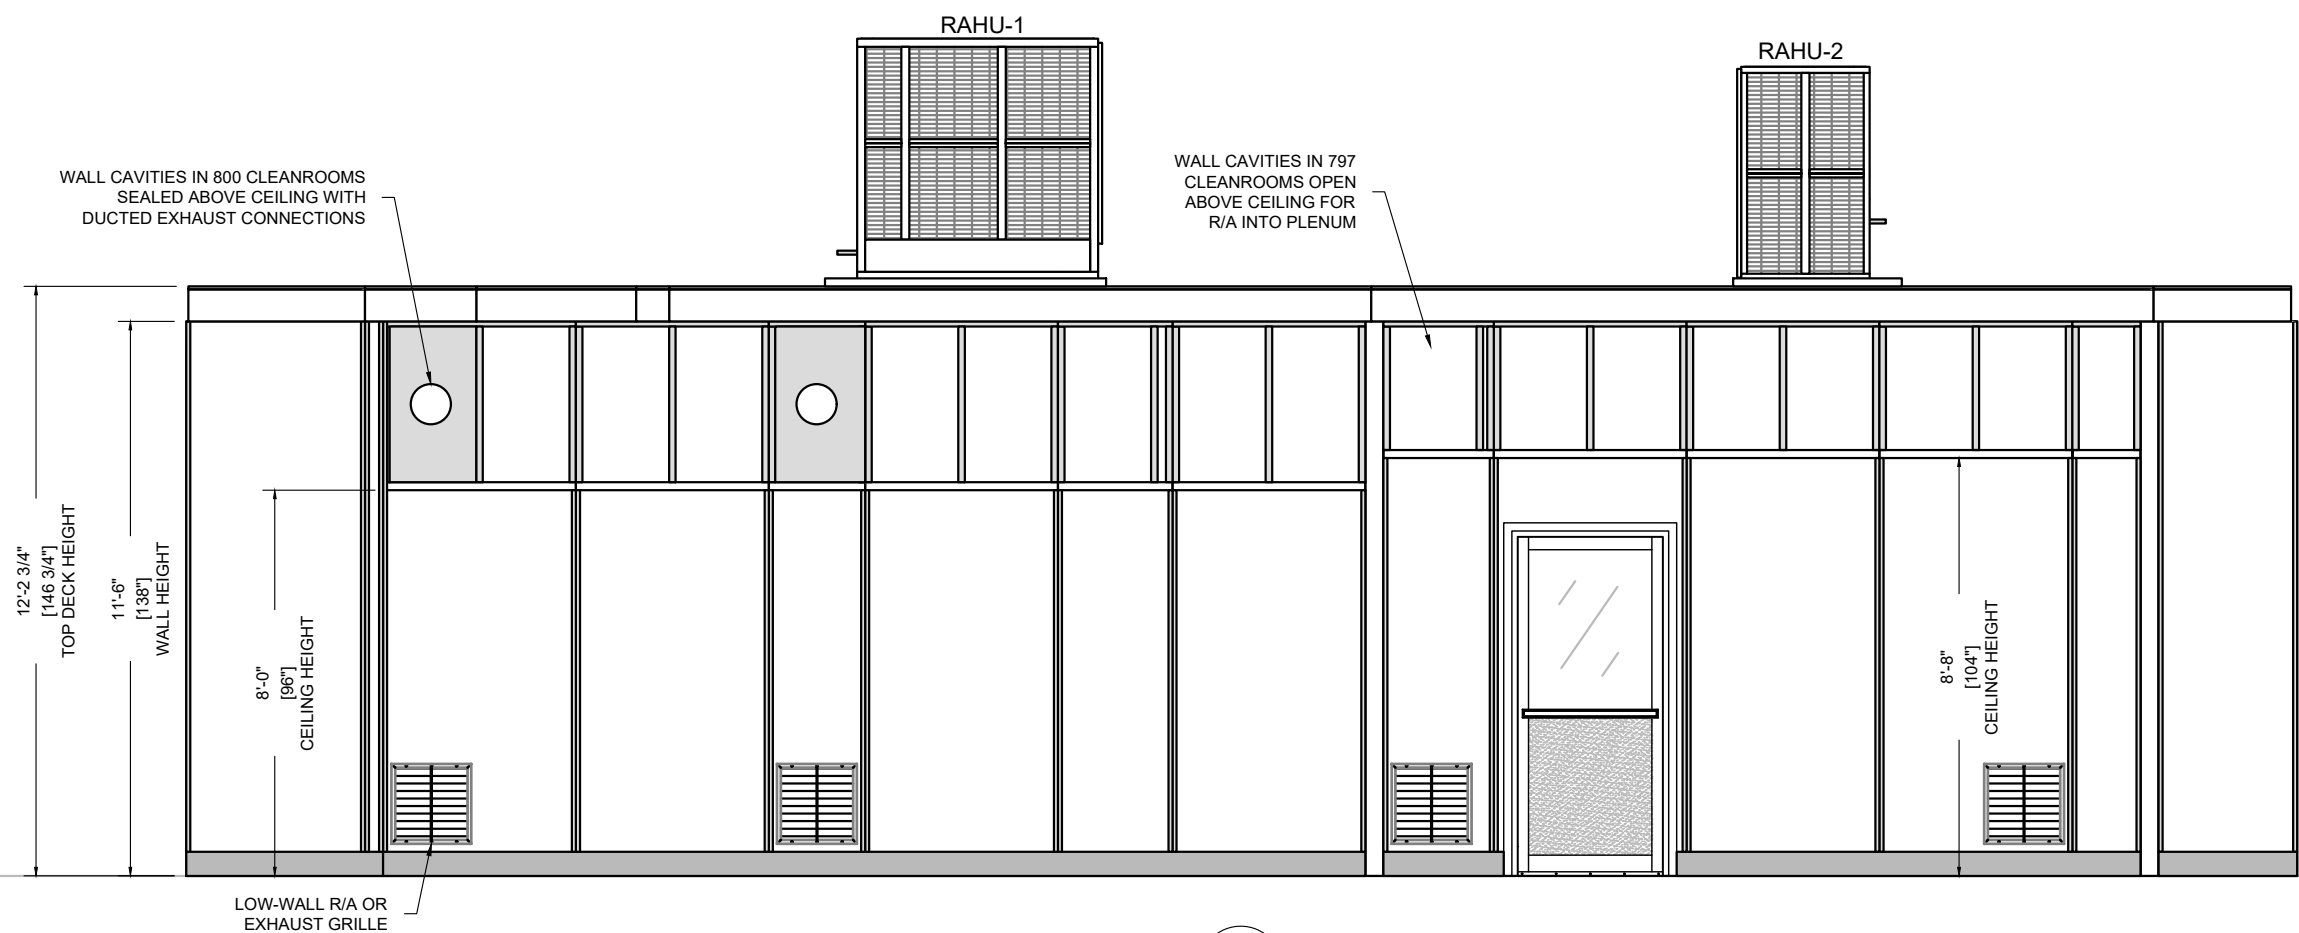

C-C
CR-100, CR-300

AS-BUILT DRAWING SET

CLEAN AIR TECHNOLOGY, INC.
Decades of Experience Building America's Cleanrooms
41105 Capital, Canton, MI 48187 Tel 734-459-6320 Fax 734-459-9437
www.cleanairtechnology.com

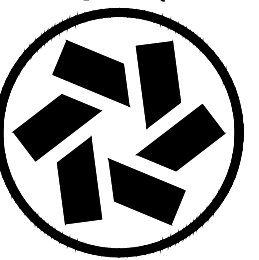

THIS DRAWING CONTAINS DESIGNS AND OTHER INFORMATION
THIS DRAWING MAY NOT BE REPRODUCED OR TRANSMITTED IN ANY FORM OR BY ANY MEANS, ELECTRONIC OR MECHANICAL, WITHOUT THE WRITTEN PERMISSION OF
CLEAN AIR TECHNOLOGY, INC. ANY COPIES OF THIS DRAWING
UNDER THE TERMS OF A CONTRACT OR OTHERWISE ARE TO
BE RETURNED TO CLEAN AIR TECHNOLOGY, INC. ON REQUEST
ACCOMPLISHED. CLEAN AIR TECHNOLOGY, INC. WILL ELECT TO
TAKE ALL NECESSARY ACTION TO ENFORCE ITS RIGHTS TO
THIS PROPRIETARY INFORMATION

REV.	NUM.	REV. DATE	REVISION DESCRIPTION	BY
A	01	02-25-18	REVISED	DWS
B	02	02-26-18	REVISED	DWS
C	03	02-26-18	REVISED	DWS
D	04	02-26-18	REVISED	DWS
E	05	02-26-18	REVISED	DWS
F	06	02-26-18	ISSUED FOR CONSTRUCTION	DWS
G	07	02-26-18	AS-BUILT	DWS
H	08	02-26-18	AS-BUILT REVISIONS	DWS
I	09	02-26-18	AS-BUILT REVISIONS	DWS
J	10	02-26-18	AS-BUILT REVISIONS	DWS
K	11	02-26-18	AS-BUILT REVISIONS	DWS
L	12	02-26-18	AS-BUILT REVISIONS	DWS
M	13	02-26-18	AS-BUILT REVISIONS	DWS
N	14	02-26-18	AS-BUILT REVISIONS	DWS
O	15	02-26-18	AS-BUILT REVISIONS	DWS
P	16	02-26-18	AS-BUILT REVISIONS	DWS
Q	17	02-26-18	AS-BUILT REVISIONS	DWS
R	18	02-26-18	AS-BUILT REVISIONS	DWS
S	19	02-26-18	AS-BUILT REVISIONS	DWS
T	20	02-26-18	AS-BUILT REVISIONS	DWS


CUSTOMER

PROJECT TITLE
USP 797 / USP 800
CLEANROOMS


PROJECT LOCATION

C.A.T. JOB NUMBER	18-142
ORIGINAL DATE:	07-17-18
DRAWN BY:	DWS
SCALE:	1/4" = 1'-0"
DESCRIPTION:	CLEANROOM SECTION VIEWS

 DRAWING #: CR-200



THIS DRAWING CONTAINS DESIGNS AND OTHER INFORMATION WHICH ARE THE PROPERTY OF CLEAN AIR TECHNOLOGY, INC. THIS DRAWING MAY NOT BE IN WHOLE OR IN PART BE REPRODUCED OR USED FOR ANY PURPOSES WITHOUT THE WRITTEN PERMISSION OF CLEAN AIR TECHNOLOGY, INC. ANY COPIES OF THIS DRAWING DISTRIBUTED FOR INFORMATION PURPOSES, WHETHER UNDER THE TERMS OF A CONTRACT OR OTHERWISE, ARE TO BE DESTROYED IMMEDIATELY AFTER THE PROJECT IS ACCOMPLISHED. CLEAN AIR TECHNOLOGY, INC. WILL ELECT TO TAKE ALL NECESSARY ACTION TO ENFORCE ITS RIGHTS TO THIS PROPRIETARY INFORMATION.

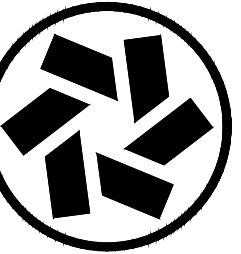

CLEAN AIR TECHNOLOGY, INC.
Decades of Experience Building America's Cleanrooms
41105 Capital, Canton, MI. 48187 Tel 734-459-6320 Fax 734-459-9437
www.cleantechnology.com

REV. NUM.	REV. DATE	REVISED	REVISION DESCRIPTION	BY
A	08-22-18	REVISED		DWS
B	08-22-18	REVISED		DWS
C	09-24-18	REVISED		DWS
D	08-26-18	REVISED		DWS
E	08-26-18	REVISED		DWS
F	09-21-18	ISSUED FOR CONSTRUCTION		DWS
G	09-21-18	ISSUED FOR CONSTRUCTION		DWS
H	01-28-19	AS-BUILT		DWS
I				
J				
K				
L				
M				
N				
O				
P				
Q				
R				
S				
T				
U				
V				
W				
X				
Y				
Z				

CUSTOMER


PROJECT TITLE
JSP 797 / USP 800
CLEANROOMS

PROJECT LOCATION


C.A.T. JOB NUMBER	18-142
ORIGINAL DATE:	07-20-18
DRAWN BY:	DWS
SCALE:	1/4" = 1'-0"

DESCRIPTION:
PARTIAL ELEVATION, SOUTH
EXTERIOR OF BUILDING

DRAWING #:	CR-201
------------	--------

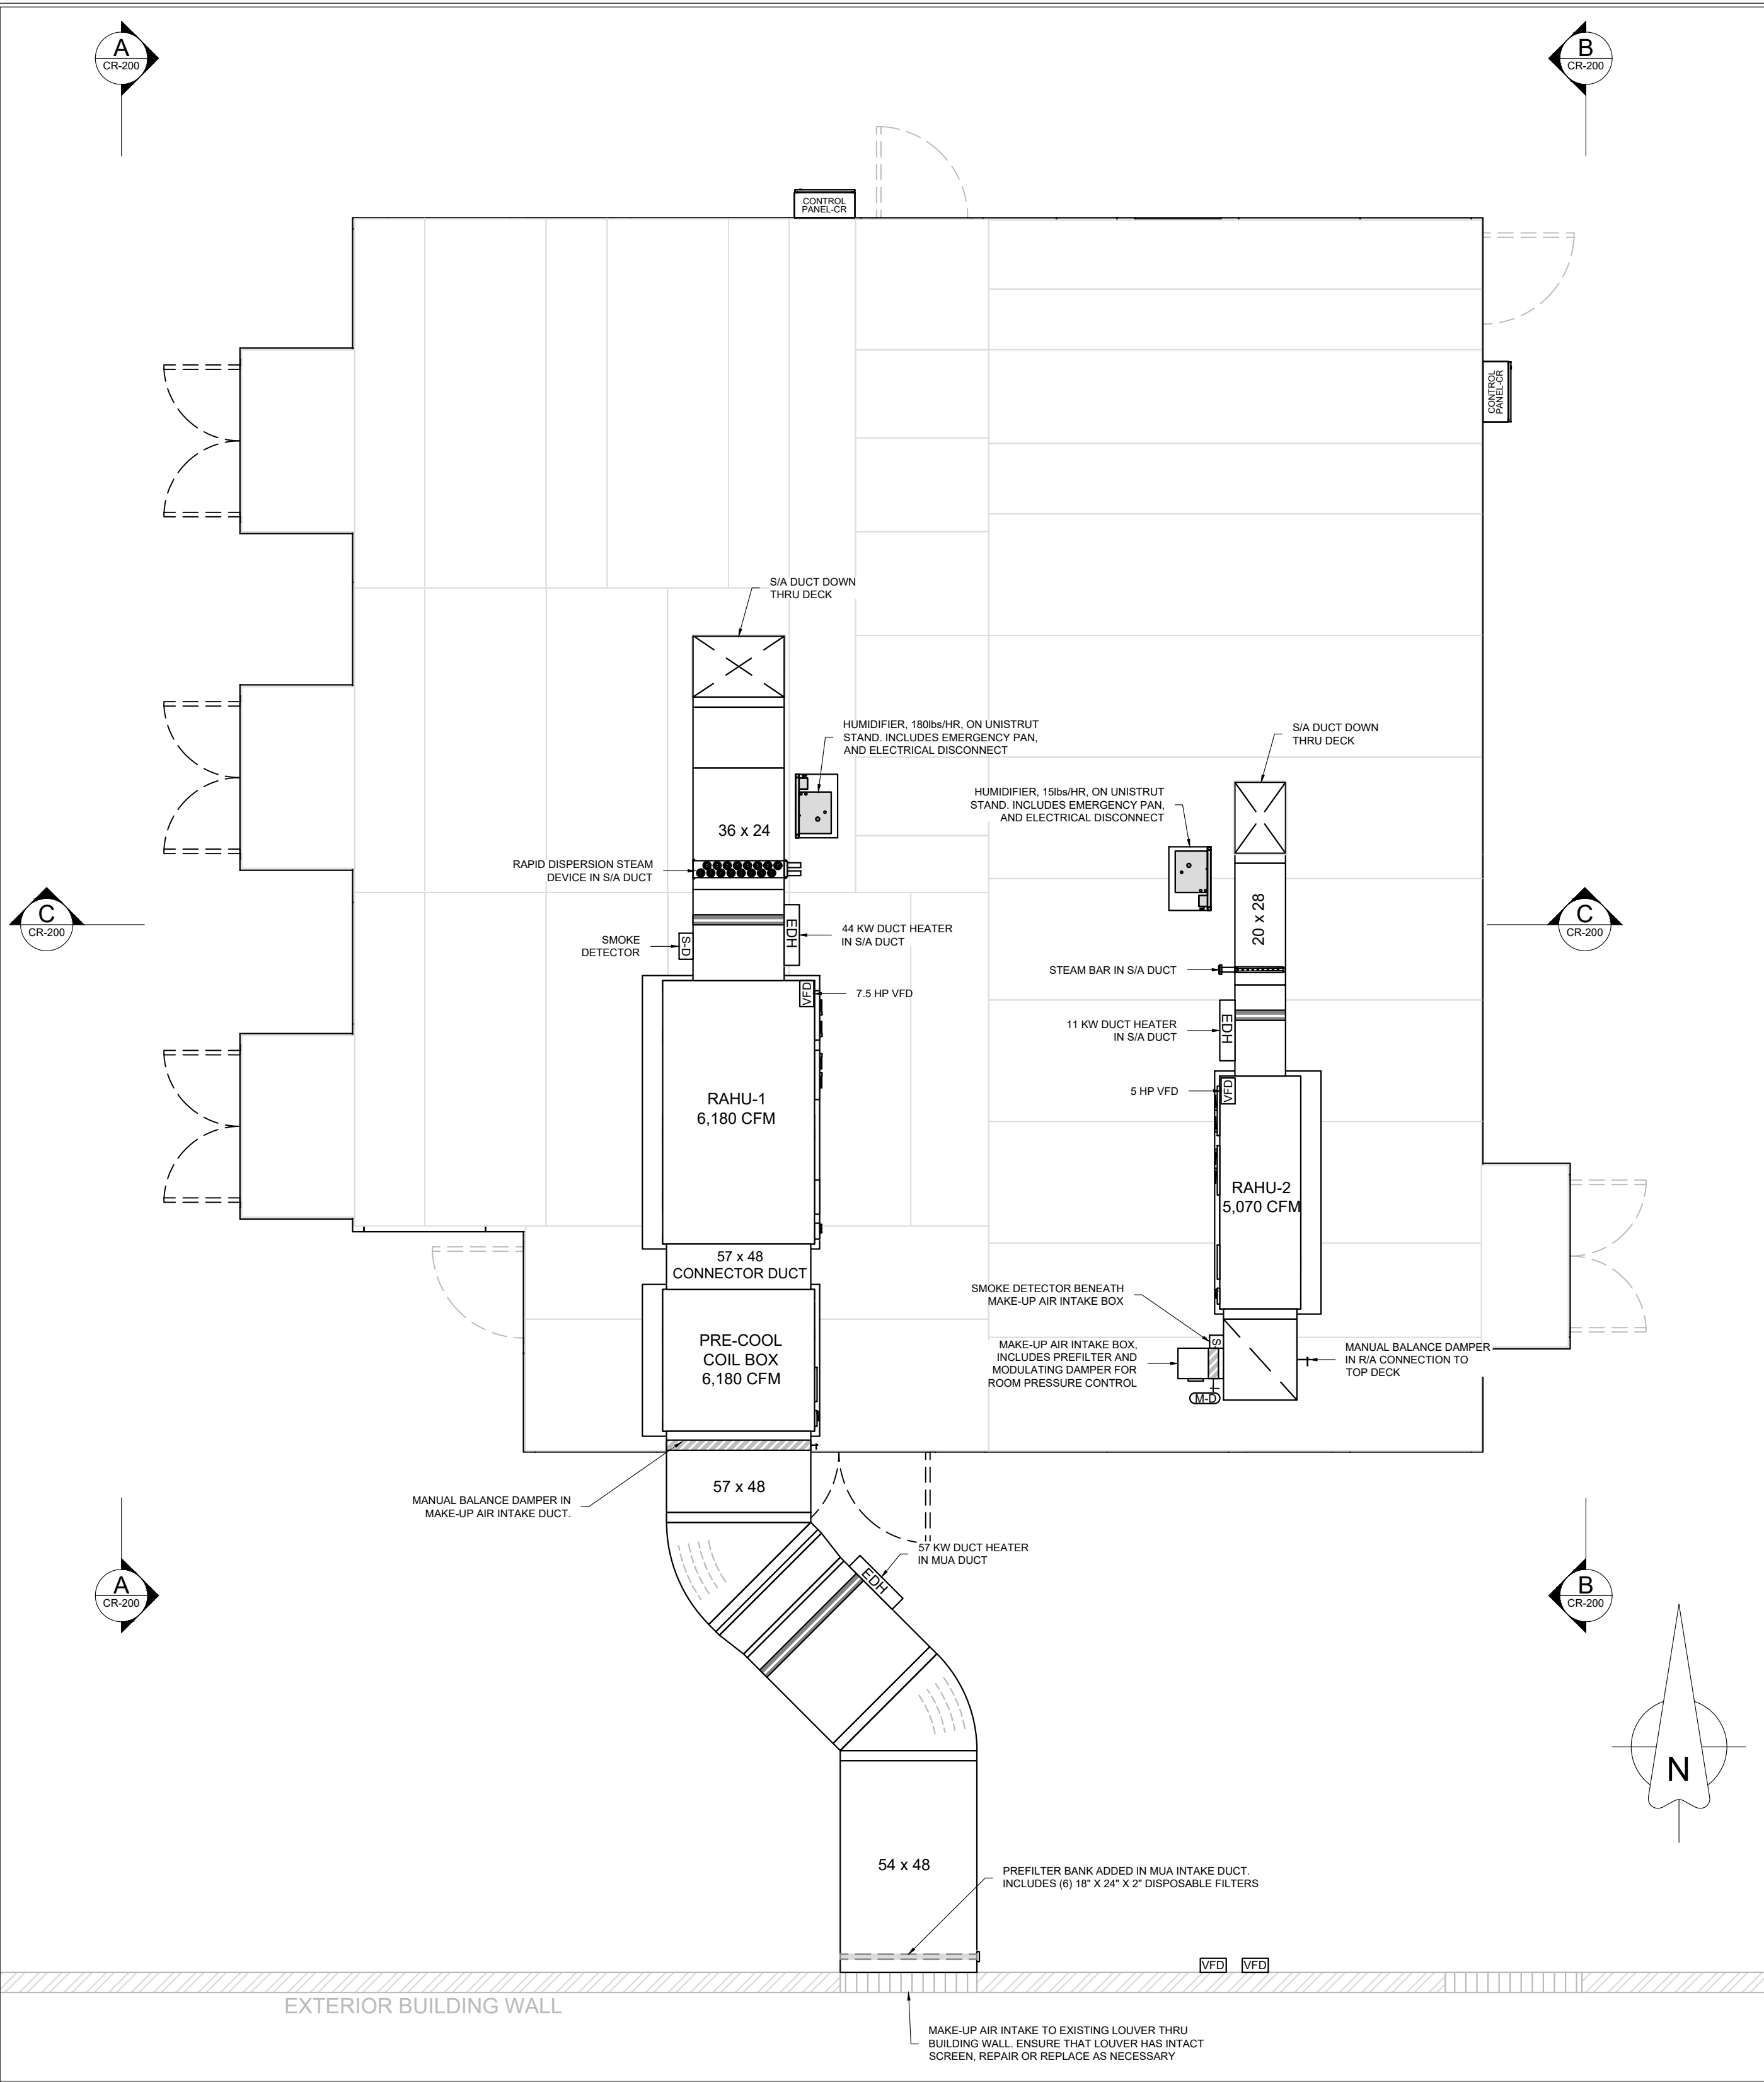

Cleanroom Area Volume and Supply air Data													
Room Name	Class	Area (sq')	Ceiling Height (in.)	Volume (Cu')	Target ACH	Target Airflow Volume (CFM)	HEPA Filter Size	HEPA Filter Quantity	Airflow Per Filter	Face Velocity (FPM)	Design Airflow Volume (CFM)	Design ACH	Make-up Air (Max. CFM)
Cream Room	ISO-7	512	102.00	4,352	60	4,352	24 x 48	7	630	91.57	4,410	60.80	256
Cream Room Gownrom	ISO-8	108	96.00	864	30	432	24 x 48	1	560	81.40	560	38.89	54
Cart Pass-Thru-1	ISO-8	13	96.00	104	30	52	16 x 16	1	100	79.18	100	57.69	100
Sample Room	ISO-7	61	96.00	488	60	488	24 x 36	1	490	97.26	490	60.25	490
Sample Room Gownroom	ISO-7	37	96.00	296	60	296	24 x 24	1	300	93.93	300	60.81	300
Gownroom	ISO-7	87	96.00	696	60	696	24 x 48	1	700	101.74	700	60.34	700
Concentrate Room	ISO-7	216	96.00	1,728	60	1,728	24 x 48	3	585	85.03	1,755	60.94	1755
V-Blend Room	ISO-7	154	96.00	1,232	60	1,232	24 x 48	2	620	90.12	1,240	60.39	1240
Fill/Pack Room	ISO-7	174	96.00	1,392	60	1,392	24 x 36	3	465	92.30	1,395	60.13	1395
Cart Pass-Thru-2	ISO-8	18	96.00	144	30	72	16 x 16	1	100	79.18	100	41.67	100
Cart Pass-Thru-3	ISO-8	18	96.00	144	30	72	16 x 16	1	100	79.18	100	41.67	100
Cart Pass-Thru-4	ISO-8	18	96.00	144	30	72	16 x 16	1	100	79.18	100	41.67	100

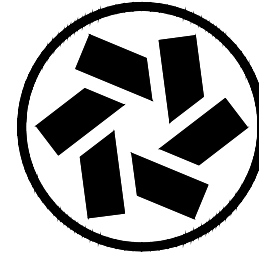

CLEAN AIR TECHNOLOGY, INC.
Decades of Experience Building America's Cleanrooms
41105 Capital, Canton, MI 48187 Tel 734-459-6320 Fax 734-459-9437
www.cleanairtechnology.com

THIS DRAWING CONTAINS DESIGNS AND OTHER INFORMATION WHICH ARE THE PROPERTY OF CLEAN AIR TECHNOLOGY, INC. THIS DRAWING MAY NOT BE REPRODUCED OR TRANSMITTED IN ANY FORM OR BY ANY MEANS, ELECTRONIC OR MECHANICAL, INCLUDING PHOTOCOPYING, RECORDING, OR BY ANY INFORMATION STORAGE AND RETRIEVAL SYSTEM, WITHOUT THE WRITTEN PERMISSION OF CLEAN AIR TECHNOLOGY, INC. ANY COPIES OF THIS DRAWING MADE WITHOUT THE WRITTEN PERMISSION OF CLEAN AIR TECHNOLOGY, INC. ARE TO BE RETURNED TO CLEAN AIR TECHNOLOGY, INC. ON REQUEST. CLEAN AIR TECHNOLOGY, INC. WILL ELECT TO TAKE ALL NECESSARY ACTION TO ENFORCE ITS RIGHTS TO THIS PROPRIETARY INFORMATION.

REV.	NUM.	REV. DATE	REVISION DESCRIPTION
A	01	05-15-18	REVISED
B	02	05-17-18	REVISED
C	03	05-26-18	REVISED
D	04	05-30-18	REVISED
E	05	06-01-18	REVISED
F	06	05-12-18	ISSUED FOR CONSTRUCTION
G	07	01-28-19	AS-BUILT
H	08	02-05-19	AS-BUILT REVISIONS
I	09	01-31-20	AS-BUILT REVISIONS
J	10		
K	11		
L	12		
M	13		
N	14		
O	15		
P	16		
Q	17		
R	18		
S	19		
T	20		
U	21		
V	22		
W	23		
X	24		
Y	25		
Z	26		



CUSTOMER

PROJECT TITLE
USP 797 / USP 800
CLEANROOMS


PROJECT LOCATION

C.A.T. JOB NUMBER	18-142
ORIGINAL DATE:	05-08-18
DRAWN BY:	DWS
SCALE:	1/4" = 1'-0"
DESCRIPTION:	MECHANICAL EQUIPMENT AND DUCTWORK
DRAWING #:	CR-300

AS-BUILT DRAWING SET

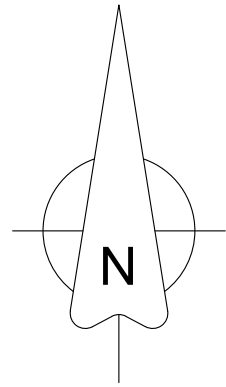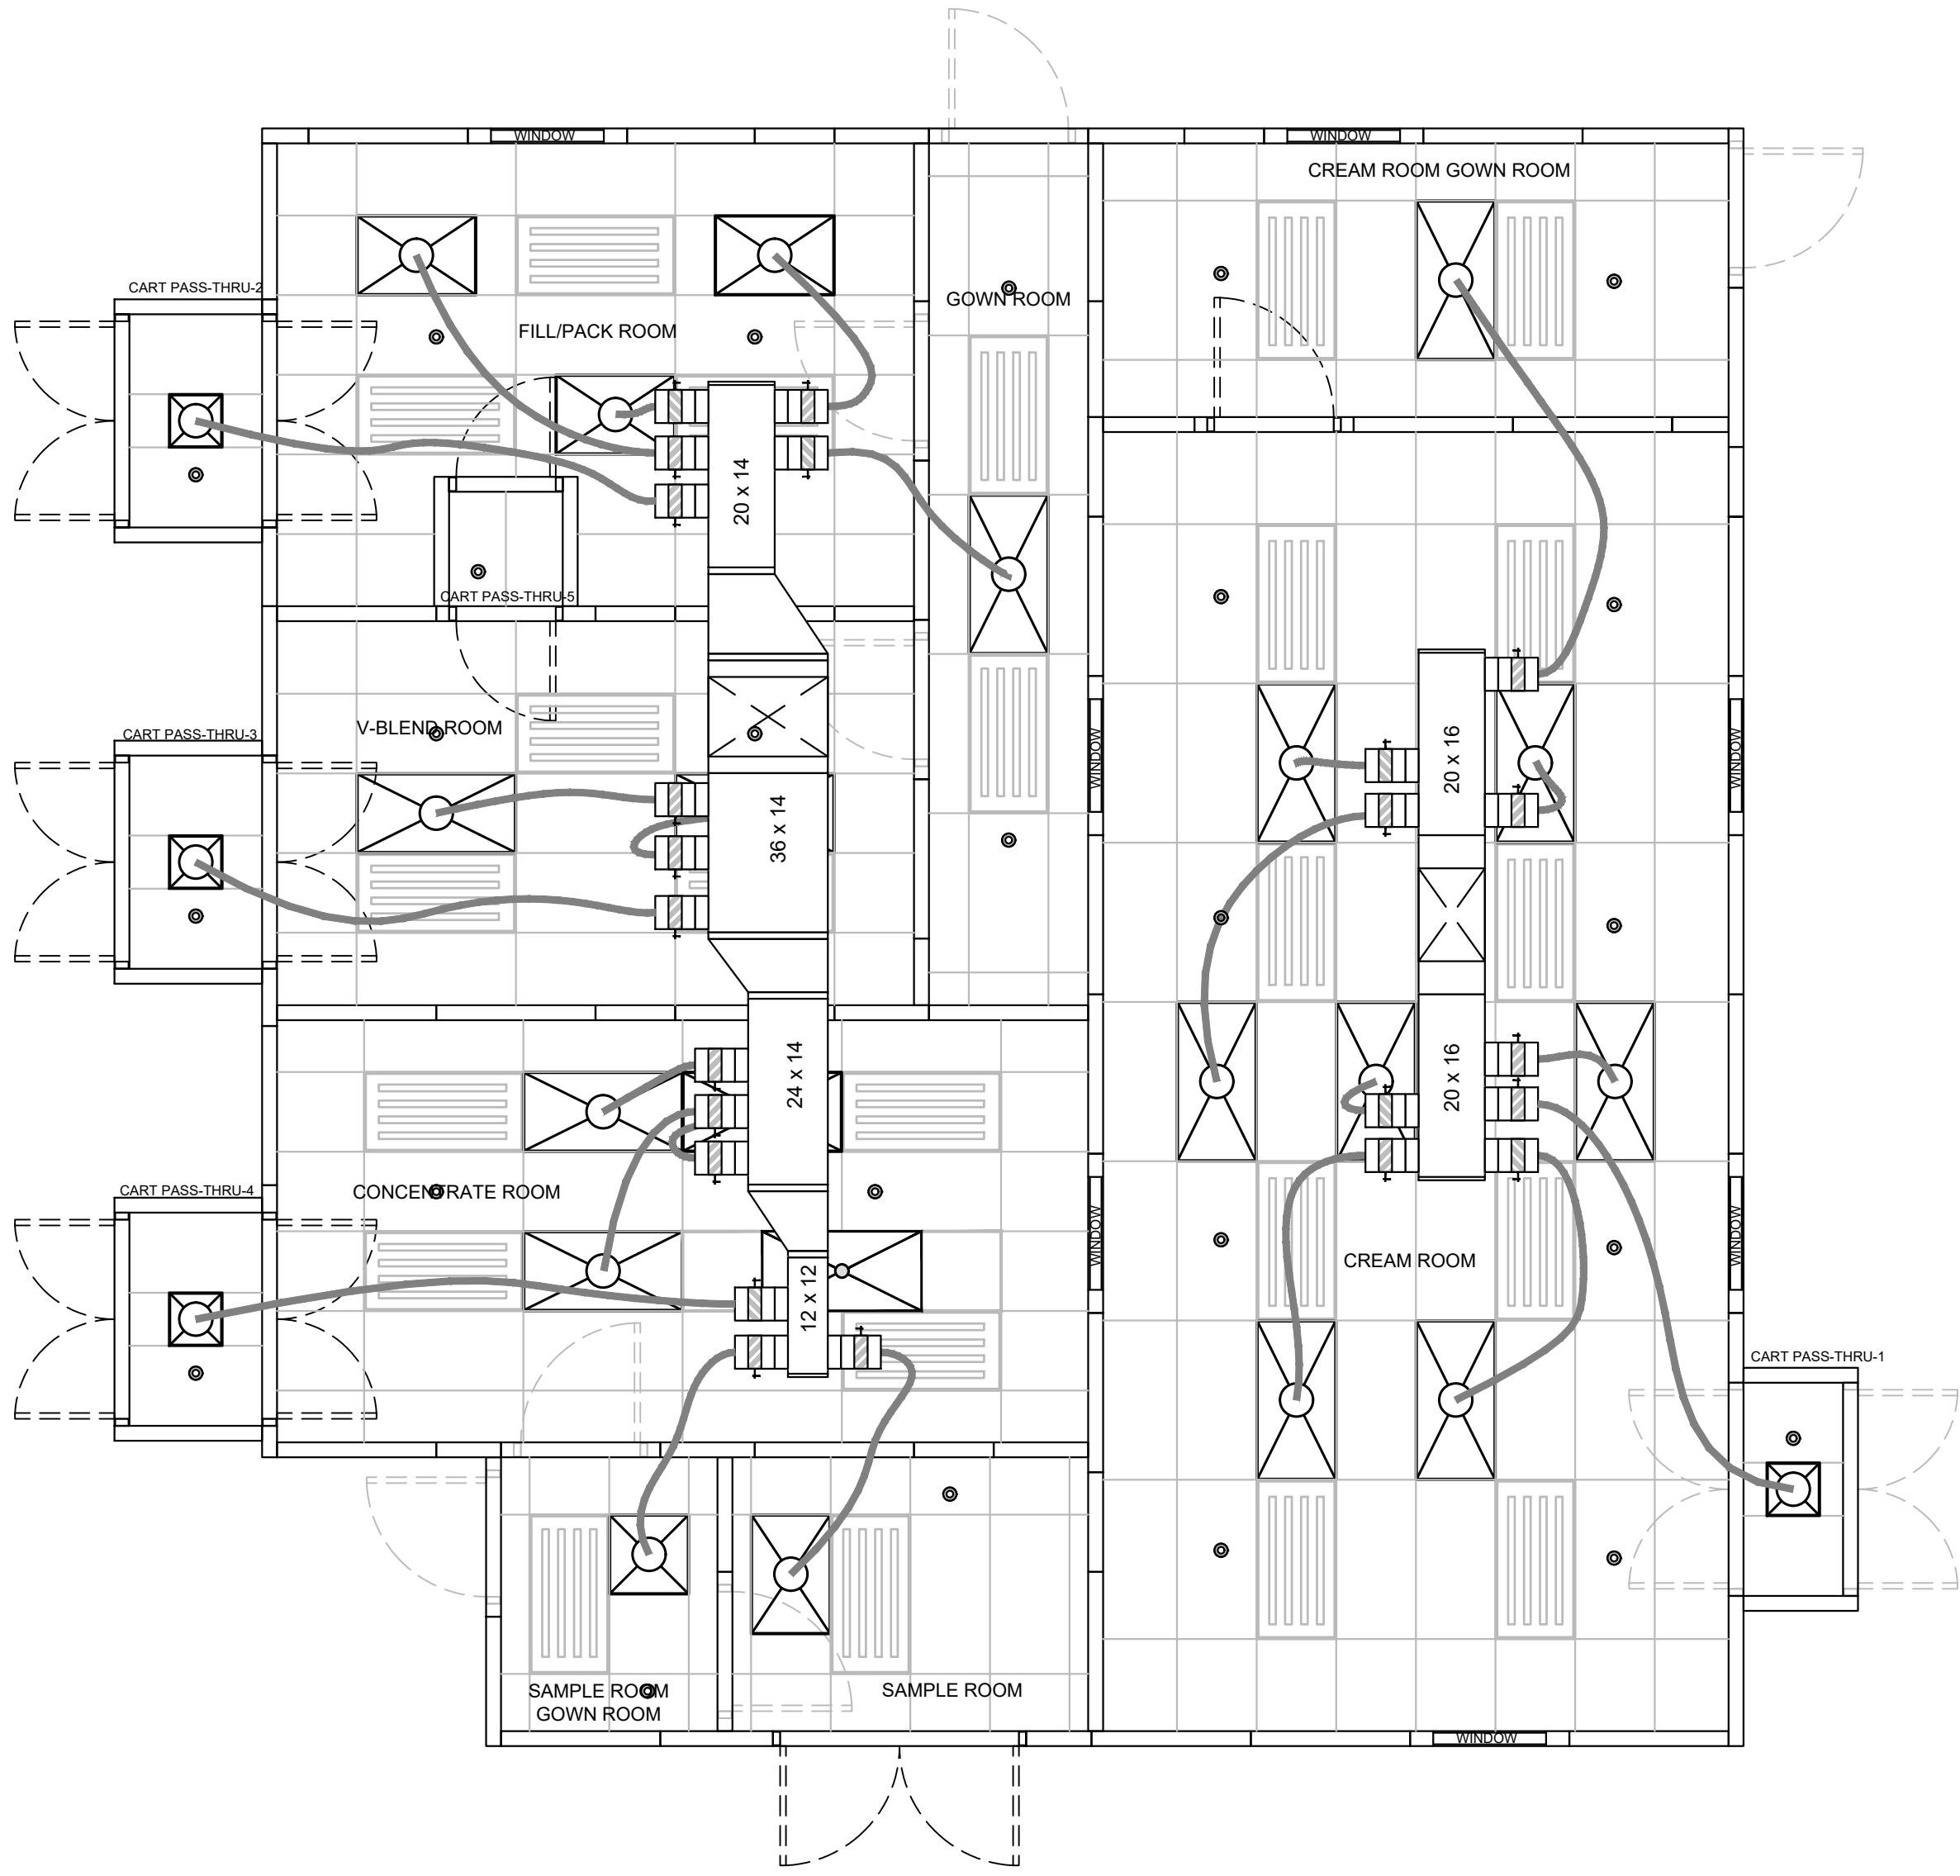

 - NOTES:
- 1. NEW CLEANROOM WALLS ARE 11'-6" TALL
 - 2. ALL CART PASS-THRU'S ARE CLASS ISO-8



CEILING GRID MOUNTED TERMINAL HEPA FILTER MODULE. SEE CHART, THIS DRAWING, FOR FILTER SIZES AND AIRFLOW SPECIFICS

- LOCATION OF FIRE-SUPPRESSION SPRINKLER HEAD

Cleanroom Area Volume and Supply air Data												
Room Name	Class	Area (sq')	Ceiling Height (in.)	Volume (Cu')	Target ACH	Target Airflow Volume (CFM)	HEPA Filter Size	HEPA Filter Quantity	Airflow Per Filter	Face Velocity (FPM)	Design Airflow Volume (CFM)	Design ACH
Cream Room	ISO-7	512	102.00	4,352	60	4,352	24 x 48	7	630	91.57	4,410	60.80
Cream Room Gownrom	ISO-8	108	96.00	864	30	432	24 x 48	1	560	81.40	560	38.89
Cart Pass-Thru-1	ISO-8	13	96.00	104	30	52	16 x 16	1	100	79.18	100	57.69
Sample Room	ISO-7	61	96.00	488	60	488	24 x 36	1	490	97.26	490	60.25
Sample Room Gownroom	ISO-7	37	96.00	296	60	296	24 x 24	1	300	93.93	300	60.81
Gownroom	ISO-7	87	96.00	696	60	696	24 x 48	1	700	101.74	700	60.34
Concentrate Room	ISO-7	216	96.00	1,728	60	1,728	24 x 48	3	585	85.03	1,755	60.94
V-Blend Room	ISO-7	154	96.00	1,232	60	1,232	24 x 48	2	620	90.12	1,240	60.39
Fill/Pack Room	ISO-7	174	96.00	1,392	60	1,392	24 x 36	3	465	92.30	1,395	60.13
Cart Pass-Thru-2	ISO-8	18	96.00	144	30	72	16 x 16	1	100	79.18	100	41.67
Cart Pass-Thru-3	ISO-8	18	96.00	144	30	72	16 x 16	1	100	79.18	100	41.67
Cart Pass-Thru-4	ISO-8	18	96.00	144	30	72	16 x 16	1	100	79.18	100	41.67

THIS DRAWING CONTAINS DESIGNS AND OTHER INFORMATION THAT ARE THE PROPERTY OF CLEAN AIR TECHNOLOGY, INC. THIS DRAWING MAY NOT BE REPRODUCED, COPIED, OR IN PART, BE USED FOR ANY OTHER PROJECT WITHOUT THE WRITTEN PERMISSION OF CLEAN AIR TECHNOLOGY, INC. ANY COPIES OF THIS DRAWING OR ANY PART THEREOF THAT ARE NOT THE PROPERTY OF CLEAN AIR TECHNOLOGY, INC. ARE TO BE RETURNED TO CLEAN AIR TECHNOLOGY, INC. ON REQUEST. CLEAN AIR TECHNOLOGY, INC. WILL ELECT TO TAKE ALL NECESSARY ACTION TO ENFORCE ITS RIGHTS TO THIS PROPRIETARY INFORMATION.

REV.	NUM.	DATE	DESCRIPTION
A	01	08-17-18	ISSUED FOR CONSTRUCTION
B	02	09-10-18	REVISED
C	03	09-12-18	ISSUED FOR CONSTRUCTION
D	04	09-12-18	REVISED
E	05	09-12-18	REVISED
F	06	09-12-18	REVISED
G	07	09-12-18	REVISED
H	08	09-12-18	REVISED
I	09	09-12-18	REVISED
J	10	09-12-18	REVISED
K	11	09-12-18	REVISED
L	12	09-12-18	REVISED
M	13	09-12-18	REVISED
N	14	09-12-18	REVISED
O	15	09-12-18	REVISED
P	16	09-12-18	REVISED
Q	17	09-12-18	REVISED
R	18	09-12-18	REVISED
S	19	09-12-18	REVISED
T	20	09-12-18	REVISED
U	21	09-12-18	REVISED
V	22	09-12-18	REVISED
W	23	09-12-18	REVISED
X	24	09-12-18	REVISED
Y	25	09-12-18	REVISED
Z	26	09-12-18	REVISED
AA	27	09-12-18	REVISED
AB	28	09-12-18	REVISED
AC	29	09-12-18	REVISED
AD	30	09-12-18	REVISED
AE	31	09-12-18	REVISED
AF	32	09-12-18	REVISED
AG	33	09-12-18	REVISED
AH	34	09-12-18	REVISED
AI	35	09-12-18	REVISED
AJ	36	09-12-18	REVISED
AK	37	09-12-18	REVISED
AL	38	09-12-18	REVISED
AM	39	09-12-18	REVISED
AN	40	09-12-18	REVISED
AO	41	09-12-18	REVISED
AP	42	09-12-18	REVISED
AQ	43	09-12-18	REVISED
AR	44	09-12-18	REVISED
AS	45	09-12-18	REVISED
AT	46	09-12-18	REVISED
AU	47	09-12-18	REVISED
AV	48	09-12-18	REVISED
AW	49	09-12-18	REVISED
AX	50	09-12-18	REVISED
AY	51	09-12-18	REVISED
AZ	52	09-12-18	REVISED
BA	53	09-12-18	REVISED
BB	54	09-12-18	REVISED
BC	55	09-12-18	REVISED
BD	56	09-12-18	REVISED
BE	57	09-12-18	REVISED
BF	58	09-12-18	REVISED
BG	59	09-12-18	REVISED
BH	60	09-12-18	REVISED
BI	61	09-12-18	REVISED
BJ	62	09-12-18	REVISED
BK	63	09-12-18	REVISED
BL	64	09-12-18	REVISED
BM	65	09-12-18	REVISED
BN	66	09-12-18	REVISED
BO	67	09-12-18	REVISED
BP	68	09-12-18	REVISED
BQ	69	09-12-18	REVISED
BR	70	09-12-18	REVISED
BS	71	09-12-18	REVISED
BT	72	09-12-18	REVISED
BU	73	09-12-18	REVISED
BV	74	09-12-18	REVISED
BW	75	09-12-18	REVISED
BX	76	09-12-18	REVISED
BY	77	09-12-18	REVISED
BZ	78	09-12-18	REVISED
CA	79	09-12-18	REVISED
CB	80	09-12-18	REVISED
CC	81	09-12-18	REVISED
CD	82	09-12-18	REVISED
CE	83	09-12-18	REVISED
CF	84	09-12-18	REVISED
CG	85	09-12-18	REVISED
CH	86	09-12-18	REVISED
CI	87	09-12-18	REVISED
CJ	88	09-12-18	REVISED
CK	89	09-12-18	REVISED
CL	90	09-12-18	REVISED
CM	91	09-12-18	REVISED
CN	92	09-12-18	REVISED
CO	93	09-12-18	REVISED
CP	94	09-12-18	REVISED
CQ	95	09-12-18	REVISED
CR	96	09-12-18	REVISED
CS	97	09-12-18	REVISED
CT	98	09-12-18	REVISED
CU	99	09-12-18	REVISED
CV	100	09-12-18	REVISED

CUSTOMER

PROJECT TITLE
USP 797 / USP 800
CLEANROOMS

PROJECT LOCATION


C.A.T. JOB NUMBER 18-142
ORIGINAL DATE: 07-18-18
DRAWN BY: DWS
SCALE: 1/4" = 1'-0"



DESCRIPTION:
DUCTWORK BELOW
DECK IN PLENUM

DRAWING #: CR-301

AS-BUILT DRAWING SET

CLEAN AIR TECHNOLOGY, INC.
Decades of Experience Building America's Cleanrooms
41105 Capital, Canton, MI 48187 Tel 734-459-6320 Fax 734-459-9437
www.cleanairtechnology.com

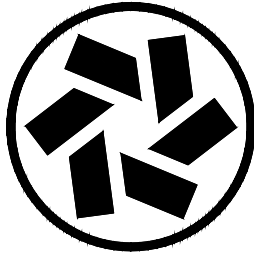


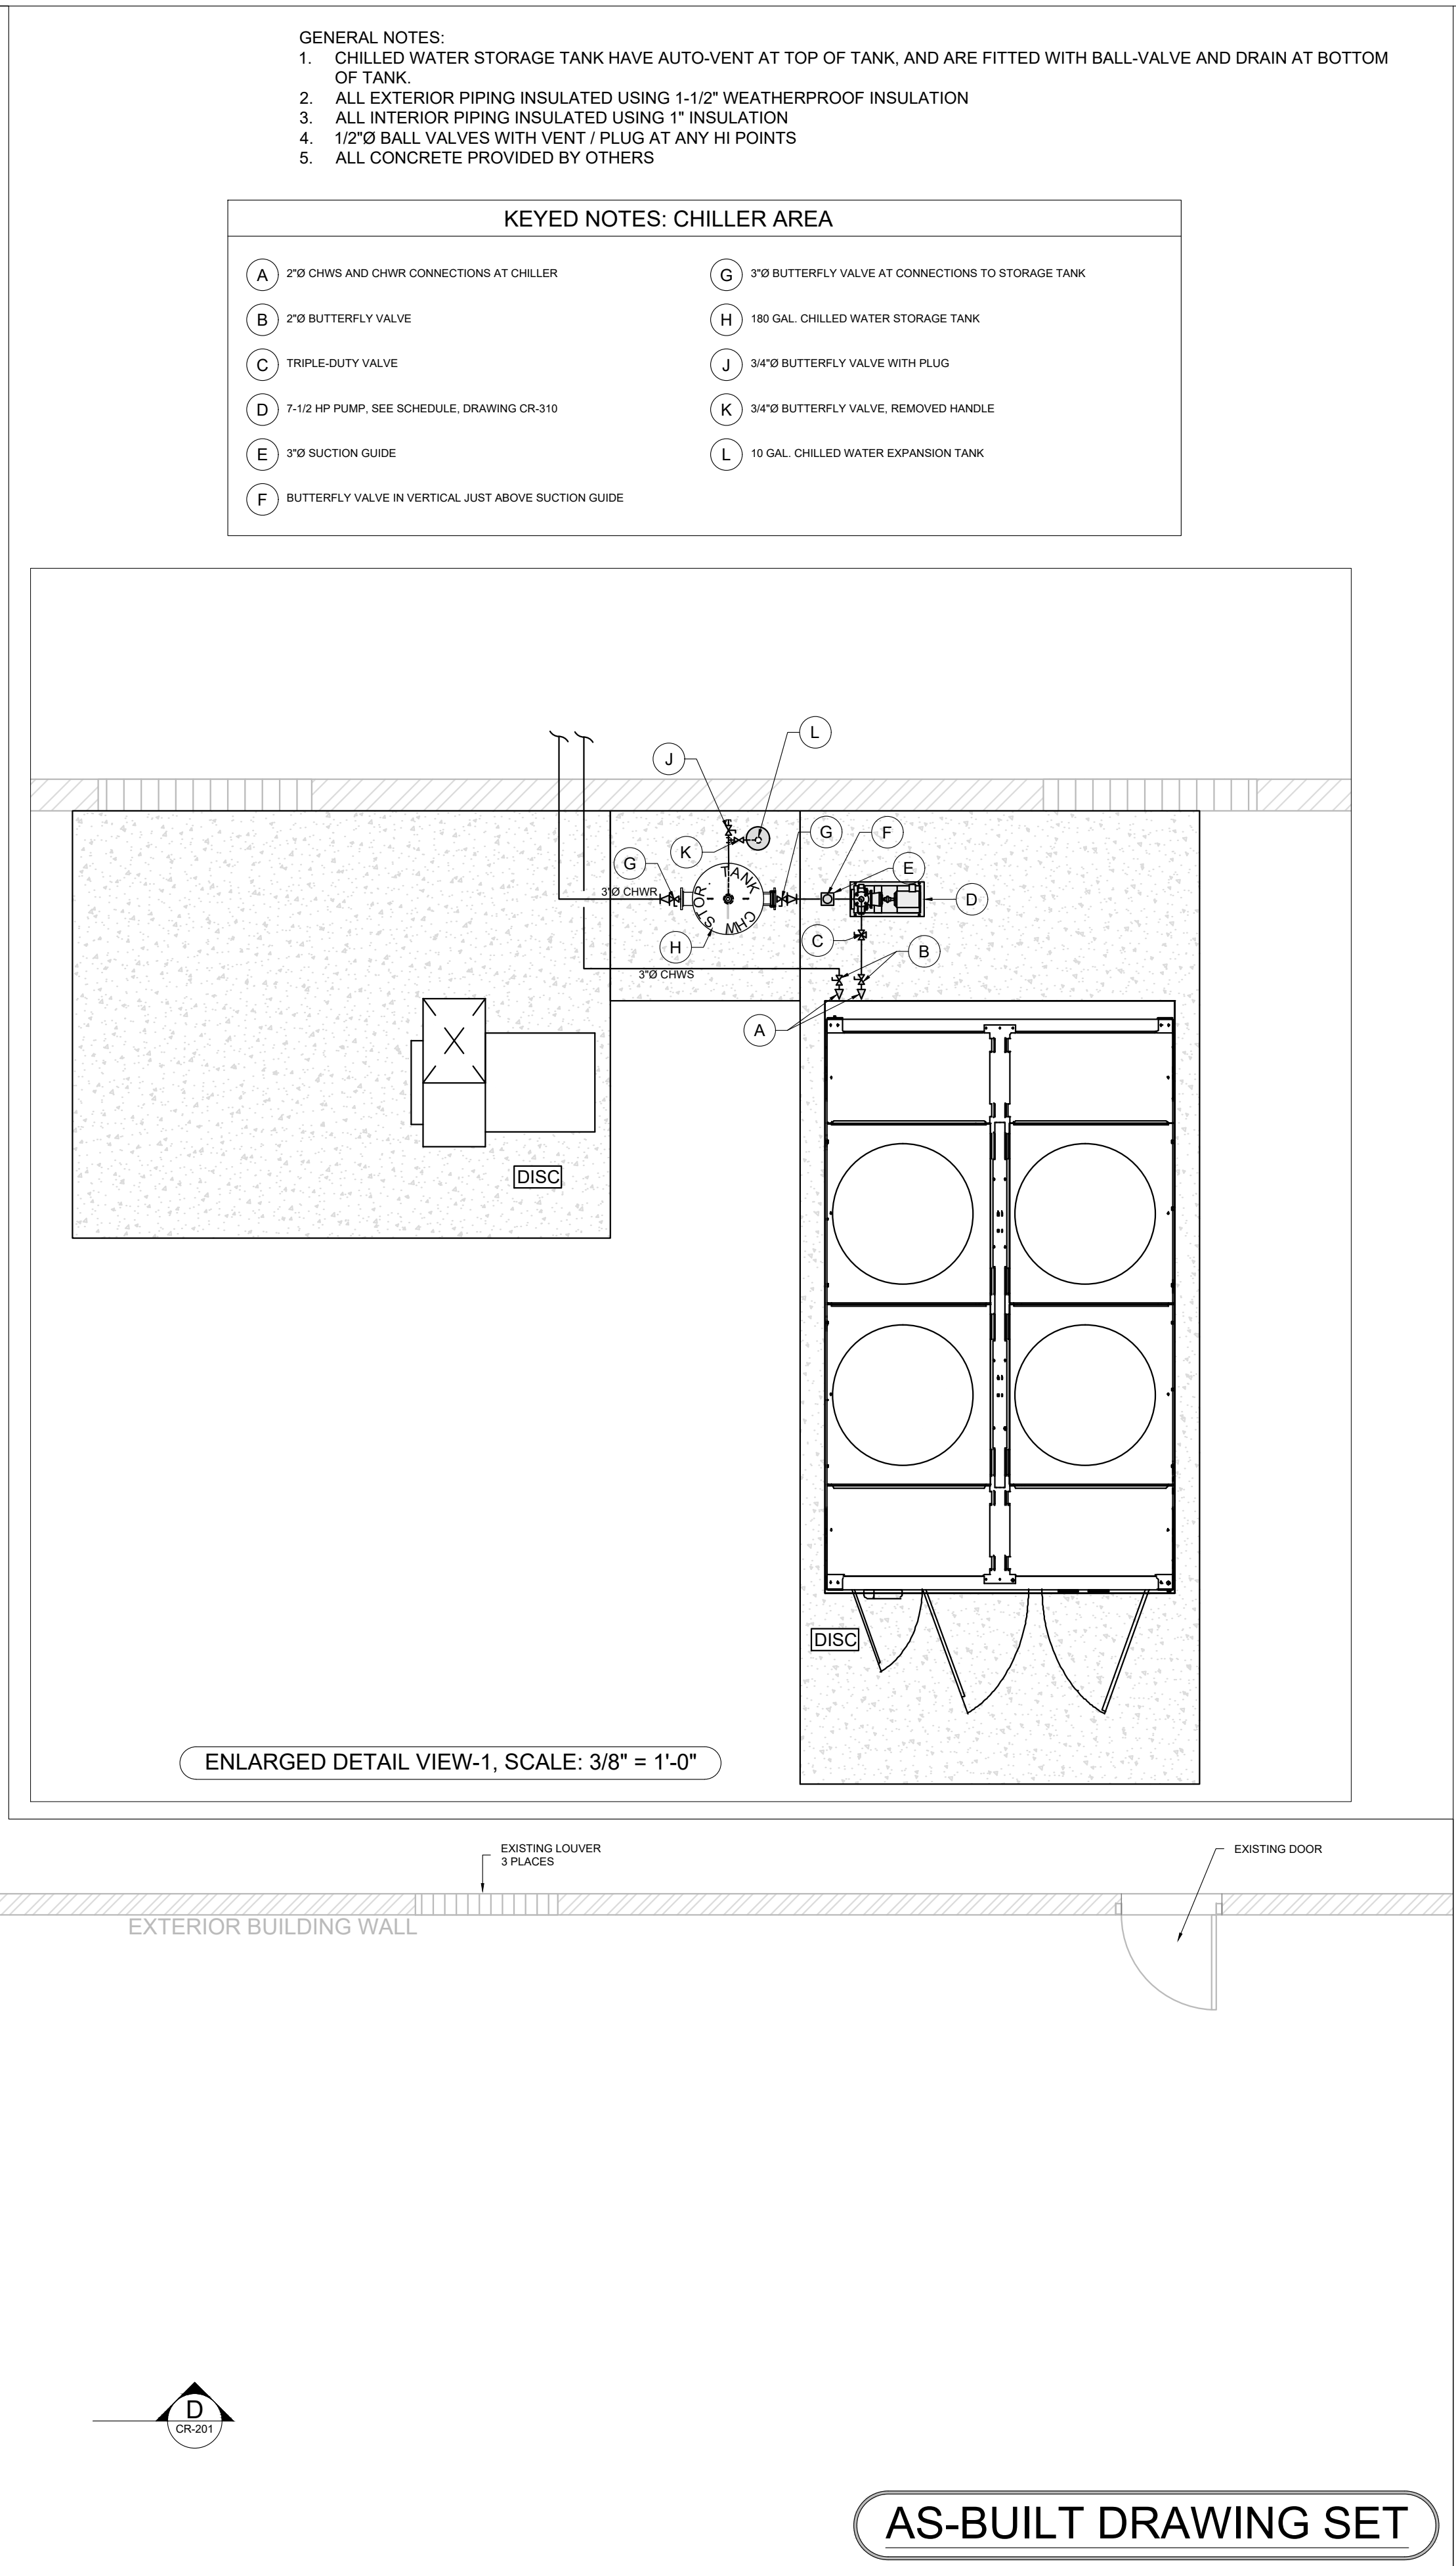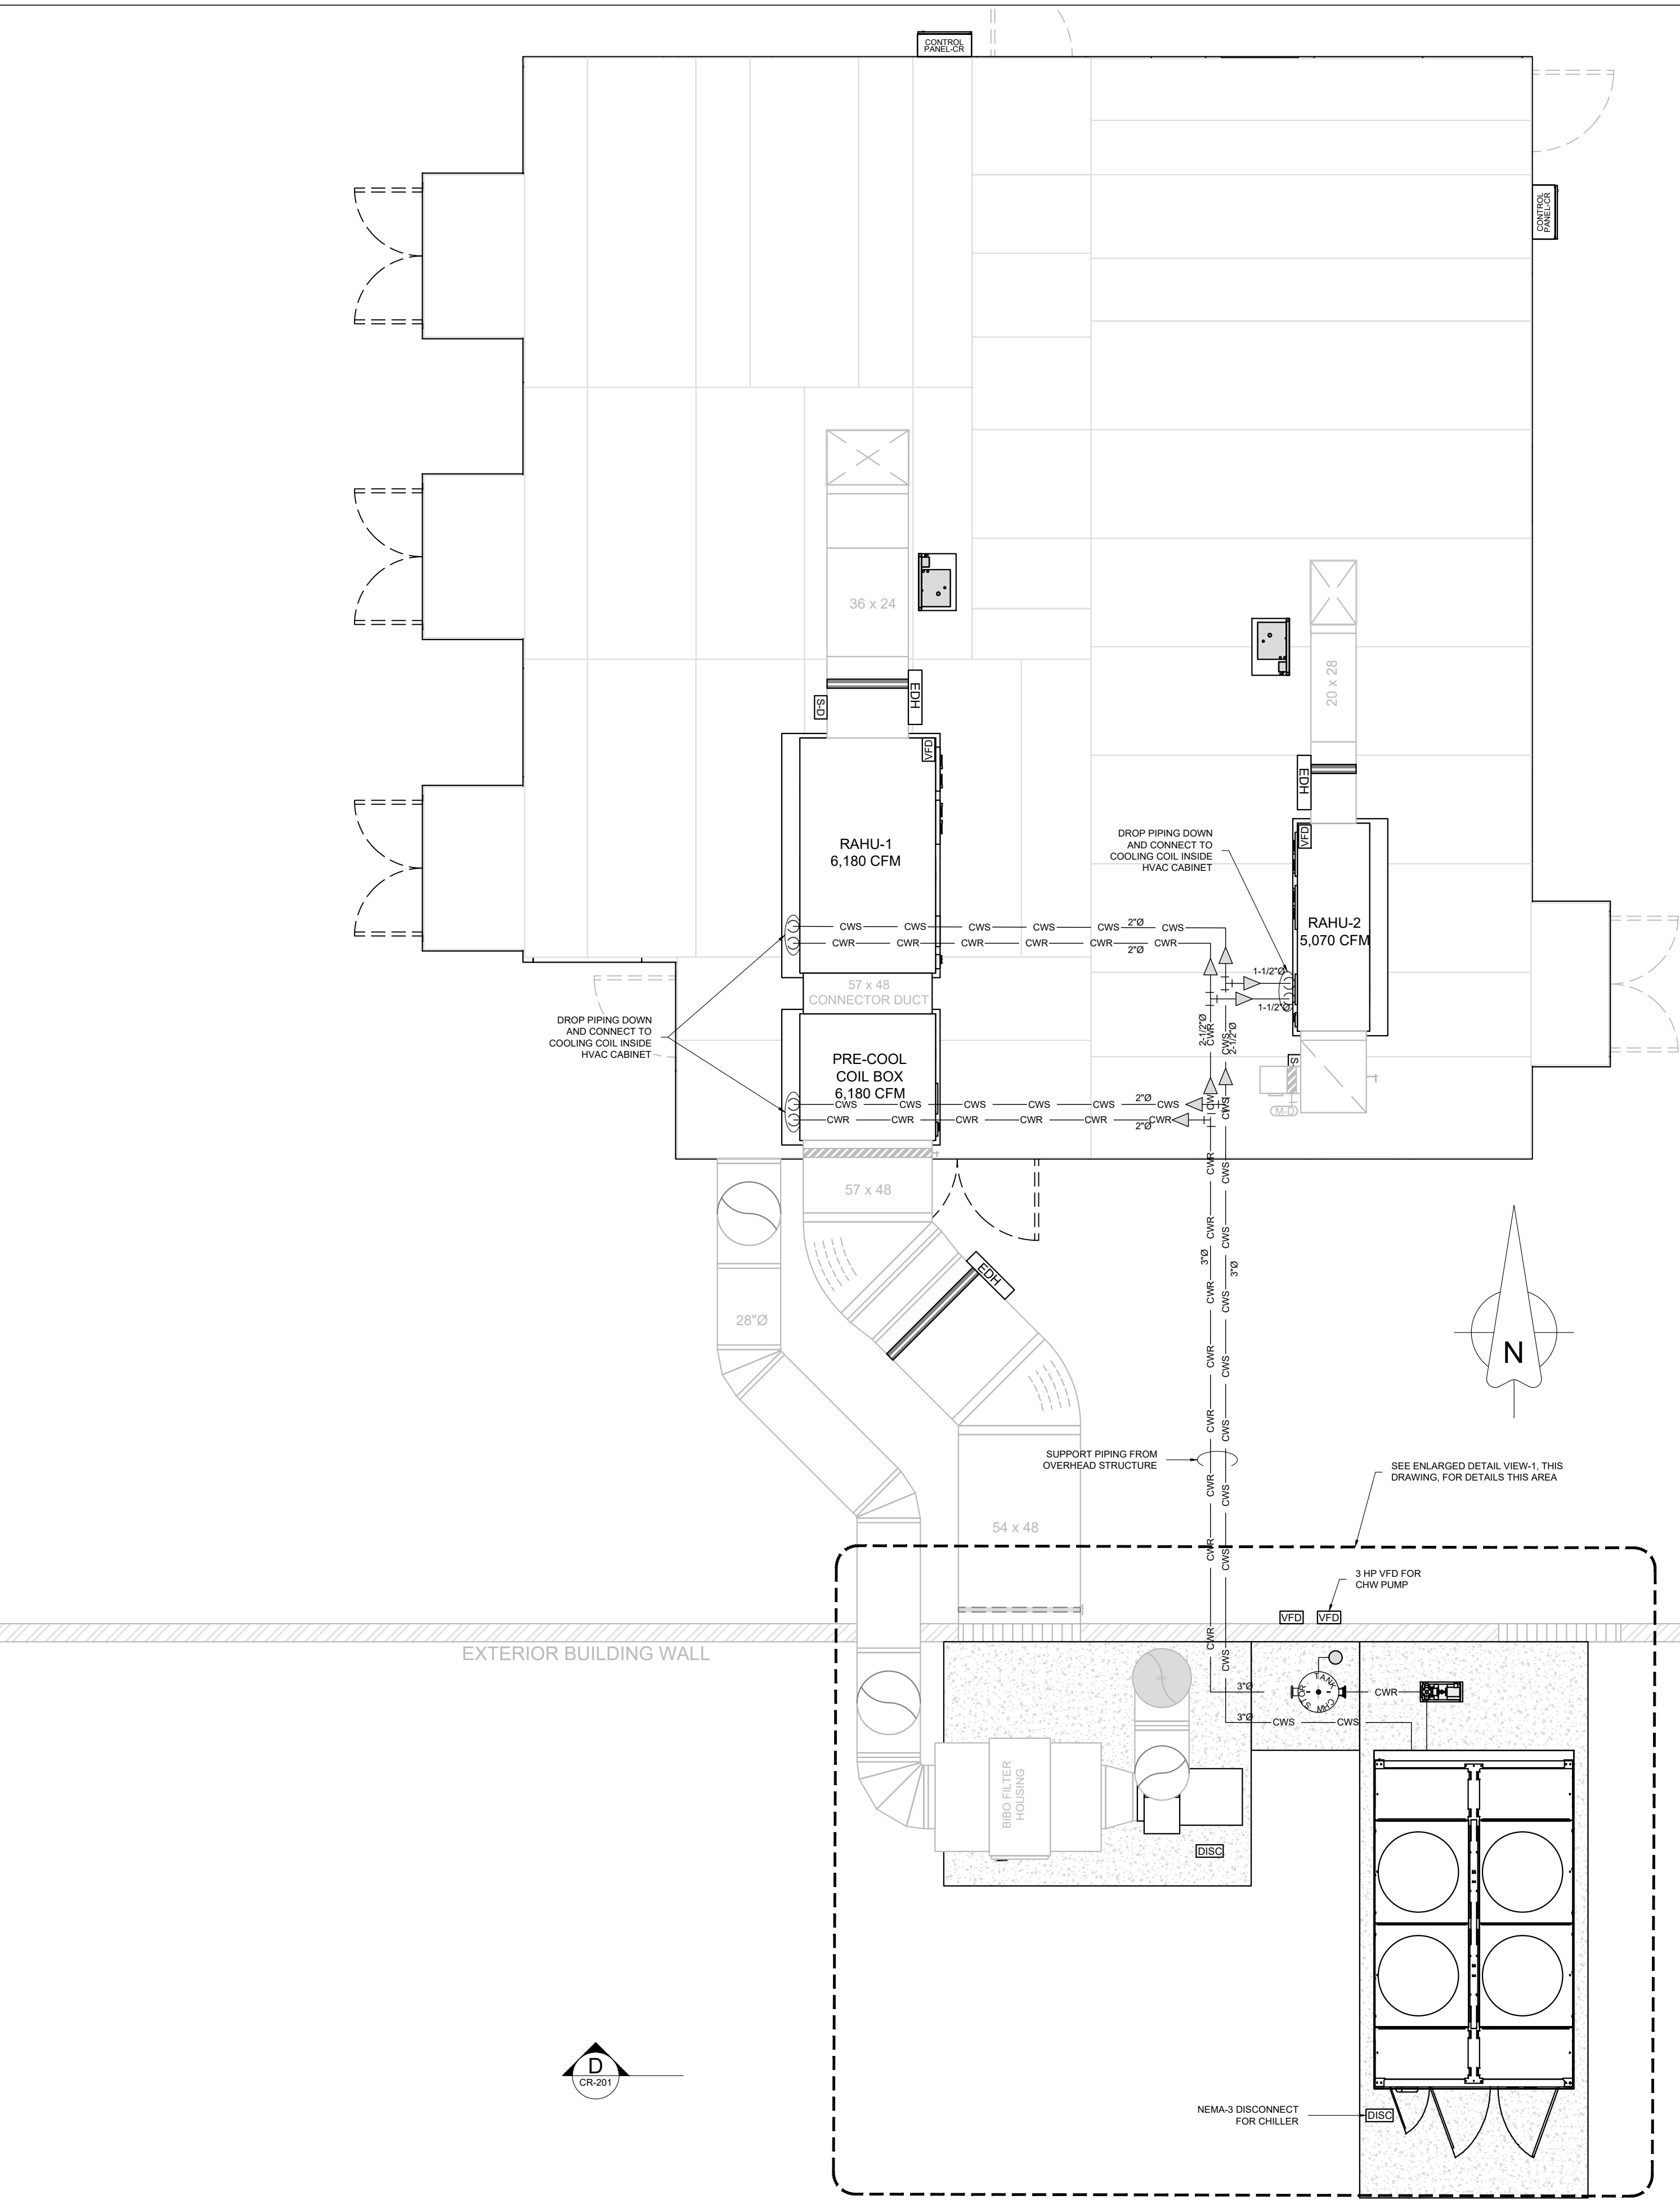

- GENERAL NOTES:
1. CHILLED WATER STORAGE TANK HAVE AUTO-VENT AT TOP OF TANK, AND ARE FITTED WITH BALL-VALVE AND DRAIN AT BOTTOM OF TANK.
 2. ALL EXTERIOR PIPING INSULATED USING 1-1/2" WEATHERPROOF INSULATION
 3. ALL INTERIOR PIPING INSULATED USING 1" INSULATION
 4. 1/2"Ø BALL VALVES WITH VENT / PLUG AT ANY HI POINTS
 5. ALL CONCRETE PROVIDED BY OTHERS

KEYED NOTES: CHILLER AREA

- | | |
|--|--|
| (A) 2"Ø CHWS AND CHWR CONNECTIONS AT CHILLER | (G) 3"Ø BUTTERFLY VALVE AT CONNECTIONS TO STORAGE TANK |
| (B) 2"Ø BUTTERFLY VALVE | (H) 180 GAL. CHILLED WATER STORAGE TANK |
| (C) TRIPLE-DUTY VALVE | (J) 3/4"Ø BUTTERFLY VALVE WITH PLUG |
| (D) 7-1/2 HP PUMP, SEE SCHEDULE, DRAWING CR-310 | (K) 3/4"Ø BUTTERFLY VALVE, REMOVED HANDLE |
| (E) 3"Ø SUCTION GUIDE | (L) 10 GAL. CHILLED WATER EXPANSION TANK |
| (F) BUTTERFLY VALVE IN VERTICAL JUST ABOVE SUCTION GUIDE | |

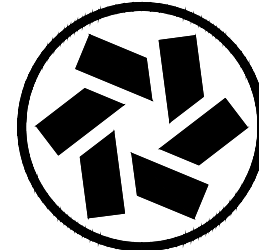


CLEAN AIR TECHNOLOGY, INC.
Decades of Experience Building America's Cleanrooms
41105 Capital, Canton, MI 48187 Tel 734-459-6320 Fax 734-459-9437
www.cleanairtechnology.com

THIS DRAWING CONTAINS DESIGNS AND OTHER INFORMATION WHICH ARE THE PROPERTY OF CLEAN AIR TECHNOLOGY, INC. THIS DRAWING MAY NOT BE REPRODUCED, COPIED, OR IN PART, BE USED FOR ANY OTHER PROJECT WITHOUT THE WRITTEN PERMISSION OF CLEAN AIR TECHNOLOGY, INC. ANY COPIES OF THIS DRAWING MADE WITHOUT THE WRITTEN PERMISSION OF CLEAN AIR TECHNOLOGY, INC. ARE TO BE RETURNED TO CLEAN AIR TECHNOLOGY, INC. ON REQUEST. CLEAN AIR TECHNOLOGY, INC. WILL ELECT TO TAKE ALL NECESSARY ACTION TO ENFORCE ITS RIGHTS TO THIS PROPRIETARY INFORMATION.


REV. NUM.	REV. DATE	REVISION DESCRIPTION	BY
A	05-15-18	REVISED	DWS
B	08-20-18	REVISED	DWS
C	08-22-18	REVISED	DWS
D	08-24-18	REVISED	DWS
E	08-24-18	REVISED	DWS
F	08-10-18	REVISED	DWS
00	09-12-18	ISSUED FOR CONSTRUCTION	DWS
01	01-28-19	AS-BUILT	DWS
02	02-05-19	AS-BUILT REVISIONS	DWS
03			
04			
05			
06			
07			
08			
09			
10			
11			
12			

CUSTOMER	
PROJECT TITLE USP 797 / USP 800 CLEANROOMS	
PROJECT LOCATION	
C.A.T. JOB NUMBER	18-142
ORIGINAL DATE:	05-08-18
DRAWN BY:	DWS
SCALE:	1/4" = 1'-0"
DESCRIPTION: CHILLED WATER PIPING AND CHILLER AREA	
DRAWING #:	CR-302

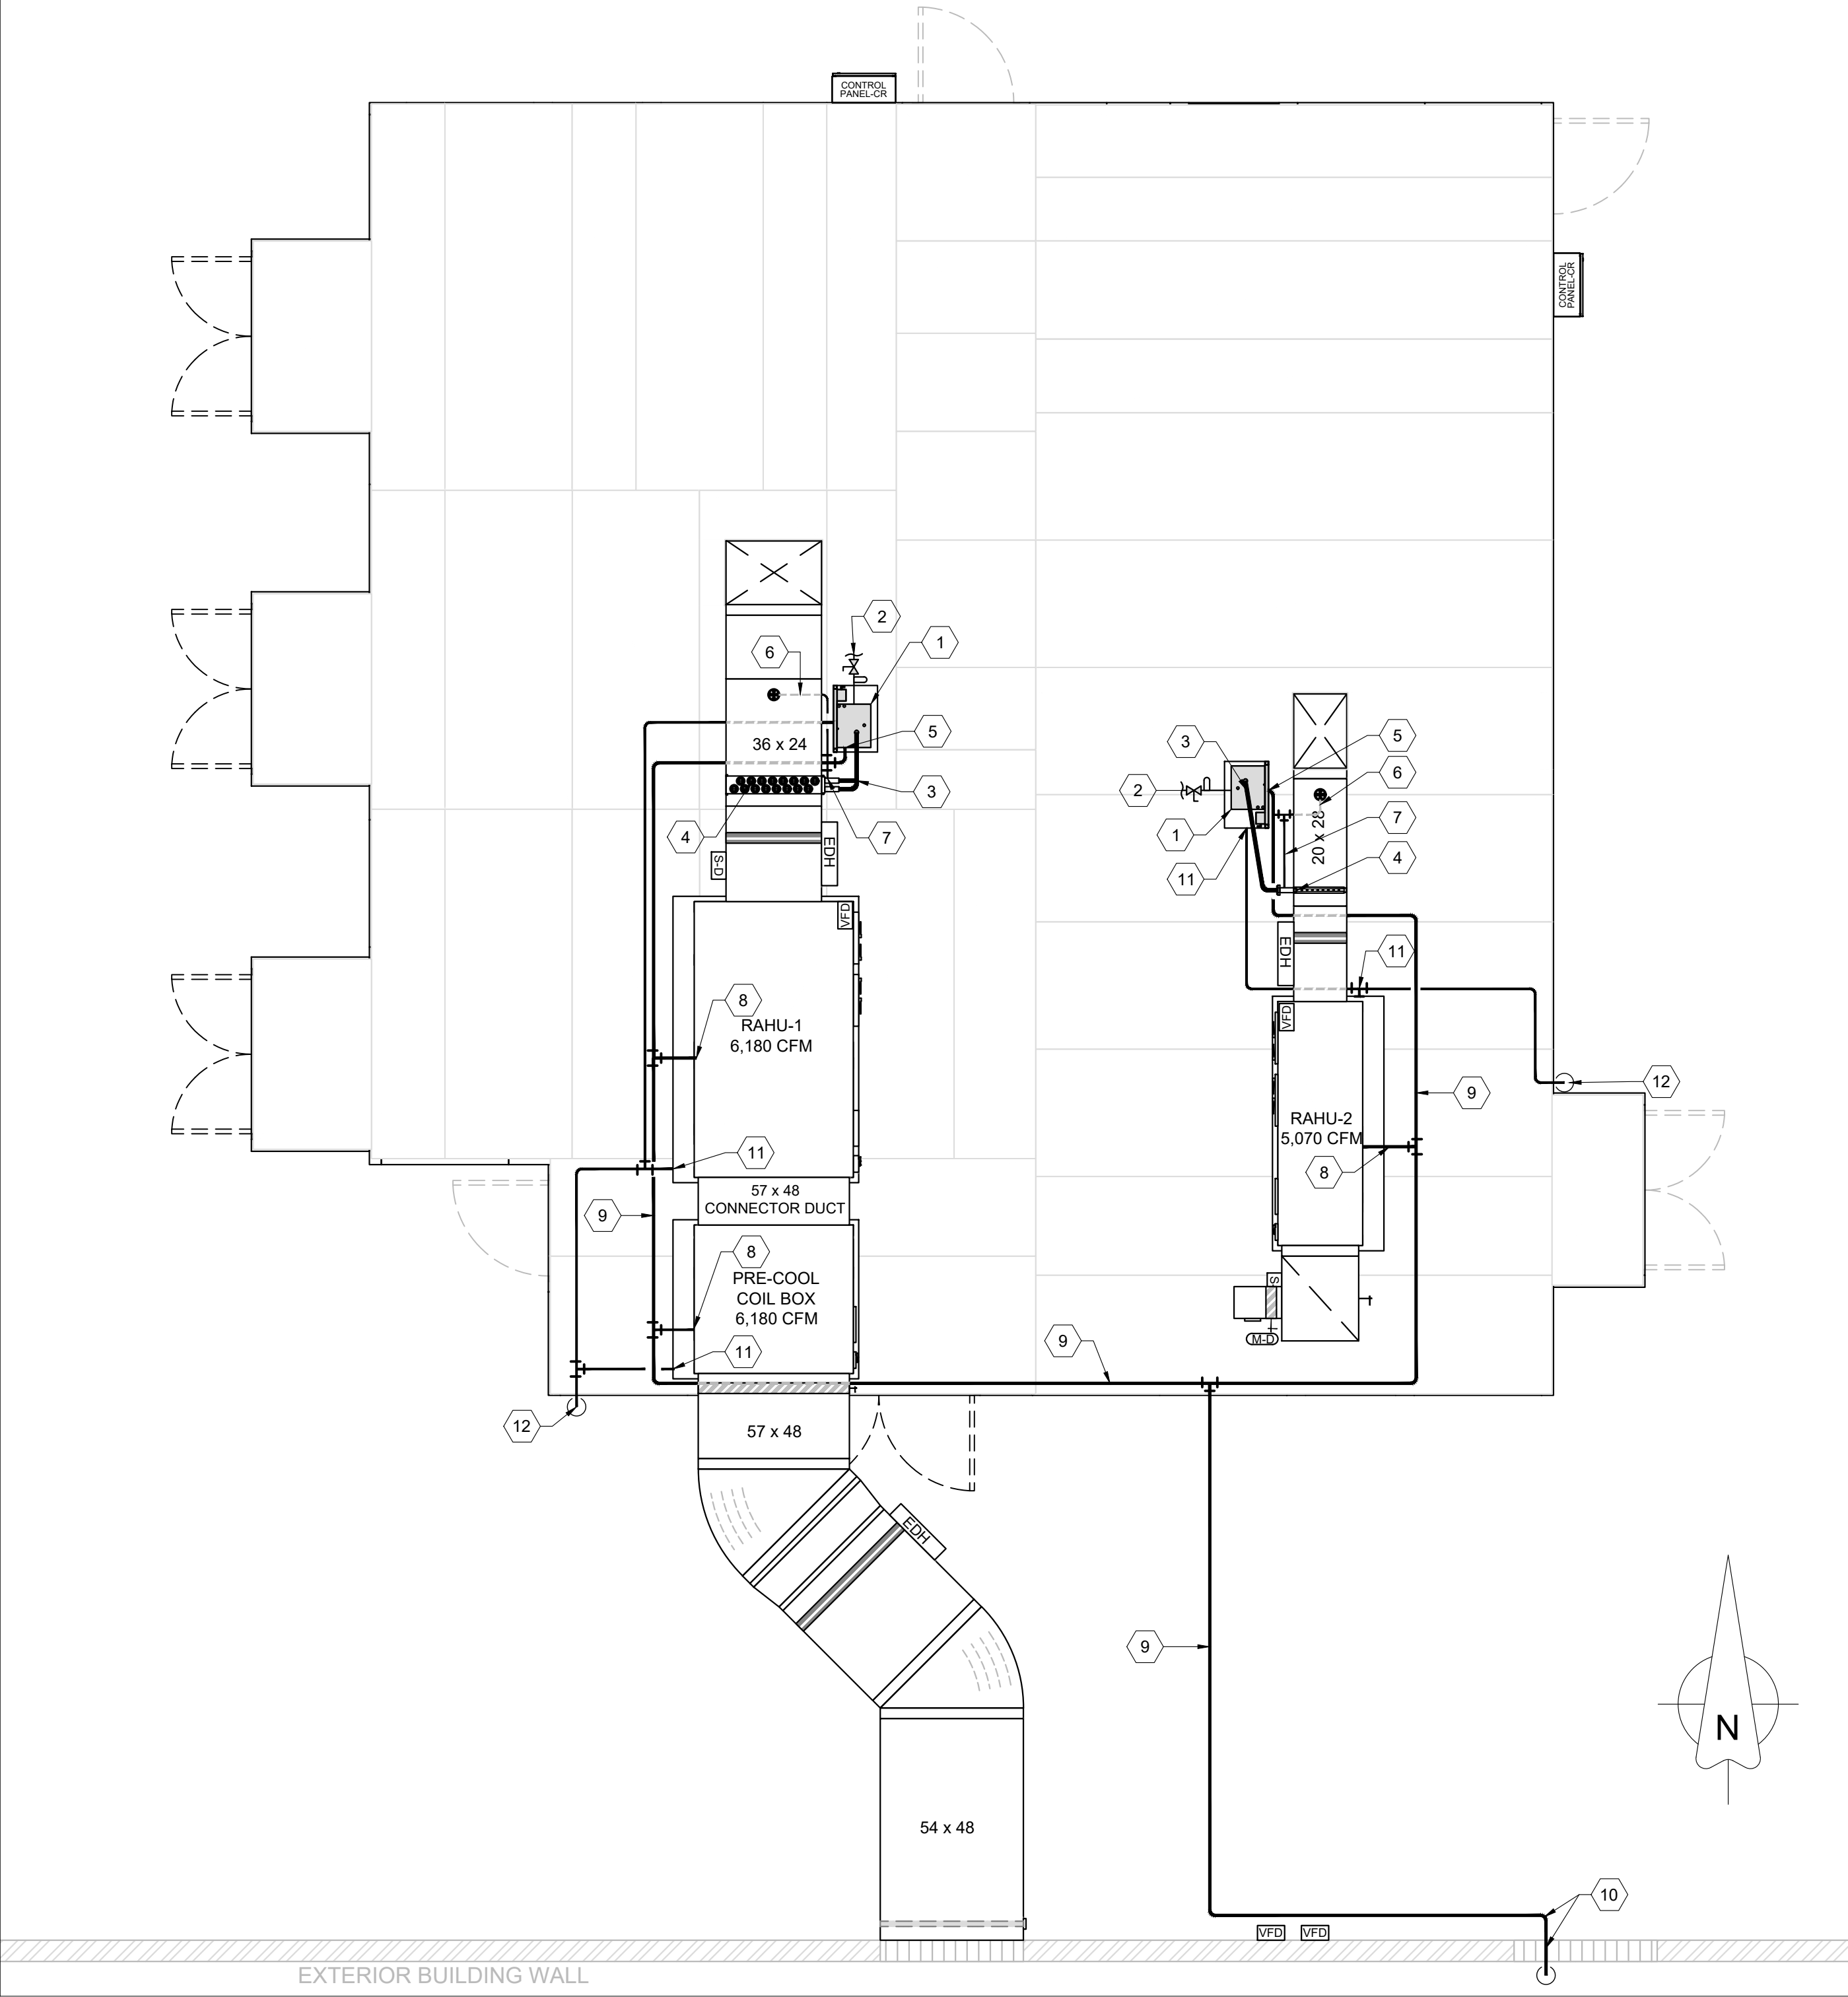

KEYED NOTES

- 1 HUMIDIFIER MOUNTED ON SUPPORT FRAME. SEE SCHEDULE, DRAWING CR-310 FOR SIZING.
NOTE: HUMIDIFIER SHALL HAVE FUSED ELECTRICAL DISCONNECT MOUNTED TO SUPPORT FRAME NEXT TO HUMIDIFIER
- 2 1/2"Ø WATER SUPPLY TO HUMIDIFIER, WITH IN-LINE FILTER AND SHUT-OFF VALVE.
- 3 INSULATED "MED L" COPPER STEAM SUPPLY PIPE FROM HUMIDIFIER TO STEAM DISPERSION BAR IN S/A DUCT, SIZED PER MANUFACTURER'S RECOMMENDATIONS FOR HUMIDIFIER SIZE. SEE DETAILS, DRAWING CR-310
- 4 STEAM DISPERSION DEVICE IN S/A DUCT
- 5 DRAIN LINE FROM HUMIDIFIER, 1-1/2"Ø COPPER, INCLUDE "CUP" FITTING AT HUMIDIFIER (1-1/2" X 4" INCREASER W/6" LEG UP OF 4"Ø COPPER).
- 6 3/8"Ø COPPER DRAIN LINE FROM CONDENSATE PAN BENEATH S/A DUCT. INCLUDE 1"Ø X 3/4"Ø INCREASER IN LEG UP, OPEN FOR AIR GAP AND TRAP FILLING
- 7 3/8"Ø COPPER DRAIN LINE FROM STEAM DEVICE. CONNECT TO 3/8"Ø DRAIN LINE FROM CONDENSATE PAN BENEATH DUCT, THEN RUN 1/2"Ø COPPER LINE TO CONNECTION AT MAIN CONDENSATE DRAIN.
- 8 CONDENSATE DRAIN, 1"Ø PVC, FROM CONDENSATE PAN INSIDE HVAC EQUIPMENT. SHALL INCLUDE 6" P-TRAP AT EXTERIOR OF CABINET.
- 9 MAIN CONDENSATE DRAIN, 1-1/2"Ø COPPER.
- 10 MAIN CONDENSATE DRAIN DROPS DOWN TO APPROX. 24" A.F.F., THEN OUT THRU BUILDING WALL.
- 11 3/4"Ø PVC DRAIN LINE FROM EMERGENCY PAN BENEATH EQUIPMENT
- 12 EMERGENCY DRAIN SHALL TURN DOWN FROM EDGE OF TOP DECK, AND RUN DOWN TO APPROX. 6" A.F.F.. EMERGENCY DRAINS SHALL BE LEFT OPEN AT BOTTOM TO ALERT OWNER TO PRESENCE OF WATER IN EMERGENCY PAN(S)

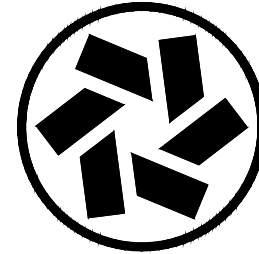

CLEAN AIR TECHNOLOGY, INC.
Decades of Experience Building America's Cleanrooms
41105 Capital, Canton, MI 48187 Tel 734-459-6320 Fax 734-459-9437
www.cleanairtechnology.com

THIS DRAWING CONTAINS DESIGNS AND OTHER INFORMATION WHICH ARE THE PROPERTY OF CLEAN AIR TECHNOLOGY, INC. THIS DRAWING MAY NOT BE REPRODUCED, COPIED, OR IN PART, BE USED FOR ANY OTHER PROJECT WITHOUT THE WRITTEN PERMISSION OF CLEAN AIR TECHNOLOGY, INC. ANY COPIES OF THIS DRAWING MADE WITHOUT THE WRITTEN PERMISSION OF CLEAN AIR TECHNOLOGY, INC. ARE VOID. THIS DRAWING IS TO BE RETURNED TO CLEAN AIR TECHNOLOGY, INC. ON REQUEST. CLEAN AIR TECHNOLOGY, INC. WILL ELECT TO TAKE ALL NECESSARY ACTION TO ENFORCE ITS RIGHTS TO THIS PROPRIETARY INFORMATION.

REV	NUM	DATE	DESCRIPTION
BY	DWS		
00	01	07-18-18	ISSUED FOR CONSTRUCTION
01	02	07-29-19	AS-BUILT
02	03		
03	04		
04	05		
99	100		

CUSTOMER

PROJECT TITLE
USP 797 / USP 800
CLEANROOMS

PROJECT LOCATION

C.A.T. JOB NUMBER 18-142

ORIGINAL DATE: 07-18-18


DRAWN BY: DWS

SCALE: 1/4" = 1'-0"

DESCRIPTION:
HUMIDIFIER AND DRAIN PIPING

DRAWING #: CR-303

AS-BUILT DRAWING SET

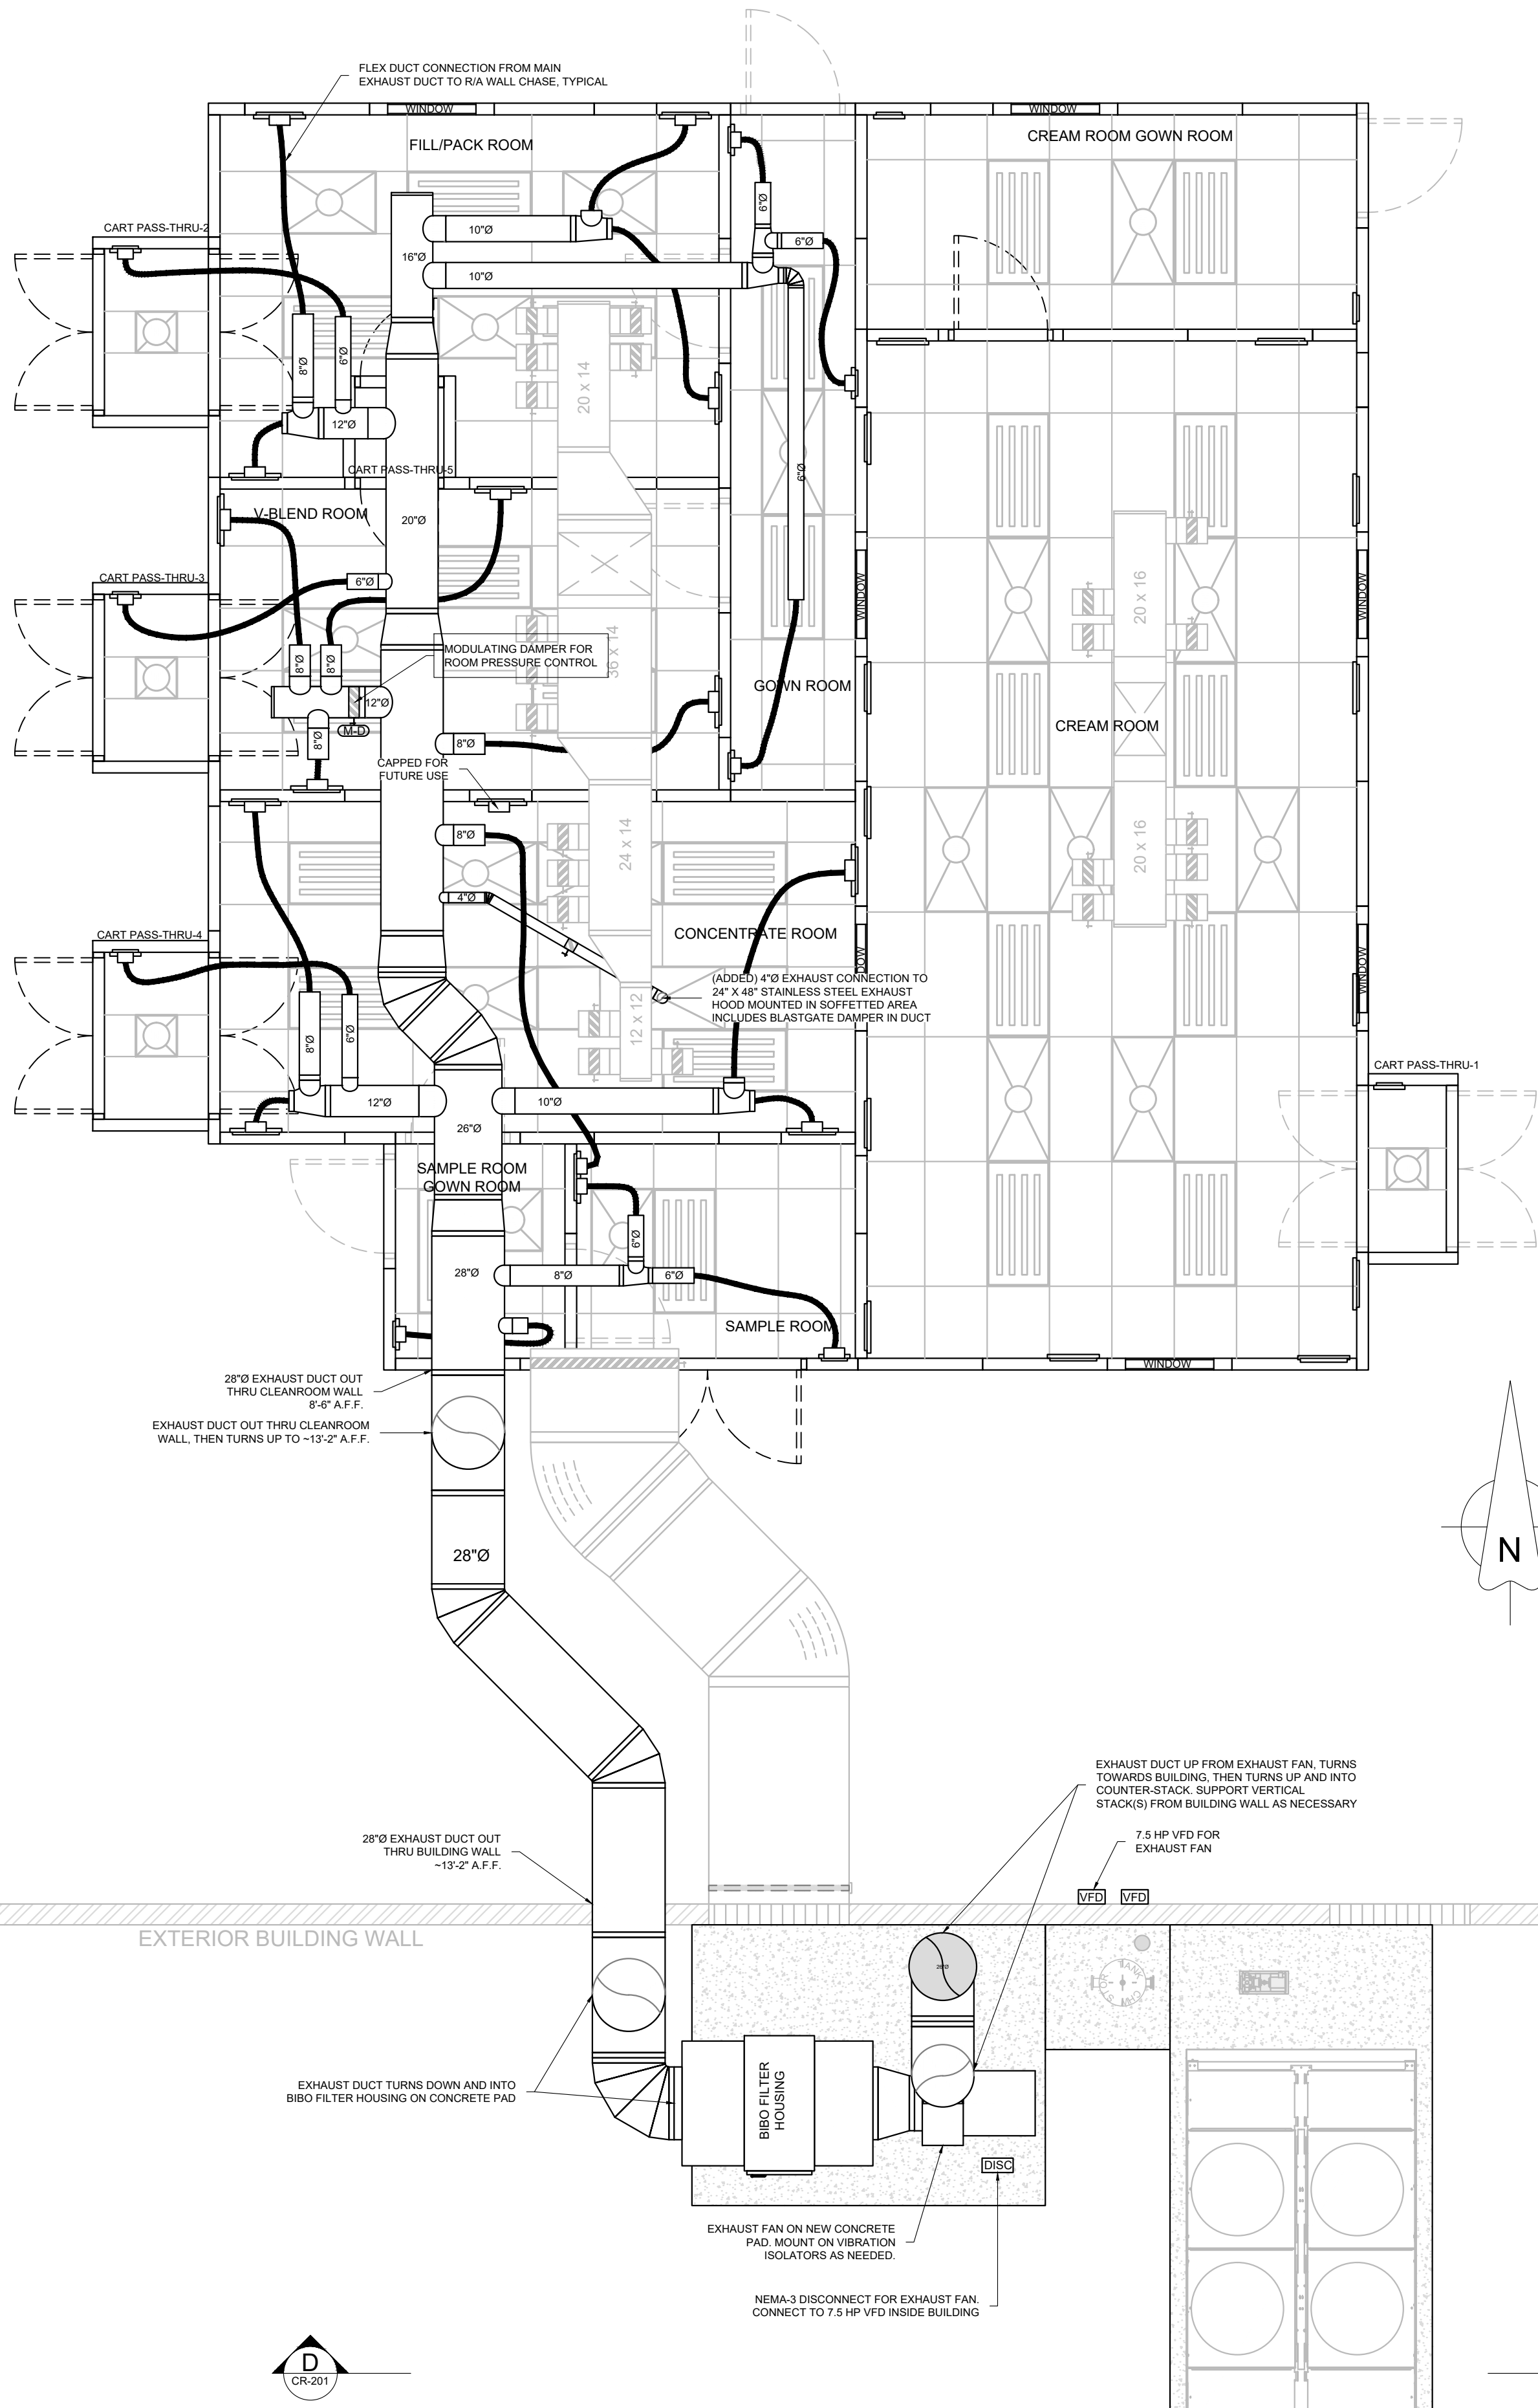

REV.	NUM.	REV. DATE	REVISION DESCRIPTION	BY
A	01	08-20-18	REVISED	DWS
B	02	08-24-18	REVISED	DWS
C	03	08-26-18	REVISED	DWS
D	04	08-26-18	REVISED	DWS
E	05	08-26-18	REVISED	DWS
F	06	08-26-18	ISSUED FOR CONSTRUCTION	DWS
G	07	11-20-18	REVISED DUCT, ADDED MOD. DAMPER	DWS
H	08	01-26-19	AS-BUILT	DWS
I	09	01-31-20	AS-BUILT REVISIONS	DWS
J	10	02-05-20	AS-BUILT REVISION	DWS
K	11	02-05-20	AS-BUILT REVISION	DWS
L	12	02-05-20	AS-BUILT REVISION	DWS
M	13	02-05-20	AS-BUILT REVISION	DWS
N	14	02-05-20	AS-BUILT REVISION	DWS
O	15	02-05-20	AS-BUILT REVISION	DWS
P	16	02-05-20	AS-BUILT REVISION	DWS
Q	17	02-05-20	AS-BUILT REVISION	DWS
R	18	02-05-20	AS-BUILT REVISION	DWS
S	19	02-05-20	AS-BUILT REVISION	DWS
T	20	02-05-20	AS-BUILT REVISION	DWS
U	21	02-05-20	AS-BUILT REVISION	DWS
V	22	02-05-20	AS-BUILT REVISION	DWS
W	23	02-05-20	AS-BUILT REVISION	DWS
X	24	02-05-20	AS-BUILT REVISION	DWS
Y	25	02-05-20	AS-BUILT REVISION	DWS
Z	26	02-05-20	AS-BUILT REVISION	DWS
AA	27	02-05-20	AS-BUILT REVISION	DWS
AB	28	02-05-20	AS-BUILT REVISION	DWS
AC	29	02-05-20	AS-BUILT REVISION	DWS
AD	30	02-05-20	AS-BUILT REVISION	DWS
AE	31	02-05-20	AS-BUILT REVISION	DWS
AF	32	02-05-20	AS-BUILT REVISION	DWS
AG	33	02-05-20	AS-BUILT REVISION	DWS
AH	34	02-05-20	AS-BUILT REVISION	DWS
AI	35	02-05-20	AS-BUILT REVISION	DWS
AJ	36	02-05-20	AS-BUILT REVISION	DWS
AK	37	02-05-20	AS-BUILT REVISION	DWS
AL	38	02-05-20	AS-BUILT REVISION	DWS
AM	39	02-05-20	AS-BUILT REVISION	DWS
AN	40	02-05-20	AS-BUILT REVISION	DWS
AO	41	02-05-20	AS-BUILT REVISION	DWS
AP	42	02-05-20	AS-BUILT REVISION	DWS
AQ	43	02-05-20	AS-BUILT REVISION	DWS
AR	44	02-05-20	AS-BUILT REVISION	DWS
AS	45	02-05-20	AS-BUILT REVISION	DWS
AT	46	02-05-20	AS-BUILT REVISION	DWS
AU	47	02-05-20	AS-BUILT REVISION	DWS
AV	48	02-05-20	AS-BUILT REVISION	DWS
AW	49	02-05-20	AS-BUILT REVISION	DWS
AX	50	02-05-20	AS-BUILT REVISION	DWS
AY	51	02-05-20	AS-BUILT REVISION	DWS
AZ	52	02-05-20	AS-BUILT REVISION	DWS
BA	53	02-05-20	AS-BUILT REVISION	DWS
BB	54	02-05-20	AS-BUILT REVISION	DWS
BC	55	02-05-20	AS-BUILT REVISION	DWS
BD	56	02-05-20	AS-BUILT REVISION	DWS
BE	57	02-05-20	AS-BUILT REVISION	DWS
BF	58	02-05-20	AS-BUILT REVISION	DWS
BG	59	02-05-20	AS-BUILT REVISION	DWS
BH	60	02-05-20	AS-BUILT REVISION	DWS
BI	61	02-05-20	AS-BUILT REVISION	DWS
BJ	62	02-05-20	AS-BUILT REVISION	DWS
BK	63	02-05-20	AS-BUILT REVISION	DWS
BL	64	02-05-20	AS-BUILT REVISION	DWS
BM	65	02-05-20	AS-BUILT REVISION	DWS
BN	66	02-05-20	AS-BUILT REVISION	DWS
BO	67	02-05-20	AS-BUILT REVISION	DWS
BP	68	02-05-20	AS-BUILT REVISION	DWS
BQ	69	02-05-20	AS-BUILT REVISION	DWS
BR	70	02-05-20	AS-BUILT REVISION	DWS
BS	71	02-05-20	AS-BUILT REVISION	DWS
BT	72	02-05-20	AS-BUILT REVISION	DWS
BU	73	02-05-20	AS-BUILT REVISION	DWS
BV	74	02-05-20	AS-BUILT REVISION	DWS
BW	75	02-05-20	AS-BUILT REVISION	DWS
BX	76	02-05-20	AS-BUILT REVISION	DWS
BY	77	02-05-20	AS-BUILT REVISION	DWS
BZ	78	02-05-20	AS-BUILT REVISION	DWS
CA	79	02-05-20	AS-BUILT REVISION	DWS
CB	80	02-05-20	AS-BUILT REVISION	DWS
CC	81	02-05-20	AS-BUILT REVISION	DWS
CD	82	02-05-20	AS-BUILT REVISION	DWS
CE	83	02-05-20	AS-BUILT REVISION	DWS
CF	84	02-05-20	AS-BUILT REVISION	DWS
CG	85	02-05-20	AS-BUILT REVISION	DWS
CH	86	02-05-20	AS-BUILT REVISION	DWS
CI	87	02-05-20	AS-BUILT REVISION	DWS
CJ	88	02-05-20	AS-BUILT REVISION	DWS
CK	89	02-05-20	AS-BUILT REVISION	DWS
CL	90	02-05-20	AS-BUILT REVISION	DWS
CM	91	02-05-20	AS-BUILT REVISION	DWS
CN	92	02-05-20	AS-BUILT REVISION	DWS
CO	93	02-05-20	AS-BUILT REVISION	DWS
CP	94	02-05-20	AS-BUILT REVISION	DWS
CQ	95	02-05-20	AS-BUILT REVISION	DWS
CR	96	02-05-20	AS-BUILT REVISION	DWS
CS	97	02-05-20	AS-BUILT REVISION	DWS
CT	98	02-05-20	AS-BUILT REVISION	DWS
CU	99	02-05-20	AS-BUILT REVISION	DWS
CV	100	02-05-20	AS-BUILT REVISION	DWS

CUSTOMER



PROJECT TITLE
USP 797 / USP 800
CLEANROOMS

PROJECT LOCATION



C.A.T. JOB NUMBER 18-142
ORIGINAL DATE: 07-18-18
DRAWN BY: DWS
SCALE: 1/4" = 1'-0"
DESCRIPTION:
800 AREA EXHAUST SYSTEM

DRAWING #: CR-304

THIS DRAWING CONTAINS DESIGNS AND OTHER INFORMATION
THIS DRAWING MAY NOT BE REPRODUCED OR TRANSMITTED IN ANY FORM OR BY ANY MEANS, ELECTRONIC OR MECHANICAL, INCLUDING PHOTOCOPYING, RECORDING, OR BY ANY INFORMATION STORAGE AND RETRIEVAL SYSTEM, WITHOUT THE WRITTEN PERMISSION OF CLEAN AIR TECHNOLOGY, INC. ANY COPIES OF THIS DRAWING
THIS DRAWING IS THE PROPERTY OF CLEAN AIR TECHNOLOGY, INC. AND IS TO BE RETURNED TO CLEAN AIR TECHNOLOGY, INC. ON REQUEST
UNDER THE TERMS OF A CONTRACT OR OTHERWISE, ARE TO
BE RETURNED TO CLEAN AIR TECHNOLOGY, INC. ON REQUEST
ACCOMPLISHED. CLEAN AIR TECHNOLOGY, INC. WILL ELECT TO
TAKE ALL NECESSARY ACTION TO ENFORCE ITS RIGHTS TO
THIS PROPRIETARY INFORMATION

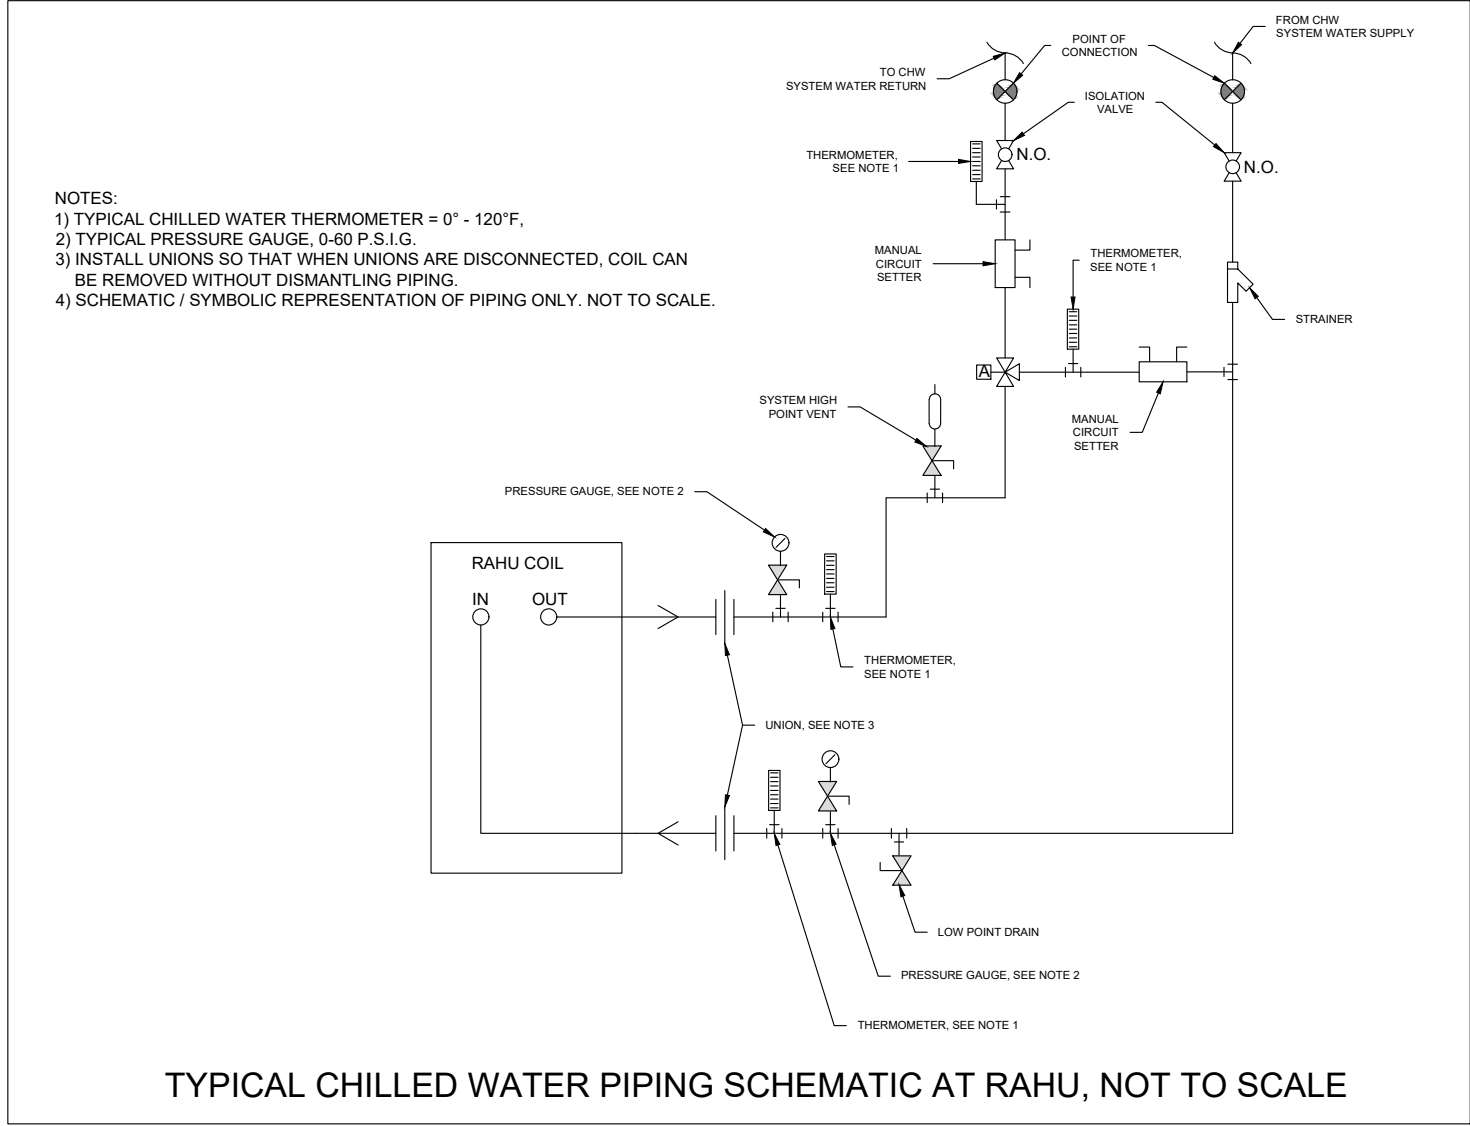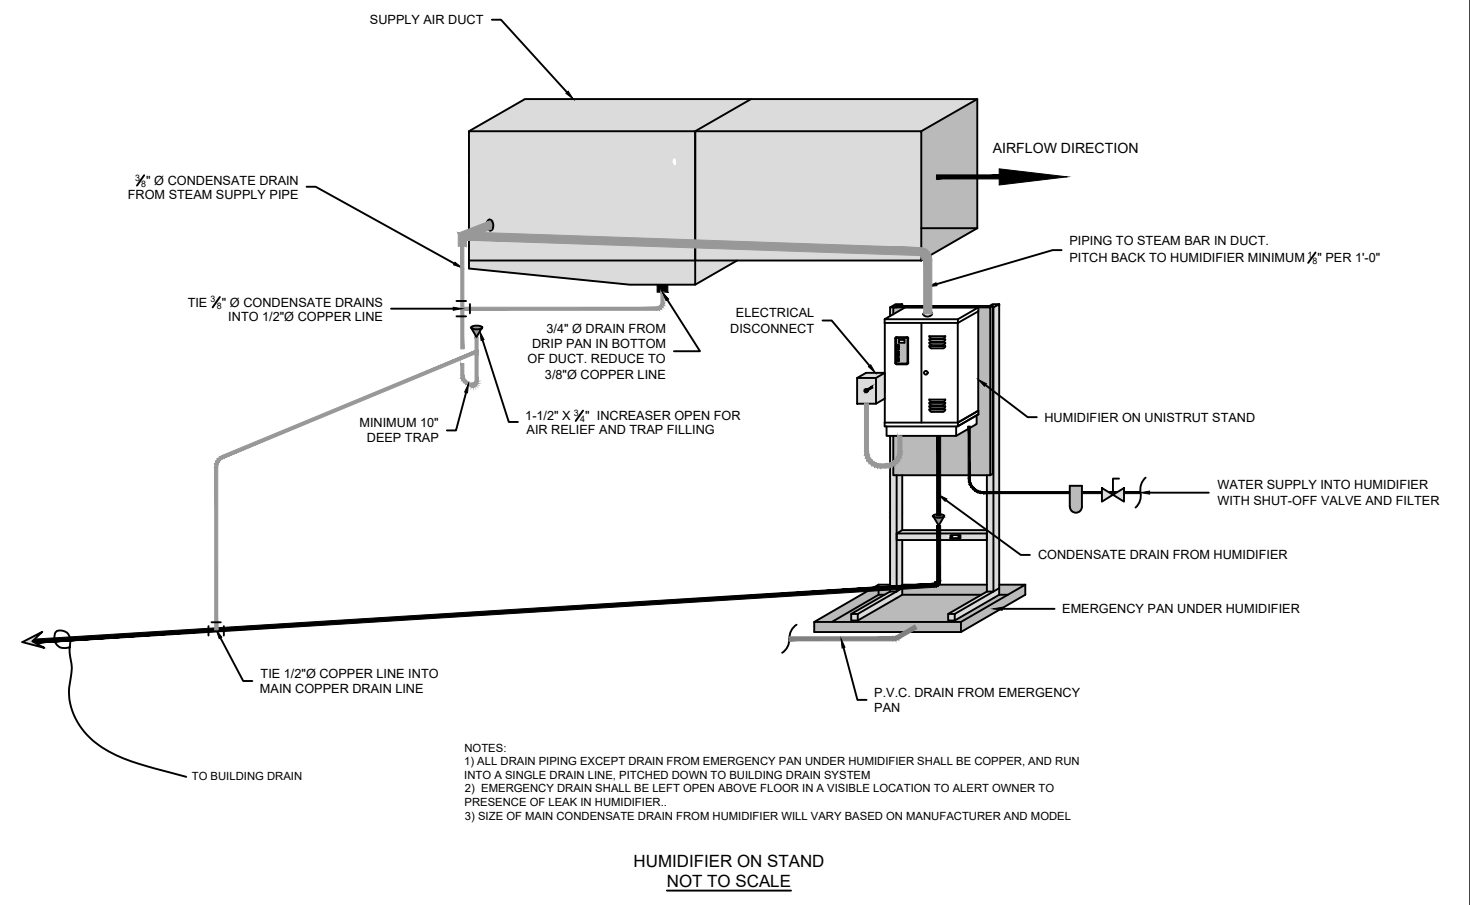

TYPICAL CHILLED WATER PIPING SCHEMATIC AT RAHU, NOT TO SCALE

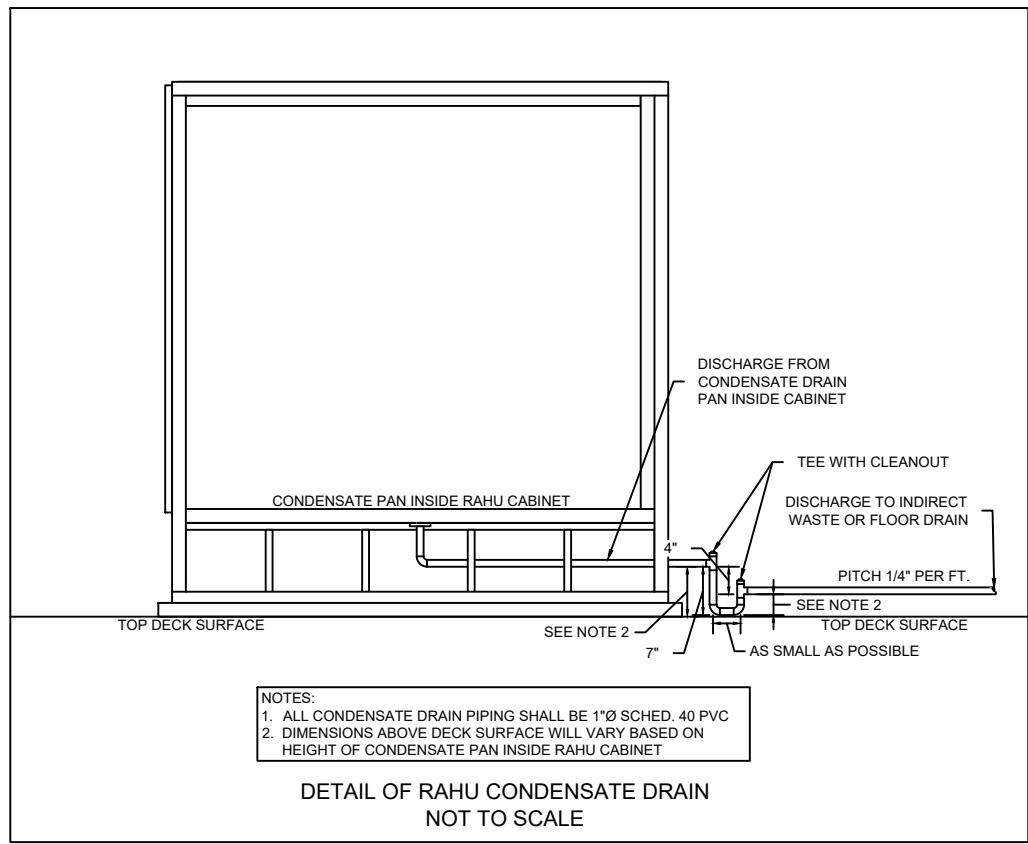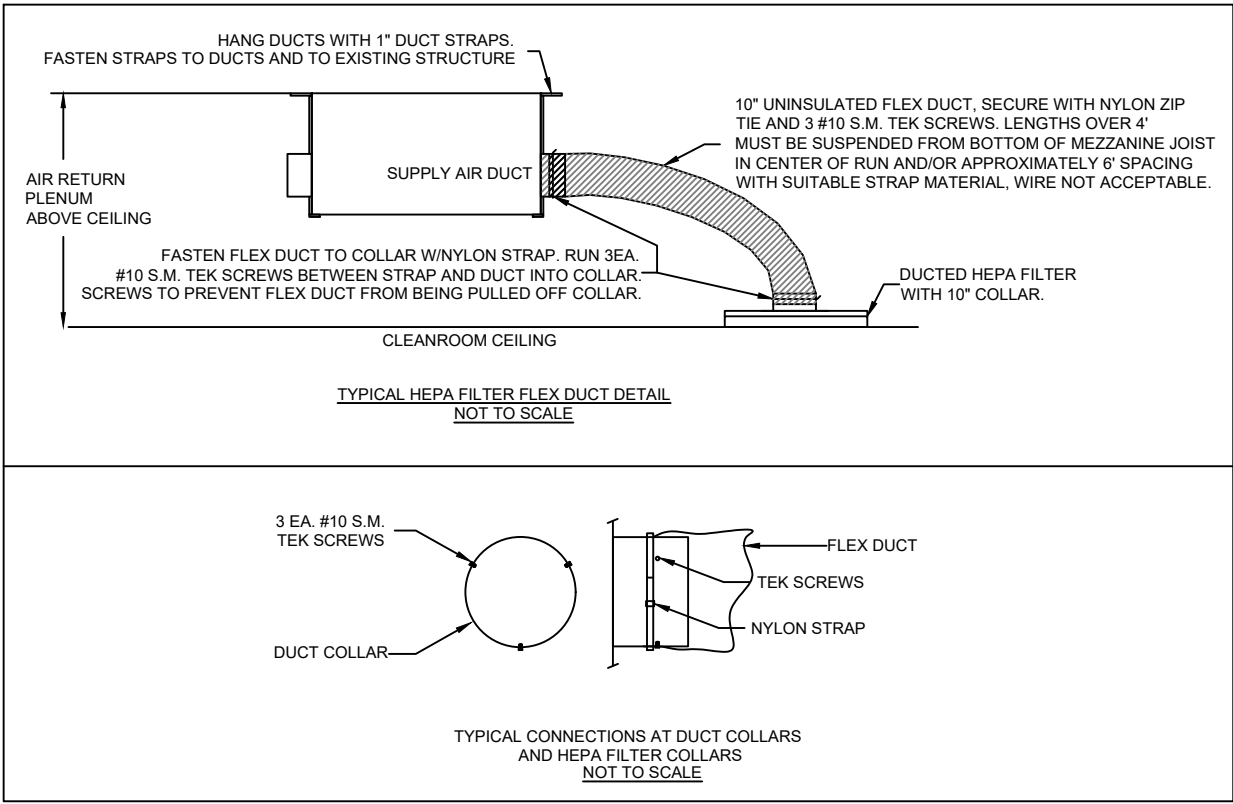

ELECTRIC HUMIDIFIER SCHEDULE (NORTEC)							ELECTRIC DUCT HEATER SCHEDULE (INDEECO)				
UNIT #	LOCATION	MODEL #	STEAM OUTPUT	WATER CON. SIZE	ELECT POWER	F.L.A.	UNIT #	UNIT SERVED	KW	ELECT POWER	F.L.A.
1	ON CLEANROOM TOP DECK	RS-180	180lbs/HR	1/2"Ø	460v/3ø/60hz	77.3	1	RAHU-1	44.0	460v/3ø/60hz	55.29
2	ON CLEANROOM TOP DECK	RS-15	15lbs/HR	1/2"Ø	460v/1ø/60hz	10.0	2	RAHU-1	57.0	460v/3ø/60hz	71.63
							3	RAHU-2	11.0	460v/3ø/60hz	13.82
							NOTES: 1) UNITS SHALL HAVE INTEGRAL DISCONNECTS AND FUSES				

AIR HANDLING UNIT SCHEDULE (BY CLEAN AIR TECHNOLOGY, INC.)														
UNIT #	FAN TYPE	LOCATION	AREA SERVED	DESIGN SCFM	FAN SIZE	ESP	TSP	MOTOR HP	MOTOR RPM	ELECT. POWER	F.L.A.	UNIT WEIGHT (lbs)	COOLING TYPE	HEATING TYPE
1	FC	ON CLEANROOM TOP DECK	800 CLEANROOM AREA	6,180	915	2.0	3.75	7.5	1,800	460v/3ø/60hz	8.85	~1,600	CHILLED WATER	ELECTRIC
2	FC	ON CLEANROOM TOP DECK	797 CLEANROOM AREA	5,070	915	2.0	3.5	5	1,800	460v/3ø/60hz	6.12	~1,200	CHILLED WATER	ELECTRIC

PACKAGED AIR COOLED CHILLER SCHEDULE (TRANE)										
UNIT #	MANUFACTURER	MODEL NUMBER / SERIES	MCA / MOCP	CAPACITY (TONS)	MIN. OPERATING CAPACITY	UNIT WEIGHT (lbs)	COMPRESSOR CHARACTERISTICS			
							TYPE	ELECT. POWER	REFRIGERANT TYPE	
1	TRANE	CGAM	148/175	70		5,569	SCROLL	460v/3ø/60hz	R410A	
NOTES: 1).										

CHW Pump Schedule (Armstrong)													
Unit #	Model Number / Series	Model Size	Inlet	Discharge	Flow (GPM)	Total Head (FT)	Type	H.P.	RPM	Electric Power	Construction	Fluid Pumped	Fluid Temp
CHWP #1	4030	3x2x10	3"	2"	165	80	Base Mount	7.5	1770	460V/3ø / 60Hz	Cast Iron	Water/Glycol (25% Glycol)	42°

EXHAUST FAN SCHEDULE (DELHI)												
UNIT #	FAN TYPE	MANUFACTURER	LOCATION	AREA SERVED	DESIGN SCFM	FAN MODEL / SIZE	TSP	MOTOR HP	FAN RPM	ELECT. POWER	F.L.A.	UNIT WEIGHT
1	BACKWARD INCLINE	DELHI	ON CONCRETE PAD AT EXTERIOR OF BUILDING	800 AREA CLEANROOMS	6,180	BI-20	3.5	7.5	1,838	460V/3ø/60hz	8.85	356 lbs

VENTILATION CALCULATIONS, 797 CLEANROOM AREA

CODE REFERENCE: 2006 IMC, TABLE 403.3, SPACE DEFINED AS "LABORATORY"

MAXIMUM OCCUPANCY: 6 PERSONS TOTAL

VENTILATION REQUIRED BY REFERENCED CODE: 20cfm/PERSON = 120cfm

VENTILATION SUPPLIED SHALL BE NO LESS THAN 120cfm, WITH A MAXIMUM OF 340cfm SUPPLIED. VENTILATION (MAKE-UP AIR) SHALL MODULATE BETWEEN MINIMUM AND MAXIMUM VALUES TO MAINTAIN CLEANROOM PRESSURE VALUES AS NECESSARY.

VENTILATION CALCULATIONS, 800 CLEANROOM AREA

CODE REFERENCE: 2006 IMC, TABLE 403.3, SPACE DEFINED AS "LABORATORY"

MAXIMUM OCCUPANCY: 6 PERSONS TOTAL

VENTILATION REQUIRED BY REFERENCED CODE: 20cfm/PERSON = 120cfm



VENTILATION SUPPLIED SHALL BE NO LESS THAN 120cfm, WITH A MAXIMUM OF 6,180cfm SUPPLIED. VENTILATION (MAKE-UP AIR) SHALL MODULATE BETWEEN MINIMUM AND MAXIMUM VALUES TO MAINTAIN CLEANROOM PRESSURE VALUES AS NECESSARY.

THIS DRAWING CONTAINS DESIGNS AND OTHER INFORMATION THAT ARE THE PROPERTY OF CLEAN AIR TECHNOLOGY, INC. THIS DRAWING MAY NOT BE REPRODUCED, COPIED, OR IN PART, BE USED FOR ANY OTHER PROJECT WITHOUT THE WRITTEN PERMISSION OF CLEAN AIR TECHNOLOGY, INC. ANY COPIES OF THIS DRAWING OR ANY PART THEREOF, INCLUDING ANY INFORMATION CONTAINED HEREIN, ARE TO BE RETURNED TO CLEAN AIR TECHNOLOGY, INC. ON REQUEST. CLEAN AIR TECHNOLOGY, INC. WILL ELECT TO TAKE ALL NECESSARY ACTION TO ENFORCE ITS RIGHTS TO THIS PROPRIETARY INFORMATION.

REV.	NUM.	REV. DATE	REVISION DESCRIPTION
A	1	07-18-18	REVISED
B	1	07-25-18	REVISED
C	1	08-29-18	REVISED
D	1	08-30-18	REVISED
E	1	09-12-18	REVISED
F	1	09-12-18	ISSUED FOR CONSTRUCTION
G	1	01-28-19	AS-BUILT

CUSTOMER	
PROJECT TITLE	USP 797 / USP 800 CLEANROOMS
PROJECT LOCATION	
C.A.T. JOB NUMBER	18-142
ORIGINAL DATE:	07-18-18
DRAWN BY:	DWS
SCALE:	NONE
DESCRIPTION:	
MECHANICAL EQUIPMENT SCHEDULES AND TYPICAL MECHANICAL DETAILS	
DRAWING #:	CR-310

AS-BUILT DRAWING SET

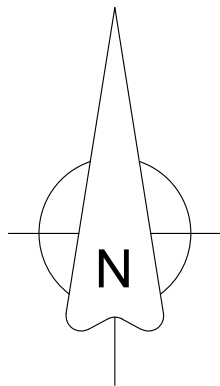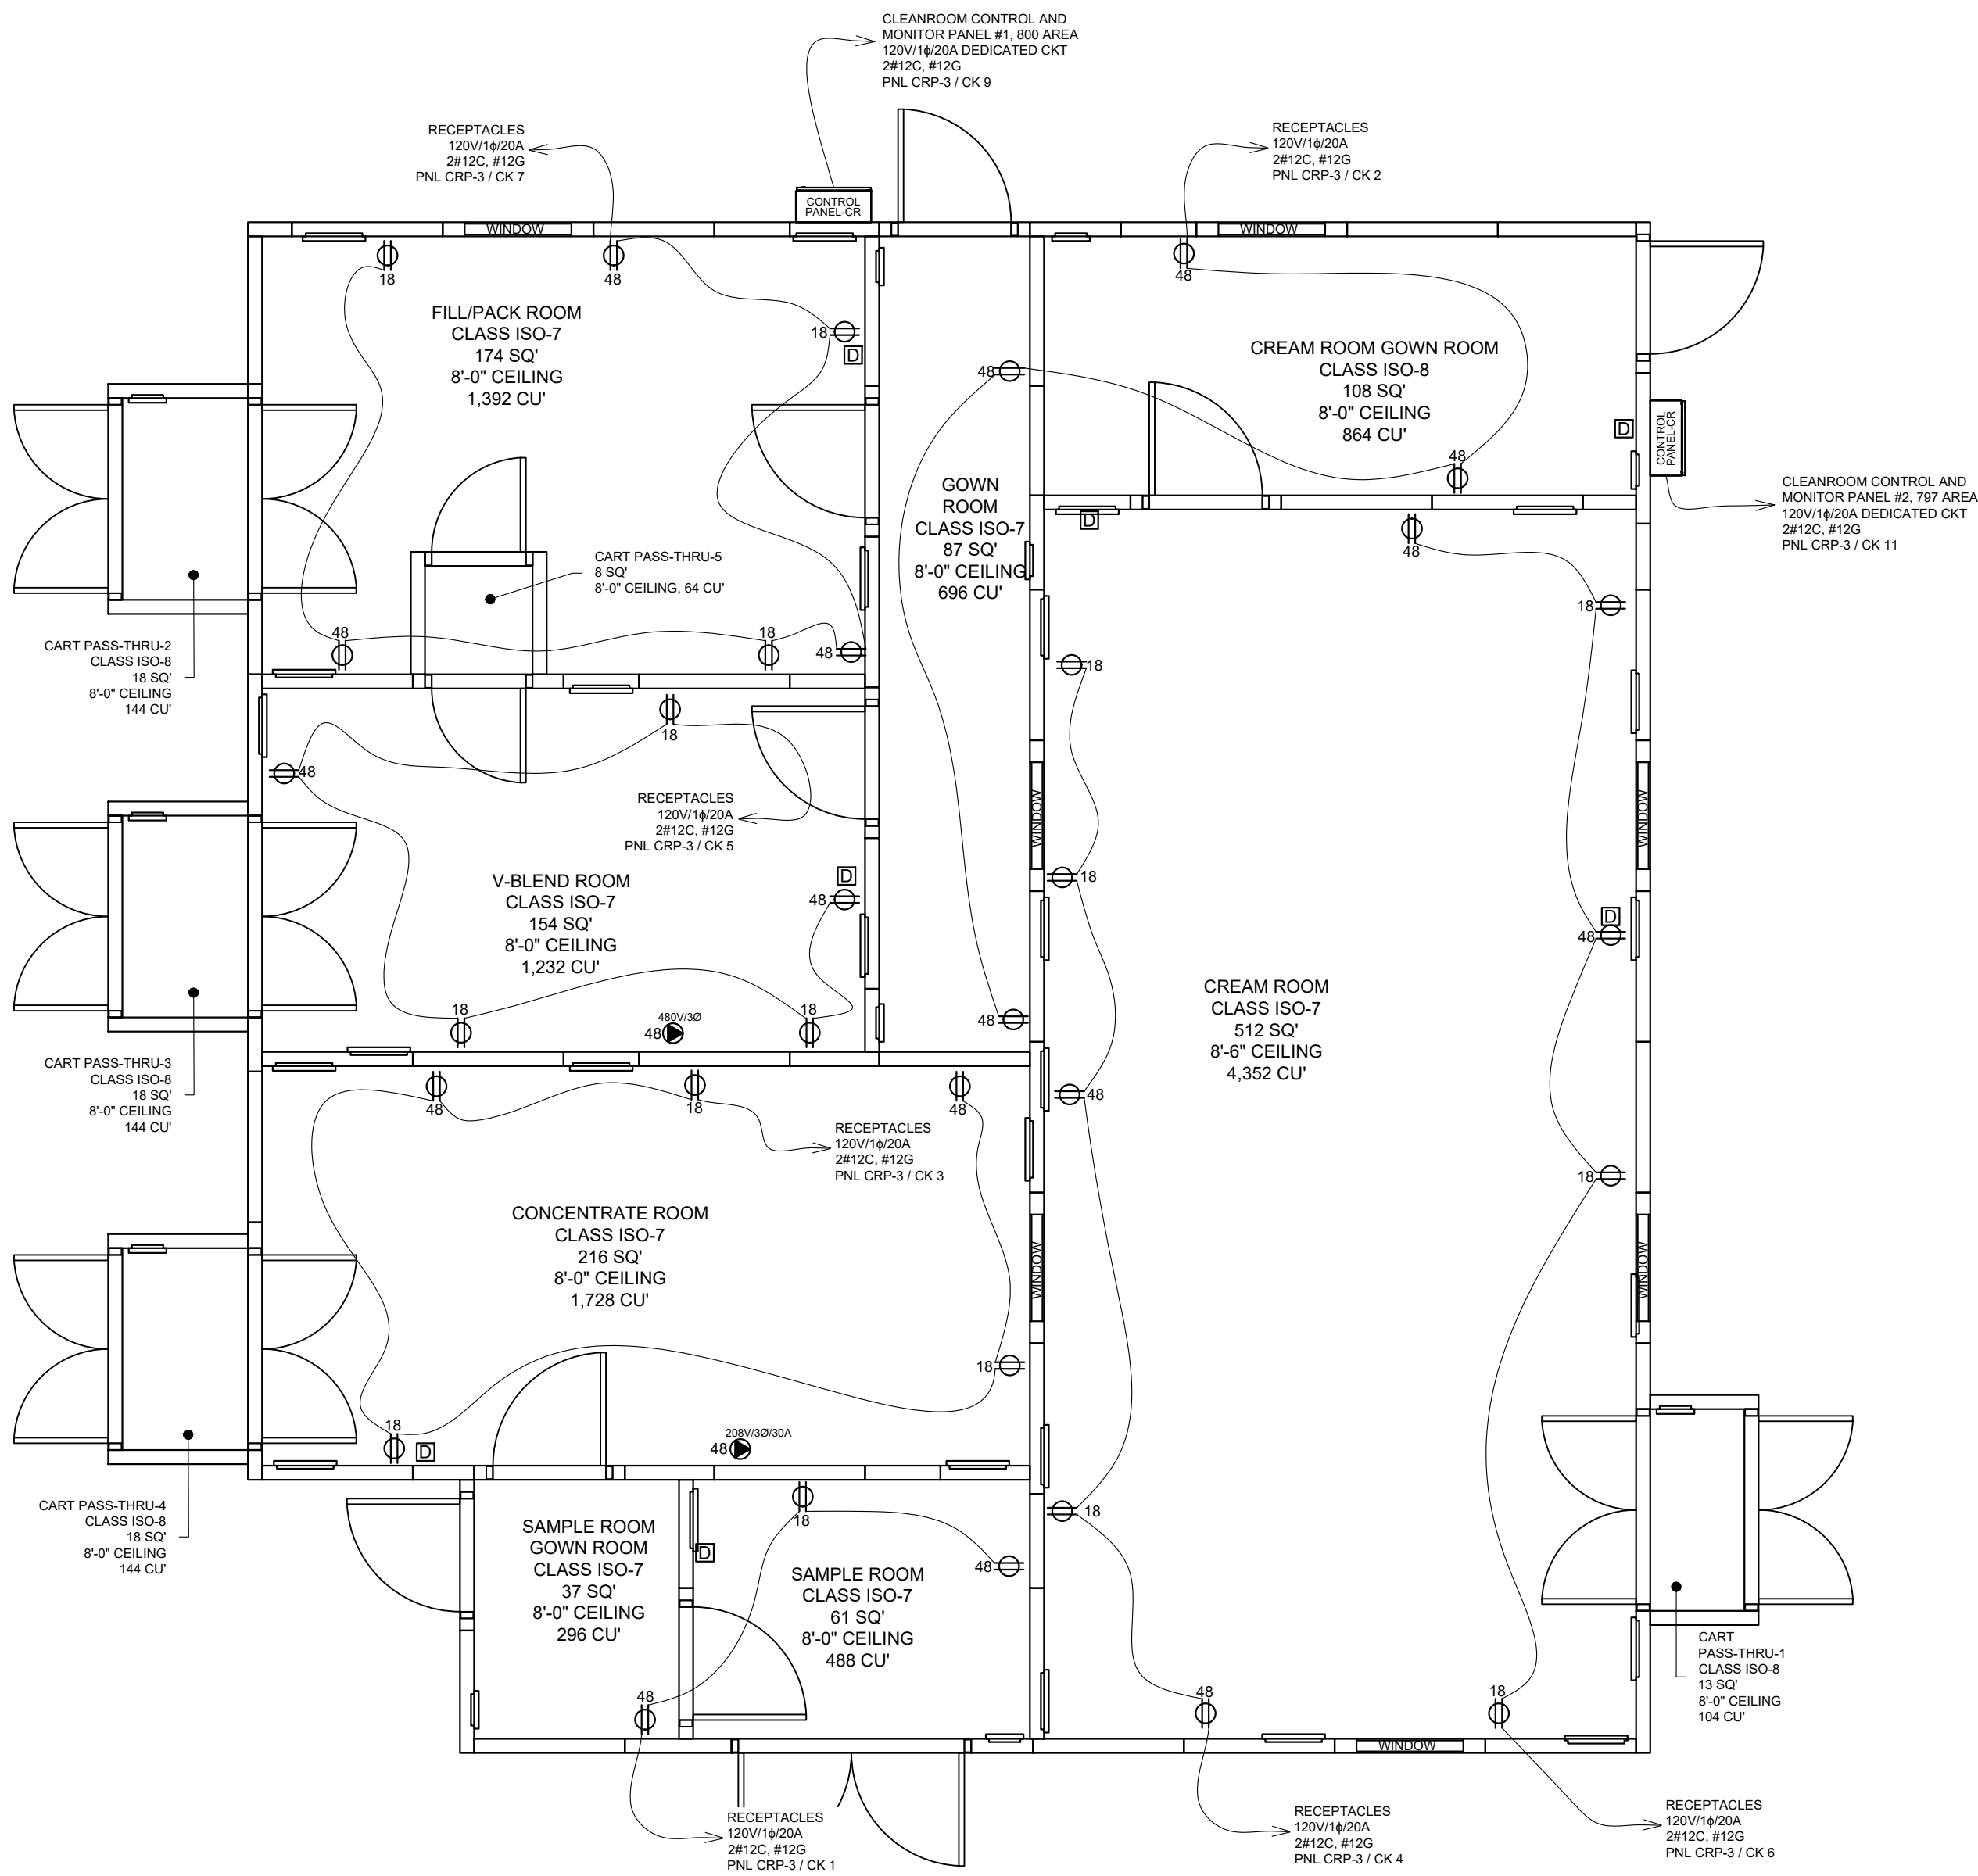


- GENERAL ELECTRICAL NOTES:
1. ALL ELECTRICAL WORK DONE IN ACCORDANCE WITH THE LATEST EDITION OF THE N.E.C.
 2. ALL ELECTRICAL WORK PERFORMED BY LICENSED CONTRACTORS AND COMPLIES WITH ALL APPLICABLE FEDERAL STATE, AND LOCAL BUILDING CODES.
 3. ALL ELECTRICAL DEVICES AND COMPONENTS INSTALLED IN CLEANROOM WALLS OR PLENUM(S) ABOVE CLEANROOM CEILING(S) ARE PLENUM RATED.

LEGEND	
18	DUPLEX RECEPTACLE OUTLET, 120V/1Ø/20A, 18" A.F.F. ON CENTER
48	DUPLEX RECEPTACLE OUTLET, 120V/1Ø/20A, 48" A.F.F. ON CENTER
J	J-BOX WITH CONDUIT AND PULL-STRING FOR DATA TERMINAL, 36" A.F.F. ON CENTER, UNLESS NOTED OTHERWISE
V	SPECIAL RECEPTACLE OUTLET, TEXT IDENTIFIES VOLTAGE, 48" A.F.F. ON CENTER FED FROM EXISTING BUILDING POWER SOURCES, WIRING AND CONNECTIONS BY OTHERS

208/120 V PANEL CRP-3														
LOAD (KVA)			DESCRIPTION	WIRE SIZE	BRKR RAT'G	CKT. NO.		CKT. NO.	BRKR RAT'G	WIRE SIZE	DESCRIPTION	LOAD (KVA)		
A	B	C										A	B	C
0.54			RECEPTACLES	12	20/1	1		2	20/1	12	RECEPTACLES	0.72		
	1.08		RECEPTACLES	12	20/1	3		4	20/1	12	RECEPTACLES		0.90	
		1.08	RECEPTACLES	12	20/1	5		6	20/1	12	RECEPTACLES			0.90
1.08			RECEPTACLES	12	20/1	7		8	20/1	12	INTERLOCKS	0.60		
	0.48		CNTL RM PNL-1(800)	12	20/1	9		10	20/1	-	SPARE		0.00	
		0.48	CNTL RM PNL-2 (797)	12	20/1	11		12	20/1	-	SPARE			0.00
0.00			SPARE	-	20/1	13		14	20/1	12	TOP DECK RECPT	0.18		
	0.00		SPARE	-	20/1	15		16	20/1	12	CHILLER AREA RECPT		0.18	
		0.00	SPARE	-	20/1	17		18	20/1	-	SPARE			0.00
0.00			SPARE	-	20/1	19		20	20/1	-	SPARE	0.00		
		0.00	SPARE	-	20/1	21		22	20/1	-	SPARE		0.00	
		0.00	SPARE	-	20/1	23		24	20/1	-	SPARE			0.00
TYPE: BRANCH CIRCUIT			GROSS PHASE TOTALS					CONNECTED LOAD			22.8 AMPERES			
MOUNTING: SURFACE			A= 3.12 KVA					LIGHTING			0.00 KVA			
SUPPLY: 208/120V, 3-PH, 4W			B= 2.64 KVA					HEATING			0.00 KVA			
MAINS: 100 AMP			C= 2.46 KVA					A/C MOTORS & HEAT PUMPS			0.00 KVA			
SCIR: BY CONTRACTOR								AIR HANDLING & EXH FANS			0.00 KVA			
NOTES:								RECEPTACLES			6.30 KVA			
1. WITH GROUND BUS								ELECTRIC WATER HEATING			0.00 KVA			
2. WITH NEUTRAL BUS								ELEVATORS			0.00 KVA			
								FOOD PROCESSING			0.00 KVA			
								PROCESS			0.00 KVA			
								MISCELLANEOUS			1.92 KVA			
								TOTAL CONNECTED LOAD			8.22 KVA			
18-142 - FAGRON-HUMCO														
SCHEDULED BY: GWM														

CLEAN AIR TECHNOLOGY, INC.
Decades of Experience Building America's Cleanrooms
41105 Capital, Canton, MI 48187 Tel 734-459-6320 Fax 734-459-9437
www.cleanairtechnology.com

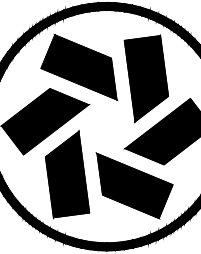

THIS DRAWING CONTAINS DESIGNS AND OTHER INFORMATION THAT IS THE PROPERTY OF CLEAN AIR TECHNOLOGY, INC. THIS DRAWING MAY NOT BE REPRODUCED OR TRANSMITTED IN ANY FORM OR BY ANY MEANS, ELECTRONIC OR MECHANICAL, INCLUDING PHOTOCOPYING, RECORDING, OR BY ANY INFORMATION STORAGE AND RETRIEVAL SYSTEM, WITHOUT THE WRITTEN PERMISSION OF CLEAN AIR TECHNOLOGY, INC. ANY COPIES OF THIS DRAWING MADE FOR OTHER THAN THE PROJECT SPECIFICALLY IDENTIFIED HEREIN ARE UNAUTHORIZED. THE USER OF THIS DRAWING AGREES TO HOLD CLEAN AIR TECHNOLOGY, INC. HARMLESS FROM AND AGAINST ALL CLAIMS, DAMAGES, LOSSES AND EXPENSES, INCLUDING REASONABLE ATTORNEY'S FEES, THAT MAY BE ASSERTED AGAINST CLEAN AIR TECHNOLOGY, INC. BY ANY THIRD PARTY AS A RESULT OF THE USER'S USE OF THIS DRAWING. THIS DRAWING IS TO BE RETURNED TO CLEAN AIR TECHNOLOGY, INC. ON REQUEST. CLEAN AIR TECHNOLOGY, INC. WILL ELECT TO TAKE ALL NECESSARY ACTION TO ENFORCE ITS RIGHTS TO THIS PROPRIETARY INFORMATION.

REV. NUM.	REV. DATE	REVISION DESCRIPTION	BY	CHKD	APP'D
A	02-25-18	REVISED	DWS		
B	02-17-18	REVISED PER P.E. REVIEW	DWS		
C	09-11-18	ISSUED FOR CONSTRUCTION	DWS		
00	09-13-18	ISSUED FOR CONSTRUCTION	DWS		
02	01-26-19	AS-BUILT	DWS		
03					
04					
05					
06					
07					
08					
09					
10					
11					
12					
13					
14					
15					
16					
17					
18					
19					
20					
21					
22					
23					
24					

CUSTOMER


PROJECT TITLE
USP 797 / USP 800
CLEANROOMS

PROJECT LOCATION


C.A.T. JOB NUMBER 18-142
ORIGINAL DATE: 07-18-18
DRAWN BY: DWS
SCALE: 1/4" = 1'-0"

DESCRIPTION:
ELECTRICAL FLOOR PLAN

DRAWING #: CR-400

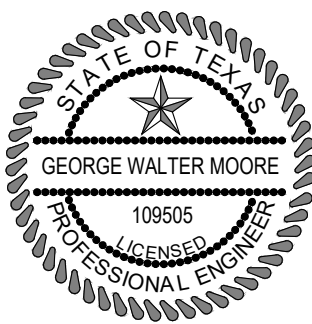

AS-BUILT DRAWING SET

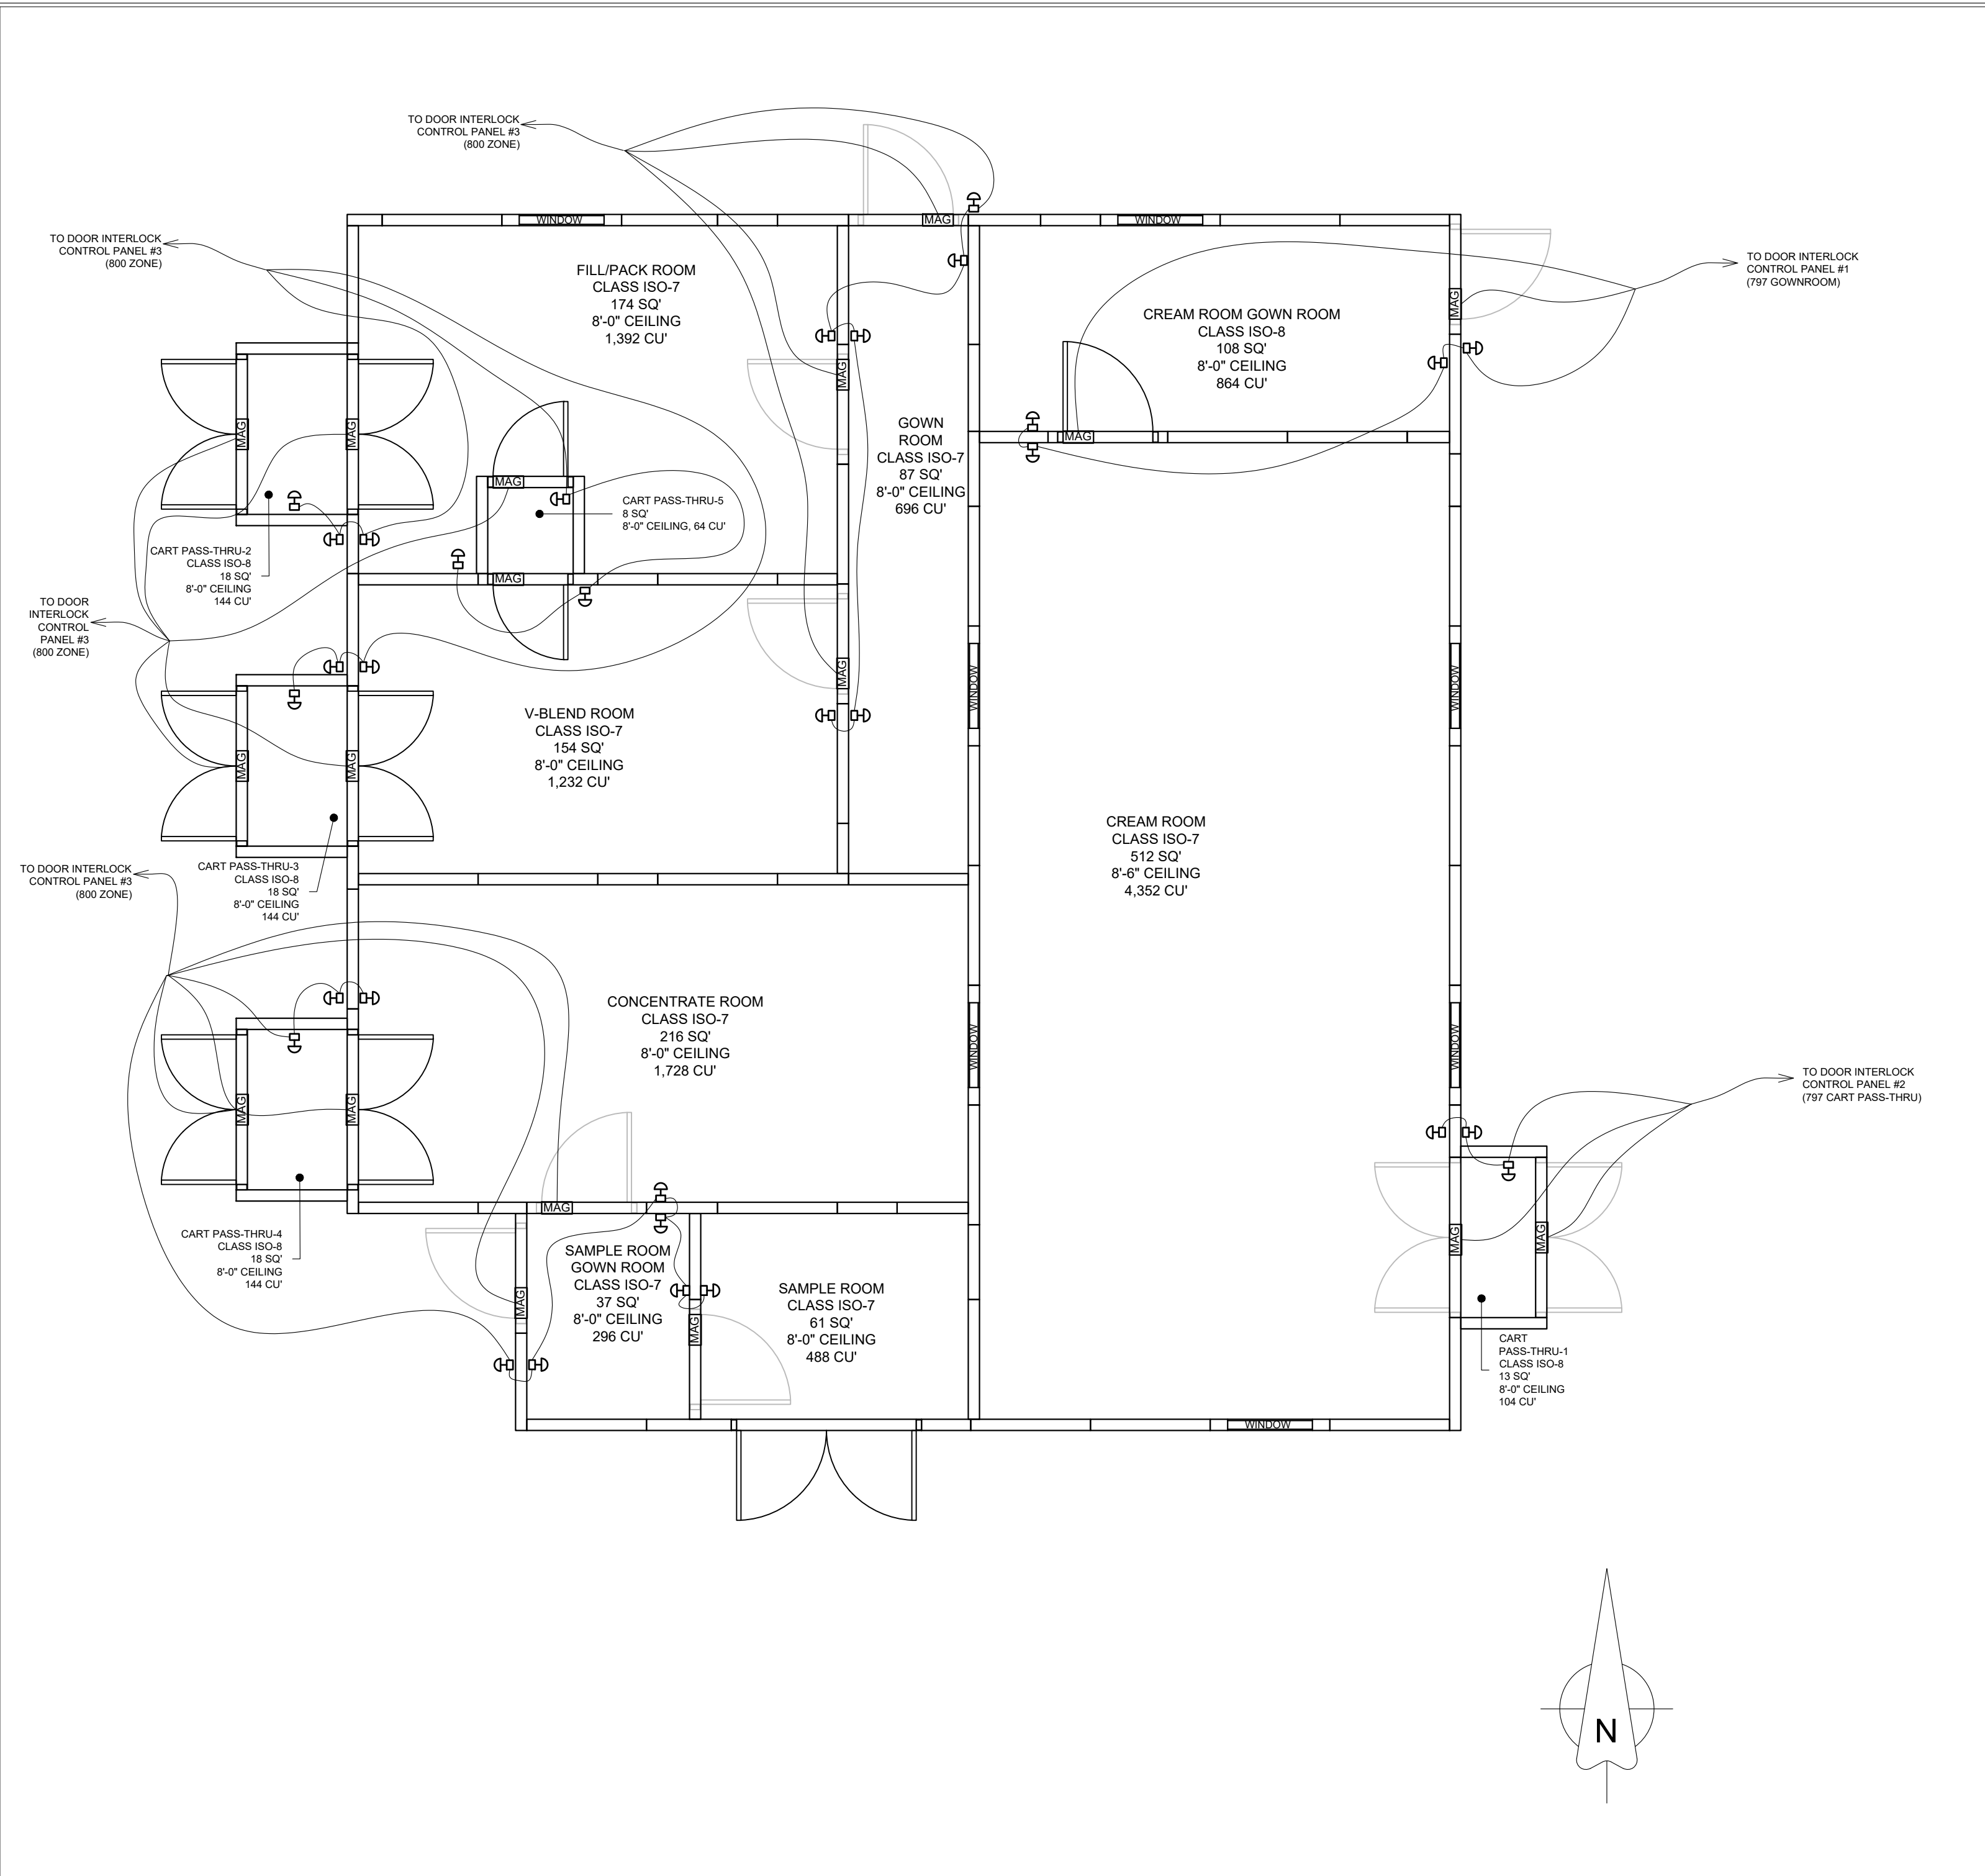

- GENERAL ELECTRICAL NOTES:
1. ALL ELECTRICAL WORK DONE IN ACCORDANCE WITH THE LATEST EDITION OF THE N.E.C.
 2. ALL ELECTRICAL WORK PERFORMED BY LICENSED CONTRACTORS AND COMPLIES WITH ALL APPLICABLE FEDERAL STATE, AND LOCAL BUILDING CODES.
 3. ALL ELECTRICAL DEVICES AND COMPONENTS INSTALLED IN CLEANROOM WALLS OR PLENUM(S) ABOVE CLEANROOM CEILING(S) ARE PLENUM RATED.

LEGEND

MAG DOOR INTERLOCK MAGNET ON ACTIVE LEAF

DD PUSH-BUTTON SAFETY OVERRIDE FOR INTERLOCKED DOOR(S), 48" A.F.F. ON CENTER

NOTE:
DOOR INTERLOCK CONTROL PANELS MOUNTED TO FRAME ON TOP DECK
SEE DRAWING CR-403 FOR LOCATION OF INTERLOCK CONTROL PANELS

CLEAN AIR TECHNOLOGY, INC.
Decades of Experience Building America's Cleanrooms
41105 Capital, Canton, MI 48187 Tel 734-459-6320 Fax 734-459-9437
www.cleanairtechnology.com

THIS DRAWING CONTAINS DESIGNS AND OTHER INFORMATION
THIS DRAWING MAY NOT BE REPRODUCED OR TRANSMITTED IN ANY FORM OR BY ANY MEANS, ELECTRONIC OR MECHANICAL, INCLUDING PHOTOCOPYING, RECORDING, OR BY ANY INFORMATION STORAGE AND RETRIEVAL SYSTEM, WITHOUT THE WRITTEN PERMISSION OF CLEAN AIR TECHNOLOGY, INC. ANY COPIES OF THIS DRAWING
UNDER THE TERMS OF A CONTRACT OR OTHERWISE, ARE TO
BE RETURNED TO CLEAN AIR TECHNOLOGY, INC. ON REQUEST
ACCOMPLISHED. CLEAN AIR TECHNOLOGY, INC. WILL ELECT TO
TAKE ALL NECESSARY ACTION TO ENFORCE ITS RIGHTS TO
THIS PROPRIETARY INFORMATION

REV. NUM.	REV. DATE	REVISION DESCRIPTION	BY
A	02-25-18	REVISED	DWS
B	09-10-18	REVISED PER P.E. REVIEW	DWS
C	09-11-18	ISSUED FOR CONSTRUCTION	DWS
00	09-13-18	ISSUED FOR CONSTRUCTION	DWS
01	09-26-18	AS-BUILT REVISIONS	DWS
02			
03			
04			
05			
06			
07			
08			
09			
10			
11			
12			
13			
14			
15			
16			
17			
18			
19			
20			


CUSTOMER

PROJECT TITLE
USP 797 / USP 800
CLEANROOMS


PROJECT LOCATION

C.A.T. JOB NUMBER	18-142
ORIGINAL DATE:	07-18-18
DRAWN BY:	DWS
SCALE:	1/4" = 1'-0"
DESCRIPTION:	DOOR INTERLOCKS

DRAWING #: CR-402

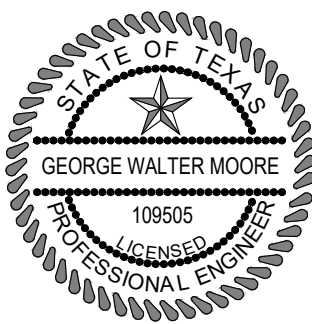

AS-BUILT DRAWING SET

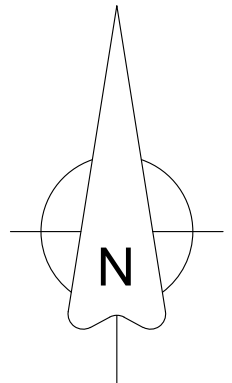


480/277 V PANEL CRP-1 (EXISTING)

18-142 - FAGRON- HUMCO

18-142 - FAGRON-HUMCO18-142 - FAGRON-HUMCO

	REV. NUM.	REV. DATE	REVISION DESCRIPTION	BY
	A	08-20-18	REVISED	DWS
	B	08-22-18	REVISED	DWS
	C	08-24-18	REVISED	DWS
	D	08-26-18	REVISED	DWS
	E	09-07-18	REVISED PER P.E. REVIEW	DWS
	F	09-11-18	REVISED PER P.E. REVIEW	DWS
	G	09-13-18	ISSUED FOR CONSTRUCTION	DWS
	H	01-28-19	AS-BUILT	DWS
	I	--	--	--
	J	--	--	--
	K	--	--	--
	L	--	--	--
	M	--	--	--
	N	--	--	--
	O	--	--	--
	P	--	--	--
	Q	--	--	--
	R	--	--	--
	S	--	--	--
	T	--	--	--
	U	--	--	--
	V	--	--	--
	W	--	--	--
	X	--	--	--
	Y	--	--	--
	Z	--	--	--


DRAWING #:	CR-403
------------	--------

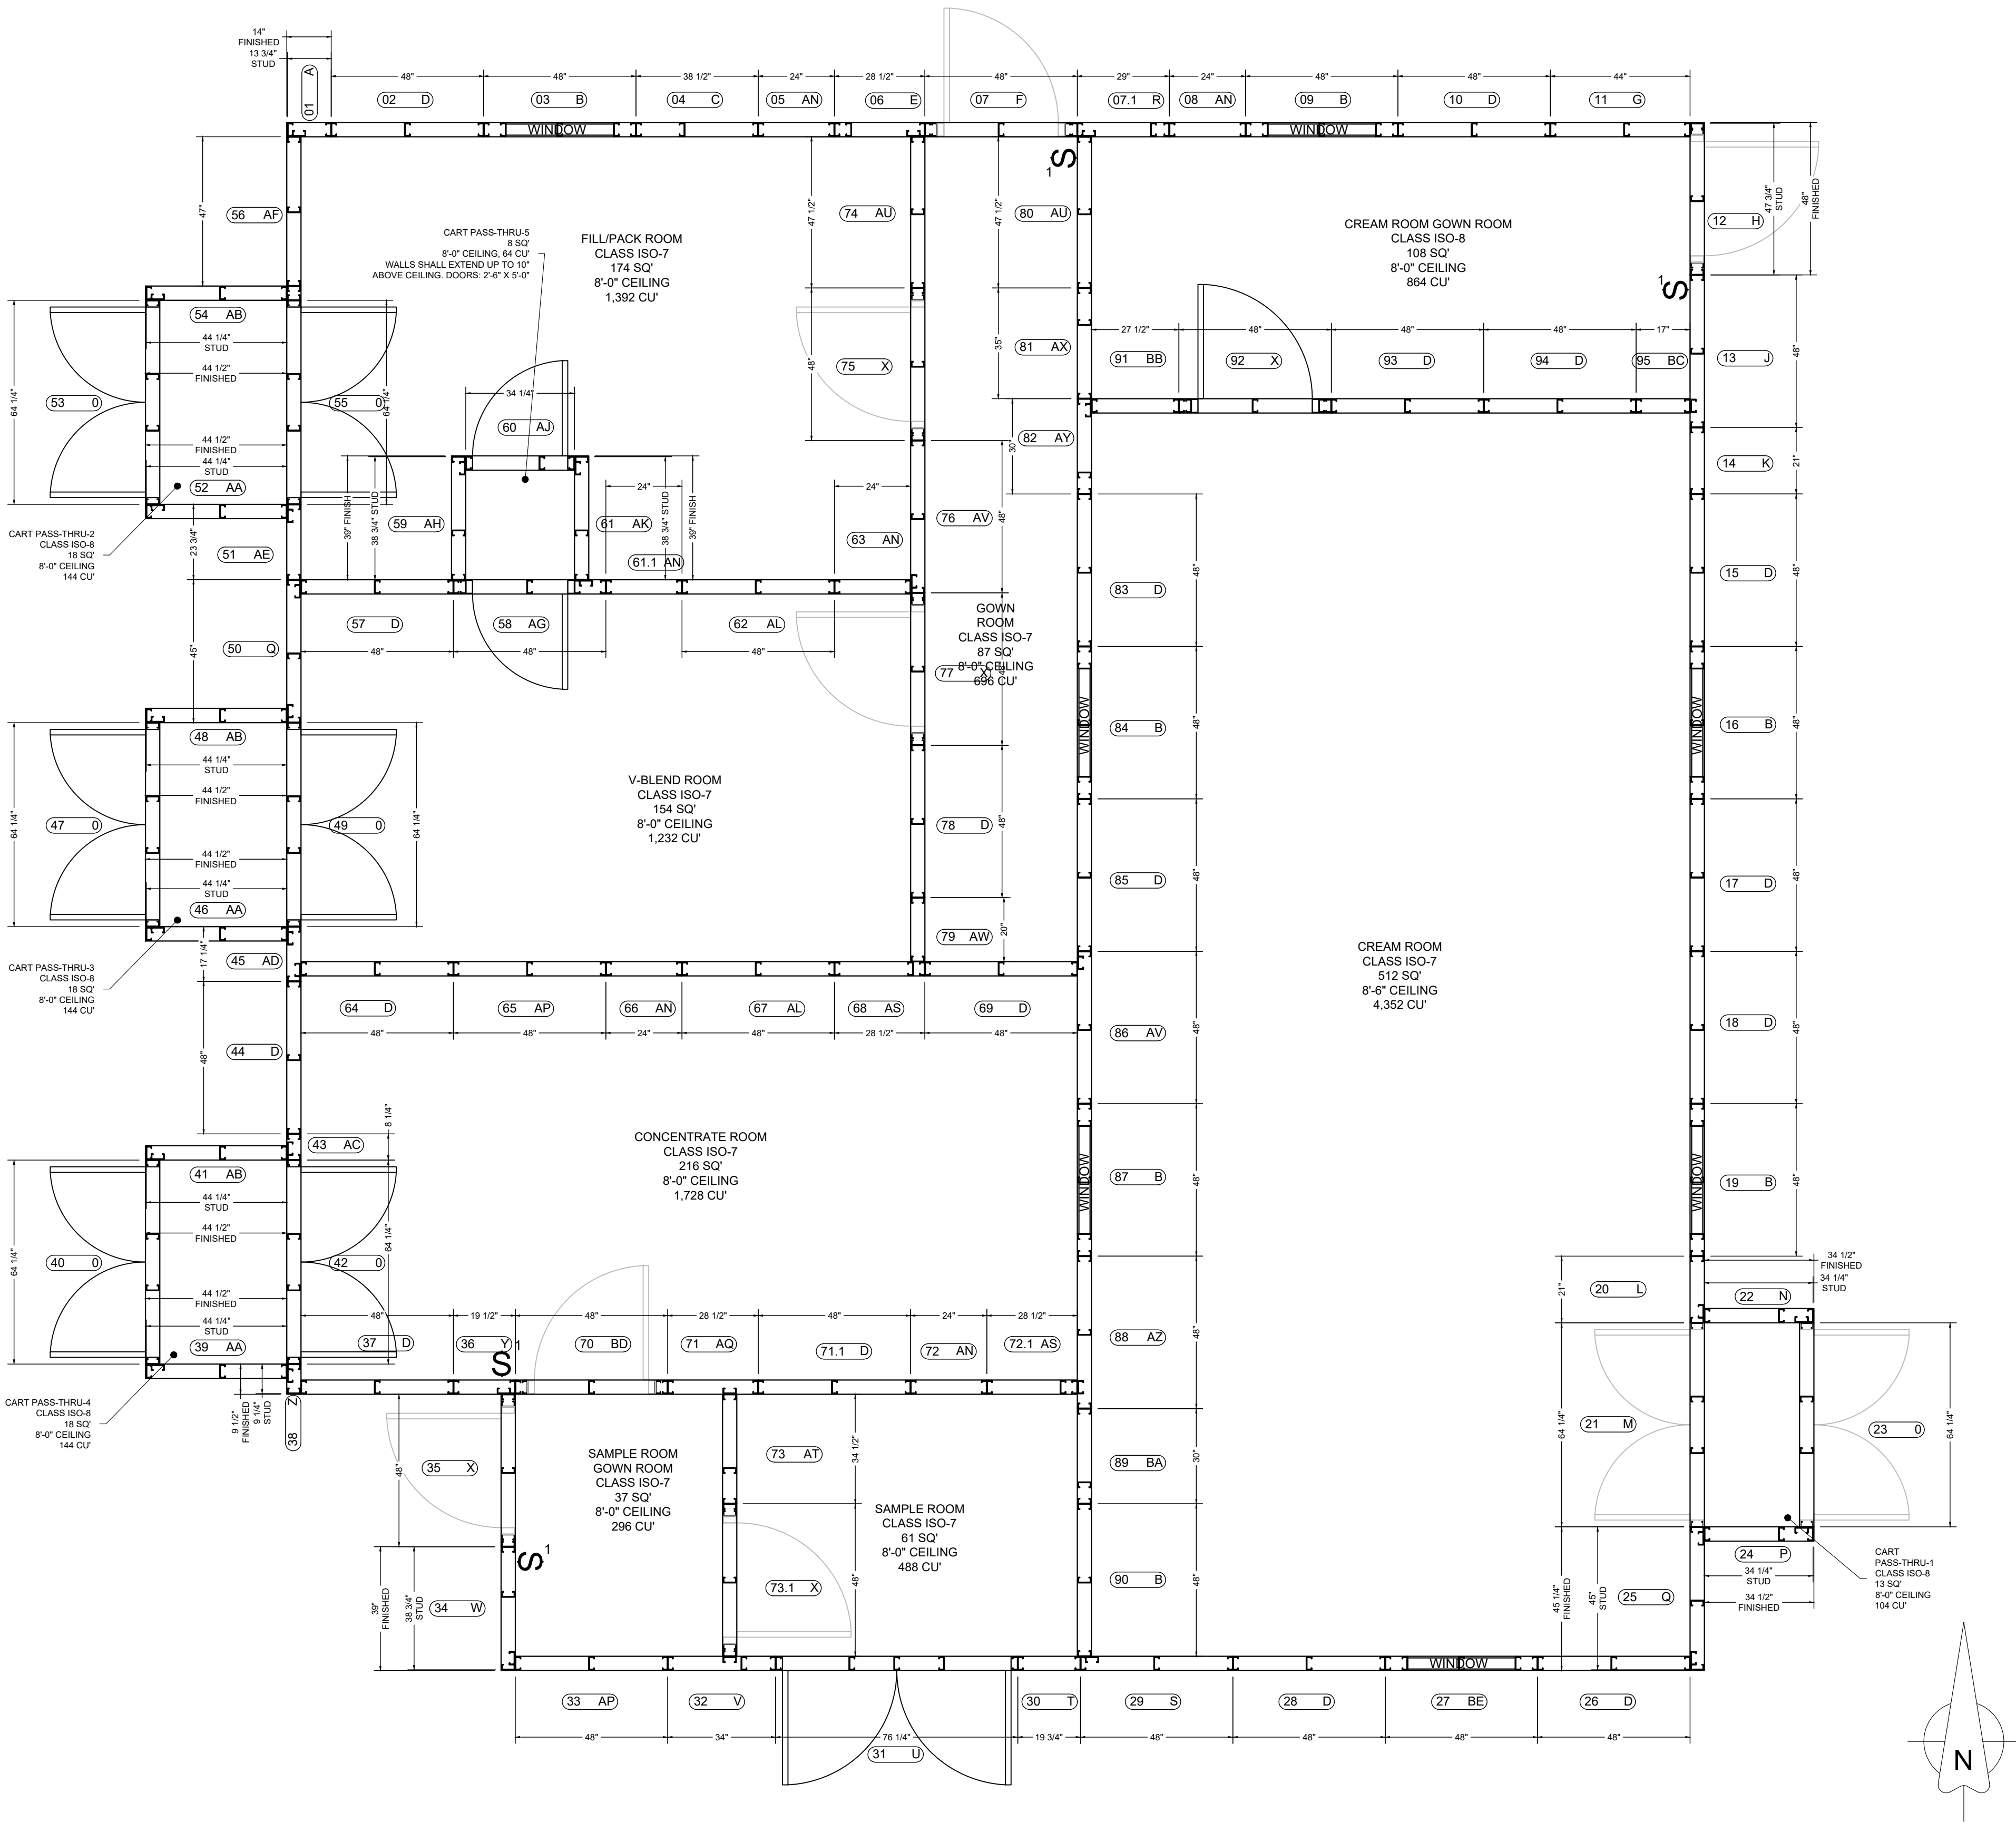

AS-BUILT DRAWING SET

18-142 WALL FRAME TABLE				
Frame Number	Letter Code	Width	Height	Stud
01	A	13-3/4"	138"	400S162-43
02	D	48"	138"	400S162-43
03	B	48"	138"	400S162-43
04	C	36-1/2"	138"	400S162-43
05	AN	24"	138"	400S162-43
06	E	28-1/2"	138"	400S162-43
07	F	48"	138"	400S162-43
07.1	R	29"	138"	400S162-43
08	AN	24"	138"	400S162-43
09	B	48"	138"	400S162-43
10	D	48"	138"	400S162-43
11	G	44"	138"	400S162-43
12	H	47-3/4"	138"	400S162-43
13	J	48"	138"	400S162-43
14	K	21"	138"	400S162-43
15	D	48"	138"	400S162-43
16	B	48"	138"	400S162-43
17	D	48"	138"	400S162-43
18	D	48"	138"	400S162-43
19	B	48"	138"	400S162-43
20	L	21"	138"	400S162-43
21	M	64-1/4"	51-3/4"	400S162-43
22	N	34-1/4"	138"	400S162-43
23	O	64-1/4"	51-3/4"	400S162-43
24	P	34-1/4"	138"	400S162-43
25	Q	45"	138"	400S162-43
26	D	48"	138"	400S162-43
27	AF	48"	138"	400S162-43
28	D	48"	138"	400S162-43
29	S	48"	138"	400S162-43
30	T	19-3/4"	138"	400S162-43
31	U	76-1/4"	51-3/4"	400S162-43
32	V	34"	138"	400S162-43
33	AP	48"	138"	400S162-43
34	W	38-3/4"	138"	400S162-43
35	X	48"	138"	400S162-43
36	Y	19-1/2"	138"	400S162-43
37	D	48"	138"	400S162-43
38	Z	9-1/4"	138"	400S162-43
39	AA	44-1/4"	138"	400S162-43
40	O	64-1/4"	51-3/4"	400S162-43
41	AB	44-1/4"	138"	400S162-43
42	O	64-1/4"	51-3/4"	400S162-43
43	AC	8-1/4"	138"	400S162-43
44	D	48"	138"	400S162-43
45	AD	17-1/4"	138"	400S162-43
46	AA	44-1/4"	138"	400S162-43
47	O	64-1/4"	51-3/4"	400S162-43
48	AB	44-1/4"	138"	400S162-43
49	O	64-1/4"	51-3/4"	400S162-43
50	Q	45"	138"	400S162-43
51	AE	23-3/4"	138"	400S162-43
52	AA	44-1/4"	138"	400S162-43
53	O	64-1/4"	51-3/4"	400S162-43
54	AB	44-1/4"	138"	400S162-43
55	O	64-1/4"	51-3/4"	400S162-43
56	AF	47"	138"	400S162-43
57	D	48"	138"	400S162-43
58	AG	48"	138"	400S162-43
59	AH	38-3/4"	106"	400S162-43
60	AJ	43-3/4"	9-1/2"	400S162-43
61	AK	38-3/4"	106"	400S162-43
61.1	AN	24"	138"	400S162-43
62	AL	48"	138"	400S162-43
63	AN	24"	138"	400S162-43
64	D	48"	138"	400S162-43
65	AP	48"	138"	400S162-43
66	AN	24"	138"	400S162-43
67	AL	48"	138"	400S162-43
68	AS	28-1/2"	138"	400S162-43
69	D	48"	138"	400S162-43
70	BD	48"	138"	400S162-43
71	AQ	28-1/2"	138"	400S162-43
71.1	D	48"	138"	400S162-43
72	AN	24"	138"	400S162-43
72.1	AS	28-1/2"	138"	400S162-43
73	AT	34-1/2"	138"	400S162-43
73.1	X	48"	138"	400S162-43
74	AU	47-1/2"	138"	400S162-43
75	X	48"	138"	400S162-43
76	AV	48"	138"	400S162-43
77	X	48"	138"	400S162-43
78	D	48"	138"	400S162-43
79	AW	20"	138"	400S162-43
80	AU	47-1/2"	138"	400S162-43
81	AX	35"	138"	400S162-43
82	AY	30"	138"	400S162-43
83	D	48"	138"	400S162-43
84	B	48"	138"	400S162-43
85	D	48"	138"	400S162-43
86	AV	48"	138"	400S162-43
87	B	48"	138"	400S162-43
88	AZ	48"	138"	400S162-43
89	BA	30"	138"	400S162-43
90	B	48"	138"	400S162-43
91	BB	27-1/2"	138"	400S162-43
92	X	48"	138"	400S162-43
93	D	48"	138"	400S162-43
94	D	48"	138"	400S162-43
95	BC	17"	138"	400S162-43

CLEAN AIR TECHNOLOGY, INC.
Decades of Experience Building America's Cleanrooms
41105 Capital, Canton, MI 48187 Tel 734-459-6320 Fax 734-459-9437
www.cleanairtechnology.com

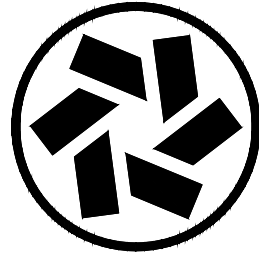

THIS DRAWING CONTAINS DESIGNS AND OTHER INFORMATION
THIS DRAWING MAY NOT BE REPRODUCED OR TRANSMITTED IN ANY FORM OR BY ANY MEANS, ELECTRONIC OR MECHANICAL, INCLUDING PHOTOCOPYING, RECORDING, OR BY ANY INFORMATION STORAGE AND RETRIEVAL SYSTEM, WITHOUT THE WRITTEN PERMISSION OF
CLEAN AIR TECHNOLOGY, INC. ANY COPIES OF THIS DRAWING
UNDER THE TERMS OF A CONTRACT OR OTHERWISE ARE TO
BE RETURNED TO CLEAN AIR TECHNOLOGY, INC. ON REQUEST
ACCOMPLISHED. CLEAN AIR TECHNOLOGY, INC. WILL ELECT TO
TAKE ALL NECESSARY ACTION TO ENFORCE ITS RIGHTS IN THIS
THIS PROPRIETARY INFORMATION

REV. NUM.	REV. DATE	REV. DESCRIPTION	BY	CHKD	APP'D
1	07-25-13	ISSUED FOR CONSTRUCTION	DWS		
2	08-17-18	REVISED	DWS		
3	08-22-18	REVISED	DWS		
4	08-24-18	REVISED	DWS		
5	08-24-18	REVISED	DWS		
6	08-24-18	REVISED	DWS		
95	08-24-18	REVISED	DWS		

CUSTOMER

PROJECT TITLE
USP 797 / USP 800
CLEANROOMS

PROJECT LOCATION

C.A.T. JOB NUMBER 18-142


ORIGINAL DATE: 07-17-18

DRAWN BY: DWS

SCALE: 3/8" = 1'-0"

DESCRIPTION:
WALL FRAME
NUMBERING PLAN

DRAWING #: CR-900

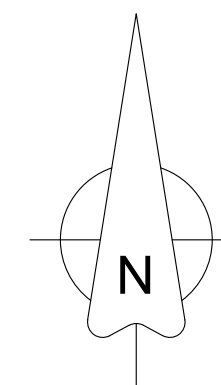


THIS DRAWING CONTAINS DESIGNS AND OTHER INFORMATION WHICH ARE THE PROPERTY OF CLEAN AIR TECHNOLOGY, INC. REPRODUCED OR USED FOR PURPOSES OF MANUFACTURE, OR OTHERWISE, WITHOUT PRIOR WRITTEN PERMISSION OF CLEAN AIR TECHNOLOGY, INC. ANY COPIES OF THIS DRAWING DISTRIBUTED FOR INFORMATION PURPOSES, WHETHER OR NOT FOR A SPECIFIC PROJECT, ARE TO BE RETURNED TO CLEAN AIR TECHNOLOGY, INC. ON REQUEST. AND WHEN THE PURPOSE FOR WHICH THEY WERE ISSUED IS ACCOMPLISHED, CLEAN AIR TECHNOLOGY, INC. WILL ELECT TO TAKE ALL NECESSARY ACTION TO ENFORCE ITS RIGHTS TO THIS PROPRIETARY INFORMATION.

REV.	NUM.	REV.	DATE	REVISION DESCRIPTION	BY
A	09-17-18	REVISED			DWS
B	09-24-18	REVISED			DWS
C	09-30-18	REVISED			DWS
00	09-21-18	ISSUED FOR CONSTRUCTION			DWS
01	01-28-19	AS-BUILT			DWS
02	02-01-19	AS-BUILT			02
03	02-01-19	AS-BUILT			02
04	02-01-19	AS-BUILT			02
100	02-01-19	AS-BUILT			02

DRAWING #: CR-901



AS-BUILT DRAWING SET

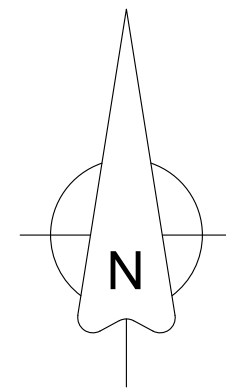

AS-BUILT DRAWING SET

REV.	NUM.	REV. DATE	REVISION DESCRIPTION	BY
00		09-21-18	ISSUED FOR CONSTRUCTION	DWS
01		01-28-19	AS-BUILT	DWS
	1			
	2			
	3			
	100			

DRAWING #:	CR-902
------------	--------

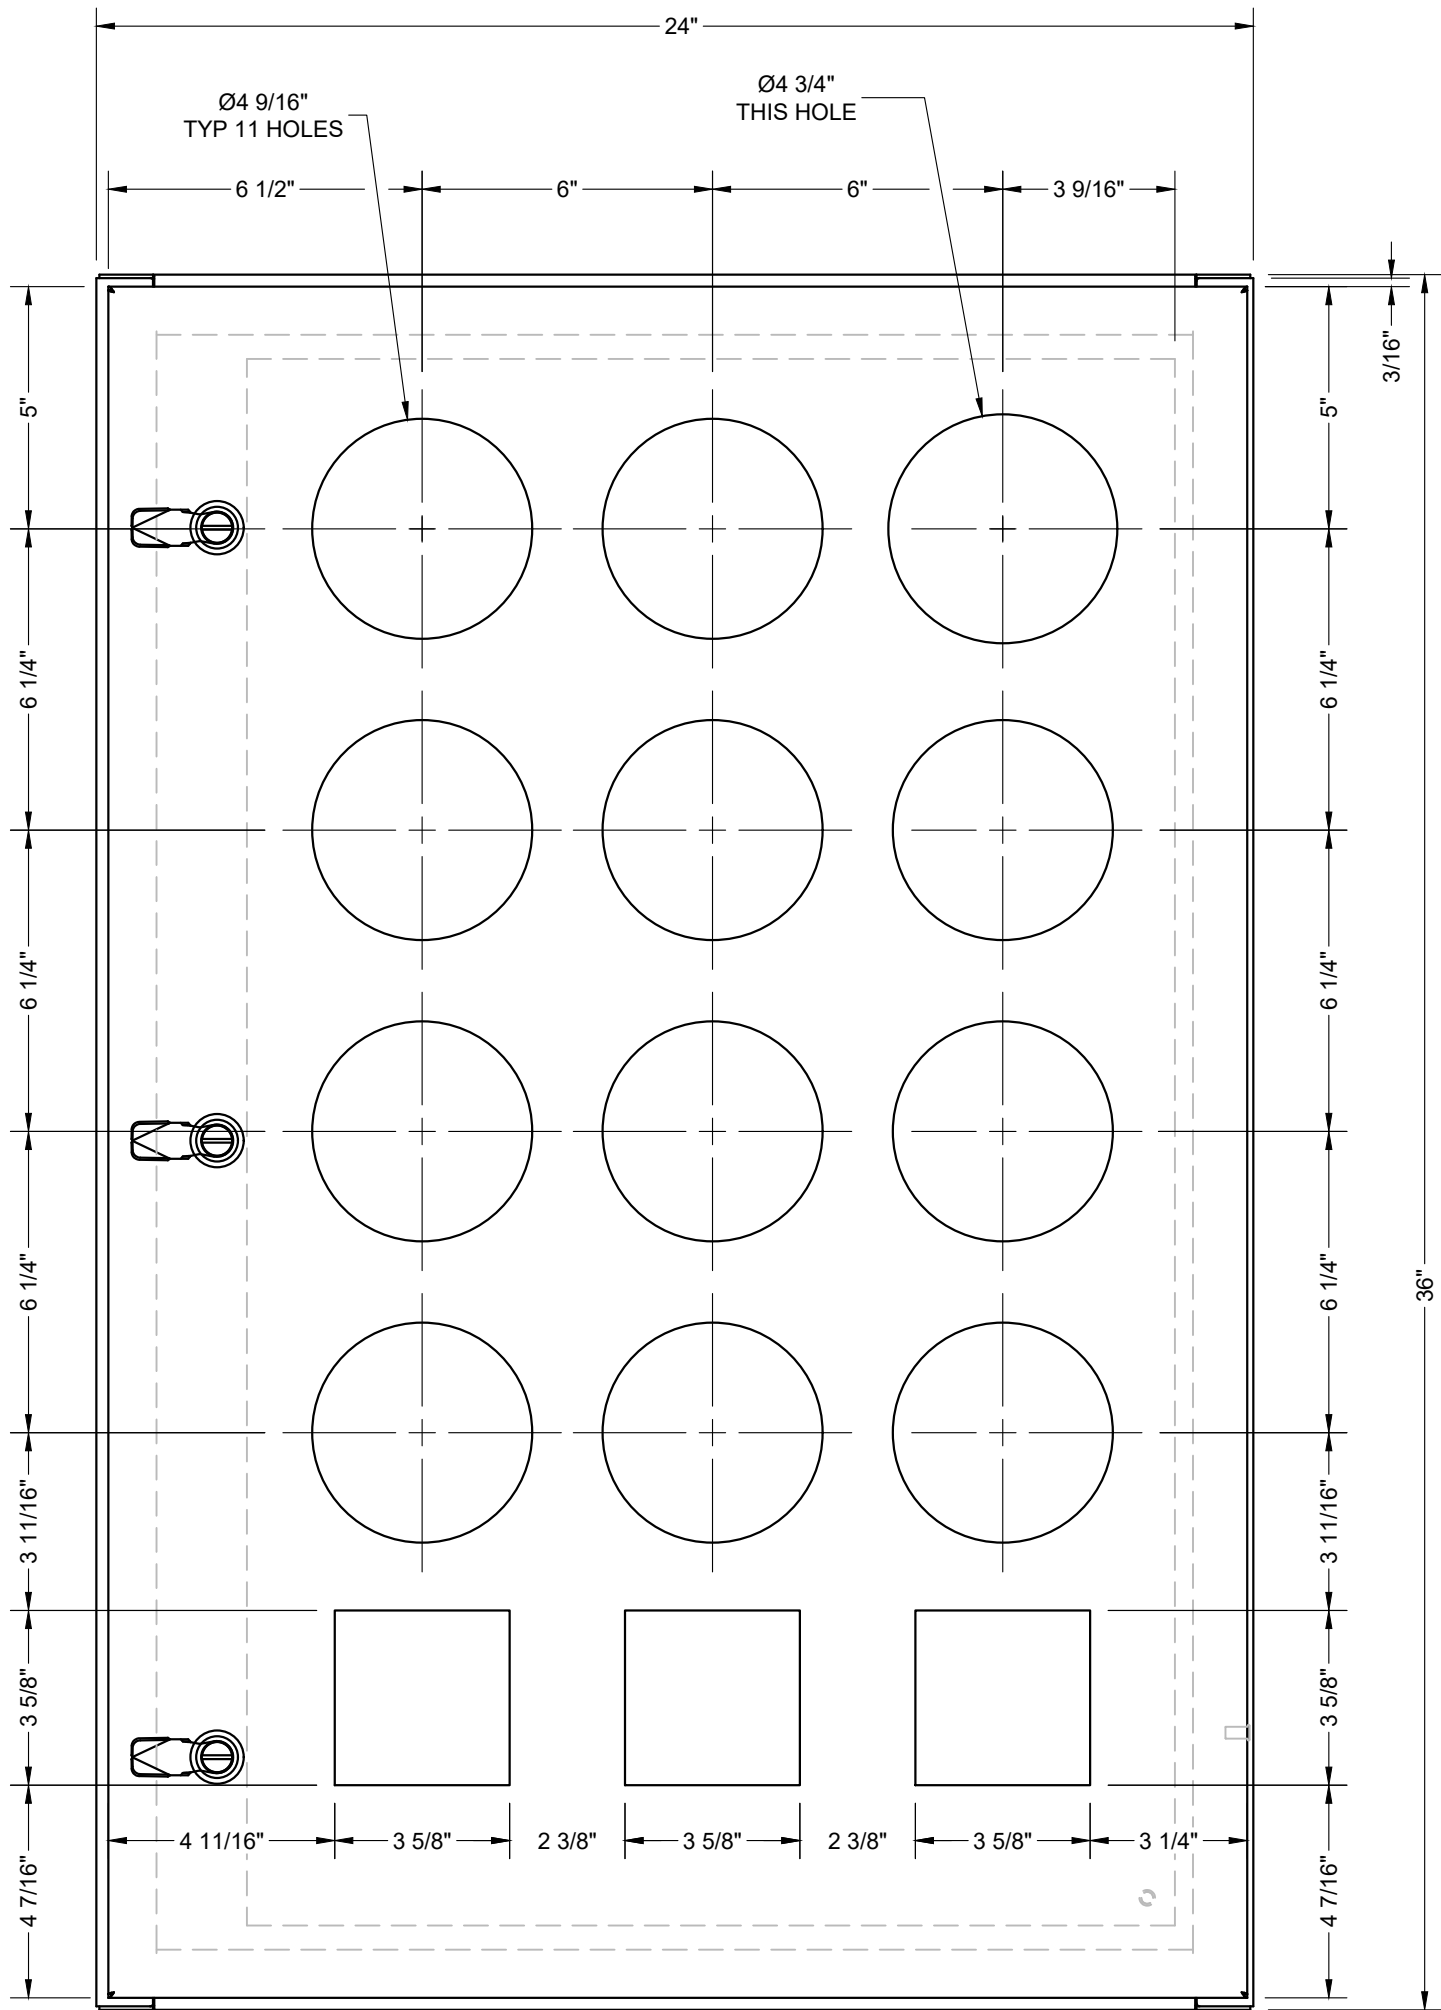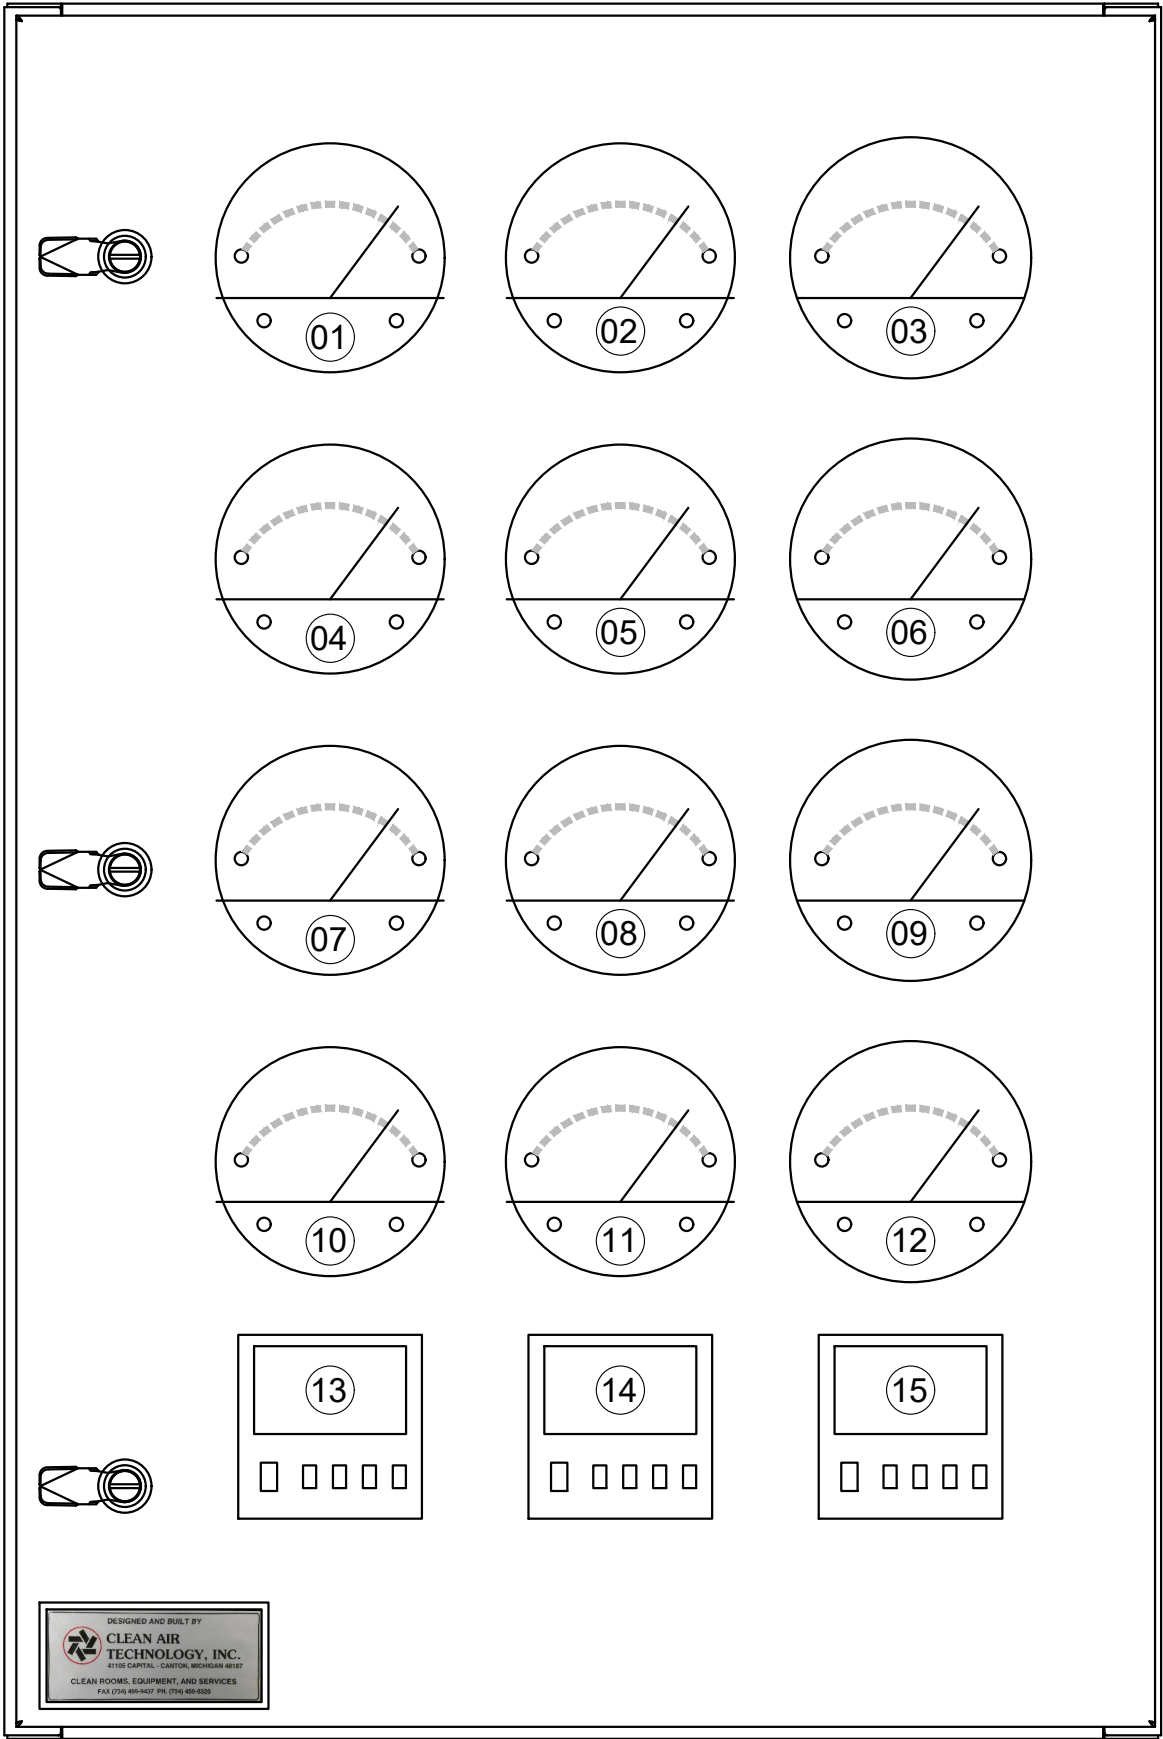

18-142 (USP800) CONTROL PANEL LAYOUT LIST				
(Panel Size - 24" wide x 36" tall)				
CONTROL #	CONTROL NAME	CONTROL TYPE	VENDOR	VENDOR PART #
01	V-Blend Room	Digital Magnahelic Gauge	Dwyer	DM2112-LCD
02	Gownroom	Digital Magnahelic Gauge	Dwyer	DM2112-LCD
03	Concentrate Room	Digihelic Pressure Controller	Dwyer	DH3-013
04	Fill / Pack Room	Digital Magnahelic Gauge	Dwyer	DM2112-LCD
05	Sample Room Gownroom	Digital Magnahelic Gauge	Dwyer	DM2112-LCD
06	Sample Room	Digital Magnahelic Gauge	Dwyer	DM2112-LCD
07	Cart Pass Thru-2	Digital Magnahelic Gauge	Dwyer	DM2112-LCD
08	Cart Pass Thru-3	Digital Magnahelic Gauge	Dwyer	DM2112-LCD
09	Cart Pass Thru-4	Digital Magnahelic Gauge	Dwyer	DM2112-LCD
10	RAHU-1 HEPA Supply	Digital Magnahelic Gauge	Dwyer	DM2105-LCD
11	RAHU-1 Pre-filter	Digital Magnahelic Gauge	Dwyer	DM2104-LCD
12	MUA-1 Pre-filter	Digital Magnahelic Gauge	Dwyer	DM2104-LCD
13	Temperature Controller	2-loop Controller	West	EC440R022MML99501
14	Humidity Controller	Single loop Controller	West	EC440R021MML99501
15	Make-up Air (MUA) Control	Single loop Controller	West	EC440R021MML99501

AS-BUILT DRAWING SET

THIS DRAWING CONTAINS DESIGNS AND OTHER INFORMATION
THIS DRAWING MAY NOT BE REPRODUCED OR COPIED
WITHOUT THE WRITTEN PERMISSION OF CLEAN AIR TECHNOLOGY, INC.
CLEAN AIR TECHNOLOGY, INC. ANY COPIES OF THIS DRAWING
UNDER THE TERMS OF A CONTRACT OR OTHERWISE, ARE TO
BE RETURNED TO CLEAN AIR TECHNOLOGY, INC. ON REQUEST
ACCOMPLISHED. CLEAN AIR TECHNOLOGY, INC. WILL ELECT TO
TAKE ALL NECESSARY ACTION TO ENFORCE ITS RIGHTS TO
THIS PROPRIETARY INFORMATION


REV. NUM.	REV. DATE	REVISION DESCRIPTION	BY
01	02-23-18	REVISED	DWS
02	01-29-19	AS-BUILT	DWS
03	02-05-19	AS-BUILT	DWS
04			
05			
06			
07			
08			
09			
10			
11			
12			
13			
14			
15			

CUSTOMER



PROJECT TITLE
USP 797 / USP 800
CLEANROOMS

PROJECT LOCATION

C.A.T. JOB NUMBER	18-142
ORIGINAL DATE:	07-23-18
DRAWN BY:	DWS
SCALE:	3" = 1'-0"
DESCRIPTION: CONTROL DEVICE LAYOUT, HOLES IN PANEL FACE FOR DEVICES, 800 CLEANROOM AREAS	
DRAWING #:	C-1

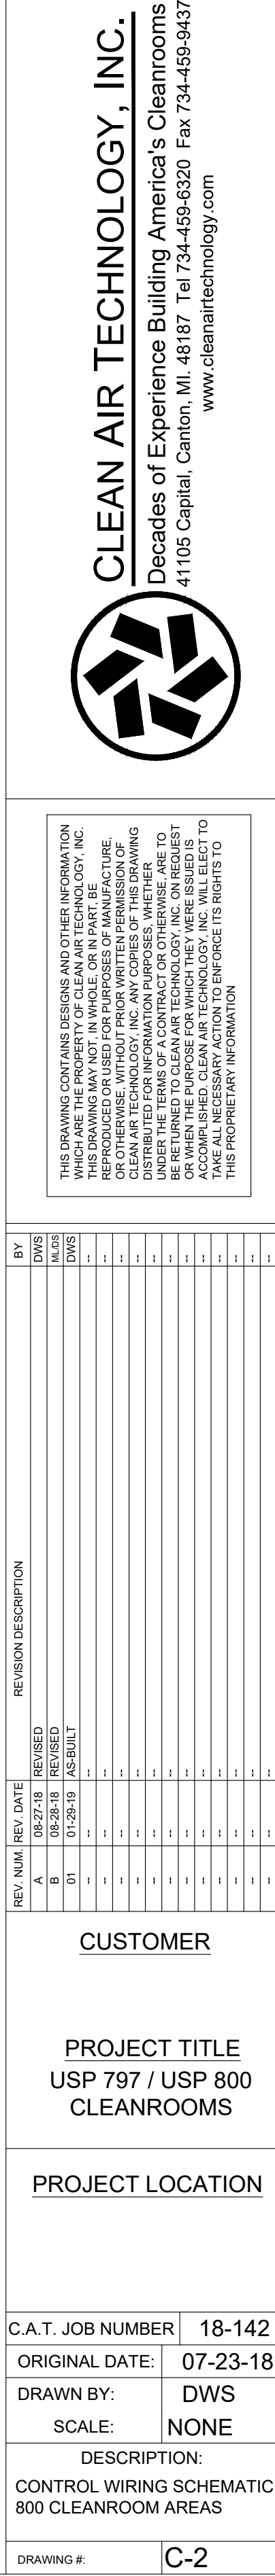

AS-BUILT DRAWING SET

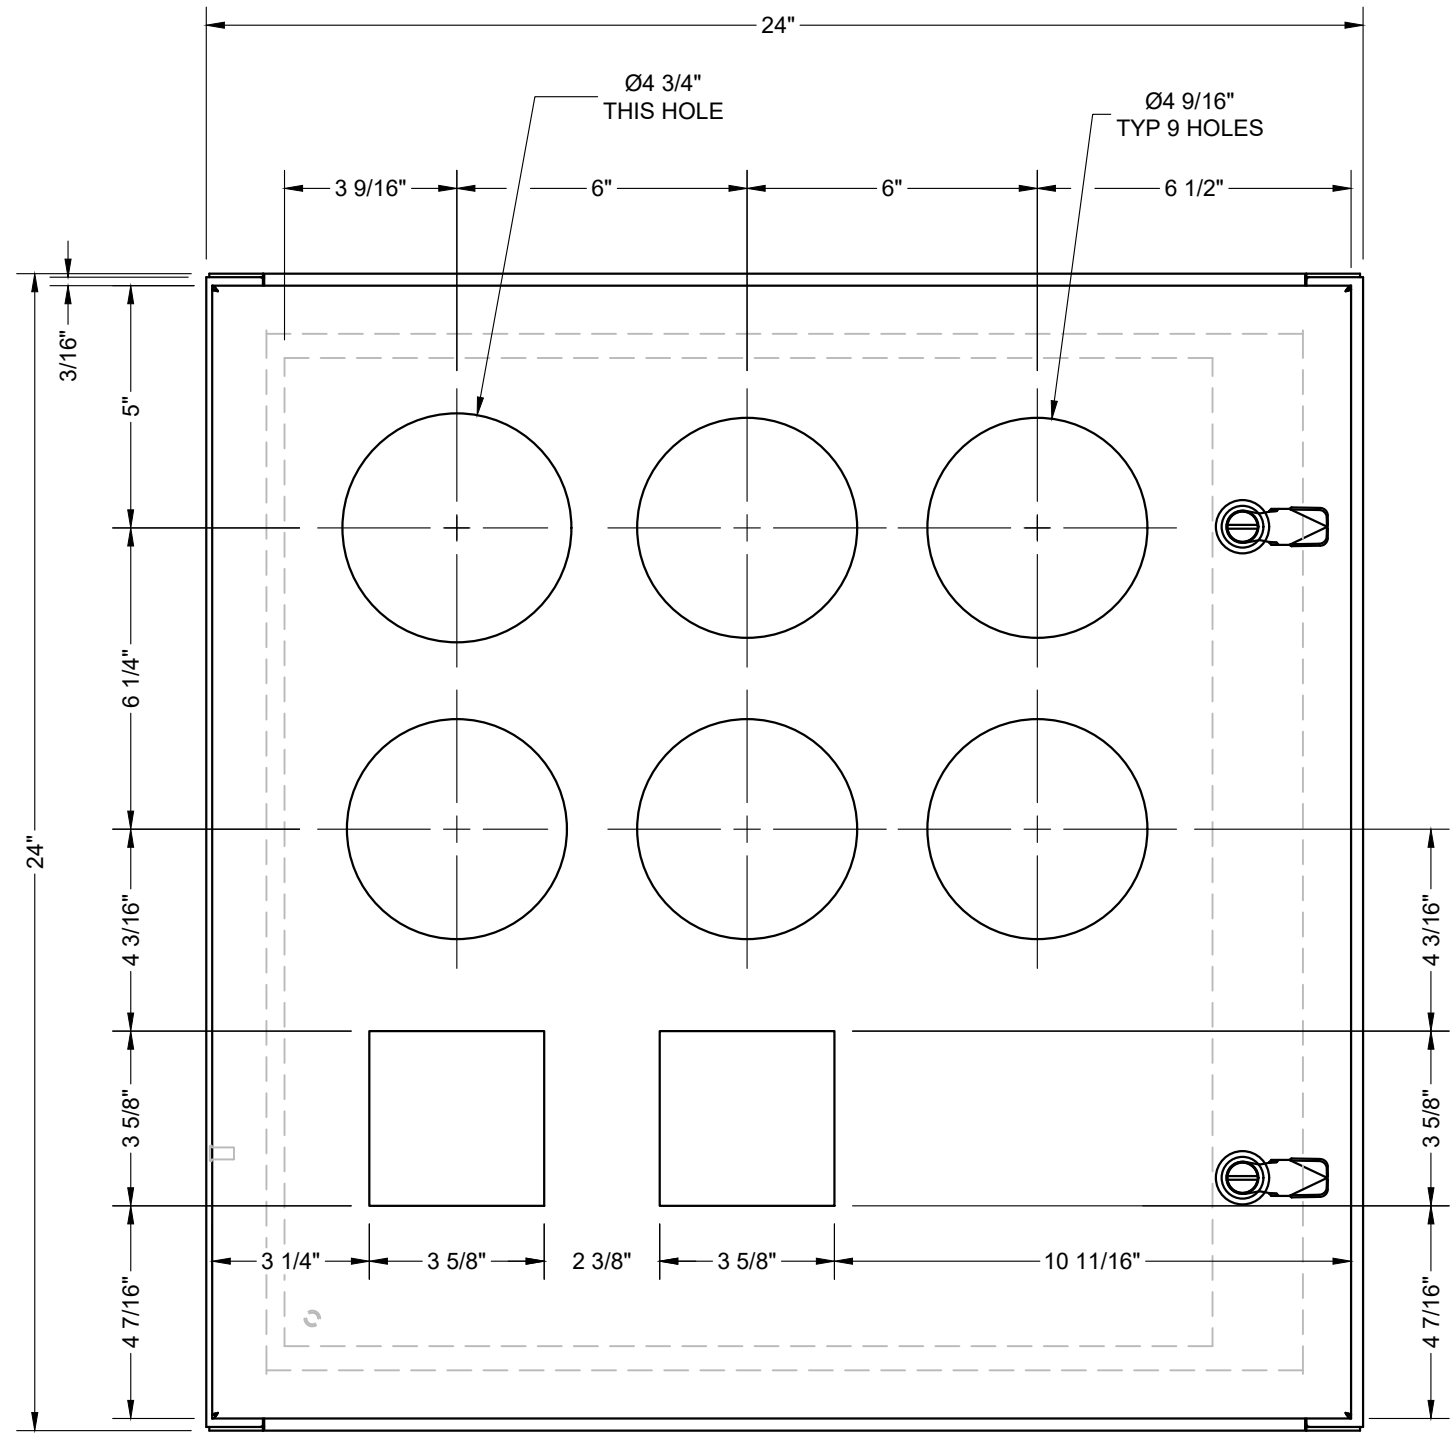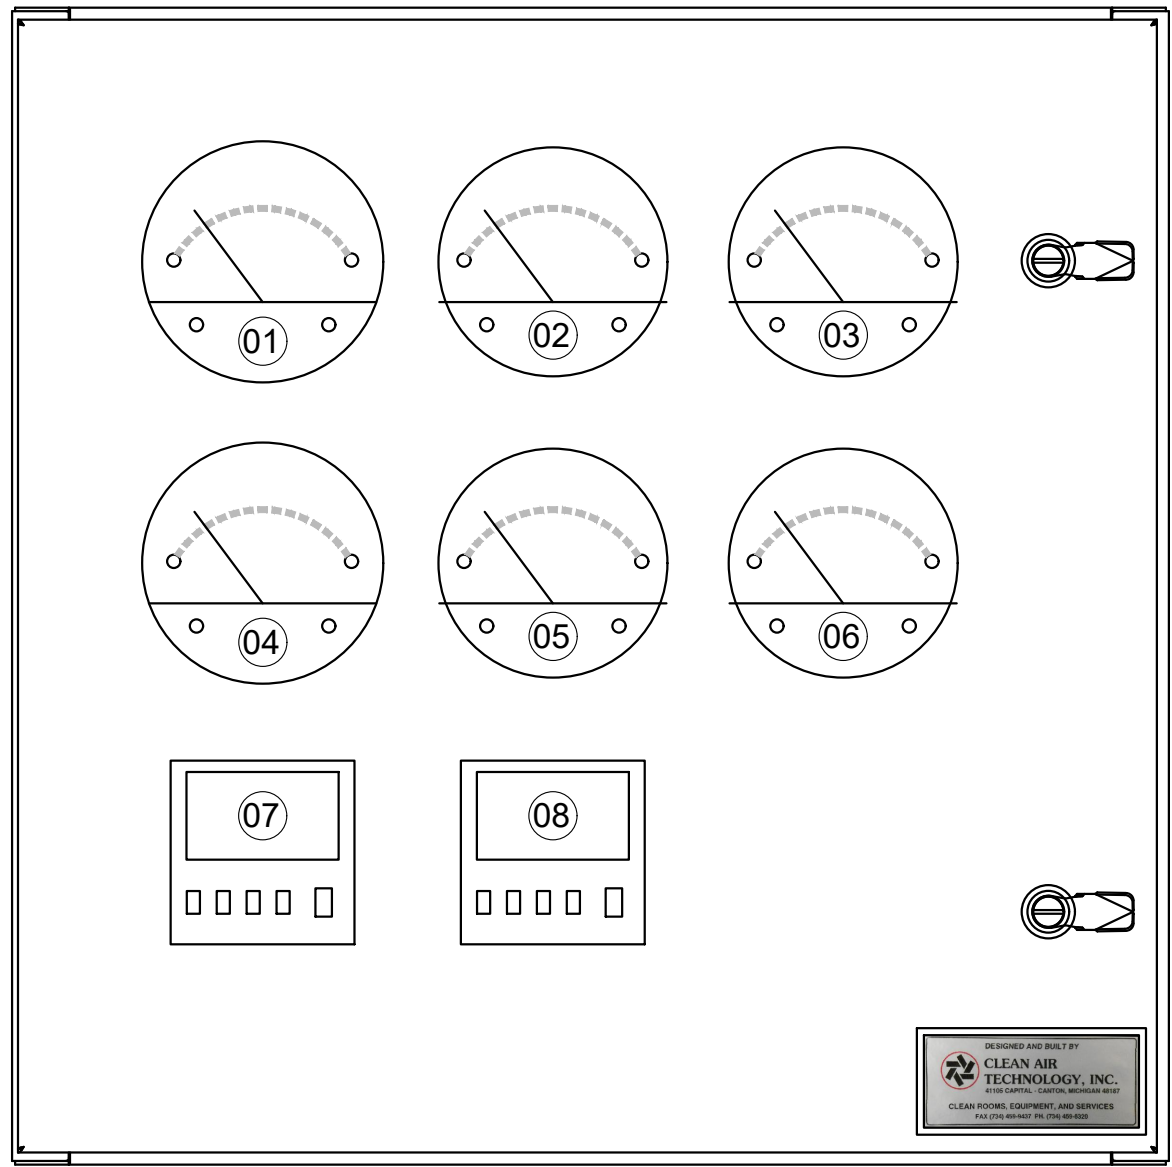

18-142 (USP797) CONTROL PANEL LAYOUT LIST				
(Panel Size - 24" wide x 24" tall)				
CONTROL #	CONTROL NAME	CONTROL TYPE	VENDOR	VENDOR PART
01	Creamroom	Digihelic Pressure Controller	Dwyer	DH3-002
02	Creamroom Gownroom	Digital Magnahelic Gauge	Dwyer	DM2102-LCD
03	Cart Pass Thru-1	Digital Magnahelic Gauge	Dwyer	DM2102-LCD
04	RAHU-2 HEPA Supply	Digital Magnahelic Gauge	Dwyer	DM2105-LCD
05	RAHU-2 Pre-filter	Digital Magnahelic Gauge	Dwyer	DM2104-LCD
06	RAHU-2 MUA Pre-filter	Digital Magnahelic Gauge	Dwyer	DM2104-LCD
07	Temperature Controller	Single Loop Controller	West	EC440R021MML99501
08	Humidity Controller	Single Loop Controller	West	EC440R021MML99501

THIS DRAWING CONTAINS DESIGNS AND OTHER INFORMATION
THESE DESIGNS AND OTHER INFORMATION ARE THE PROPERTY OF
CLEAN AIR TECHNOLOGY, INC. THIS DRAWING MAY NOT BE REPRODUCED
OR USED IN ANY MANNER WITHOUT THE WRITTEN PERMISSION OF
CLEAN AIR TECHNOLOGY, INC. ANY COPIES OF THIS DRAWING
MADE WITHOUT THE WRITTEN PERMISSION OF CLEAN AIR TECHNOLOGY, INC.
UNDER THE TERMS OF A CONTRACT OR OTHERWISE, ARE TO
BE RETURNED TO CLEAN AIR TECHNOLOGY, INC. ON REQUEST
AND WILL BE DESTROYED. CLEAN AIR TECHNOLOGY, INC. WILL ELECT TO
TAKE ALL NECESSARY ACTION TO ENFORCE ITS RIGHTS TO
THIS PROPRIETARY INFORMATION

REV.	NUM.	DATE	DESCRIPTION	BY
1	01	07-23-18	AS-BUILT	DWS
2	02	07-23-18	REVISED	DWS
3	03	07-23-18	REVISED	DWS
4	04	07-23-18	REVISED	DWS
100	100	07-23-18	REVISED	DWS


CUSTOMER	
PROJECT TITLE USP 797 / USP 800 CLEANROOMS	
PROJECT LOCATION	
C.A.T. JOB NUMBER	18-142
ORIGINAL DATE:	07-23-18
DRAWN BY:	DWS
SCALE:	3" = 1'-0"
DESCRIPTION: CONTROL DEVICE LAYOUT, HOLES IN PANEL FACE FOR DEVICES, 797 CLEANROOM AREAS	
DRAWING #:	C-3

AS-BUILT DRAWING SET

[illegible]

C.A.T. JOB NUMBER:	18-142
ORIGINAL DATE:	08-27-18
DRAWN BY:	DWS
SCALE:	NONE
DESCRIPTION: CONTROL WIRING SCHEMATIC, 797 CLEANROOM AREAS	
DRAWING #:	C-4

THIS DRAWING CONTAINS DESIGNS AND OTHER INFORMATION WHICH ARE THE PROPERTY OF CLEAN AIR TECHNOLOGY, INC. THIS DRAWING MAY NOT, IN WHOLE, OR IN PART, BE REPRODUCED OR USED FOR PURPOSES OF A PATENT, OR OTHERWISE, WITHOUT PRIOR WRITTEN PERMISSION OF CLEAN AIR TECHNOLOGY, INC. ANY COPIES OF THIS DRAWING OR ANY PART THEREOF, INCLUDING ANY INFORMATION CONTAINED HEREIN, ARE HEREBY RETURNED TO CLEAN AIR TECHNOLOGY, INC. ON REQUEST AND WHEN THE PURPOSE FOR WHICH THEY WERE ISSUED IS ACCOMPLISHED. CLEAN AIR TECHNOLOGY, INC. WILL ELECT TO TAKE ALL NECESSARY ACTION TO ENFORCE ITS RIGHTS TO THIS PROPRIETARY INFORMATION.

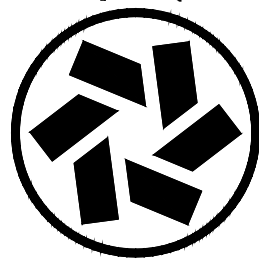

CLEAN AIR TECHNOLOGY, INC.
Decades of Experience Building America's Cleanrooms
411105 Capital, Canton, MI. 48187 Tel 734-459-6320 Fax 734-459-9437
www.cleanarttechnology.com