


DESIGNATOR	QTY	PART NUMBER	DESCRIPTION
F 97	2	770-07385	STRAINER-BASKET TYPE 3 CL150&300
MV 75	2	334-07274	VALVE-BALL SVF 3 CL150 CS FIRE
CV 51	2	336-07261	VALVE-CHECK KF 3 WAFER CL150
PR 1	1	991-07671	REG-2"CL150 35-125#SPRG 1098H-EGR

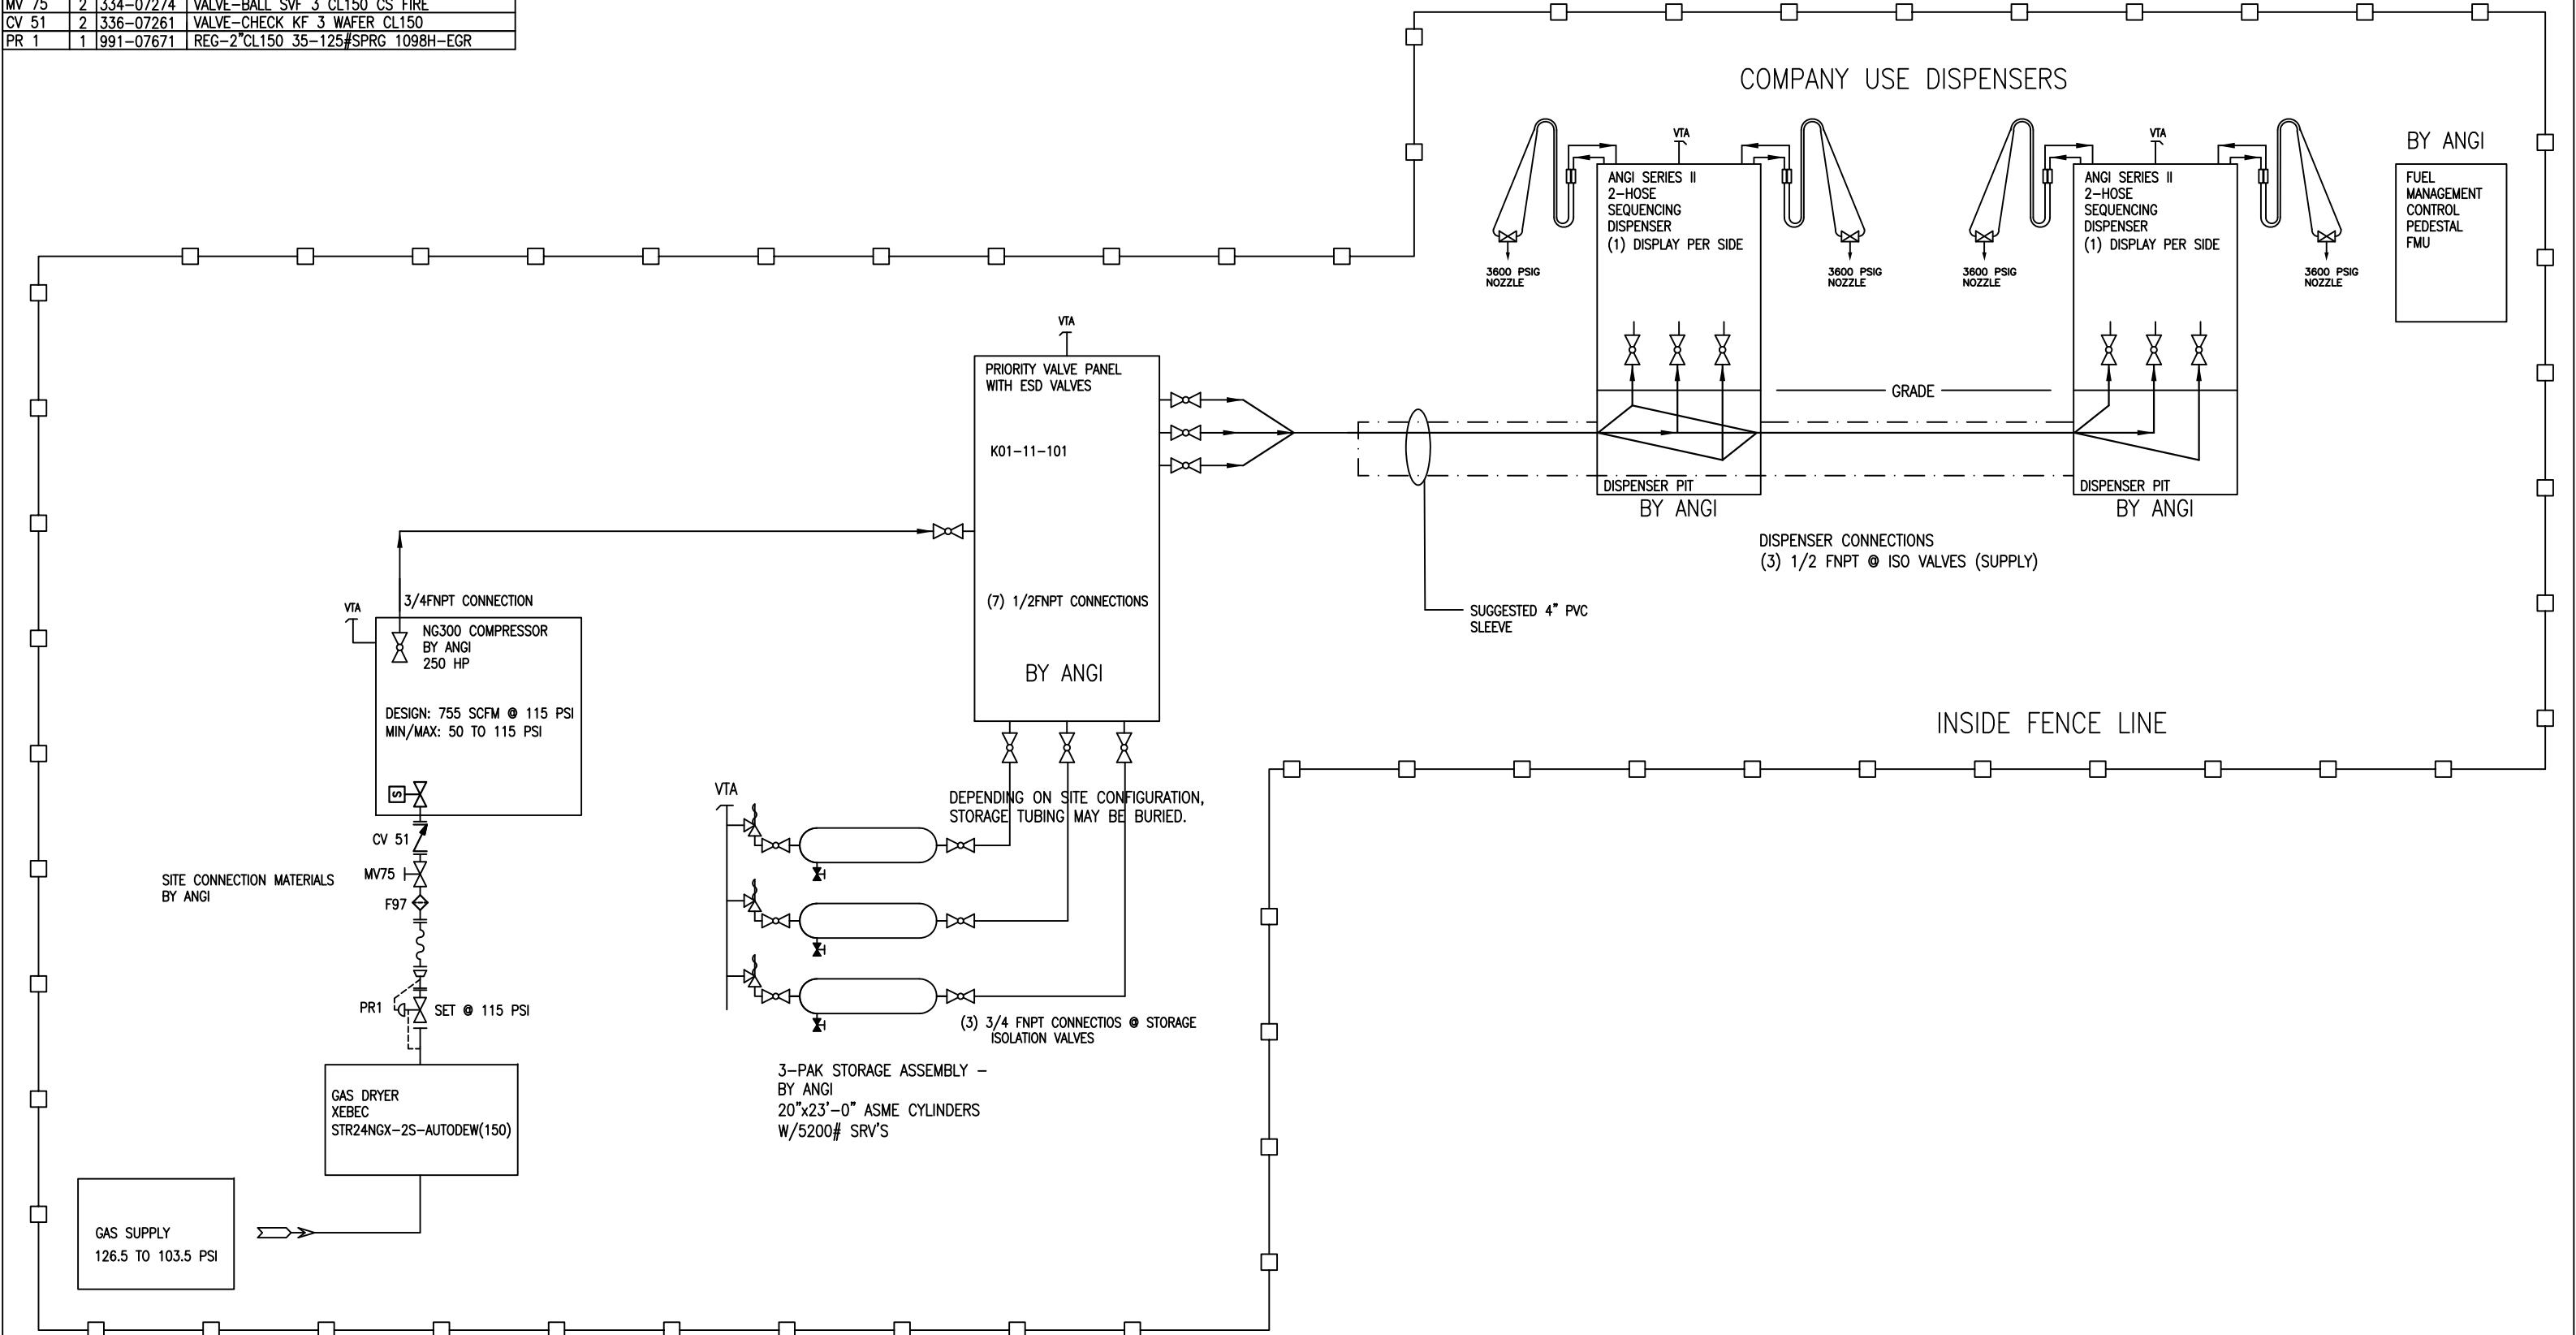


D	6/14/12 HMR	ADDED DRYER PER CUSTOMER REQUEST SEE ECN #120614-01			
C	4/20/12 ADM	COMPLETED TBD FOR PR1			
B	2/10/12 ADM	REMOVED PUBLIC DISPENSER			
A	1/23/12 ADM	MOVED DISPENSER VENTS TO TOP OF DISP	E	9/5/12 ADM	CLARIFIED SITE MATERIAL CONNECTIONS
REV	DATE/BY	DESCRIPTION	REV	DATE/BY	DESCRIPTION



THIS DRAWING AND ALL INFORMATION THEREIN IS THE SOLE PROPERTY OF ANGI AND SHOULD NOT BE COPIED, REPRODUCED, OR SUBMITTED TO OTHERS WITHOUT WRITTEN AUTHORIZATION. ALL REPRODUCTIONS ARE SUBJECT TO RETURN ON DEMAND.

ANGI ENERGY SYSTEMS
15 PLUMB STREET
MILTON, WI 53563
PH: 608-868-4626
FX: 608-868-2723

 
UNLESS OTHERWISE SPECIFIED



BREAK SHARP EDGES
ALL DIMENSIONS IN INCHES

FRACTIONAL ±.125
TWO PLACE DECIMAL ±.010
THREE PLACE DECIMAL ±.005
ANGLES ±1°

TITLE SITE P&ID – COMPANY AND PUBLIC USE FAST FILL SYSTEM					
CUSTOMER PIONEER NATURAL GAS – BIVENS			PROJECT NO. 30974		
SHEET 1/1	SCALE NA		DRAWING NO. A05-03-30974		REV. E
DRAWN BY HMR	DATE 05 DEC 11				

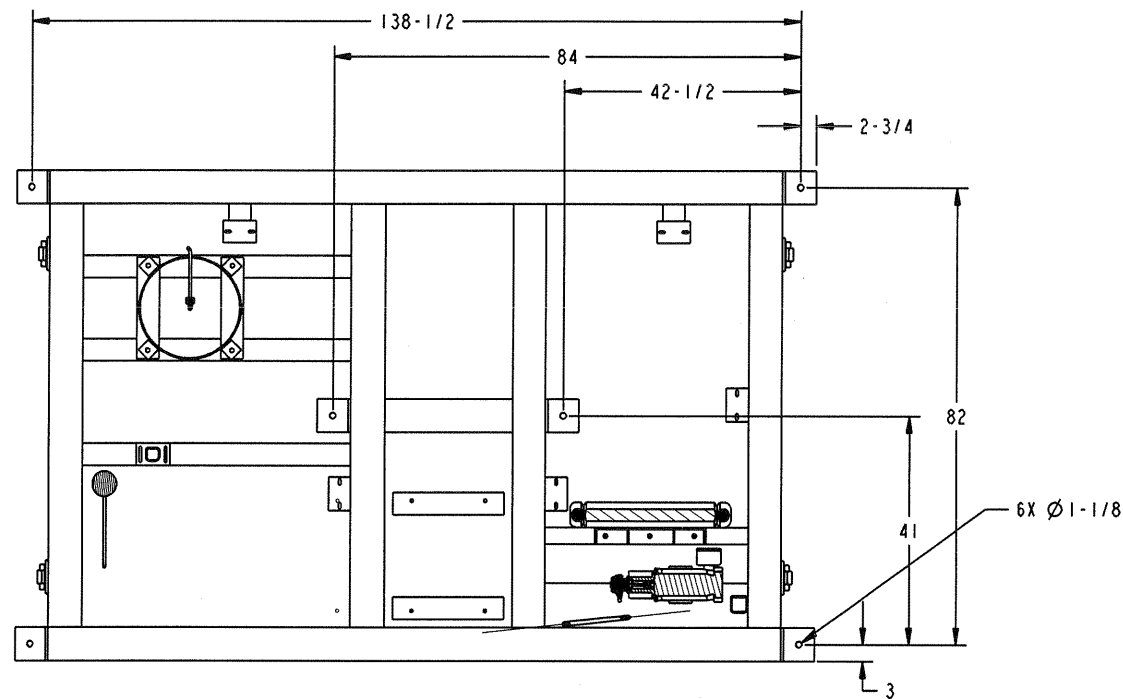

SECTION A-A
ANCHOR BOLT LOCATIONS

COMPRESSOR DATA

WEIGHT: 15,000 LBS.


TYPE: ARIEL RECIPROCATING COMPRESSOR, J60/2 4-STAGE
CYLINDERS MAY VARY FROM THOSE SHOWN.

CLEARANCE: ALLOW 36" MINIMUM ON ALL SIDES FOR
ACCESS UNLESS OTHERWISE INDICATED.


MOUNTING: REQUIRES SIX (6) 1" DIAMETER ANCHOR BOLTS (NOT
PROVIDED). GROUTING THE COMPRESSOR TO THE
CONCRETE PAD IS NOT RECOMMENDED.

LIFTING: MINIMUM 13' SPREADER BAR IS REQUIRED.
UTILIZE FOUR (4) LIFT RINGS.


SHIPPING: VENT STACK, 3" INLET VALVE, AND 1/4" ACTUATOR
TUBING ARE REMOVED FOR SHIPPING.

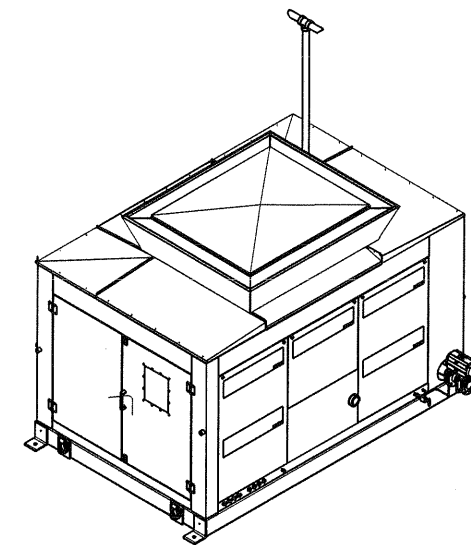

SCALE 0.031

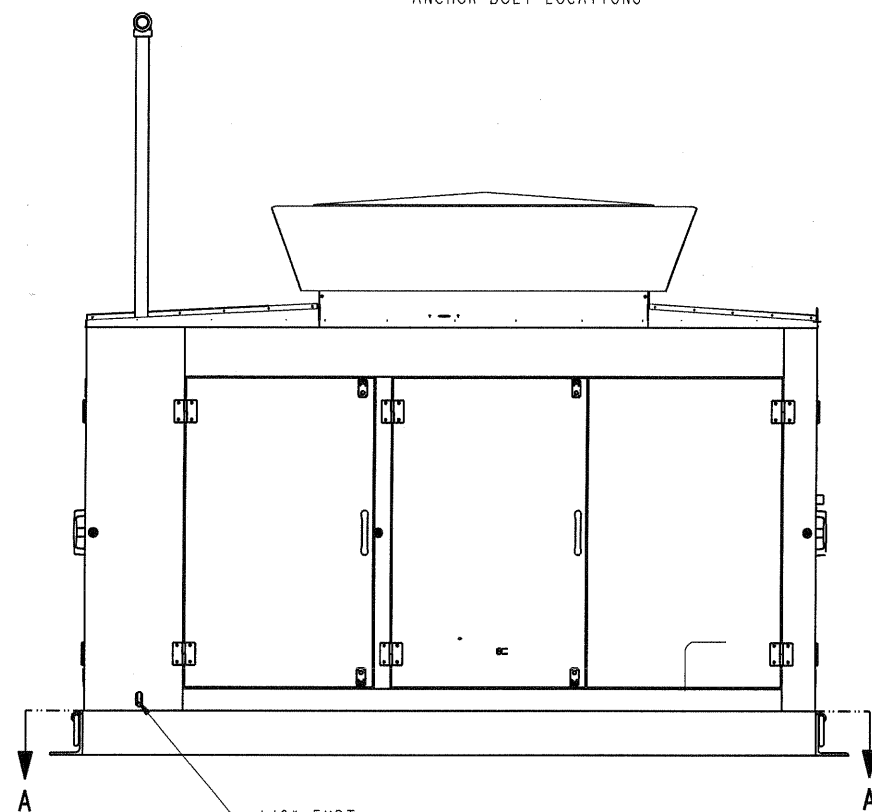


1/2" FNPT
INLET FILTER DRAIN






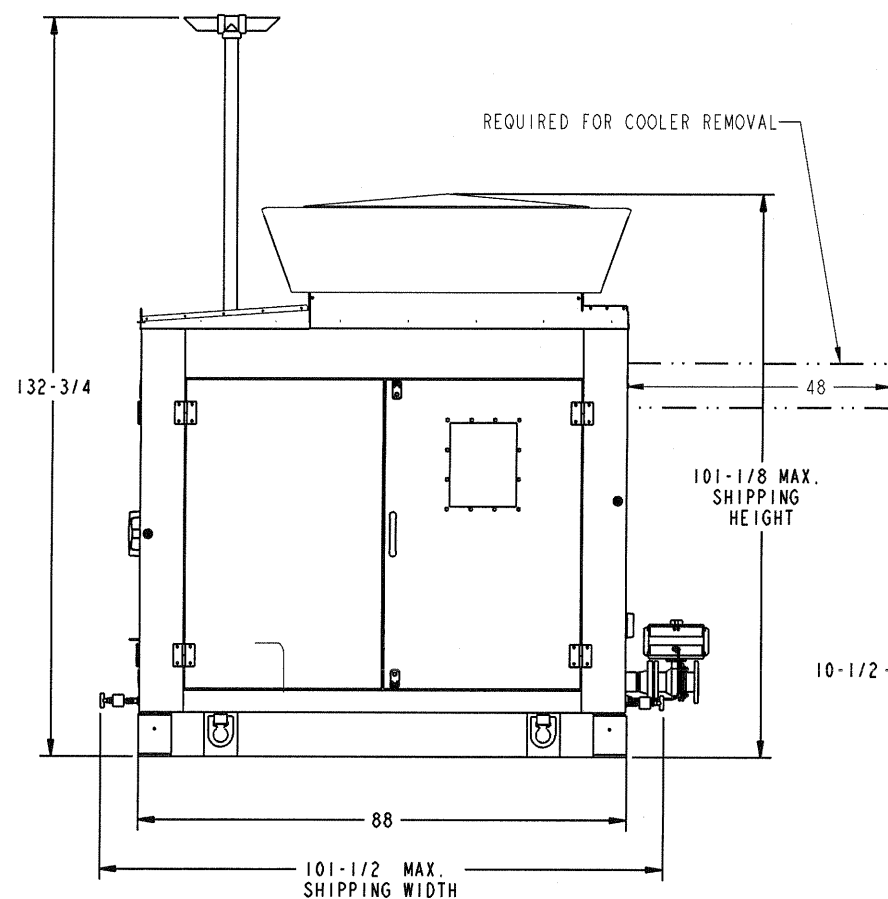


REQUIRED FOR COOLER REMOVAL

SCALE 0.063

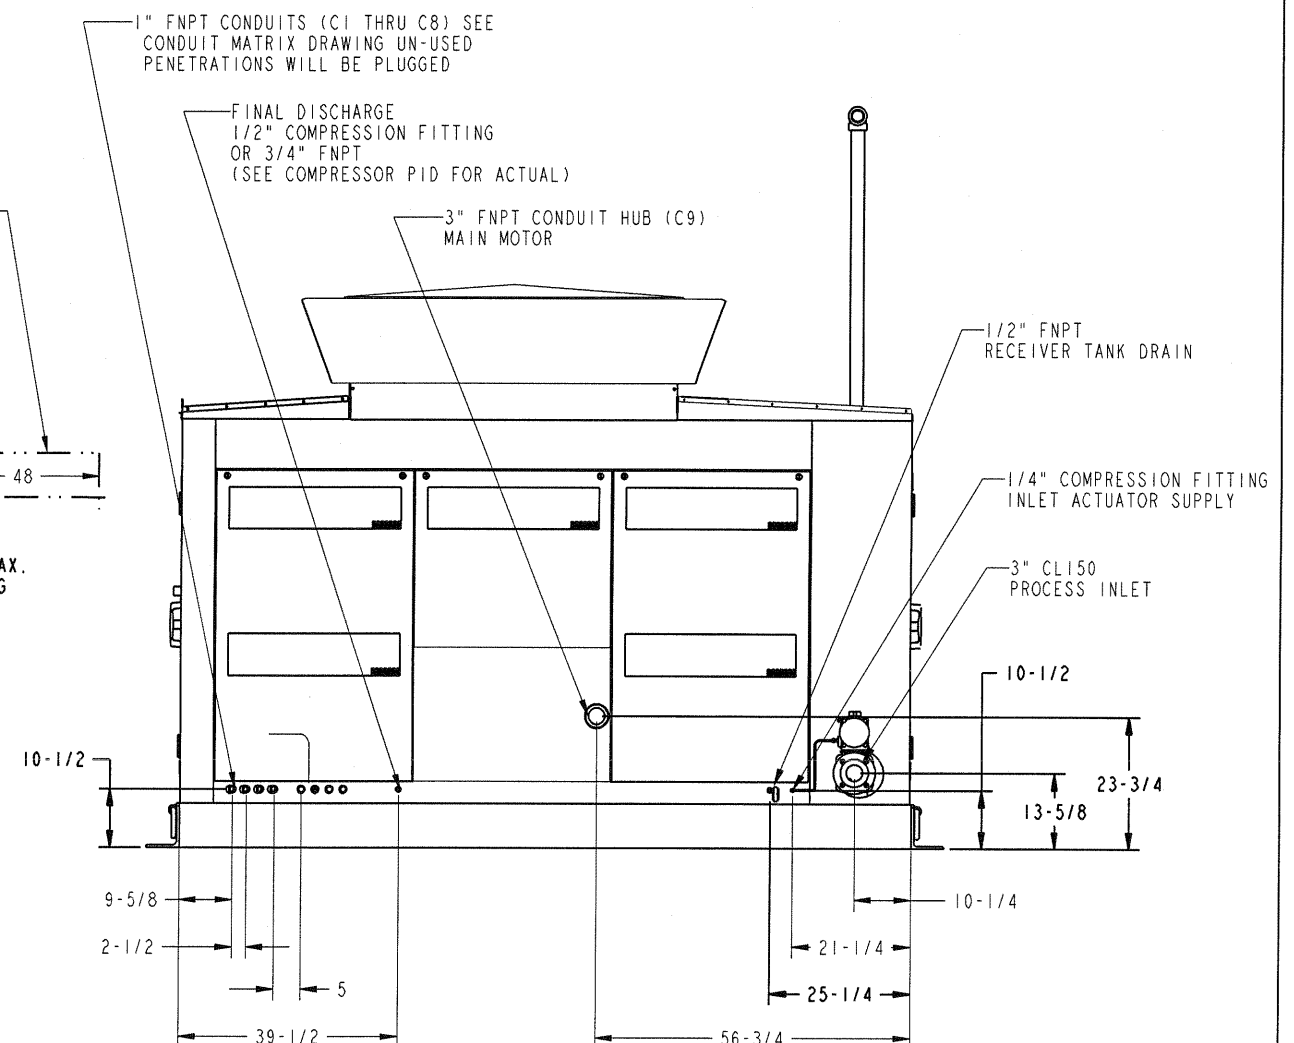

REV	DATE/BY	DESCRIPTION	REV	DATE/BY	DESCRIPTION
B	11/18/11	REVISED FINAL DISCHARGE CALLOUT			
A	6/07/11	ADM			
REV	DATE/BY	DESCRIPTION	REV	DATE/BY	DESCRIPTION
ANGI ENERGY SYSTEMS 15 PLUMB STREET MILTON, WI 53563 PH: 800-880-4428 FX: 800-880-2123			UNLESS OTHERWISE SPECIFIED BREAK SHARP EDGES ALL DIMENSIONS IN INCHES FRACTIONAL DECIMAL TWO PLACE DECIMAL THREE PLACE DECIMAL ANGLES		
THIS DRAWING AND INFORMATION THEREIN IS THE SOLE PROPERTY OF ANGI ENERGY SYSTEMS. IT IS TO BE USED ONLY FOR THE PROJECT AND SITE SPECIFICALLY IDENTIFIED HEREIN. NO PART OF THIS DRAWING OR INFORMATION IS TO BE REPRODUCED OR TRANSMITTED IN ANY FORM OR BY ANY MEANS, ELECTRONIC OR MECHANICAL, WITHOUT WRITTEN AUTHORIZATION. ALL REPRODUCTIONS ARE SUBJECT TO RETURN ON DEMAND.			TITLE GENERAL ARRANGEMENT - NG300ES40 WITH ENCLOSURE AND 3" CL150 INLET CUSTOMER PROJECT NO. STANDARD SHEET 1 of 2 SCALE 0.027 DRAWING NO. GAD-NG300ES40-3E DATE 5/18/2011 REV. B		

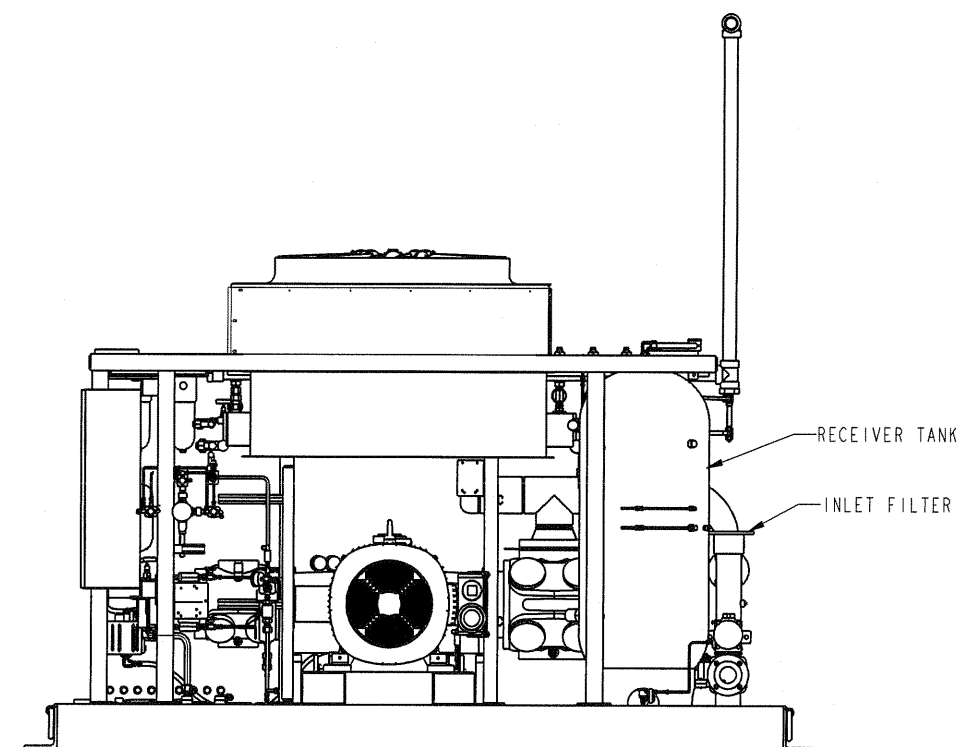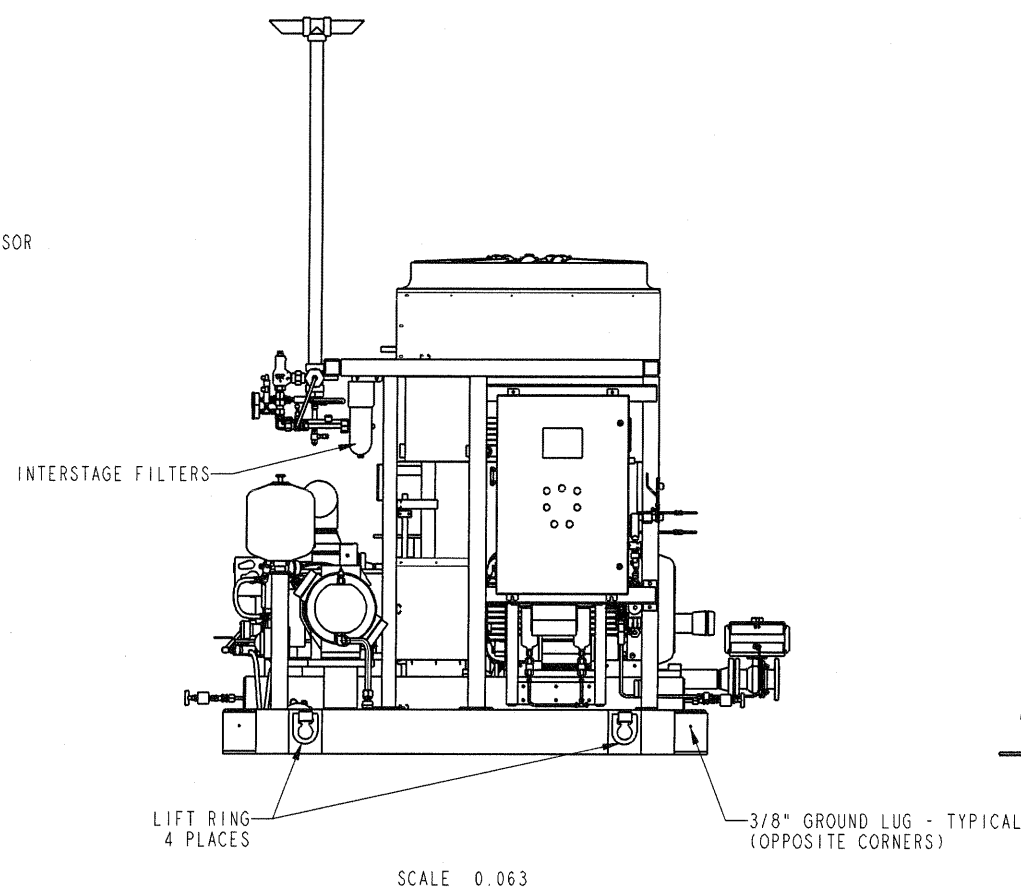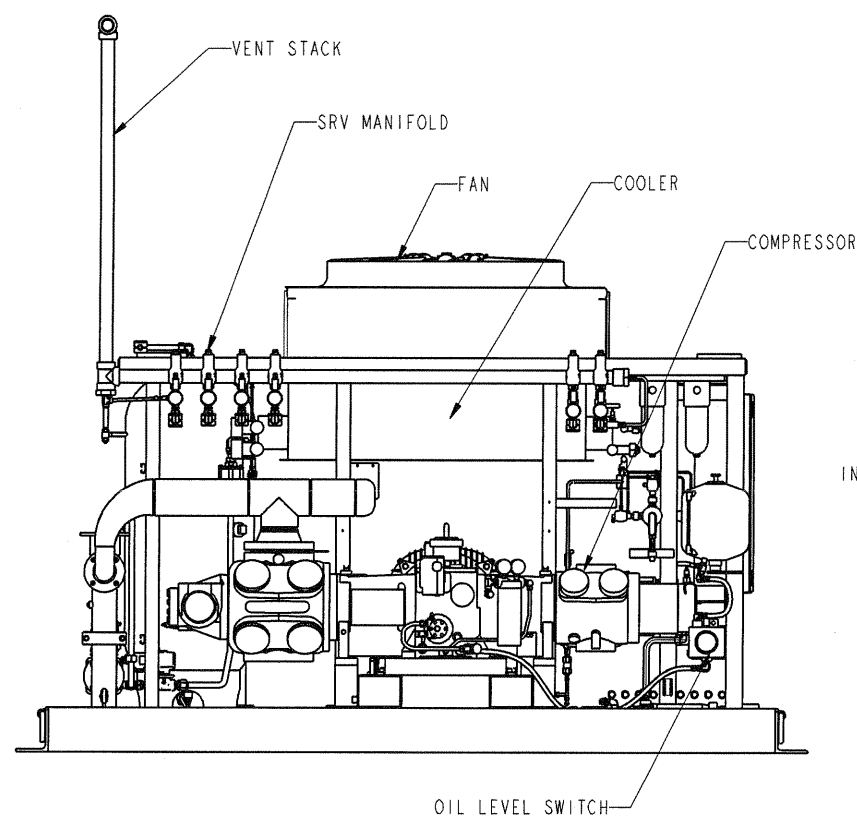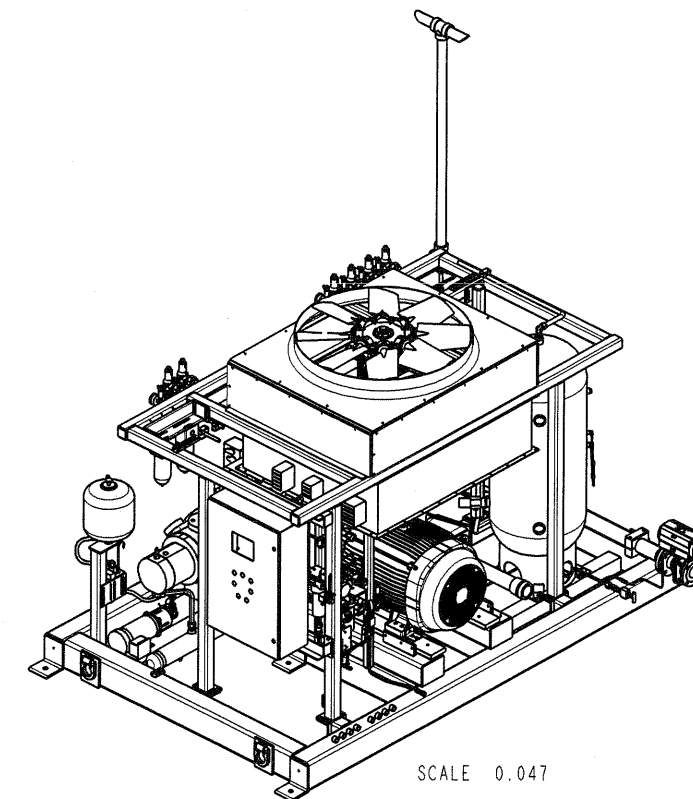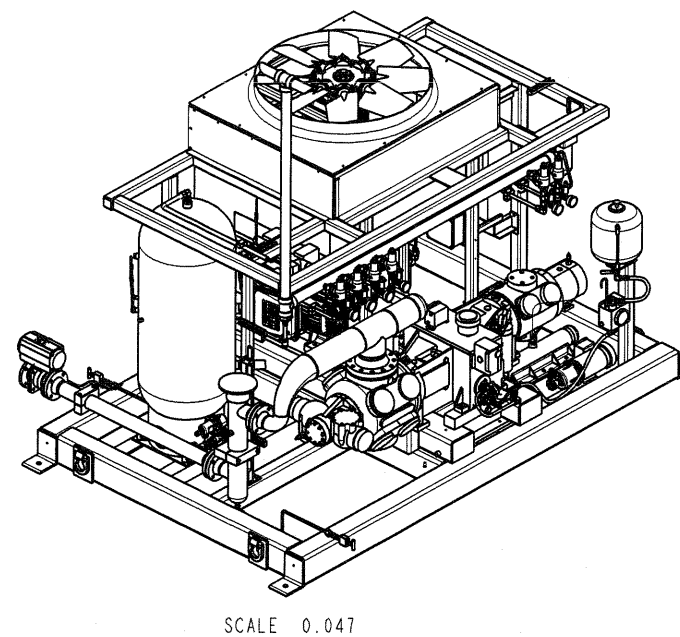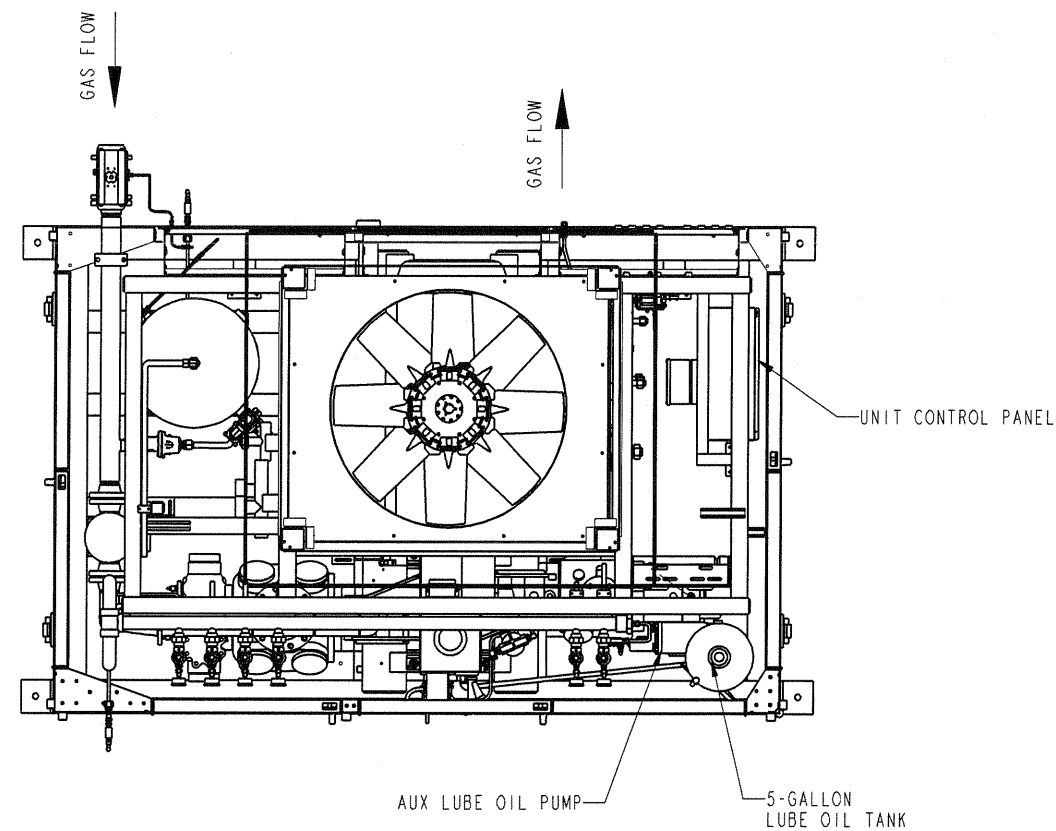


SUBMITTAL RELEASE ONLY
DO NOT MANUFACTURE TO THIS PRINT



ANGI ENERGY SYSTEMS
15 FLYING STREET
MILTON, WI 53563
PH: 608-886-4658
FX: 608-886-2723

UNLESS OTHERWISE SPECIFIED
BREATHE SHARP EDGES
ALL DIMENSIONS IN INCHES
FRACTIONAL .125
TWO PLACE DECIMAL .010
THREE PLACE DECIMAL .005
ANGLES

TITLE: GENERAL ARRANGEMENT - NG300ES40 WITH ENCLOSURE AND 3" CL150 INLET
CUSTOMER: PROJECT NO: STANDARD
SHEET: 2 of 2 SCALE: 0.027 DRAWING NO: GAD-NG300ES40-3E
DRAWN BY: ADM DATE: 5/18/2011 REV: B

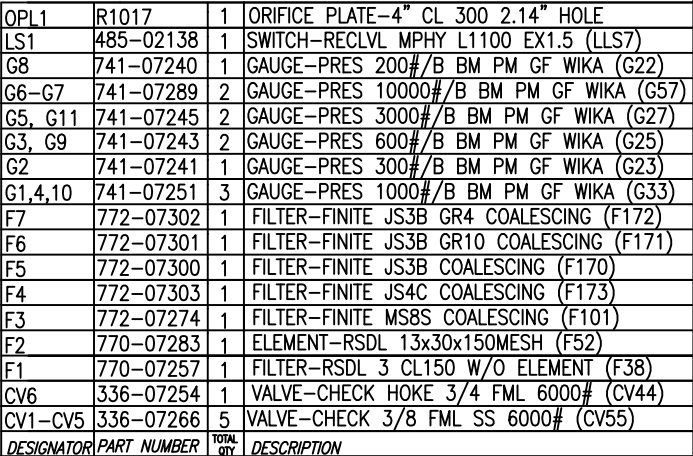


ANGI
ENERGY SYSTEMS

ANGI ENERGY SYSTEMS
15 PLUMB STREET
MILTON, WI 53563
PH: 608-868-4626
FX: 608-868-2723

THIS DRAWING AND ALL INFORMATION THEREIN IS THE SOLE PROPERTY OF ANGI AND SHOULD NOT BE COPIED, REPRODUCED, OR SUBMITTED TO OTHERS WITHOUT WRITTEN AUTHORIZATION. ALL REPRODUCTIONS ARE SUBJECT TO RETURN ON DEMAND.

UNLESS OTHERWISE SPECIFIED  BREAK SHARP EDGES <u>ALL DIMENSIONS IN INCHES</u> FRACTIONAL ±.125 TWO PLACE DECIMAL ±.010 THREE PLACE DECIMAL ±.005 ANGLES ±1°		TITLE NG300E 4-STAGE COMPRESSOR – PIPING AND INSTRUMENTATION 8SP-HE CYLINDER, 70-100 PRESSURE RANGE			
CUSTOMER			PROJECT NO.		
SHEET 1/2		SCALE 1:2		DRAWING NO.	
DRAWN BY ADM		DATE 4/3/2012		PID-NG300ES4Q-8(100)	
				REV. —	

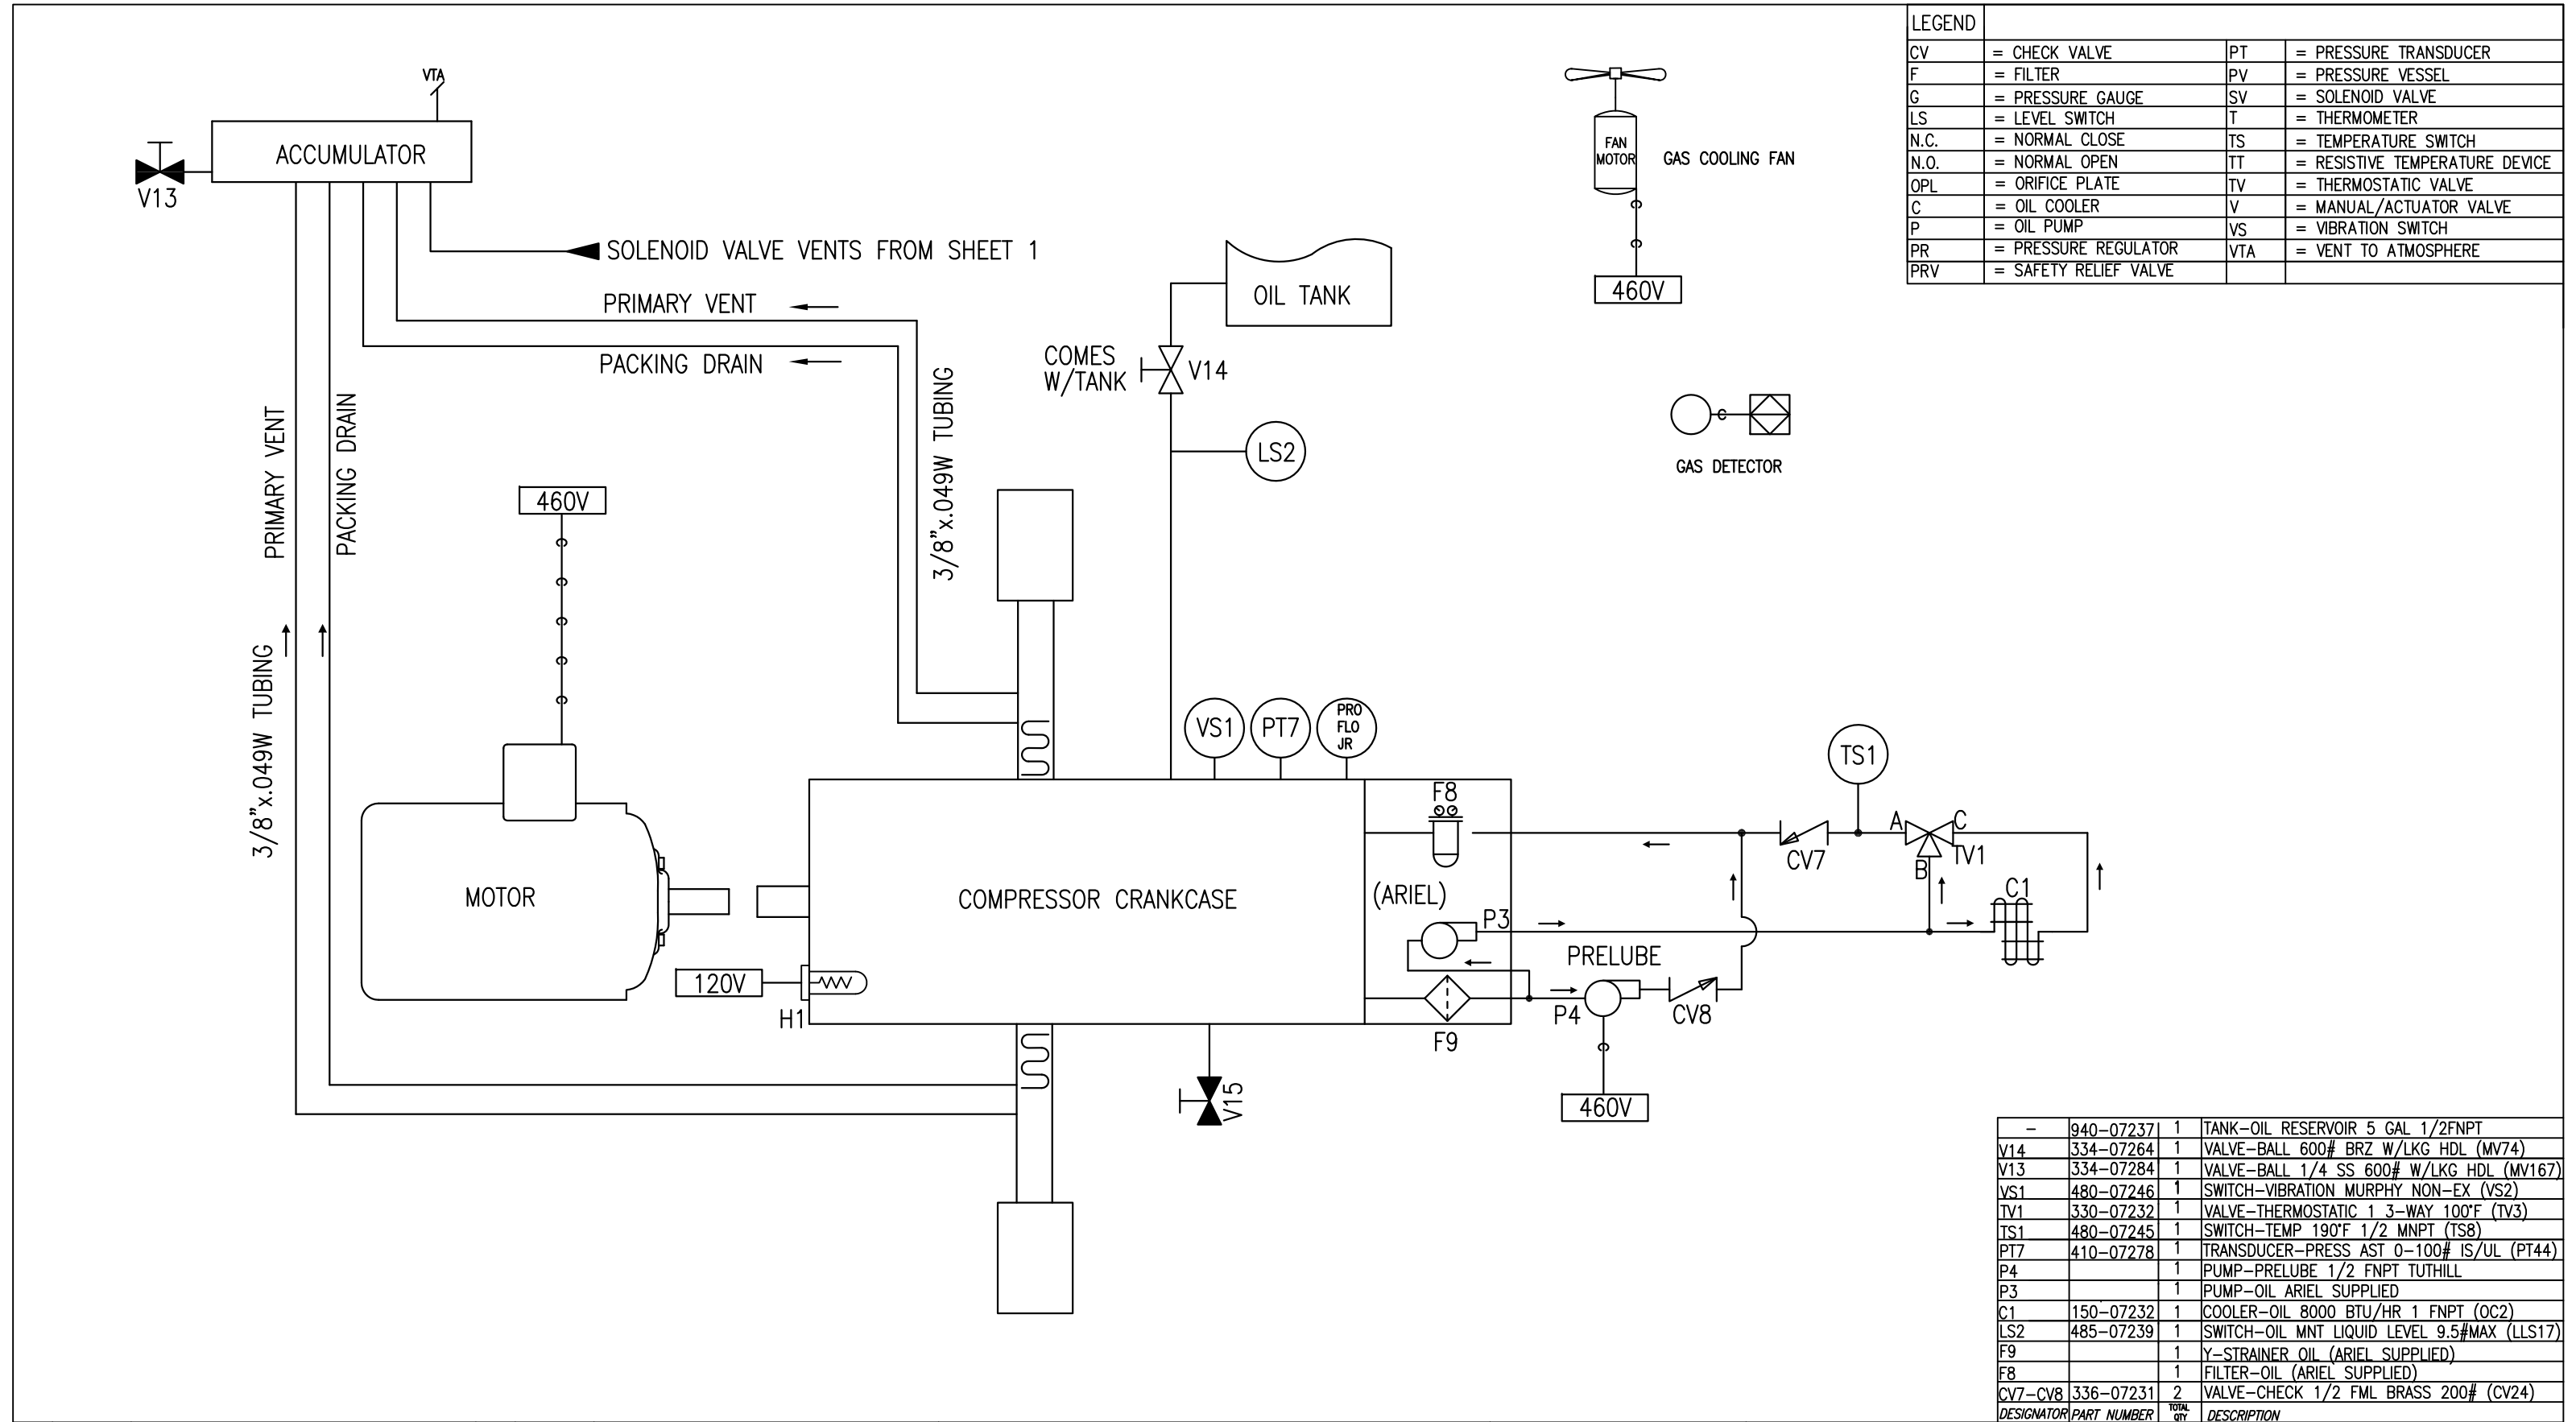

LEGEND			
CV	= CHECK VALVE	PT	= PRESSURE TRANSDUCER
F	= FILTER	PV	= PRESSURE VESSEL
G	= PRESSURE GAUGE	SV	= SOLENOID VALVE
LS	= LEVEL SWITCH	T	= THERMOMETER
N.C.	= NORMAL CLOSE	TS	= TEMPERATURE SWITCH
N.O.	= NORMAL OPEN	TT	= RESISTIVE TEMPERATURE DEVICE
OPL	= ORIFICE PLATE	TV	= THERMOSTATIC VALVE
C	= OIL COOLER	V	= MANUAL/ACTUATOR VALVE
P	= OIL PUMP	VS	= VIBRATION SWITCH
PR	= PRESSURE REGULATOR	VTA	= VENT TO ATMOSPHERE
PRV	= SAFETY RELIEF VALVE		

-	940-07237	1	TANK-OIL RESERVOIR 5 GAL 1/2FNPT
V14	334-07264	1	VALVE-BALL 600# BRZ W/LKG HDL (MV74)
V13	334-07284	1	VALVE-BALL 1/4 SS 600# W/LKG HDL (MV167)
VS1	480-07246	1	SWITCH-VIBRATION MURPHY NON-EX (VS2)
TV1	330-07232	1	VALVE-THERMOSTATIC 1 3-WAY 100°F (TV3)
TS1	480-07245	1	SWITCH-TEMP 190°F 1/2 MNPT (TS8)
PT7	410-07278	1	TRANSDUCER-PRESS AST 0-100# IS/UL (PT44)
P4		1	PUMP-PRELUBE 1/2 FNPT TUTHILL
P3		1	PUMP-OIL ARIEL SUPPLIED
C1	150-07232	1	COOLER-OIL 8000 BTU/HR 1 FNPT (OC2)
LS2	485-07239	1	SWITCH-OIL MNT LIQUID LEVEL 9.5#MAX (LLS17)
F9		1	Y-STRAINER OIL (ARIEL SUPPLIED)
F8		1	FILTER-OIL (ARIEL SUPPLIED)
CV7-CV8	336-07231	2	VALVE-CHECK 1/2 FML BRASS 200# (CV24)
DESIGNATOR		TOTAL QTY	DESCRIPTION

*					
REV	DATE/BY	DESCRIPTION		REV	DATE/BY

ANGI ENERGY SYSTEMS
15 PLUMB STREET
MILTON, WI 53563
PH: 608-868-4626
FX: 608-868-2723

UNLESS OTHERWISE SPECIFIED

BREAK SHARP EDGES
ALL DIMENSIONS IN INCHES

FRACTIONAL	±.125
TWO PLACE DECIMAL	±.010
THREE PLACE DECIMAL	±.005
ANGLES	±1°

TITLE NG300E 4-STAGE COMPRESSOR – PIPING AND INSTRUMENTATION
8SP-HE CYLINDER, 70-100 PRESSURE RANGE

CUSTOMER		PROJECT NO.	
SHEET	2/2	SCALE	1:2
DRAWN BY	ADM	DATE	4/3/12

DRAWING NO.	PID-NG300ES4Q-8(100)	REV.	-
-------------	----------------------	------	---

THIS DRAWING AND ALL INFORMATION THEREIN IS THE SOLE PROPERTY OF ANGI AND SHOULD NOT BE COPIED, REPRODUCED, OR SUBMITTED TO OTHERS WITHOUT WRITTEN AUTHORIZATION. ALL REPRODUCTIONS ARE SUBJECT TO RETURN ON DEMAND.



ANGI

ENERGY SYSTEMS

MILTON, WI - USA

DRAWING INDEX	
PAGE	DESCRIPTION
1	INDEX AND GENERAL INFORMATION
2	110VAC POWER DISTRIBUTION
3	24VDC POWER DISTRIBUTION
4	PLC DIGITAL/ANALOG I/O CARD #1
5	PLC DIGITAL/ANALOG I/O CARD #2
6	PLC ANALOG CARD#3
7	PLC DIGITAL/ANALOG I/O CARD #4
8	COMPONENT WIRING DETAILS – PLC POWER & COMMUNICATIONS
9	LIGHTING/GAS DETECTOR BEACON INTERCONNECT

NOTE: ALL ELECTRICAL CONNECTION MUST BE COMPLETED OR SUPERVISED BY QUALIFIED PERSONNEL, AND MEET ALL LOCAL AND APPLICABLE CODES. REFER TO NEC FOR MORE INFORMATION.

FUSE CHART		
FUSE #	ANGI PART NUMBER	AMPS
FU-1	440-07273	10
FU-2	440-07307	3
FU-3	440-07307	3
FU-4	440-07307	3
FU-5	440-07307	3
FU-6	440-07307	3
FU-7	440-07307	3
FU-8	440-07307	3
FU-9	440-07273	10
FU-10	440-07254	5
FU-11	440-07307	3
FU-12	440-07307	3
FU-13	440-07307	3
FU-14	440-07307	3
FU-15	440-07307	3
FU-16	440-07307	3

NOTE:

ESD CIRCUIT – SELECT SETTINGS FOR (LOCAL OR SITE SUPPLIED ESD POWER)

– SEE PAGE 2, FOR ESD POWER CIRCUIT – WIRE CONNECTION REQUIREMENTS

– ADD OR REMOVE WIRE #'s 103 & 125 AS NECESSARY (JOB SITE SPECIFIC)

– VERIFY CORRECT SETTINGS FOR "ESD" SUPPLY CIRCUIT POWER AT EACH JOB SITE

UL FILE AND PANEL TYPE		
X	NNNY.E328888	INDUSTRIAL CONTROL PANELS AND ASSEMBLIES FOR USE IN HAZARDOUS LOCATIONS
	NRBX.E334511	INDUSTRIAL CONTROL PANELS RELATING TO HAZARDOUS LOCATIONS
	NITW.E319535	INDUSTRIAL CONTROL PANELS
		THIRD PARTY CERTIFICATION REQUIRED
	NON CERTIFIED	NO CERTIFICATION REQUIRED / AVAILABLE



MILTON, WI - USA

793-08003

JOB NUMBER 30974-01

SCHEMATIC A80-10-30974-01

PRIMARY SUPPLY AMPS 10

VOLTS 120VAC PHASE 1 HZ 60

SECONDARY SUPPLY AMPS 10

VOLTS 24VDC PHASE 1 HZ

MOTOR HP N/A FLA N/A

ENCL. TYPE 4

SHORT CIRCUIT CURRENT RATING 5KAIC

HAZARDOUS LOCATION RATING

CLASS 1 DIV 2 GROUP A,B,C,D

www.angienergy.com

COMPRESSOR#1
CONTROL PANEL

CONTROLLED DRAWING

THIS DRAWING COMPLIES WITH AGENCY LISTINGS. DO NOT CHANGE WITHOUT APPROVAL FROM ENGINEERING DEPARTMENT.


*					
REV	DATE/BY	DESCRIPTION	REV	DATE/BY	DESCRIPTION



ANGI ENERGY SYSTEMS
15 PLUMB STREET
MILTON, WI 53563
PH: 608-868-4626
FX: 608-868-2723

THIS DRAWING AND ALL INFORMATION THEREIN IS THE SOLE PROPERTY OF ANGI AND SHOULD NOT BE COPIED, REPRODUCED, OR SUBMITTED TO OTHERS WITHOUT WRITTEN AUTHORIZATION. ALL REPRODUCTIONS ARE SUBJECT TO RETURN ON DEMAND.

 UNLESS OTHERWISE SPECIFIED




BREAK SHARP EDGES

ALL DIMENSIONS IN INCHES

FRACTIONAL ±.125
TWO PLACE DECIMAL ±.010
THREE PLACE DECIMAL ±.005
ANGLES ±1°

TITLE RX 371-ELECTRICAL SCHEMATIC/ELECTRIC DRIVE ARIEL FOUR STAGE/COMPRESSOR UNIT CONTROL PANEL			
CUSTOMER Pioneer Natural Resources – Bivens		PROJECT NO. 30974-01	
SHEET 1/9	SCALE 1:1	DRAWING NO. A80-10-30974-01	REV. –
DRAWN BY NDA	DATE 1/18/12		

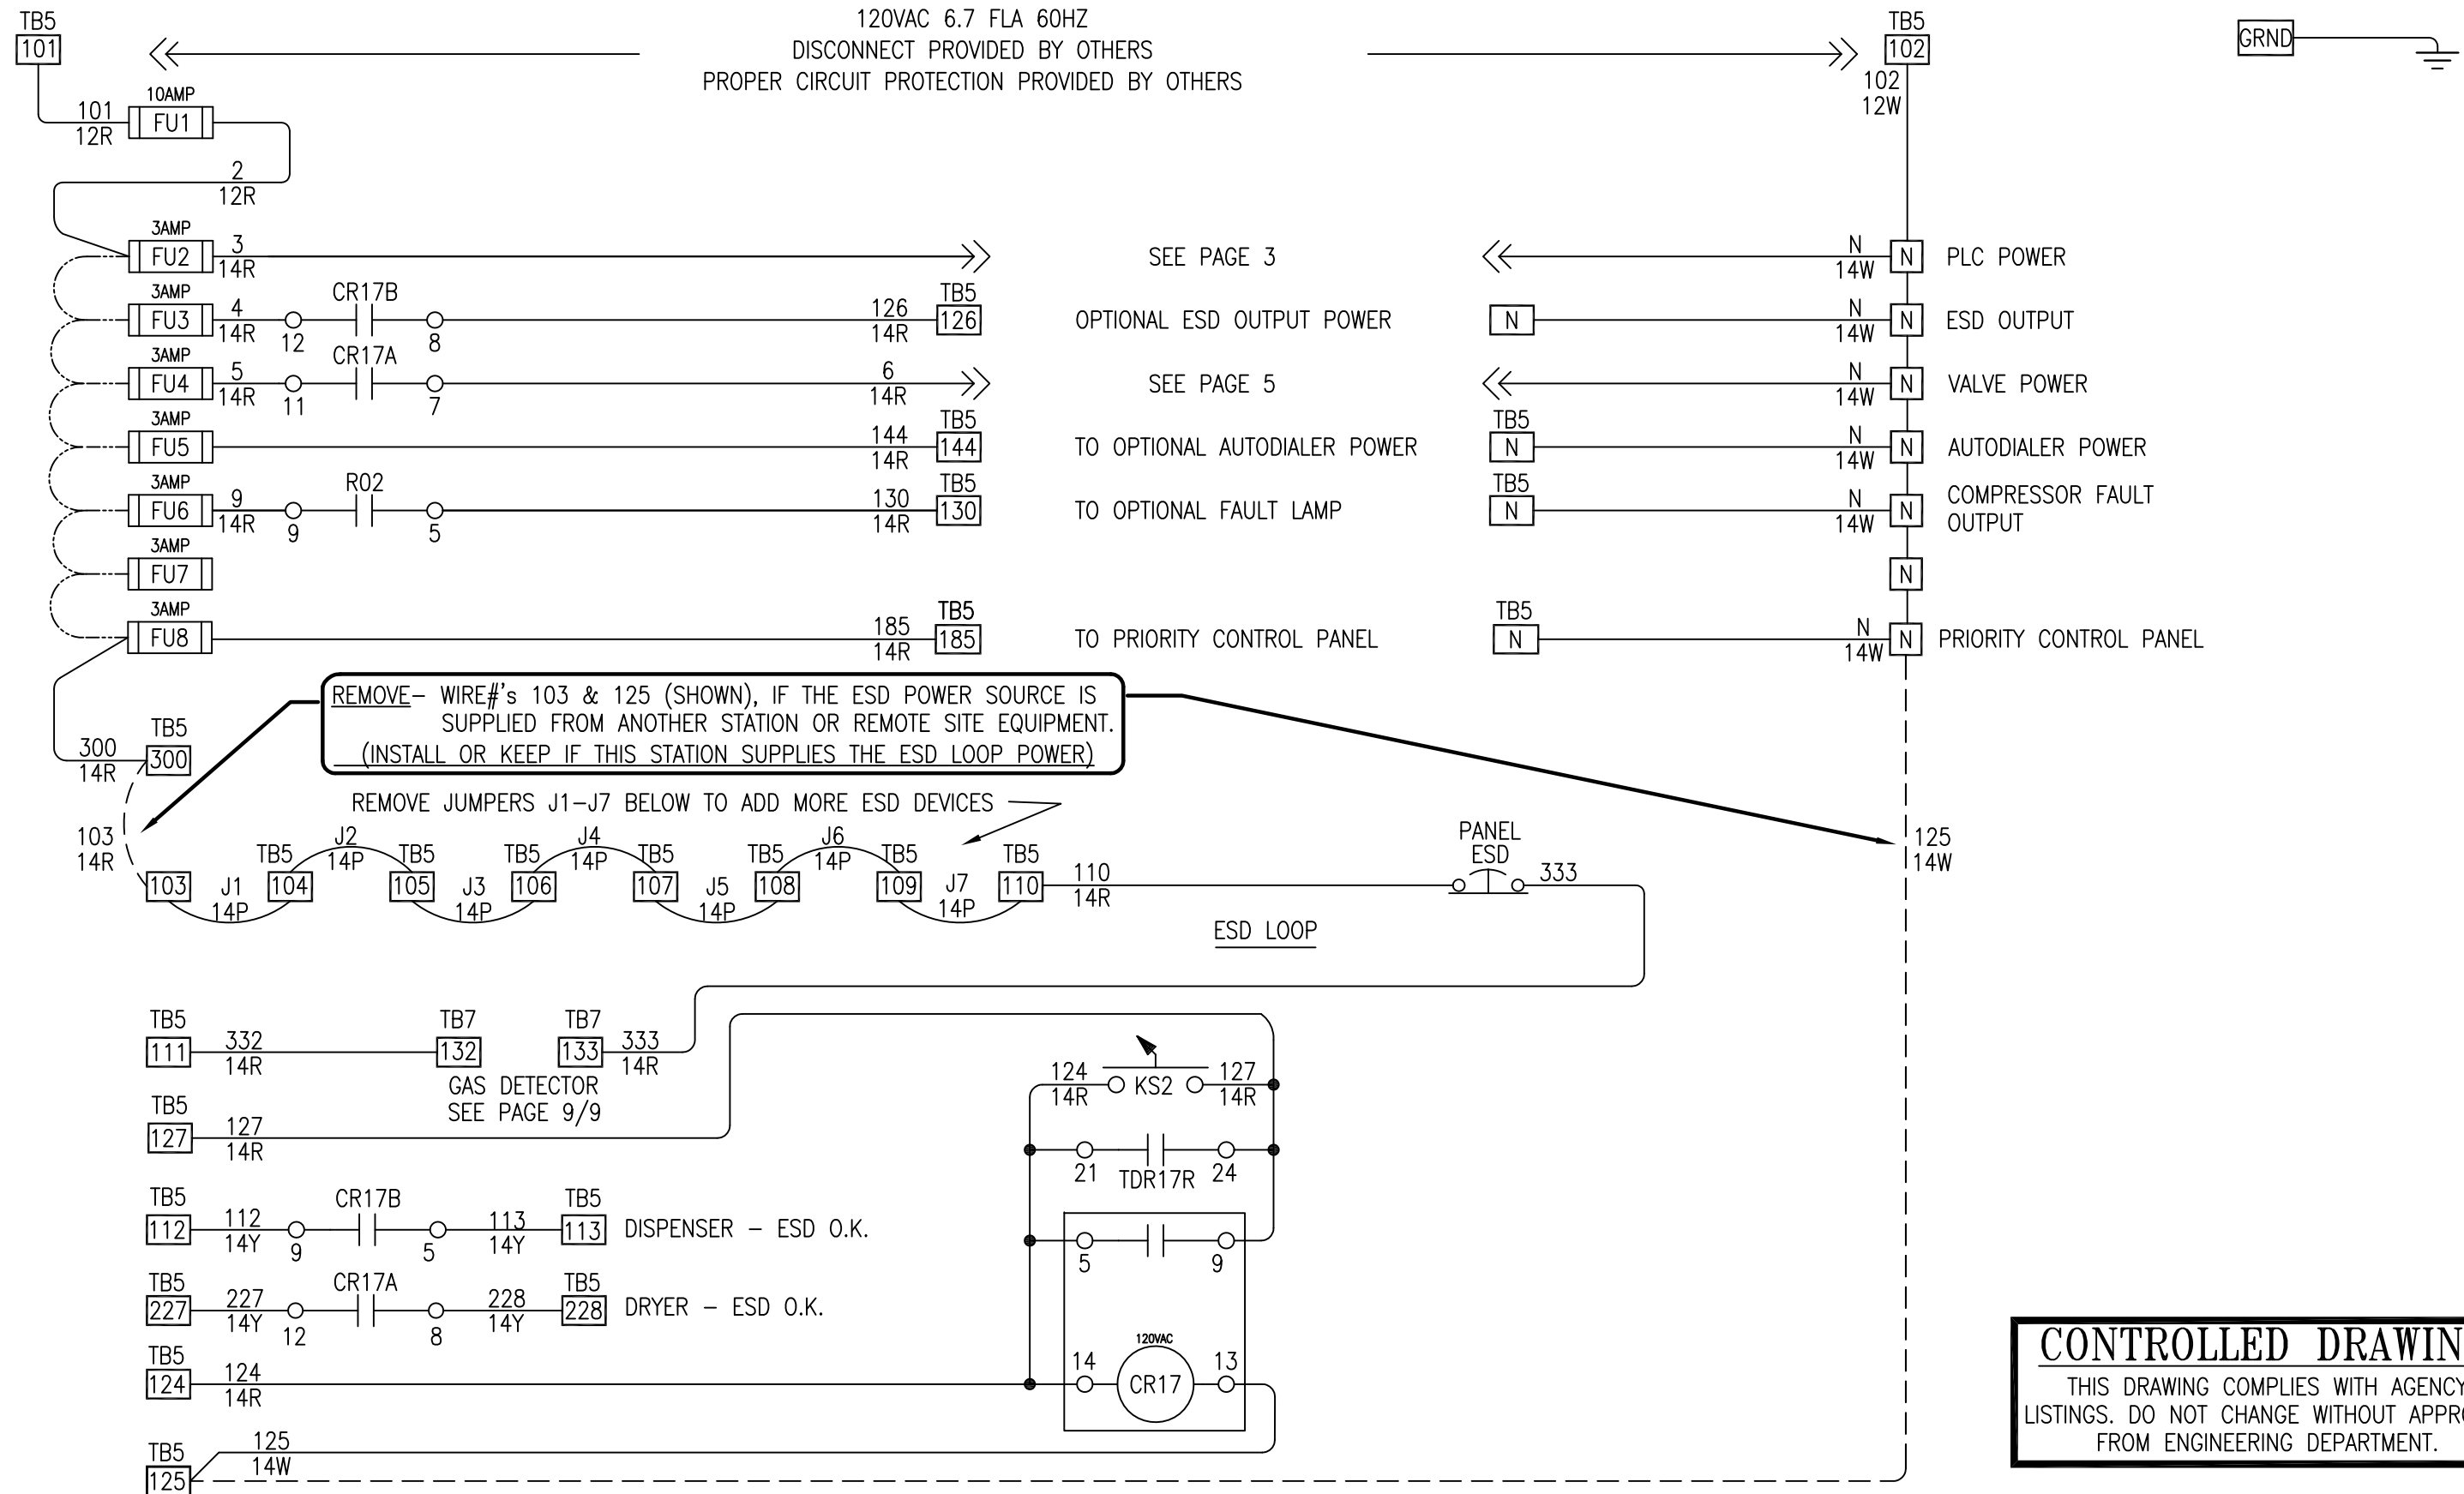

REV	DATE/BY	DESCRIPTION	REV	DATE/BY	DESCRIPTION
*					




ANGI ENERGY SYSTEMS
15 PLUMB STREET
MILTON, WI 53563
PH: 608-868-4626
FX: 608-868-2723

THIS DRAWING AND ALL INFORMATION THEREIN IS THE SOLE PROPERTY OF ANGI AND SHOULD NOT BE COPIED, REPRODUCED, OR SUBMITTED TO OTHERS WITHOUT WRITTEN AUTHORIZATION. ALL REPRODUCTIONS ARE SUBJECT TO RETURN ON DEMAND.

UNLESS OTHERWISE SPECIFIED		TITLE RX 371-ELECTRICAL SCHEMATIC/ELECTRIC DRIVE ARIEL FOUR STAGE/COMPRESSOR UNIT CONTROL PANEL			
BREAK SHARP EDGES		CUSTOMER Pioneer Natural Resources - Bivens		PROJECT NO. 30974-01	
ALL DIMENSIONS IN INCHES		SHEET 2/9	SCALE 1:1	DRAWING NO. A80-10-30974-01	REV. -
FRACTIONAL TWO PLACE DECIMAL THREE PLACE DECIMAL ANGLES		DRAWN BY NDA	DATE 1/18/12		

CONTROLLED DRAWING
THIS DRAWING COMPLIES WITH AGENCY LISTINGS. DO NOT CHANGE WITHOUT APPROVAL FROM ENGINEERING DEPARTMENT.

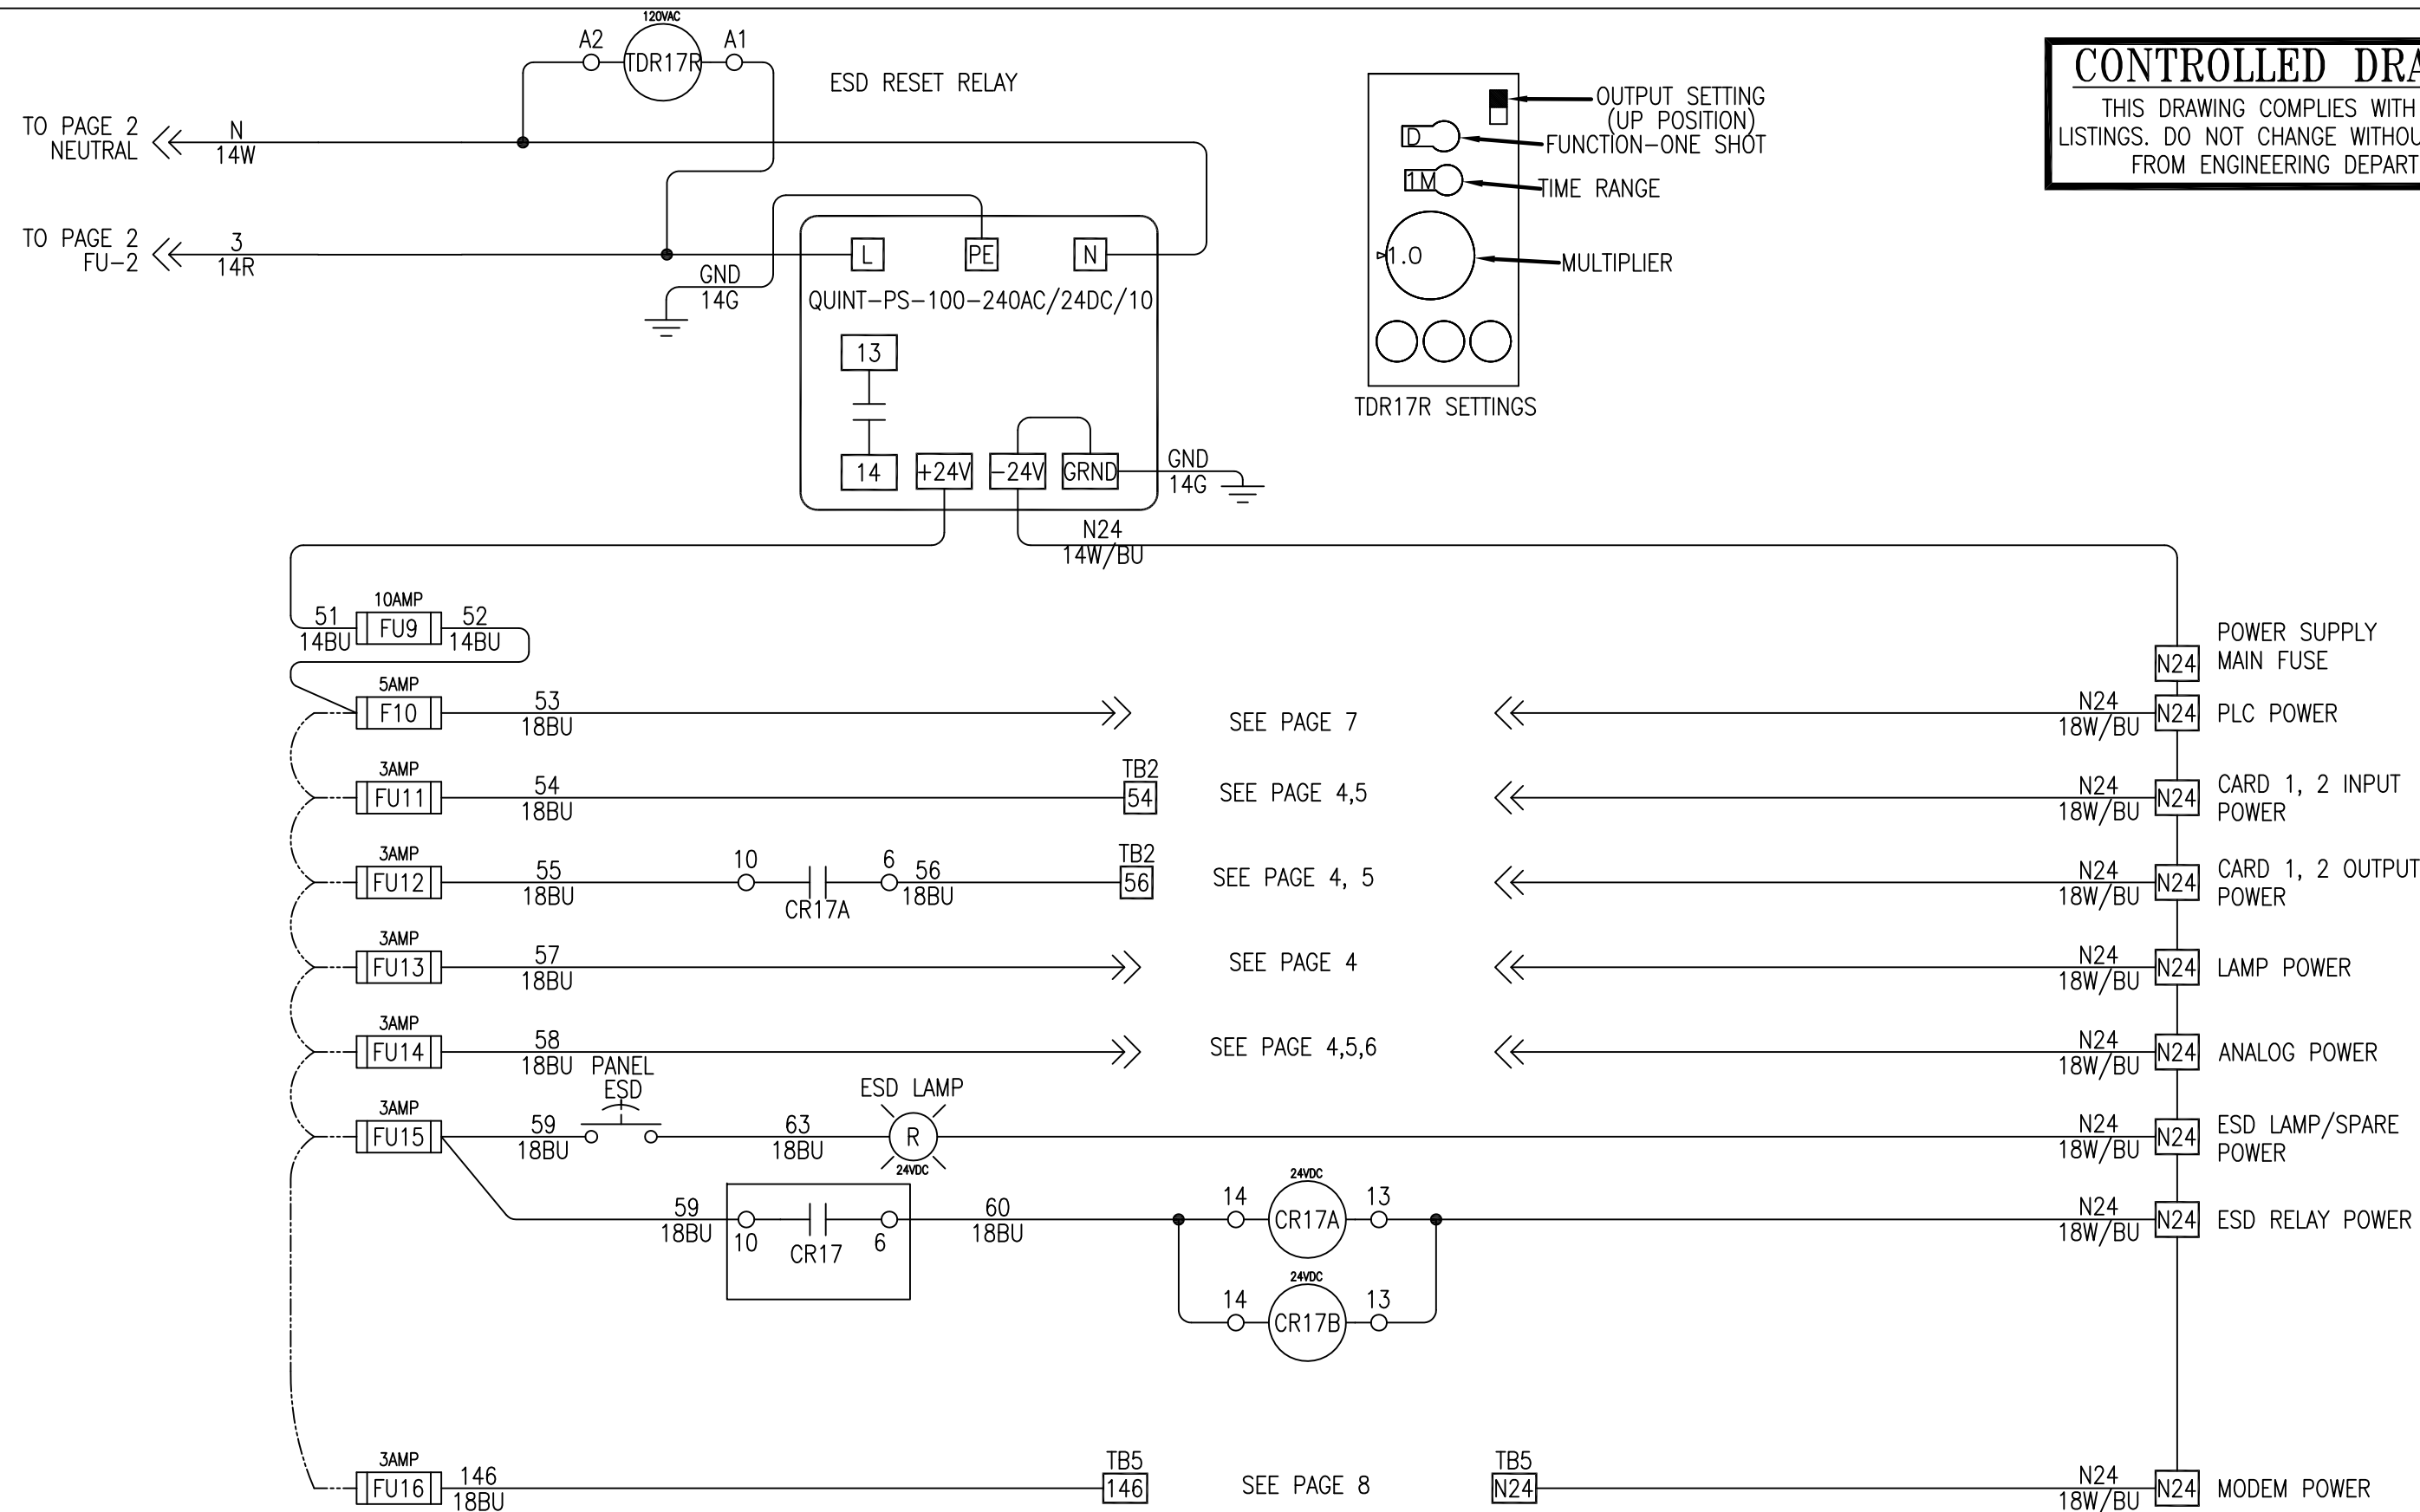


REV	DATE/BY	DESCRIPTION	REV	DATE/BY	DESCRIPTION



ANGI ENERGY SYSTEMS
15 PLUMB STREET
MILTON, WI 53563
PH: 608-868-4626
FX: 608-868-2723

THIS DRAWING AND ALL INFORMATION THEREIN IS THE SOLE PROPERTY OF ANGI AND SHOULD NOT BE COPIED, REPRODUCED, OR SUBMITTED TO OTHERS WITHOUT WRITTEN AUTHORIZATION. ALL REPRODUCTIONS ARE SUBJECT TO RETURN ON DEMAND.

 UNLESS OTHERWISE SPECIFIED


 BREAK SHARP EDGES

ALL DIMENSIONS IN INCHES


FRACTIONAL ±.125
TWO PLACE DECIMAL ±.010
THREE PLACE DECIMAL ±.005
ANGLES ±1°

TITLE				PROJECT NO.	
RX 371-ELECTRICAL SCHEMATIC/ELECTRIC DRIVE ARIEL FOUR STAGE/COMPRESSOR UNIT CONTROL PANEL				30974-01	
CUSTOMER		DRAWING NO.		REV.	
Pioneer Natural Resources - Bivens		A80-10-30974-01		-	
SHEET	SCALE	DRAWN BY	DATE		
3/9	1:1	NDA	1/18/12		




TO N24
SEE PAGE 3

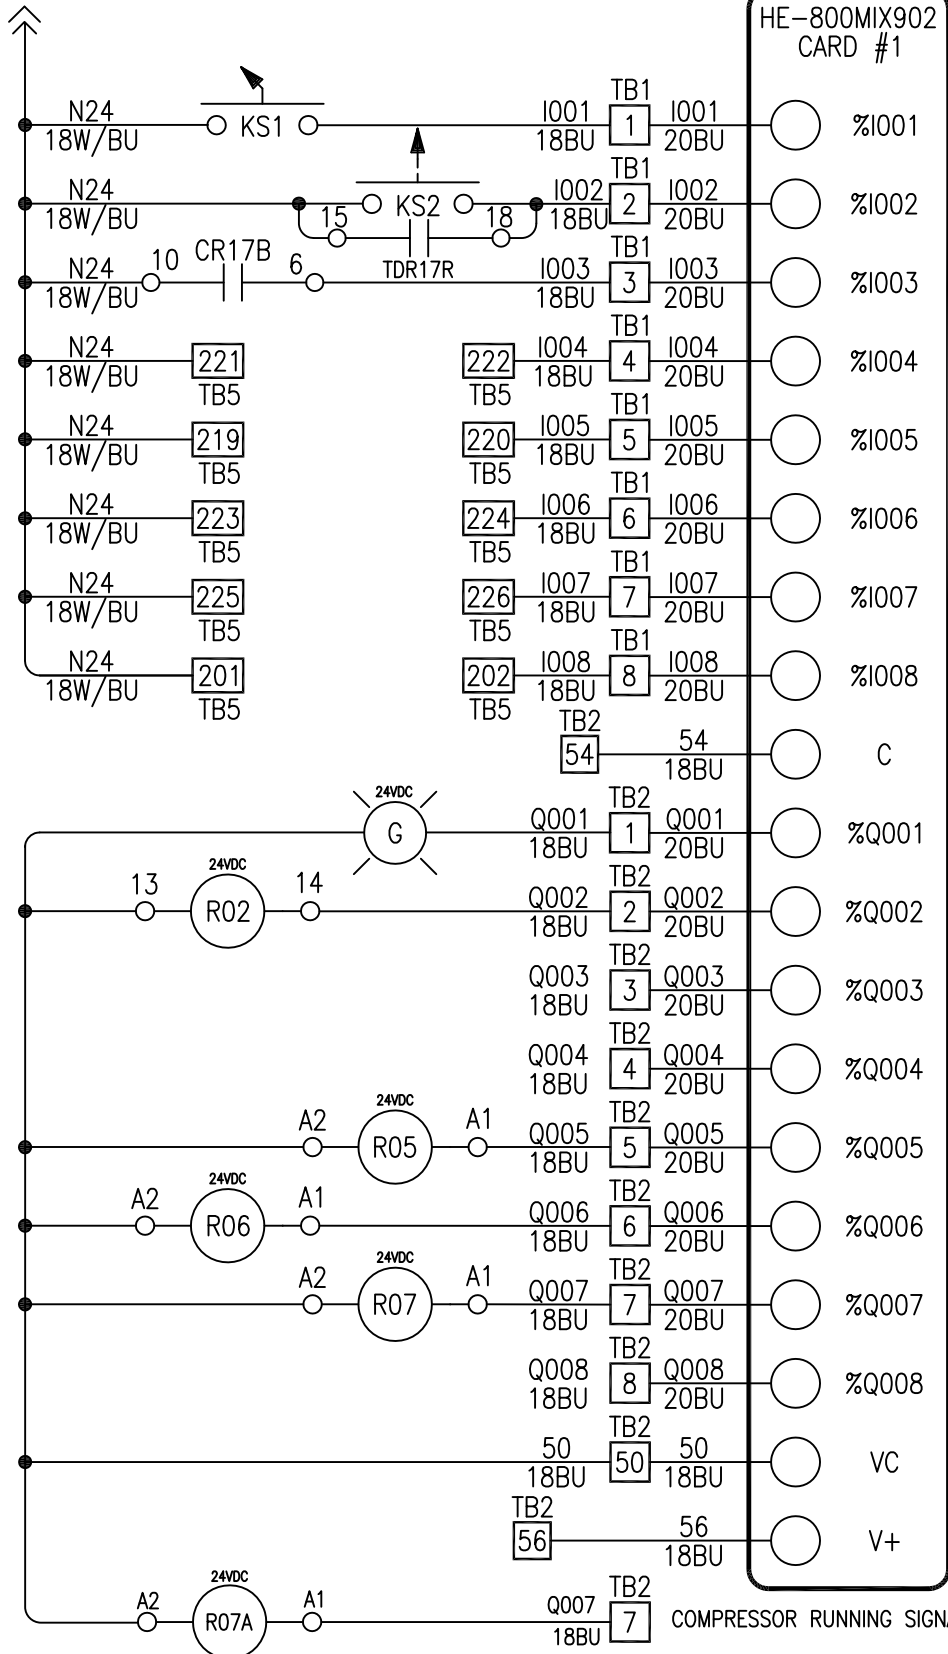


OFF/ON KEYSWITCH
RESET KEYSWITCH
ESD SHUTDOWN
GENERATOR ACTIVE
UPS ACTIVE
PRELUBE RUNNING
FAN RUNNING (NOT USED)
COMPRESSOR RUNNING
C
RUN LAMP
FAULT LAMP
SPARE
SPARE
PRELUBE RUN
FAN RUN
COMPRESSOR RUN
SPARE
VC
V+

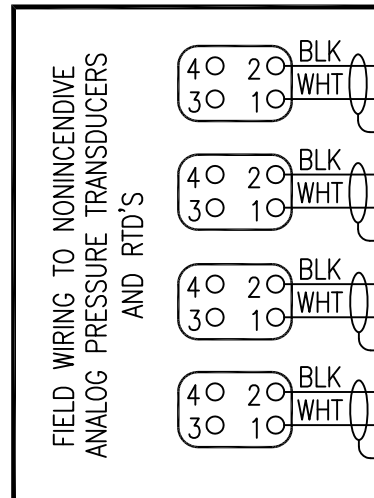

TO FU-13
SEE PAGE 3

 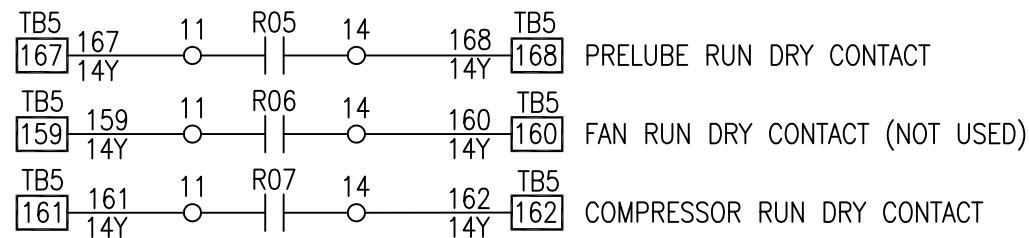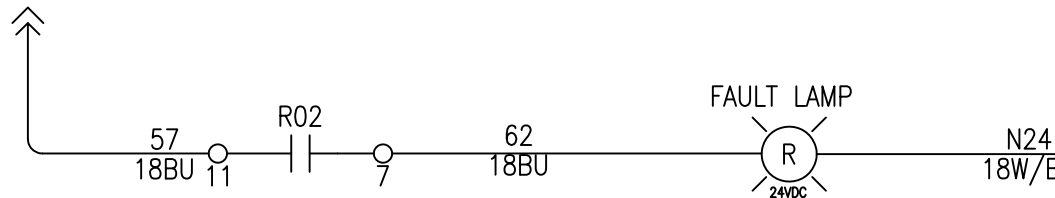


TO PAGE 3
FU-14

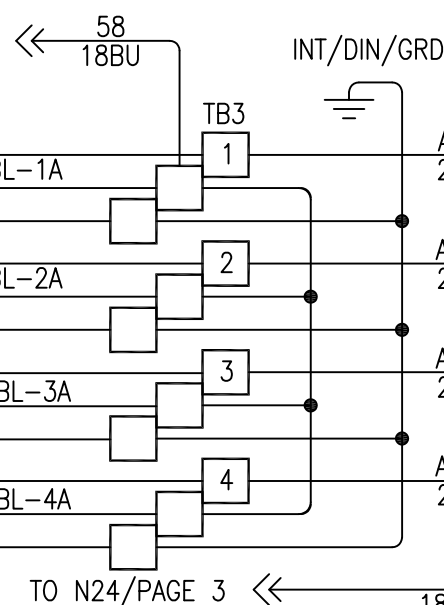

INT/DIN/GRD

HE-800MIX902
CARD #1

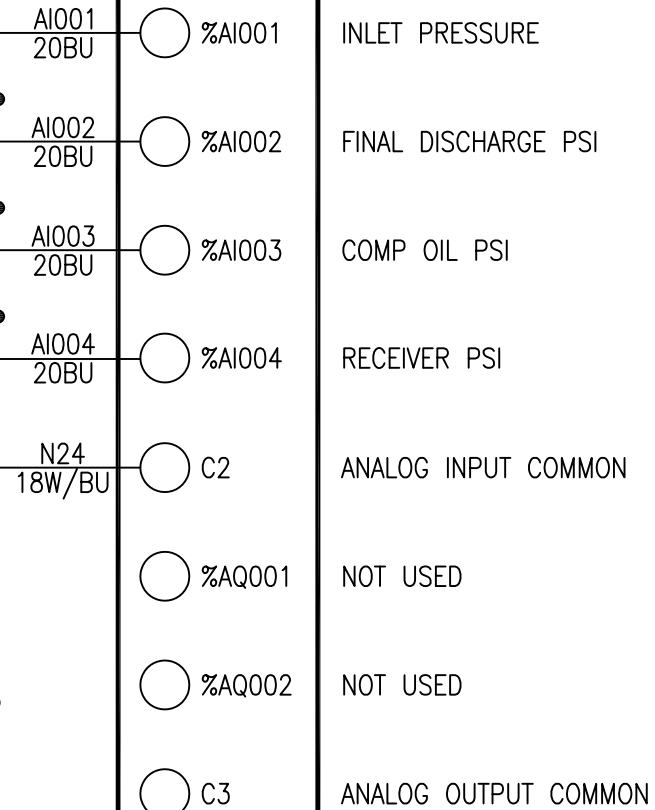

CONTROLLED DRAWING

THIS DRAWING COMPLIES WITH AGENCY
LISTINGS. DO NOT CHANGE WITHOUT APPROVAL
FROM ENGINEERING DEPARTMENT.

REV	DATE/BY	DESCRIPTION	REV	DATE/BY	DESCRIPTION
*					





THIS DRAWING AND ALL INFORMATION THEREIN IS THE SOLE PROPERTY OF ANGI
AND SHOULD NOT BE COPIED, REPRODUCED, OR SUBMITTED TO OTHERS WITHOUT
WRITTEN AUTHORIZATION. ALL REPRODUCTIONS ARE SUBJECT TO RETURN ON DEMAND.

UNLESS OTHERWISE SPECIFIED

BREAK SHARP EDGES
ALL DIMENSIONS IN INCHES
FRACTIONAL ±.125
TWO PLACE DECIMAL ±.010
THREE PLACE DECIMAL ±.005
ANGLES ±1°

TITLE RX 371-ELECTRICAL SCHEMATIC/ELECTRIC DRIVE ARIEL FOUR STAGE/COMPRESSOR UNIT CONTROL PANEL			
CUSTOMER Pioneer Natural Resources - Bivens		PROJECT NO. 30974-01	
SHEET 4/9	SCALE 1:1	DRAWING NO. A80-10-30974-01	REV. -
DRAWN BY NDA	DATE 1/18/12		

GAS DETECTOR CONNECTIONS
SEE PAGE 9 FOR DETAILS

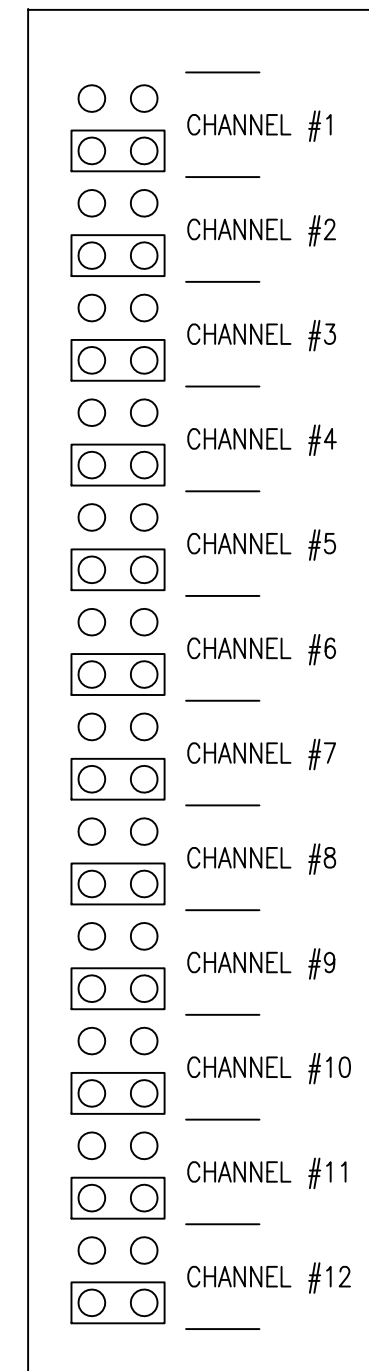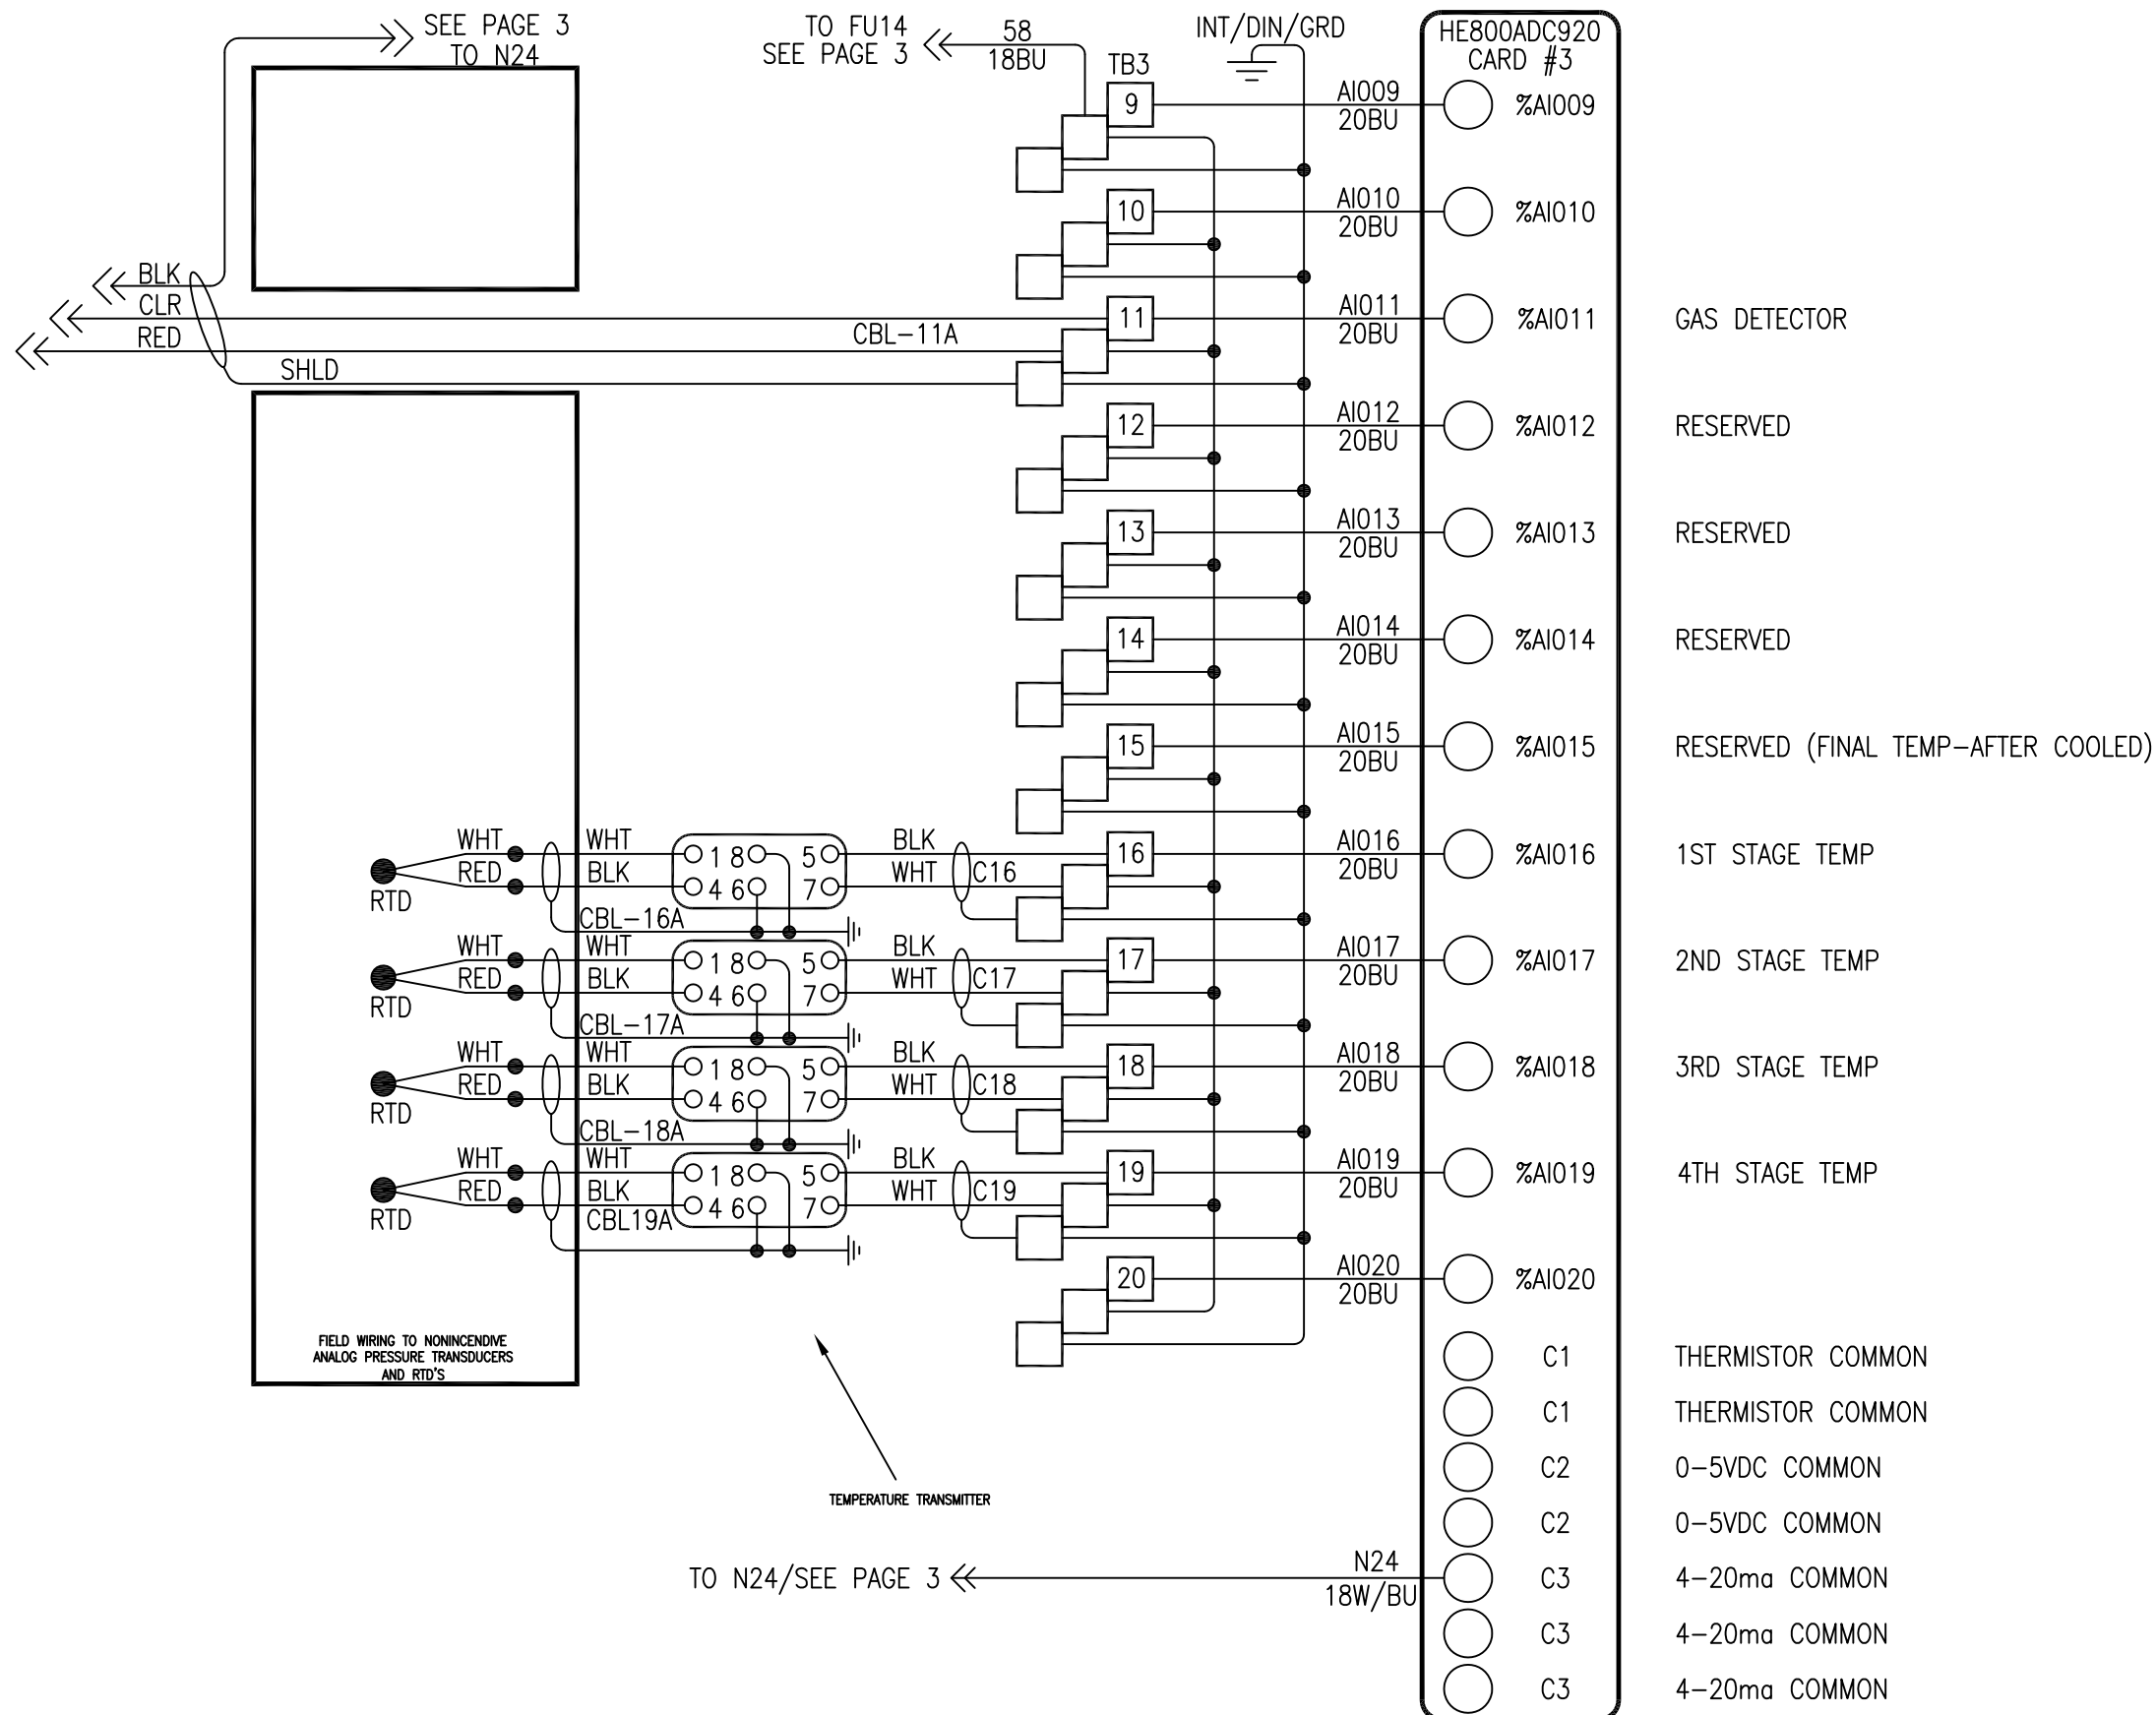

INPUT JUMPER CONFIGURATION

CONTROLLED DRAWING

THIS DRAWING COMPLIES WITH AGENCY LISTINGS. DO NOT CHANGE WITHOUT APPROVAL FROM ENGINEERING DEPARTMENT.

REV	DATE/BY	DESCRIPTION	REV	DATE/BY	DESCRIPTION
*					

ANGI
ENERGY SYSTEMS

ANGI ENERGY SYSTEMS
15 PLUMB STREET
MILTON, WI 53563
PH: 608-868-4626
FX: 608-868-2723

THIS DRAWING AND ALL INFORMATION THEREIN IS THE SOLE PROPERTY OF ANGI AND SHOULD NOT BE COPIED, REPRODUCED, OR SUBMITTED TO OTHERS WITHOUT WRITTEN AUTHORIZATION. ALL REPRODUCTIONS ARE SUBJECT TO RETURN ON DEMAND.

UNLESS OTHERWISE SPECIFIED

BREAK SHARP EDGES

ALL DIMENSIONS IN INCHES


FRACTIONAL ±.125
TWO PLACE DECIMAL ±.010
THREE PLACE DECIMAL ±.005
ANGLES ±1°

TITLE RX 371-ELECTRICAL SCHEMATIC/ELECTRIC DRIVE ARIEL FOUR STAGE/COMPRESSOR UNIT CONTROL PANEL			
CUSTOMER Pioneer Natural Resources - Bivens		PROJECT NO. 30974-01	
SHEET 6/9	SCALE 1:1	DRAWING NO. A80-10-30974-01	REV. -
DRAWN BY NDA	DATE 1/18/12		

RESERVED FOR 4TH CARD

CONTROLLED DRAWING

 THIS DRAWING COMPLIES WITH AGENCY LISTINGS. DO NOT CHANGE WITHOUT APPROVAL FROM ENGINEERING DEPARTMENT.

						 ANGI ENERGY SYSTEMS 15 PLUMB STREET MILTON, WI 53563 PH: 608-868-4626 FX: 608-868-2723 THIS DRAWING AND ALL INFORMATION THEREIN IS THE SOLE PROPERTY OF ANGI AND SHOULD NOT BE COPIED, REPRODUCED, OR SUBMITTED TO OTHERS WITHOUT WRITTEN AUTHORIZATION. ALL REPRODUCTIONS ARE SUBJECT TO RETURN ON DEMAND.	UNLESS OTHERWISE SPECIFIED		TITLE RX 371-ELECTRICAL SCHEMATIC/ELECTRIC DRIVE ARIEL FOUR STAGE/COMPRESSOR UNIT CONTROL PANEL							
									CUSTOMER Pioneer Natural Resources – Bivens		PROJECT NO. 30974-01					
							BREAK SHARP EDGES		SHEET 7/9	SCALE 1:1	DRAWING NO. A80-10-30974-01	REV. -				
							ALL DIMENSIONS IN INCHES									
							FRACTIONAL	±.125								
						TWO PLACE DECIMAL	±.010	DRAWN BY NDA			DATE 1/18/12					
						THREE PLACE DECIMAL	±.005									
						ANGLES	±1°									
REV	DATE/BY	DESCRIPTION	REV	DATE/BY	DESCRIPTION											

WIRE#	SIZE	COLOR TYPE	START	WIRE PATH							END	DETAILS
2x1T-1	4/0	AWG	P5	SS1-A	C109A						M1	
2x1T-2	4/0	AWG	P5	SS1-A	C109A						M1	
2x1T-3	4/0	AWG	P5	SS1-A	C109A						M1	
GROUND	2	AWG	P5	GROUND	C109A						M1	
3T-1	12	AWG	P5	MMS1-A	C107A						J1	1
3T-2	12	AWG	P5	MMS1-A	C107A						J1	2
3T-3	12	AWG	P5	MMS1-A	C107A						J1	3
GND	12	AWG	P5	GROUND	C107A						J1	GROUND
2T-1	10	AWG	P5	MMS2-A	C107A						J1	4
2T-2	10	AWG	P5	MMS2-A	C107A						J1	5
2T-3	10	AWG	P5	MMS2-A	C107A						J1	6
GND	12	AWG	P5	GROUND	C108A						J1	GROUND
10A	12	AWG	P5	H4	C108A						J1	10
N	12	AWG	P5	N4	C108A						J1	N
12A	12	AWG	P5	H3	C108A						J1	12
N	12	AWG	P5	N3	C108A						J1	N
101A	12	AWG	P5	H1	C104A						P1	TB5-101
102A	12	AWG	P5	N1	C104A						P1	TB5-102
GND	12	AWG	P5	GROUND	C104A						P1	GROUND
112A	14	AWG	P5	112A	C104A						P1	TB5-112
113A	14	AWG	P5	113A	C104A						P1	TB5-113
128A	14	AWG	P5	128A	C104A						P1	TB5-128
129A	14	AWG	P5	129A	C104A						P1	TB5-129
159A	14	AWG	P5	159A	C104A						P1	TB5-159
160A	14	AWG	P5	160A	C104A						P1	TB5-160
161A	14	AWG	P5	161A	C104A						P1	TB5-161
162A	14	AWG	P5	162A	C104A						P1	TB5-162
167A	14	AWG	P5	167A	C104A						P1	TB5-167
168A	14	AWG	P5	168A	C104A						P1	TB5-168
201A	14	AWG	P5	201A	C104A						P1	TB5-201
202A	14	AWG	P5	202A	C104A						P1	TB5-202
223A	14	AWG	P5	223A	C104A						P1	TB5-223
224A	14	AWG	P5	224A	C104A						P1	TB5-224
225A	14	AWG	P5	225A	C104A						P1	TB5-225
226A	14	AWG	P5	226A	C104A						P1	TB5-226
227A	14	AWG	P5	210	C104A						P1	TB5-227
228A	14	AWG	P5	211	C104A						P1	TB5-228
105A	14	AWG	P1	TB5-105	C101A						ESD1	BUTTON
106A	14	AWG	P1	TB5-106	C101A						ESD1	BUTTON
107A	14	AWG	P1	TB5-107	C101A	C101B					ESD2	BUTTON
107B	14	AWG	P1	ESD2	C101C						ESD3	BUTTON
108A	14	AWG	P1	TB5-108	C101A	C101B	C101C				ESD3	BUTTON
8T-1	12	AWG	P5	H8	C110A	JB1					C110A-1	D1 TS2-1
N	12	AWG	P5	N8	C110A	JB1					C110A-1	D1 TS2-2
GND	12	AWG	P5	GROUND	C110A	JB1					C110A-1	D1 TS2-3
9T-1	12	AWG	P5	H9	C110A	JB1					C110A-2	D2 TS2-1
N	12	AWG	P5	N9	C110A	JB1					C110A-2	D2 TS2-2
GND	12	AWG	P5	GROUND	C110A	JB1					C110A-2	D2 TS2-3


WIRE#	SIZE	COLOR TYPE	START	WIRE PATH							END	DETAILS
11T-1	12	AWG	P5	H11							C114A	F1 BLK
N	12	AWG	P5	N11							C114A	F1 WHT
GND	12	AWG	P5	GROUND							C114A	F1 GRN
4T-1	14	AWG	P5	H3							C111A	P6 TB5-101
N	14	AWG	P5	N3							C111A	P6 TB5-102
GND	14	AWG	P5	GROUND							C111A	P6 GROUND
109A	14	AWG	P1	TB5-109							C102A	P6 TB5-101
110A	14	AWG	P1	TB5-110							C102A	P6 TB5-102
124B	14	AWG	P1	TB5-124							C102A	P6 TB5-124
125B	14	AWG	P1	TB5-125							C102A	P6 TB5-125
1A	14	AWG	F1	TB1-2							C401A	D1 TS3-1
3A	14	AWG	F1	TB1-5							C401A	D1 TS3-3
5A	14	AWG	F1	TB1-3							C401A	D1 TS3-5
7A	14	AWG	F1	TB1-6							C401A	D1 TS3-7
1B	14	AWG	F1	TB1-2							C401B	D2 TS3-1
3B	14	AWG	F1	TB1-5							C401B	D2 TS3-3
5B	14	AWG	F1	TB1-3							C401B	D2 TS3-5
7B	14	AWG	F1	TB1-6							C401B	D2 TS3-7
7T-1	10	AWG	P5	MS3	C112A							P3 L1
7T-2	10	AWG	P5	MS3	C112A							P3 L2
7T-3	10	AWG	P5	MS3	C112A							P3 L3
GND	10	AWG	P5	GROUND	C112A							P3 GND
CBL1	20	2-WIRE	D1	TB2-14/15							C402A	F1 J4 +12/P1/OV HOSE 1
CBL2	20	2-WIRE	D1	TB2-17/18							C402A	F1 J4 +12/P1/OV HOSE 2
CBL3	20	2-WIRE	D2	TB2-14/15							C402B	F1 J6 +12/P1/OV HOSE 3
CBL4	20	2-WIRE	D2	TB2-17/18							C402B	F1 J6 +12/P1/OV HOSE 4
181B	#14	AWG	P1	TB5-181	C103A							P3 50
182B	#14	AWG	P1	TB5-182	C103A							P3 51
RX371AE	CBL	5-20GA	P1	TB7-31	C106A							P6 TB6-1
179B	14	AWG	P1	TB5-179	C106A							P6 TB5-163
180B	14	AWG	P1	TB5-180	C106A							P6 TB5-164
PH1	NA	PHONE	NA	UTILITY	C105A							P1 MODEM

NOTE: 10% SPARES MUST BE INCLUDED AND CLEARLY LABELED IN CONDUIT RING WHENEVER POSSIBLE

B	9/7/12 PJH	ADD DRYER										
REV	DATE/BY	DESCRIPTION									REV	DATE/BY



 ANGI ENERGY SYSTEMS
15 PLUMB STREET
MILTON, WI 53563
PH: 608-868-4626
FX: 608-868-2723

UNLESS OTHERWISE SPECIFIED

BREAK SHARP EDGES
ALL DIMENSIONS IN INCHES
FRACTIONAL ±.125
TWO PLACE DECIMAL ±.010
THREE PLACE DECIMAL ±.005
ANGLES ±1°

TITLE
SINGLE LINE/CUSTOMER INTERCONNECT DETAILS
ARIEL MINI SKID COMPRESSOR

CUSTOMER
Pioneer – Bivens, TX

SHEET
1/7

SCALE
NA

DRAWN BY
PJH


DATE
2/8/12

PROJECT NO.
30974-01

DRAWING NO.
A80-50-30974

REV.
B

THIS DRAWING AND ALL INFORMATION THEREIN IS THE SOLE PROPERTY OF ANGI AND SHOULD NOT BE COPIED, REPRODUCED, OR SUBMITTED TO OTHERS WITHOUT WRITTEN AUTHORIZATION. ALL REPRODUCTIONS ARE SUBJECT TO RETURN ON DEMAND.

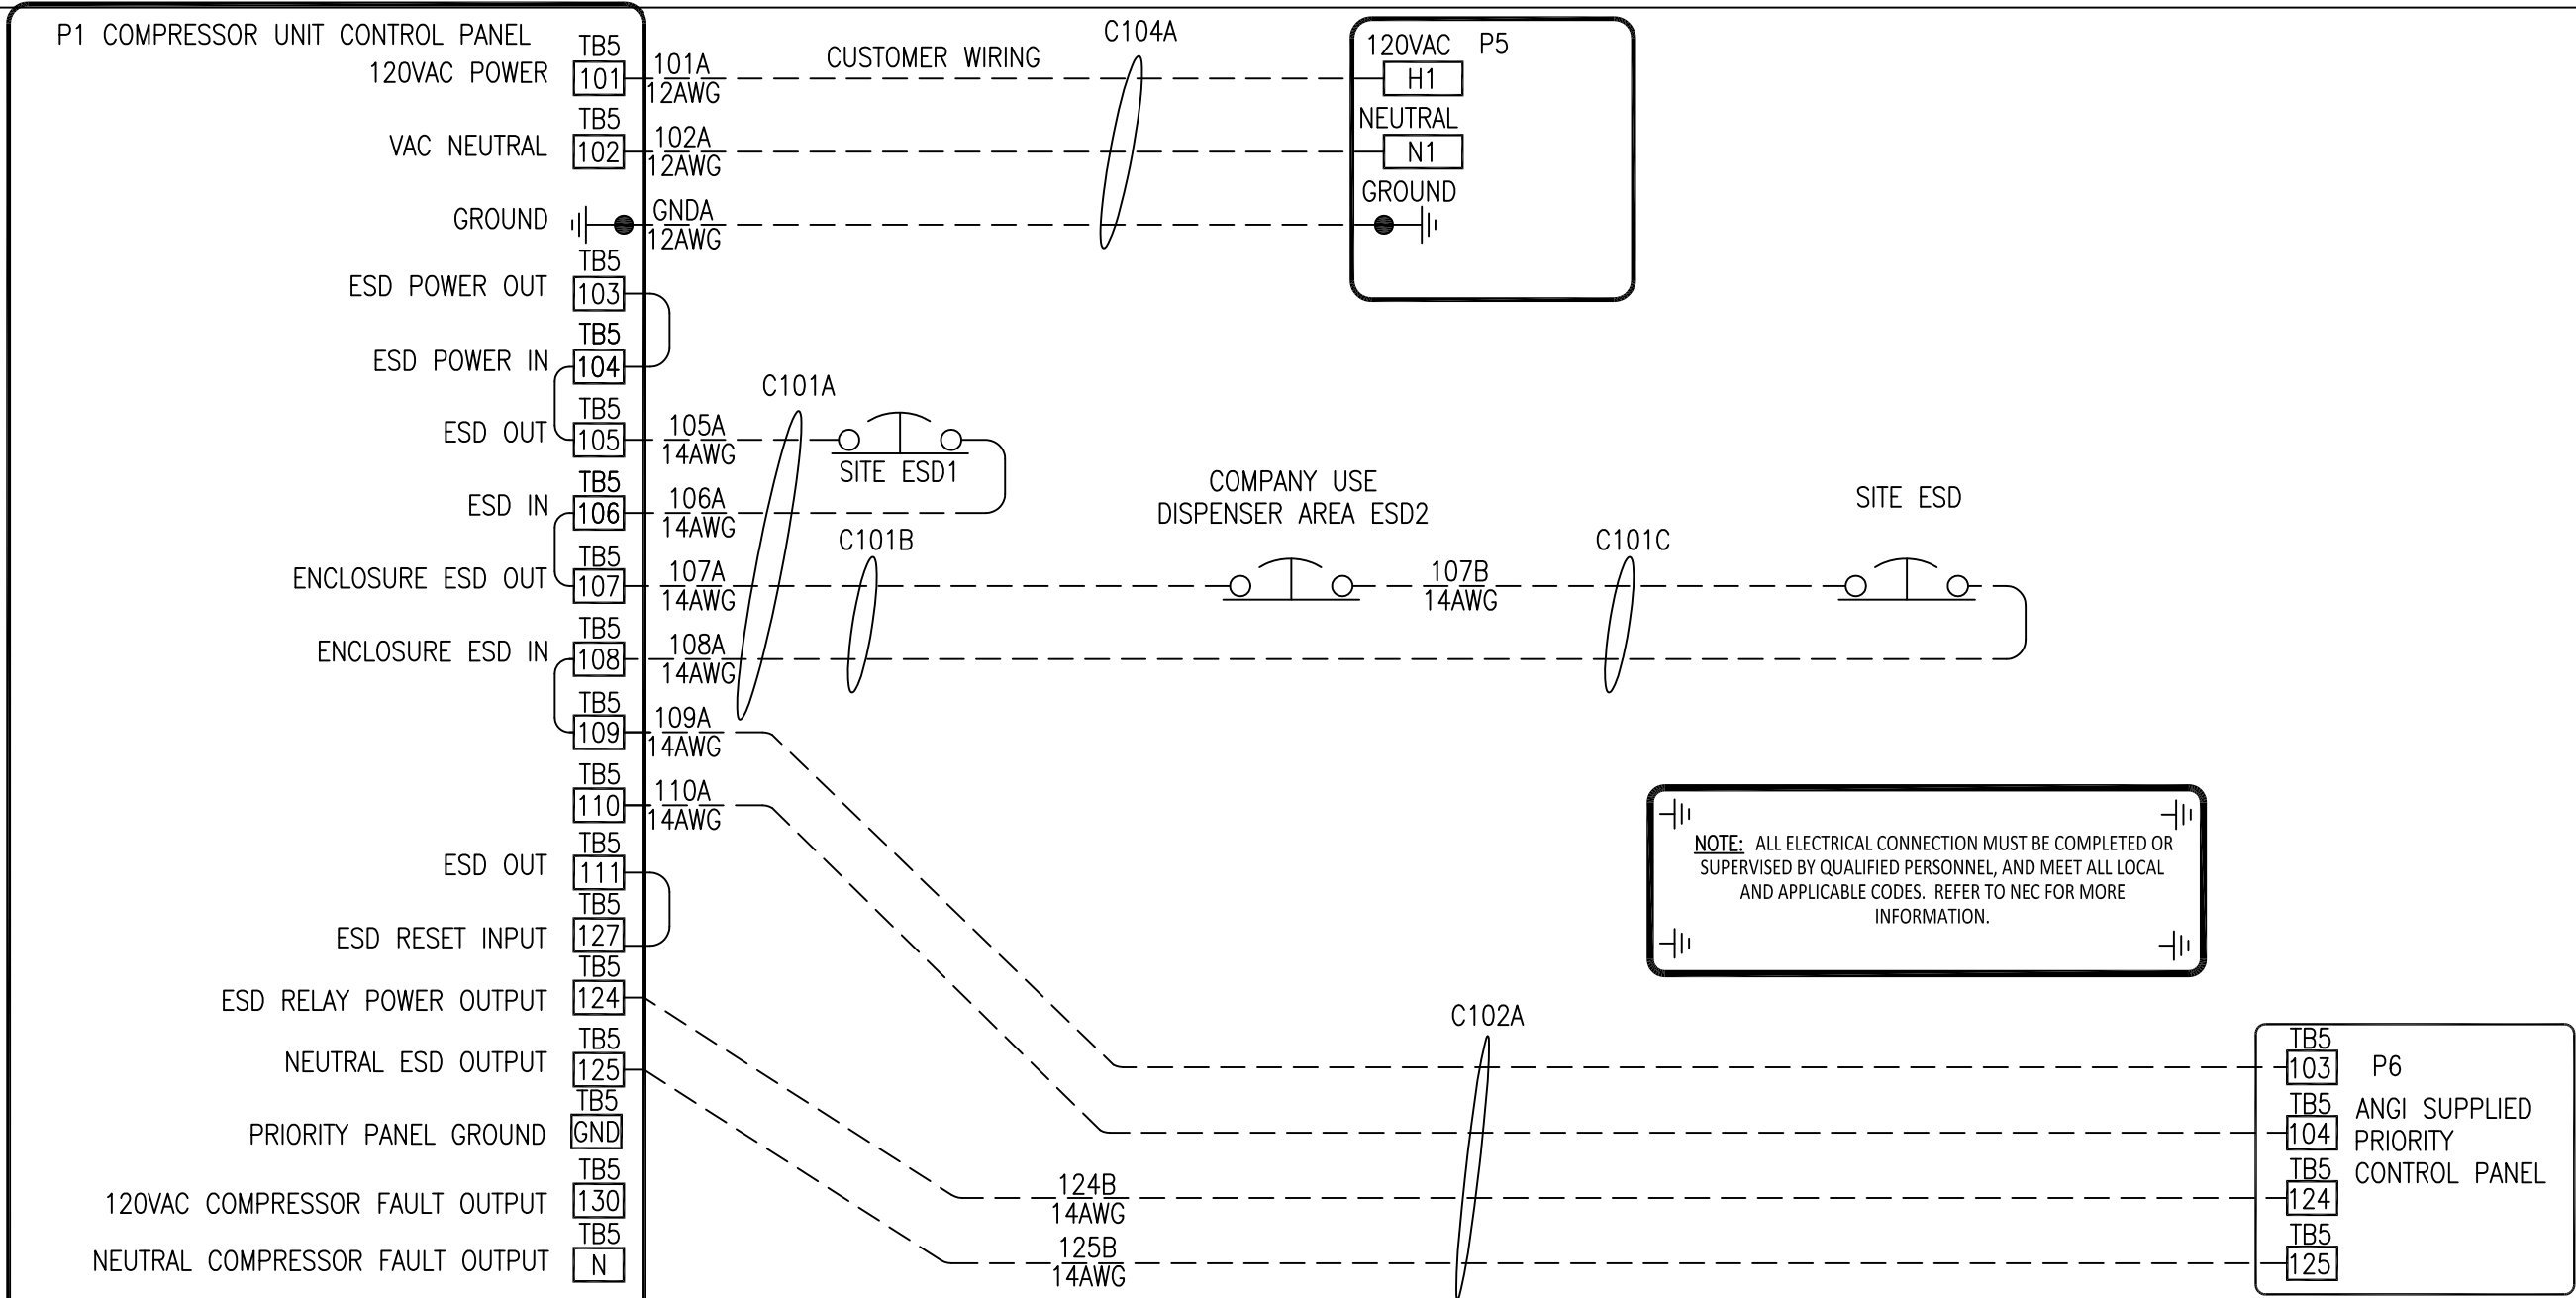


REV	DATE/BY	DESCRIPTION	REV	DATE/BY	DESCRIPTION



ANGI ENERGY SYSTEMS
15 PLUMB STREET
MILTON, WI 53563
PH: 608-868-4626
FX: 608-868-2723


THIS DRAWING AND ALL INFORMATION THEREIN IS THE SOLE PROPERTY OF ANGI AND SHOULD NOT BE COPIED, REPRODUCED, OR SUBMITTED TO OTHERS WITHOUT WRITTEN AUTHORIZATION. ALL REPRODUCTIONS ARE SUBJECT TO RETURN ON DEMAND.

 UNLESS OTHERWISE SPECIFIED



BREAK SHARP EDGES
ALL DIMENSIONS IN INCHES
FRACTIONAL ±.125
TWO PLACE DECIMAL ±.010
THREE PLACE DECIMAL ±.005
ANGLES ±1°

TITLE				
SINGLE LINE/CUSTOMER INTERCONNECT DETAILS ARIEL MINI SKID COMPRESSOR				
CUSTOMER		Pioneer – Bivens, TX		PROJECT NO. 30974-01
SHEET	3/7	SCALE	NA	DRAWING NO. A80-50-30974
DRAWN BY PJH		DATE	2/8/12	REV. B

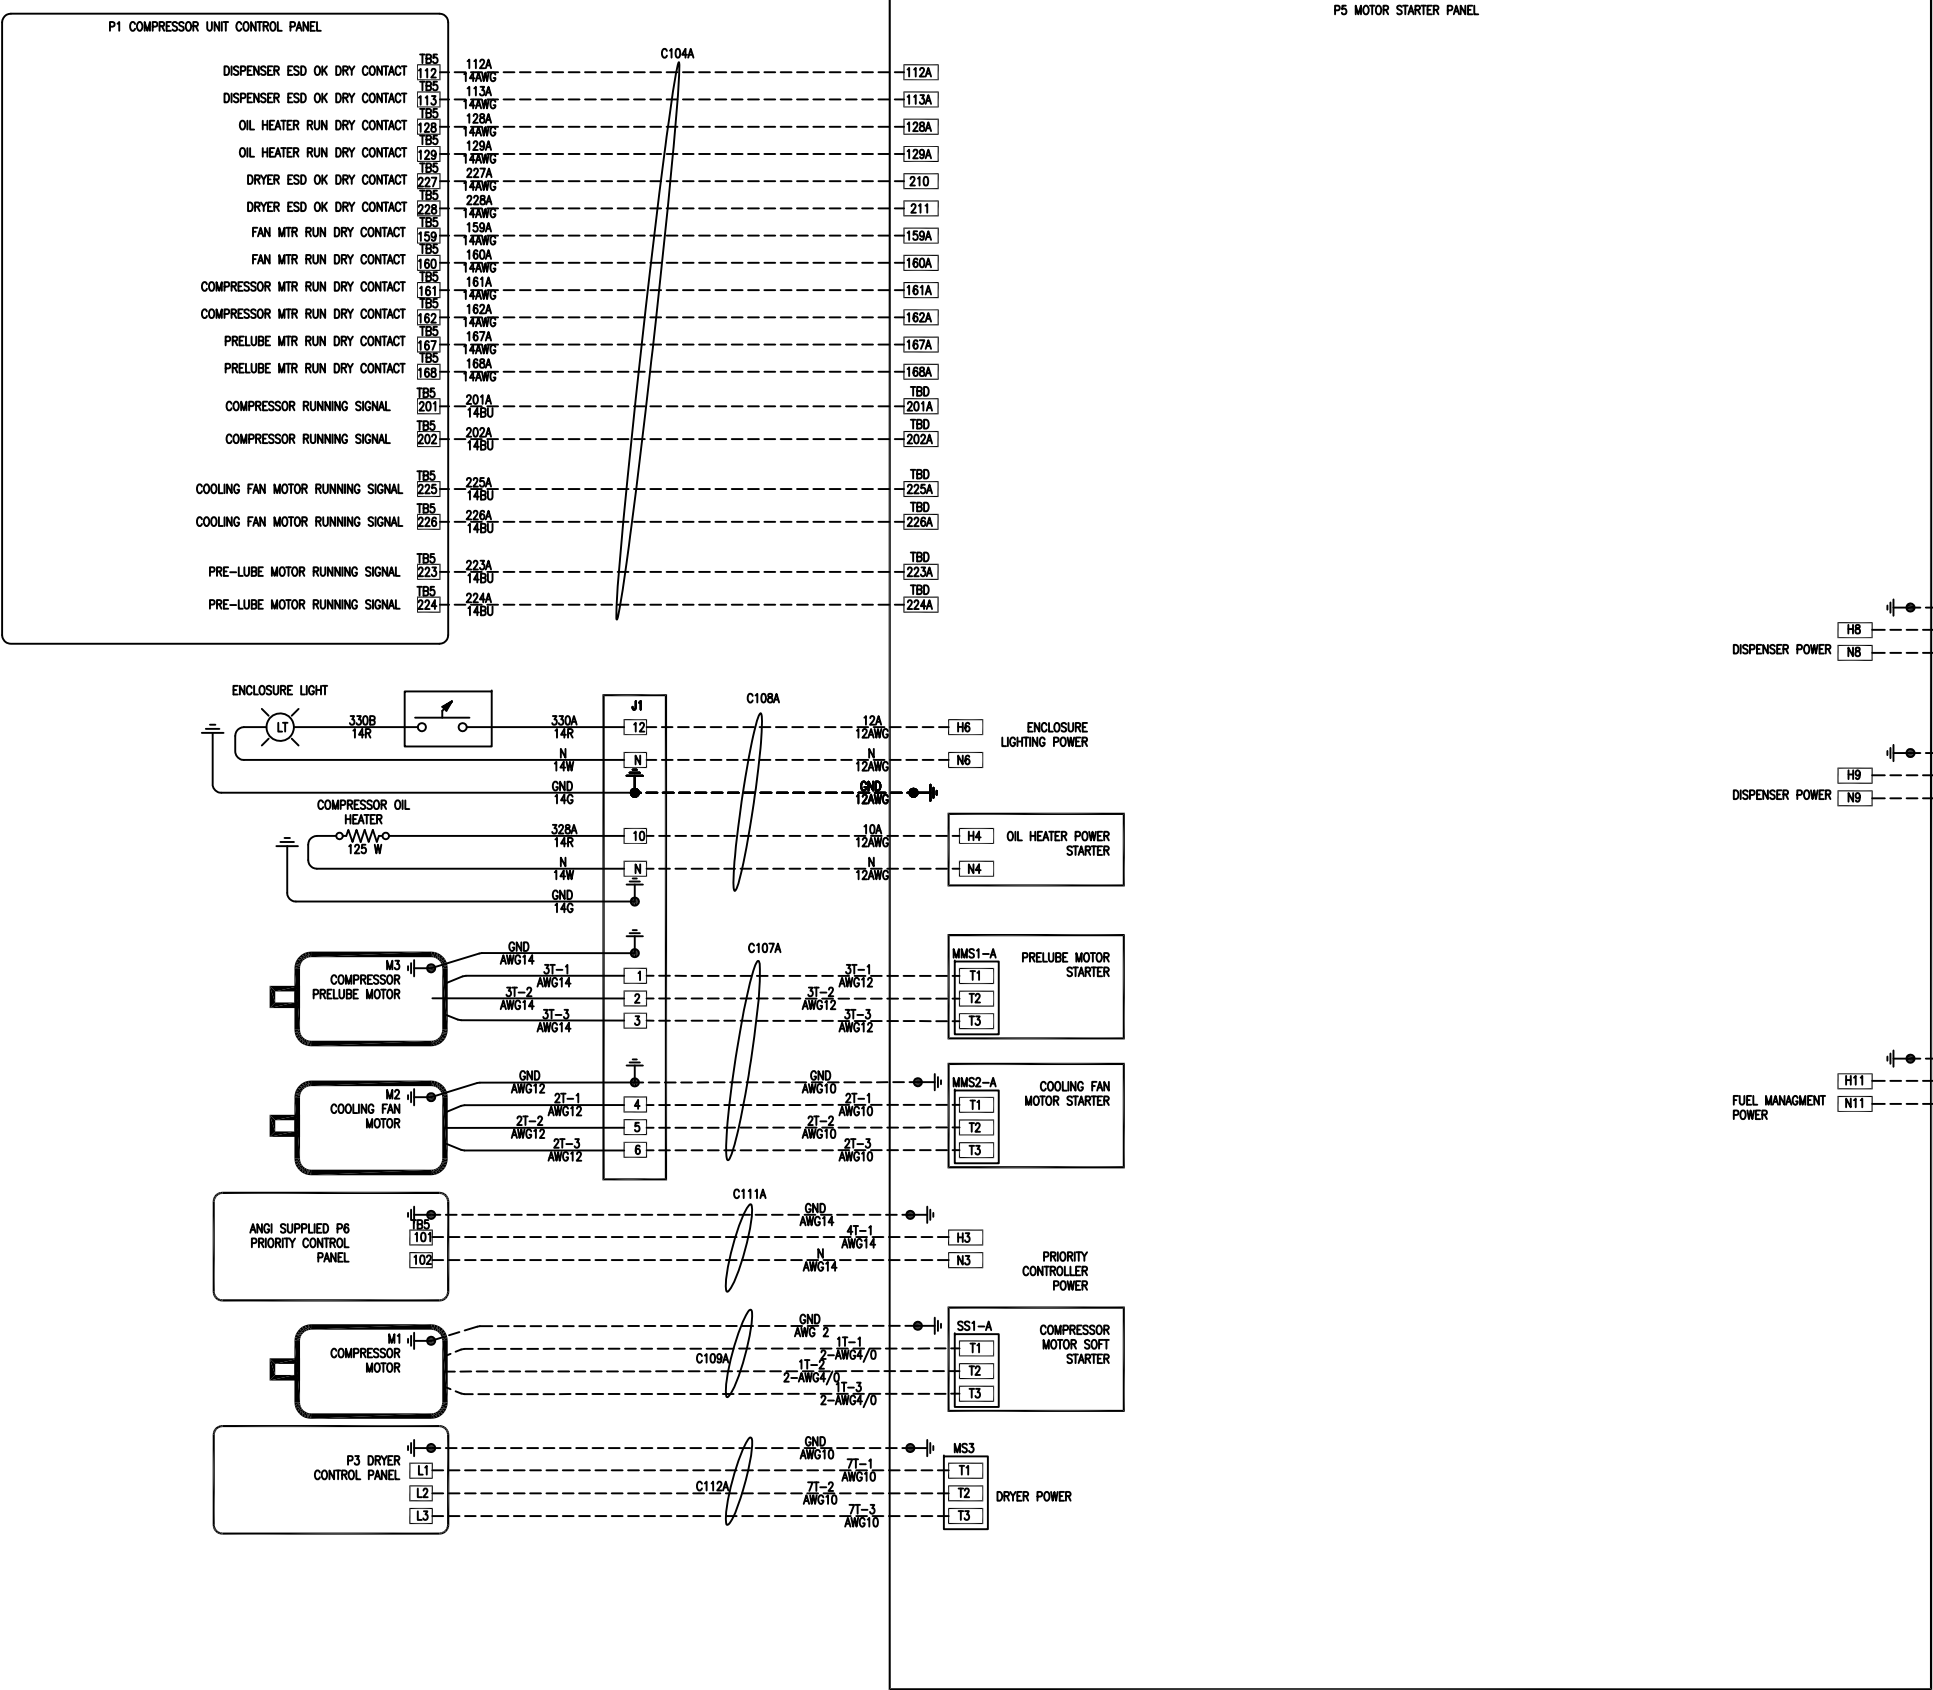

B	9/7/12 PJH	ADD DRYER			
REV	DATE/BY	DESCRIPTION	REV	DATE/BY	DESCRIPTION




THIS DRAWING AND ALL INFORMATION THEREIN IS THE SOLE PROPERTY OF ANGI AND SHOULD NOT BE COPIED, REPRODUCED, OR SUBMITTED TO OTHERS WITHOUT WRITTEN AUTHORIZATION. ALL REPRODUCTIONS ARE SUBJECT TO RETURN ON DEMAND.

ANGI ENERGY SYSTEMS
15 PLUMB STREET
MILTON, WI 53563
PH: 608-868-4626
FX: 608-868-2723

UNLESS OTHERWISE SPECIFIED
BREAK SHARP EDGES
ALL DIMENSIONS IN INCHES
FRACTIONAL ±.125
TWO PLACE DECIMAL ±.010
THREE PLACE DECIMAL ±.005
ANGLES ±1°

TITLE SINGLE LINE/CUSTOMER INTERCONNECT DETAILS ARIEL MINI SKID COMPRESSOR					
CUSTOMER Pioneer – Bivens, TX			PROJECT NO. 30974-01		
SHEET 4/7		SCALE NA		DRAWING NO. A80-50-30974	
DRAWN BY PJH		DATE 2/8/12		REV. B	

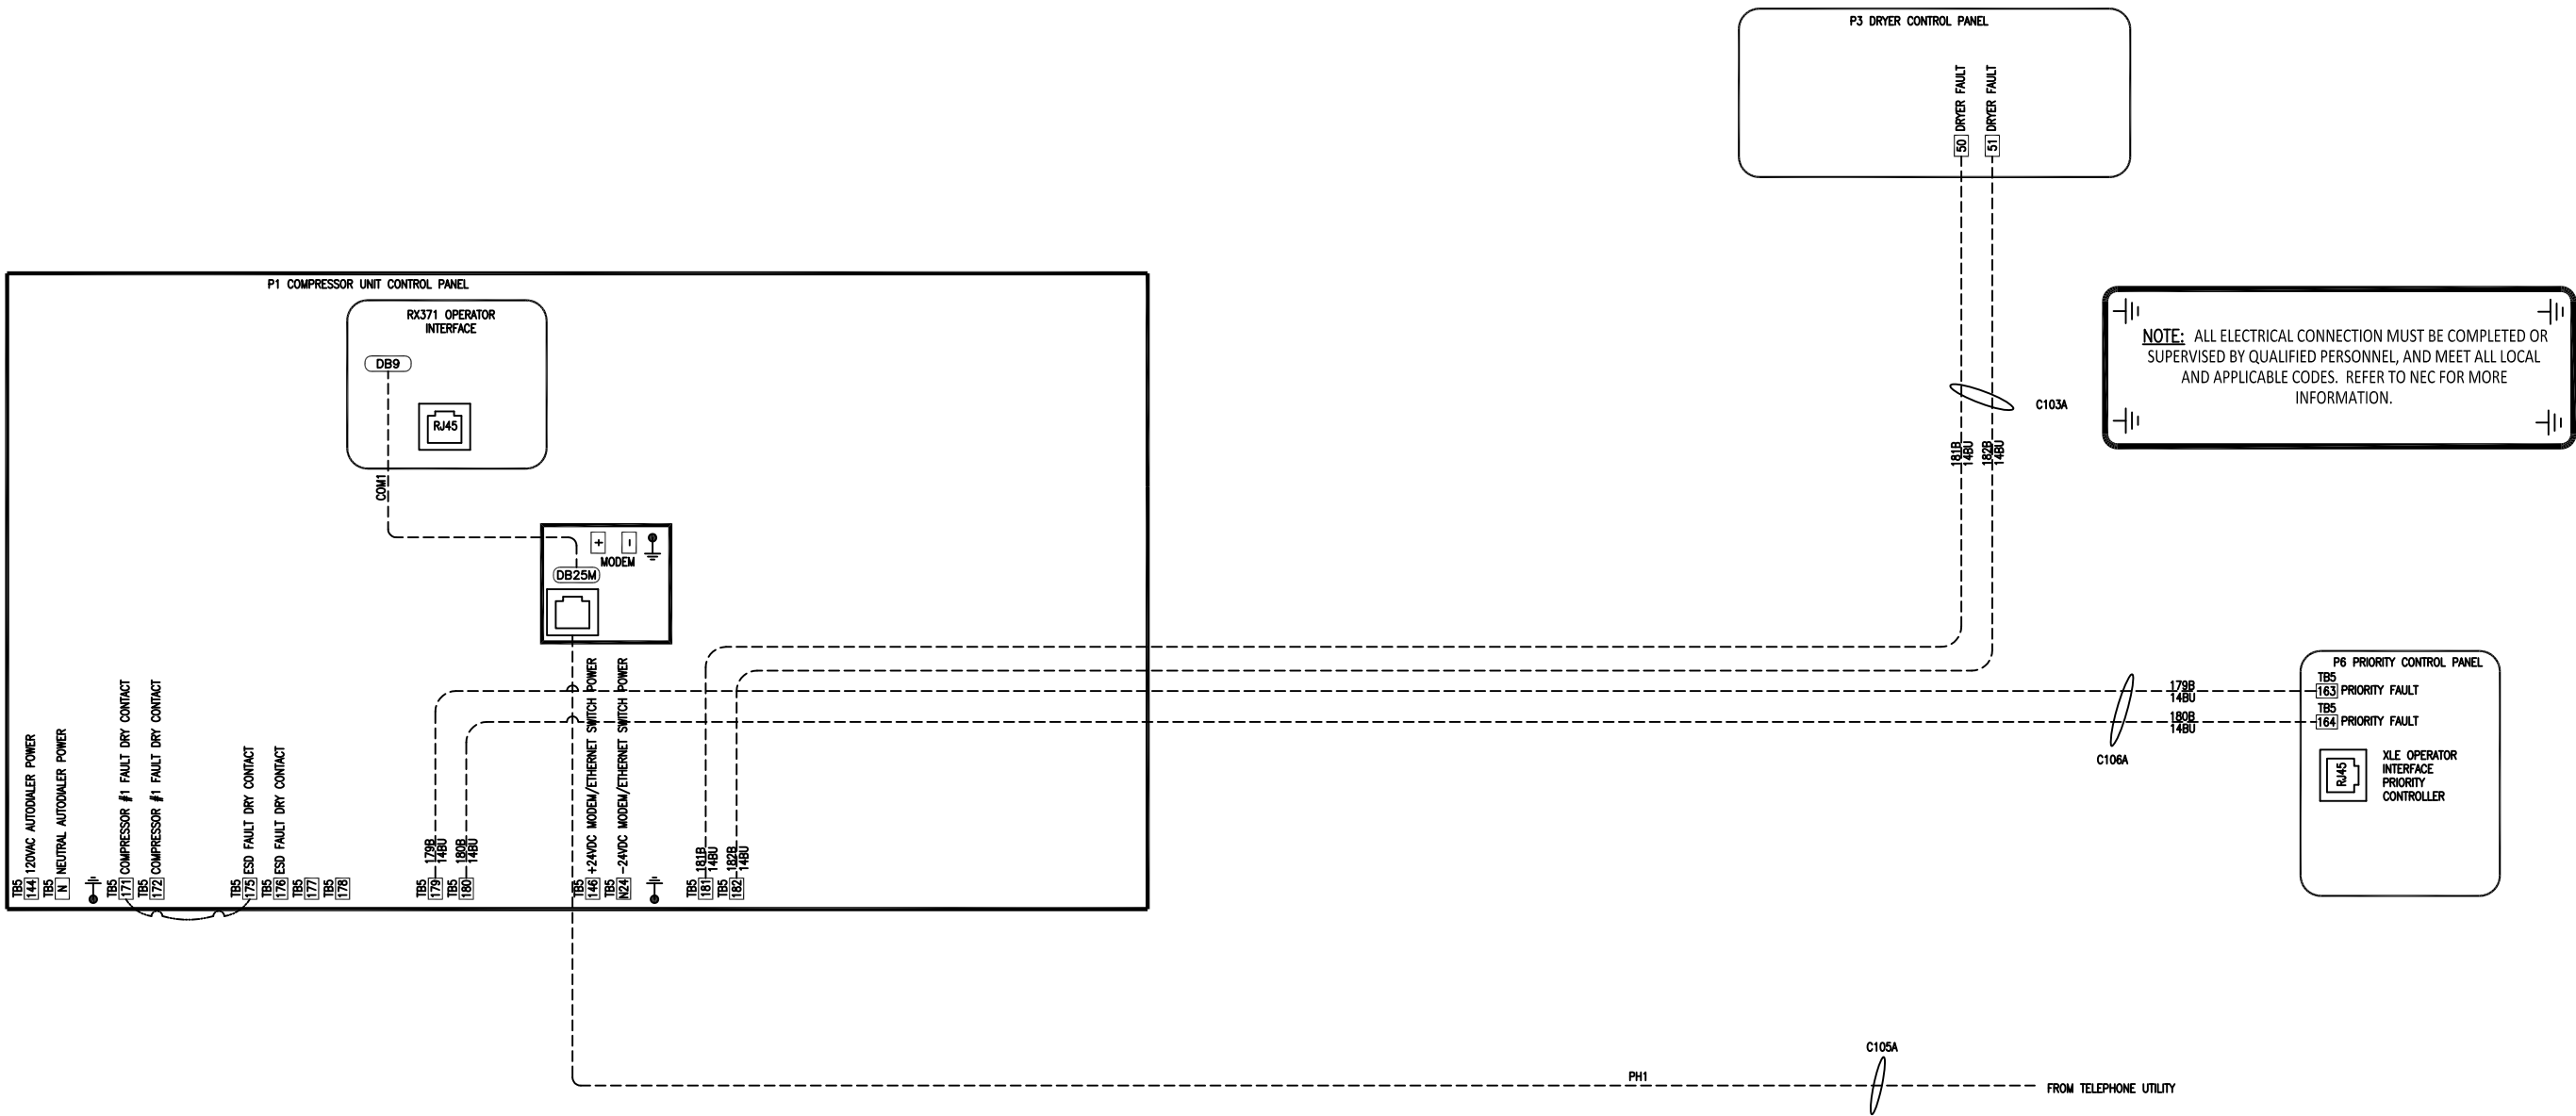


B	9/7/12 PJH	ADD DRYER			
A	4/21/12 PJH	REMOVE WARNING SIGNAL WIRING AND TERMINALS			
REV	DATE/BY	DESCRIPTION	REV	DATE/BY	DESCRIPTION



ANGI ENERGY SYSTEMS
15 PLUMB STREET
MILTON, WI 53563
PH: 608-868-4626
FX: 608-868-2723

THIS DRAWING AND ALL INFORMATION THEREIN IS THE SOLE PROPERTY OF ANGI AND SHOULD NOT BE COPIED, REPRODUCED, OR SUBMITTED TO OTHERS WITHOUT WRITTEN AUTHORIZATION. ALL REPRODUCTIONS ARE SUBJECT TO RETURN ON DEMAND.

 
UNLESS OTHERWISE SPECIFIED


 BREAK SHARP EDGES

ALL DIMENSIONS IN INCHES

FRACTIONAL	±.125
TWO PLACE DECIMAL	±.010
THREE PLACE DECIMAL	±.005
ANGLES	±1°

TITLE SINGLE LINE/CUSTOMER INTERCONNECT DETAILS ARIEL MINI SKID COMPRESSOR				
CUSTOMER Pioneer – Bivens, TX			PROJECT NO. 30974-01	
SHEET 5/7	SCALE NA	DRAWING NO. A80-50-30974		REV. B
DRAWN BY PJH	DATE 2/8/12			

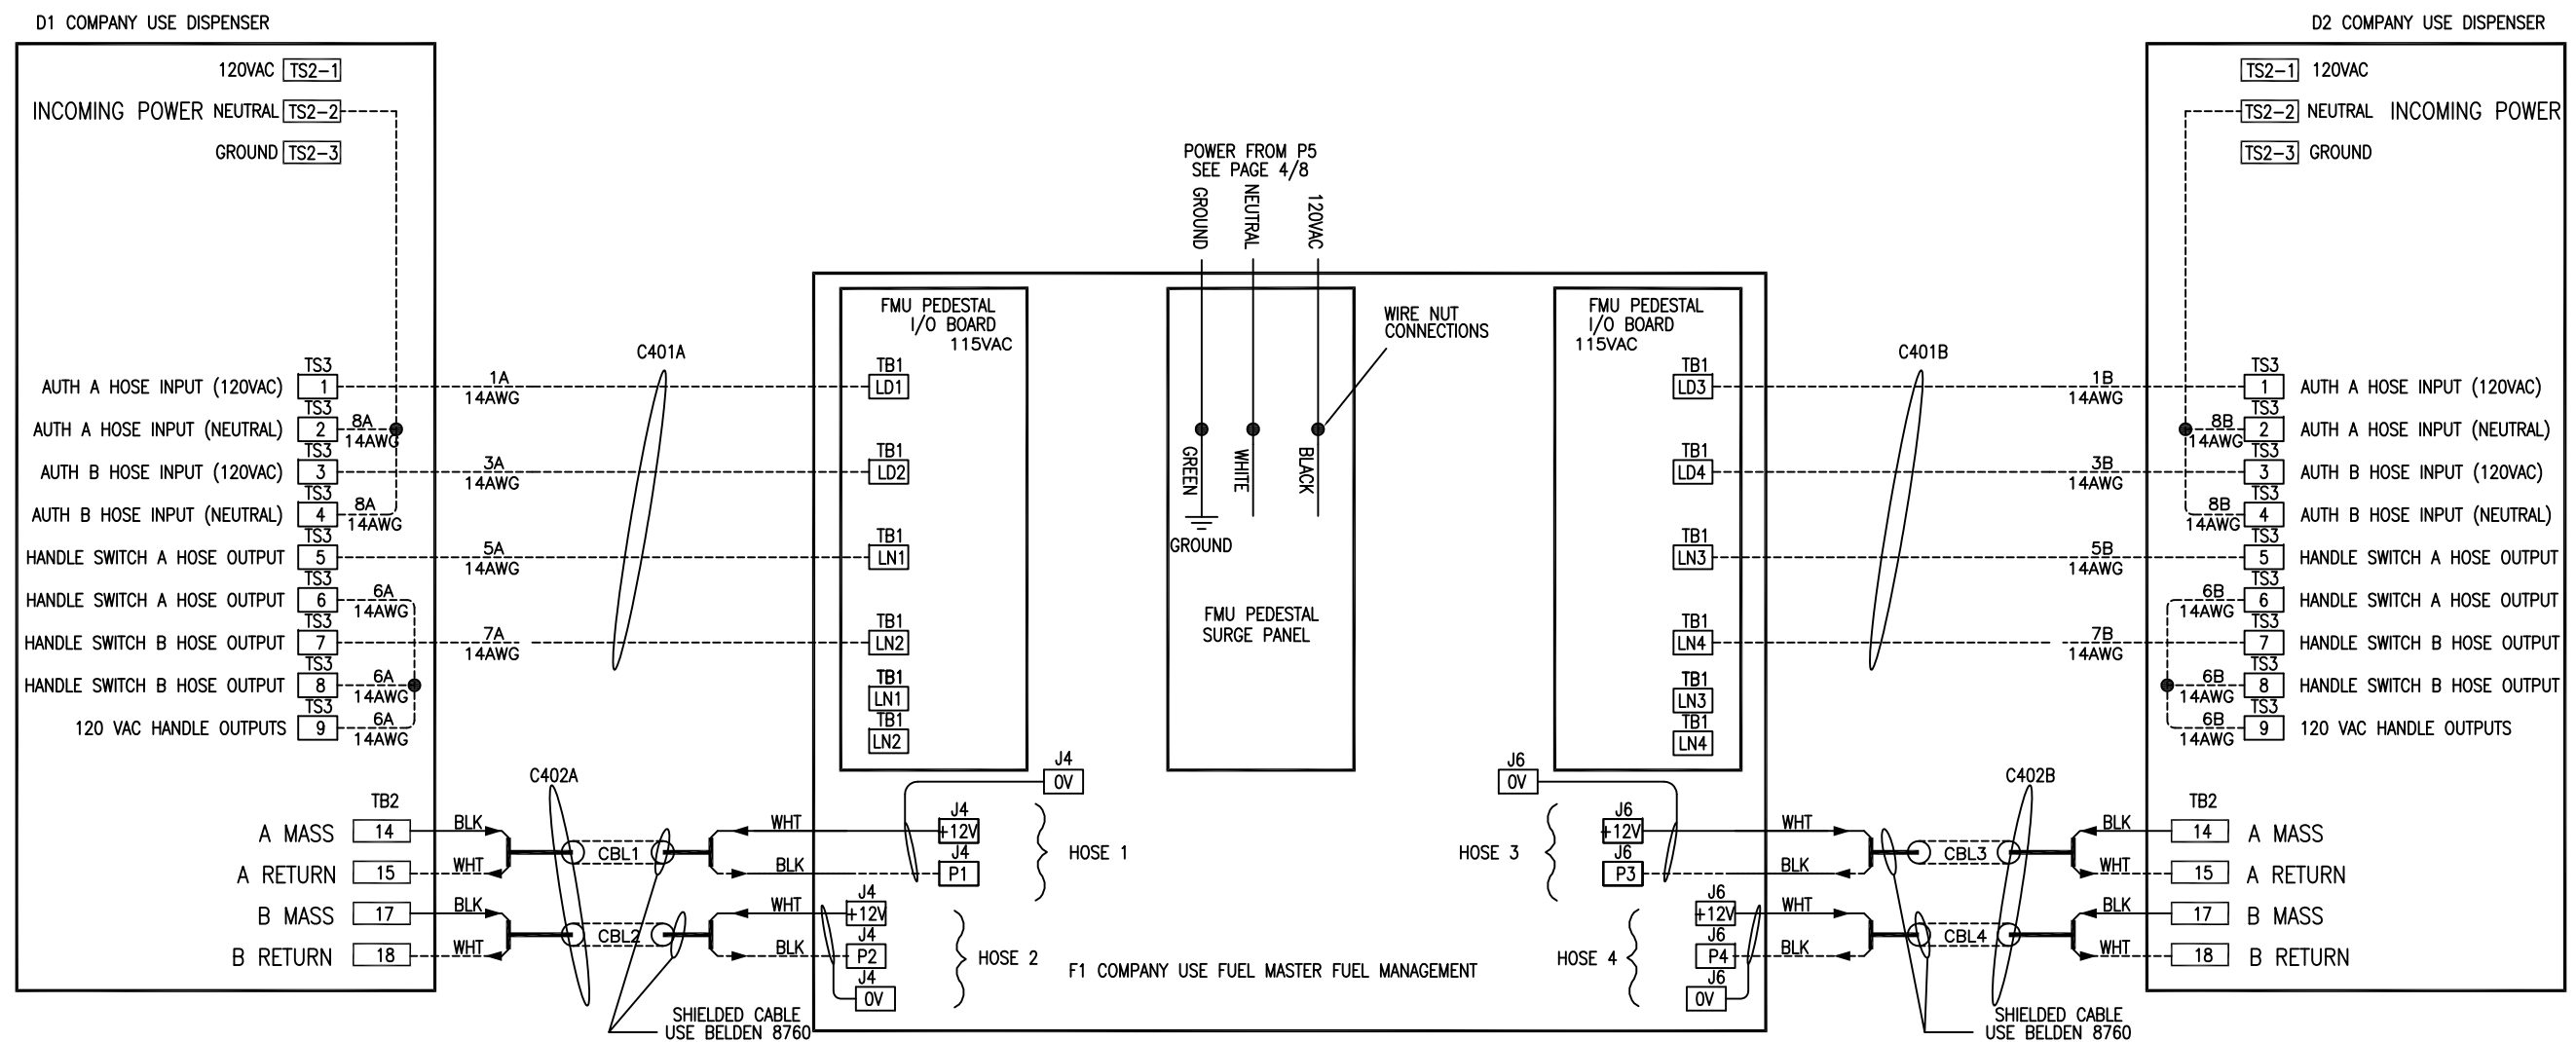

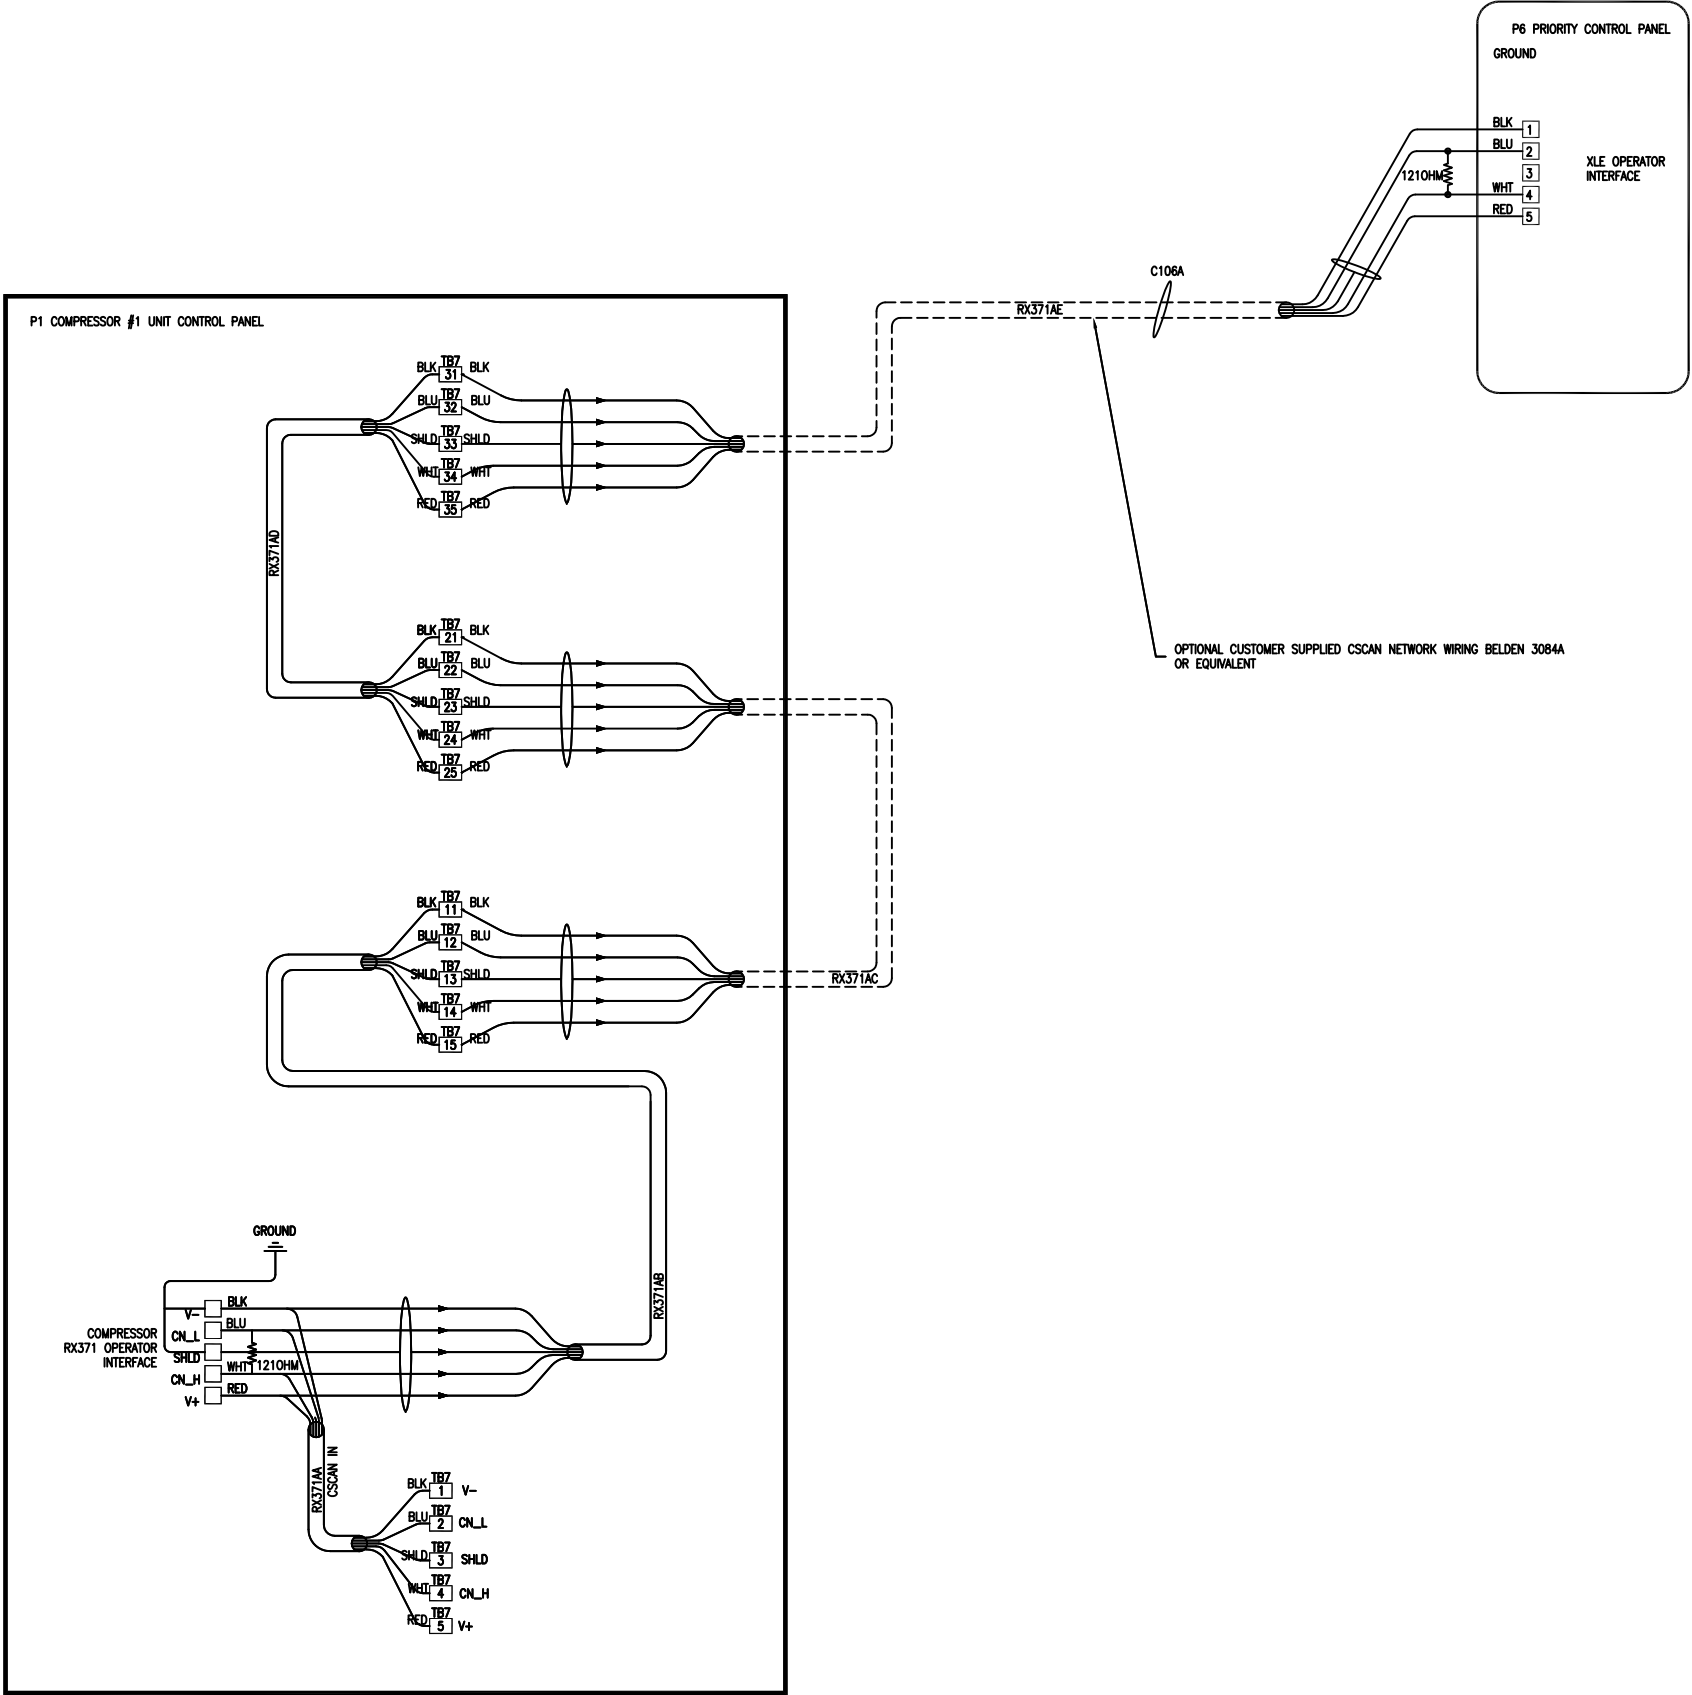


REV	DATE/BY	DESCRIPTION	REV	DATE/BY	DESCRIPTION



ANGI ENERGY SYSTEMS
15 PLUMB STREET
MILTON, WI 53563
PH: 608-868-4626
FX: 608-868-2723

THIS DRAWING AND ALL INFORMATION THEREIN IS THE SOLE PROPERTY OF ANGI AND SHOULD NOT BE COPIED, REPRODUCED, OR SUBMITTED TO OTHERS WITHOUT WRITTEN AUTHORIZATION. ALL REPRODUCTIONS ARE SUBJECT TO RETURN ON DEMAND.

 UNLESS OTHERWISE SPECIFIED



BREAK SHARP EDGES

ALL DIMENSIONS IN INCHES

FRACTIONAL	±.125
TWO PLACE DECIMAL	±.010
THREE PLACE DECIMAL	±.005
ANGLES	±1°

TITLE				
SINGLE LINE/CUSTOMER INTERCONNECT DETAILS ARIEL MINI SKID COMPRESSOR				
CUSTOMER		Pioneer – Bivens, TX		PROJECT NO. 30974-01
SHEET	7/7	SCALE	NA	DRAWING NO. A80-50-30974
DRAWN BY	PJH	DATE	2/8/12	REV. B