


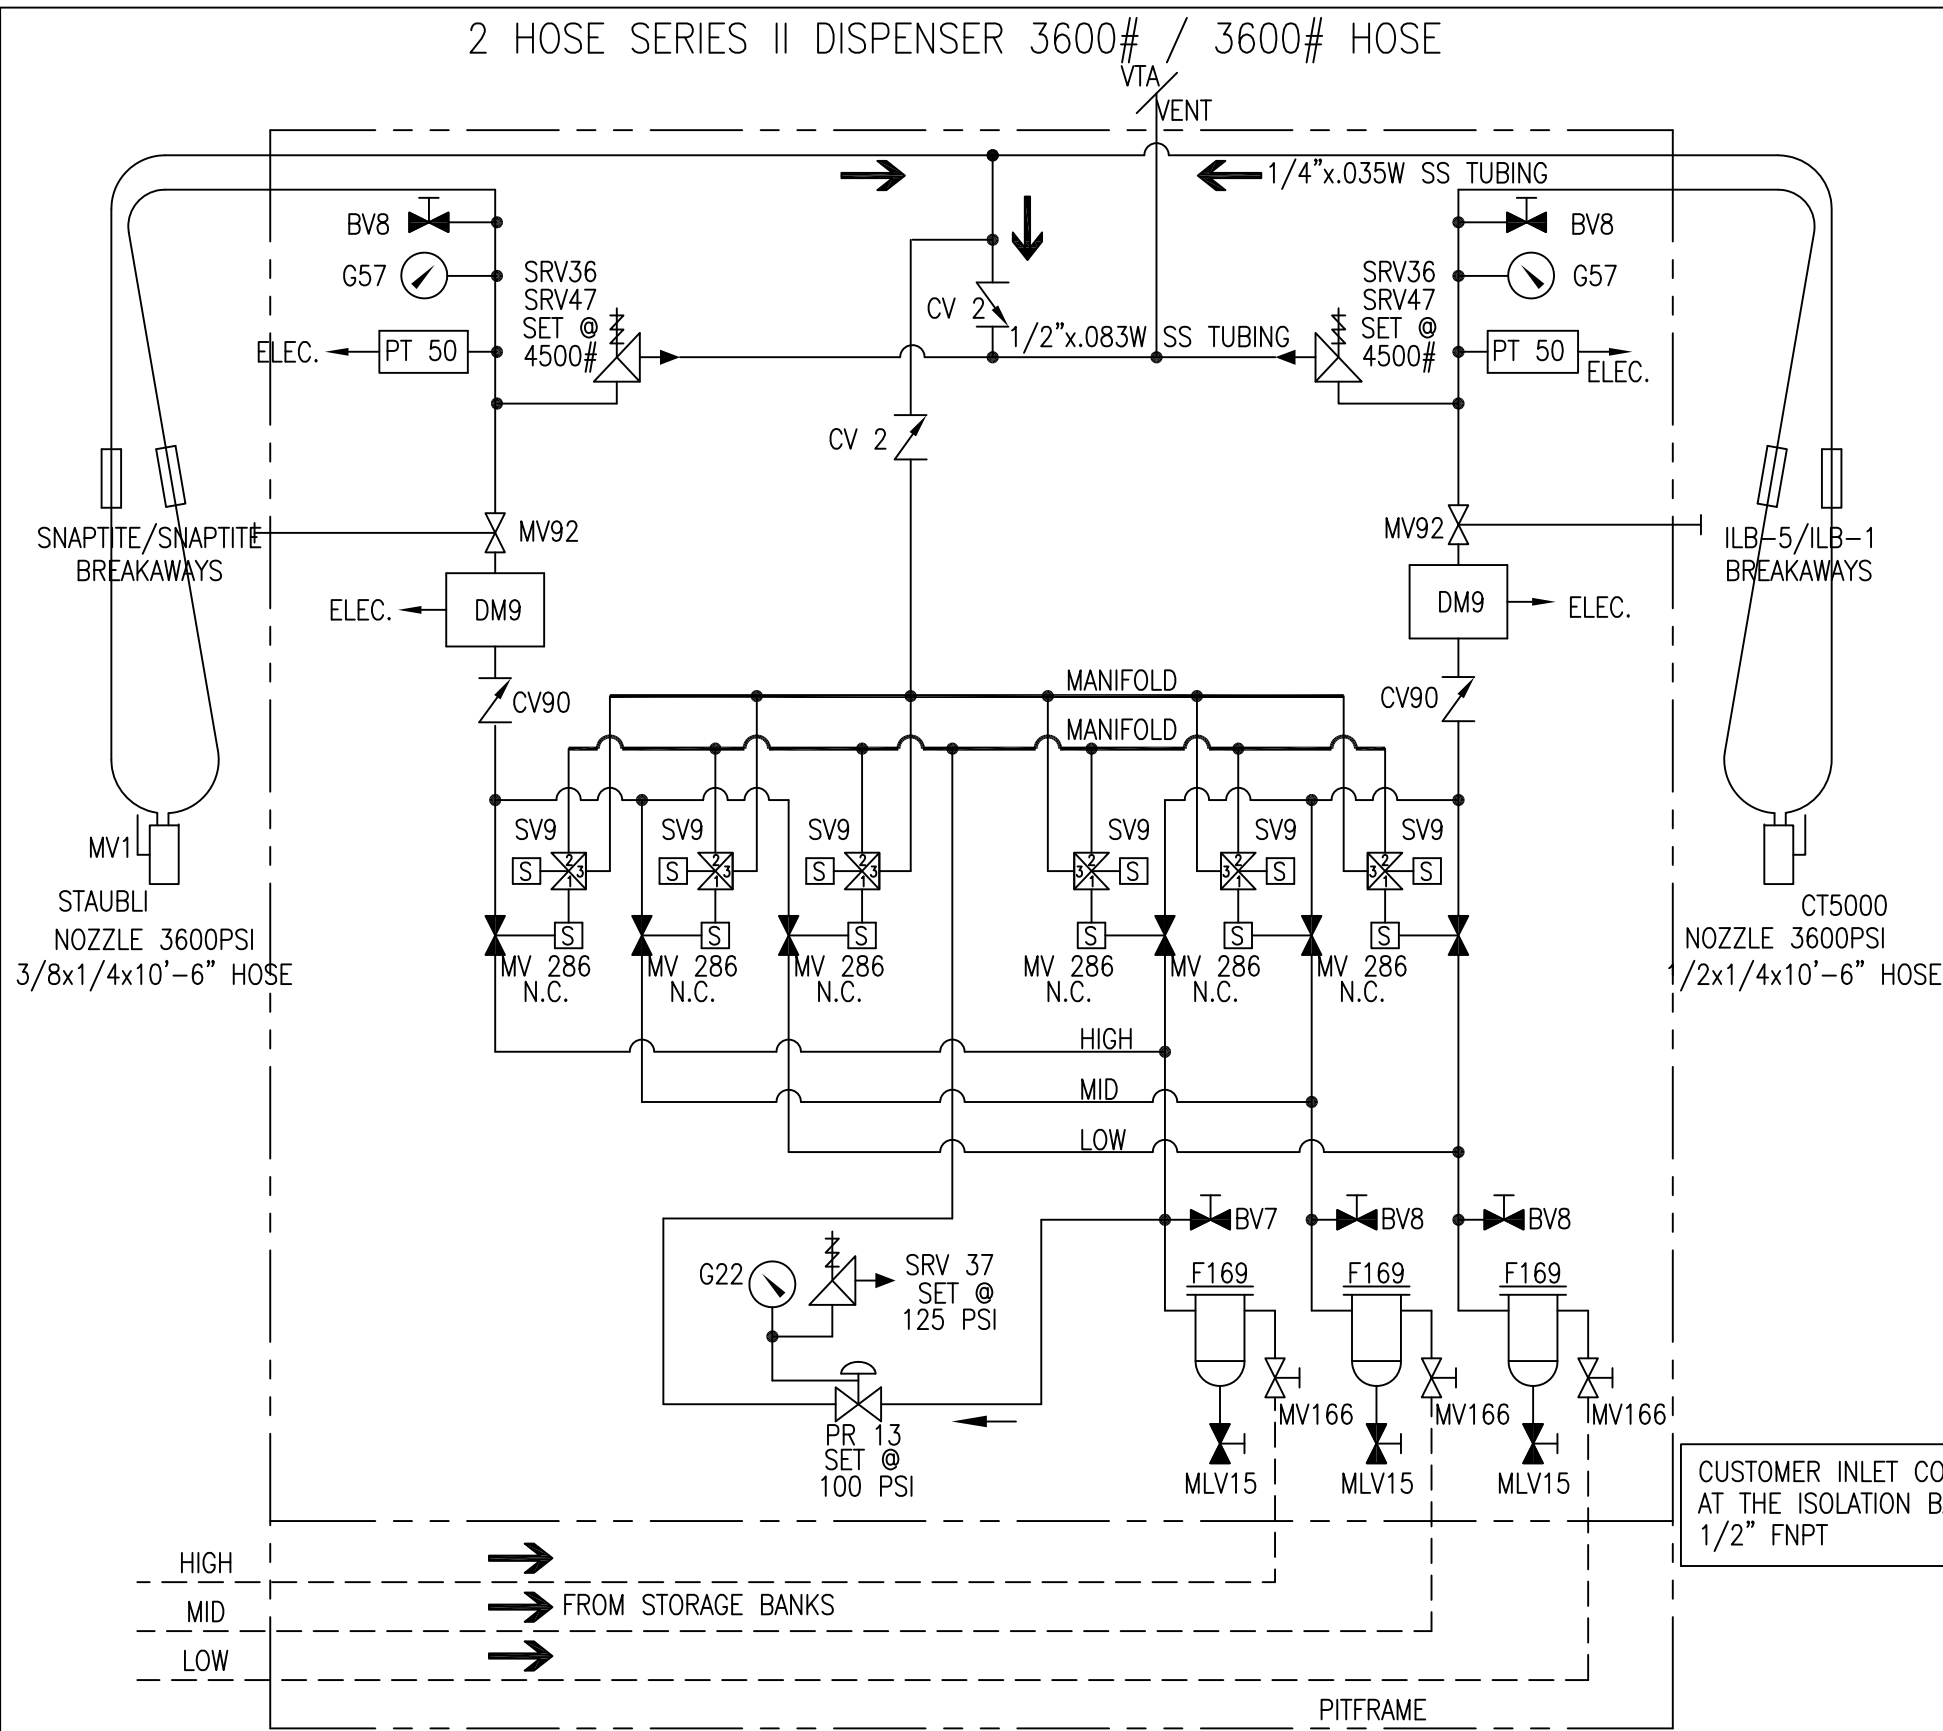

DESIGNATOR	PART NUMBER	DESCRIPTION
BV 7	330-07281	VALVE-PURGE 1/4 FNPT 6000#
BV 8	330-07312	VALVE-PURGE 7/16-20MSAE 6000# SS
CV 2	336-02419	VALVE-CHECK HOKE 1/4ML 6000# SS 2# CRACKING SPRING
CV 90	336-07319	VALVE-CHECK HOKE 1/2 FSAE (3/4-16FSAE/SAE-8) 6000#
DM 9	902-07240	METER-D CNG50 W/10' 4WIRE CABLE W/NO RFT, NO DISPLAY
F 169	772-07299	FILTER-FINITE SAE-8 JS2B GR4 COALESCING ELEMENT 5500#
G 22	741-07240	GAUGE-PRES 200#/B BM PM GF WIKA
G 57	741-07289	GAUGE-PRES 10,000#/B BM PM GF WIKA
MLV 15	330-07385	VALVE-NEEDLE 1/4 FNPT 6000# CS
MV 1	330-02488	VALVE-BALL WHITEY 1/4 6000# 3WAY 83SERIES
MV 92	334-07294	VALVE-BALL SVF 1/2 6000# W/LOCKING HANDLE (H766)
MV 166	334-07362	VALVE-BALL SVF 1/2 6000# W/LOCKING HANDLE (HBVE)
MV 286	334-07496	VALVE/ACT-ASSY SVF SAE-8 F.P. 6000# SS W/A2S-35-12-V-NC
PR 13	500-01674	REGULATOR-MECO 150#
PT 50	410-07282	TRANSDUCER-PRESSURE AST 0-6000# UL CL1 DIV1&2
SRV 36	330-02483	VALVE-RELIEF NURPO R3A 1/4MLxFML
SRV 37	331-04522	VALVE-RELIEF CIRCLE SEAL 125# 1/4
SRV 47	652-01845	SPRING-NUPRO RED 4000-5000#
SV 9	330-07243	VALVE-SOL 3WY 1/4 150# 120V NC BRS UL
--	700-07259	BREAKAWAY-INLINE SNAPTITE NON-RELIEVING (SUPPLY)
--	700-07260	BREAKAWAY-INLINE SNAPTITE RELEVING (VENT)
--	700-06460	NOZZLE-3600# STAUBLI CMV08 YELLOW
--	820-07251	HOSE WHIP ASSY-1/4x24" FACESEAL (137-05016)
--	820-07252	HOSE WHIP ASSY-3/8x24" FACESEAL (137-07230)
--	820-07313	HOSE ASSY-3/8x1/4x7'-6" FACESEAL (137-05469)
--	700-07289	BREAKAWAY-INLINE OPW ILB-5
--	820-07306	HOSE ASSY-1/2x1/4x7'-6" FACESEAL (137-07236)
--	820-07333	HOSE WHIP ASSY-1/4x25" FACESEAL (137-05016)
--	820-07285	HOSE WHIP ASSY-1/2x24" FACESEAL (137-06688)
--	700-03945	NOZZLE-3600# OPW CT5000
--	700-07488	BREAKAWAY-INLINE OPW ILB-1

LEGEND	
BV	=BLEED (PURGE) VALVE
CV	=CHECK VALVE
DM	=MASS FLOW D-METER
F	=FILTER
G	=PRESSURE GAUGE
MV	=MANUAL BALL VALVE
PR	=PRESSURE REGULATOR
PT	=PRESSURE TRANSDUCER
SRV	=SAFETY RELIEF VALVE
SV	=SOLENOID VALVE
VTA	=VENT TO ATMOSPHERE

FOR ELECTRICAL SCHEMATIC SEE "E45-00-008"

DISPENSER 1 OF 1 - REF A05-23-30974 FOR DISPENSER 2


REV	DATE/BY	DESCRIPTION	REV	DATE/BY	DESCRIPTION
B	6/14/12 HMR	UPDATED 1-HOSE TO CT5000 & 1/2x1/4 PER CUSTOMER REQUEST, SEE ECN#120614-001			
A	5/3/12 HMR	UPDATED GAUGE TO 10,000#			

ANGI ENERGY SYSTEMS

ANGI ENERGY SYSTEMS
15 PLUMB STREET
MILTON, WI 53563
PH: 608-868-4626
FX: 608-868-2723

THIS DRAWING AND ALL INFORMATION THEREIN IS THE SOLE PROPERTY OF ANGI AND SHOULD NOT BE COPIED, REPRODUCED, OR SUBMITTED TO OTHERS WITHOUT WRITTEN AUTHORIZATION. ALL REPRODUCTIONS ARE SUBJECT TO RETURN ON DEMAND.

UNLESS OTHERWISE SPECIFIED		TITLE			
BREAK SHARP EDGES		2 HOSE, 2 METER, SERIES II W/ACTUATED BALL VALVES			
ALL DIMENSIONS IN INCHES		3600 / 3600# HOSES, DISPENSER P & ID			
FRACTIONAL ±.125		CUSTOMER PIONEER NATURAL GAS - BIVENS		PROJECT NO. 30974	
TWO PLACE DECIMAL ±.010		SHEET 1/1	SCALE NTS	DRAWING NO. A05-21-30974	REV. B
THREE PLACE DECIMAL ±.005		DRAWN BY HMR	DATE 1/30/12		
ANGLES ±1°					


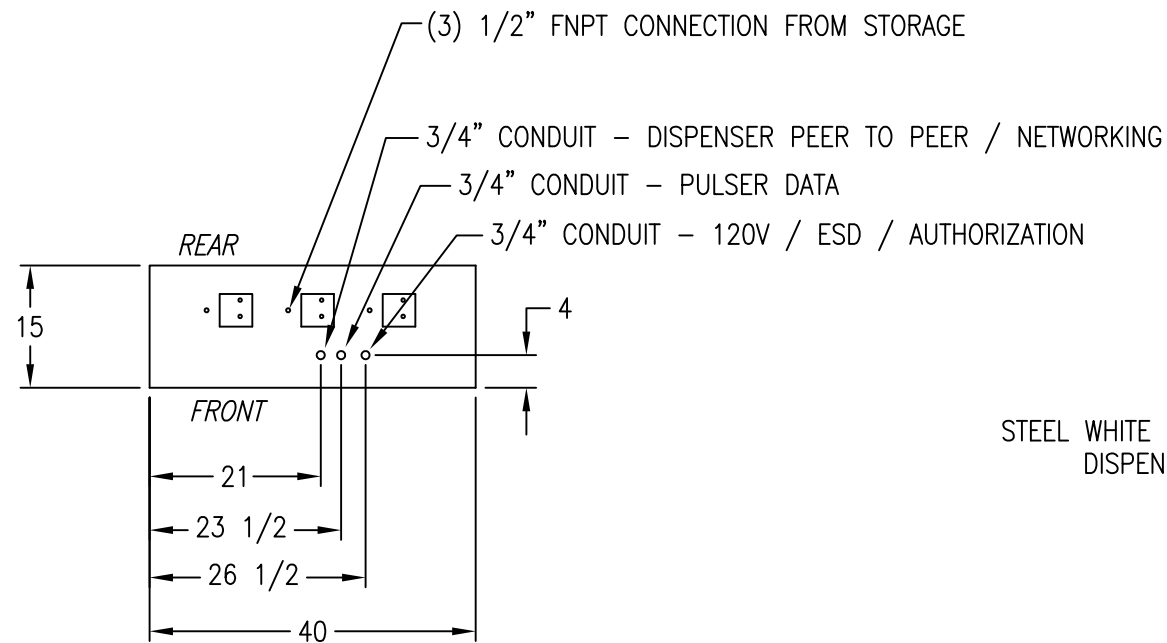


SECTION A-A



TOP VIEW CONNECTION DETAIL

THIS IS THE LOCATION OF TUBING PENETRATIONS
WHEN THE FINITE FILTERS ARE IN DISPENSER

*THE FRONT SIDE OF THE DISPENSER
IS THE SIDE THAT HOUSES THE ELECTRICAL BOX IN THE
LOWER PORTION OF THE ENCLOSURE.

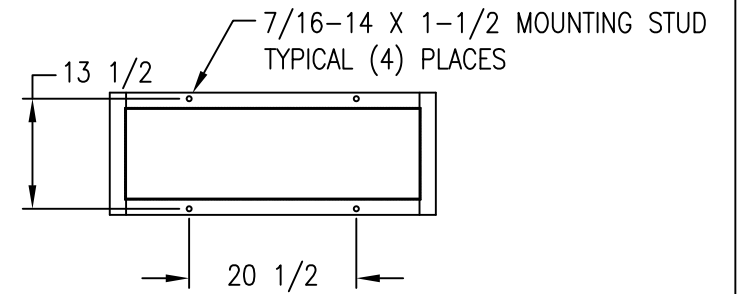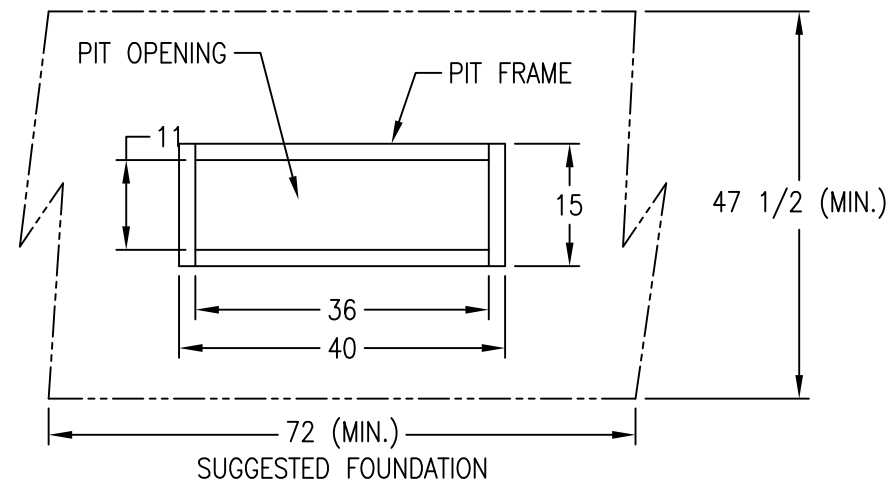

PIT FRAME / CABINET MOUNTING DETAIL

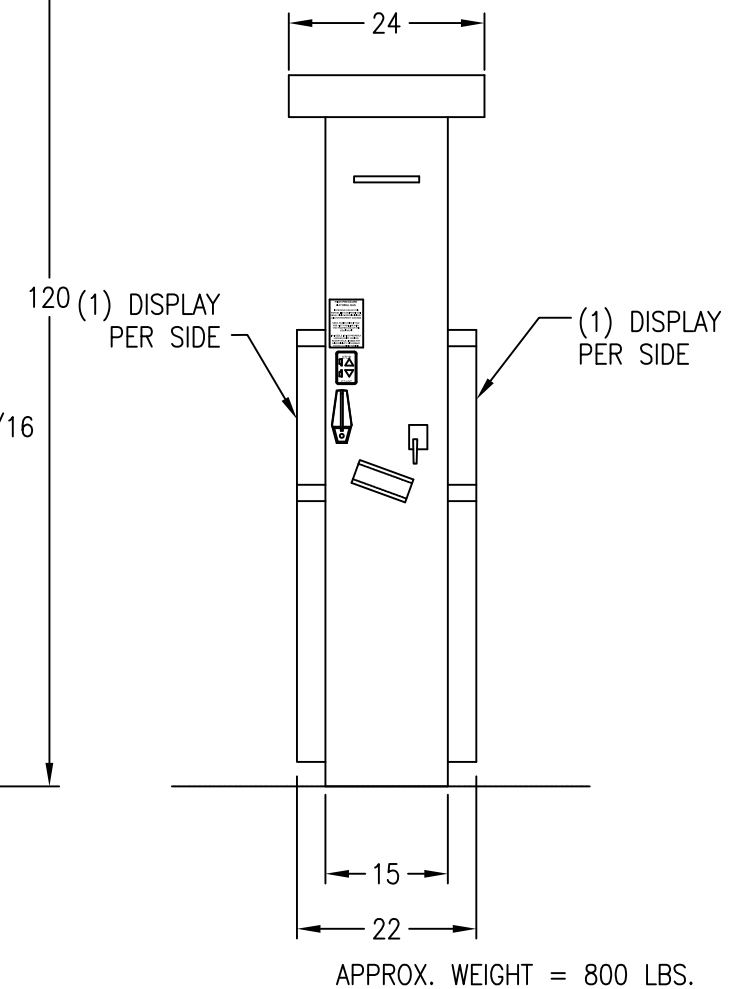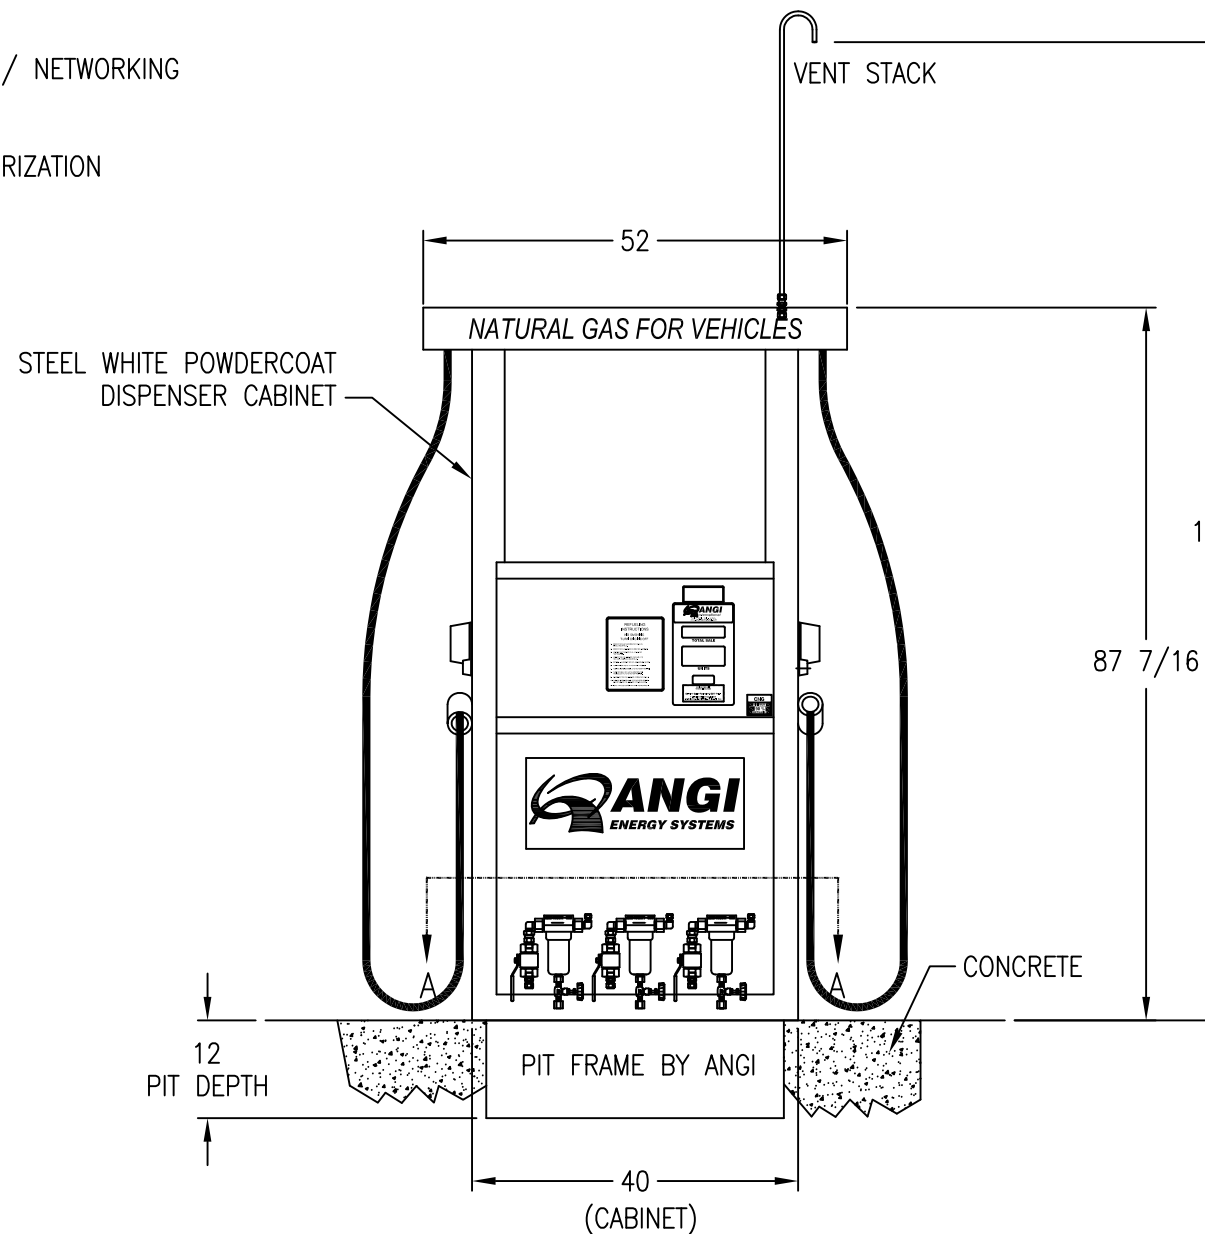

APPROX. WEIGHT = 800 LBS.

REV	DATE/BY	DESCRIPTION	REV	DATE/BY	DESCRIPTION
*					

ANGI ENERGY SYSTEMS

ANGI ENERGY SYSTEMS
15 PLUMB STREET
MILTON, WI 53563
PH: 608-868-4626
FX: 608-868-2723

THIS DRAWING AND ALL INFORMATION THEREIN IS THE SOLE PROPERTY OF ANGI AND SHOULD NOT BE COPIED, REPRODUCED, OR SUBMITTED TO OTHERS WITHOUT WRITTEN AUTHORIZATION. ALL REPRODUCTIONS ARE SUBJECT TO RETURN ON DEMAND.

UNLESS OTHERWISE SPECIFIED


BREAK SHARP EDGES

ALL DIMENSIONS IN INCHES

FRACTIONAL ±.125
TWO PLACE DECIMAL ±.010
THREE PLACE DECIMAL ±.005
ANGLES ±1°

TITLE					SERIES II DISPENSER – INSTALLATION DIMENSIONS 2–HOSE, 3–BANK SEQUENCING						
CUSTOMER				PIONEER NATURAL GAS – BIVENS			PROJECT NO.		30974		
SHEET		1/1		SCALE		1:24		DRAWING NO.		REV.	
DRAWN BY		HMR		DATE		1/30/12					
									A05–22–30974		–

2 HOSE SERIES II DISPENSER 3600# / 3600# HOSE

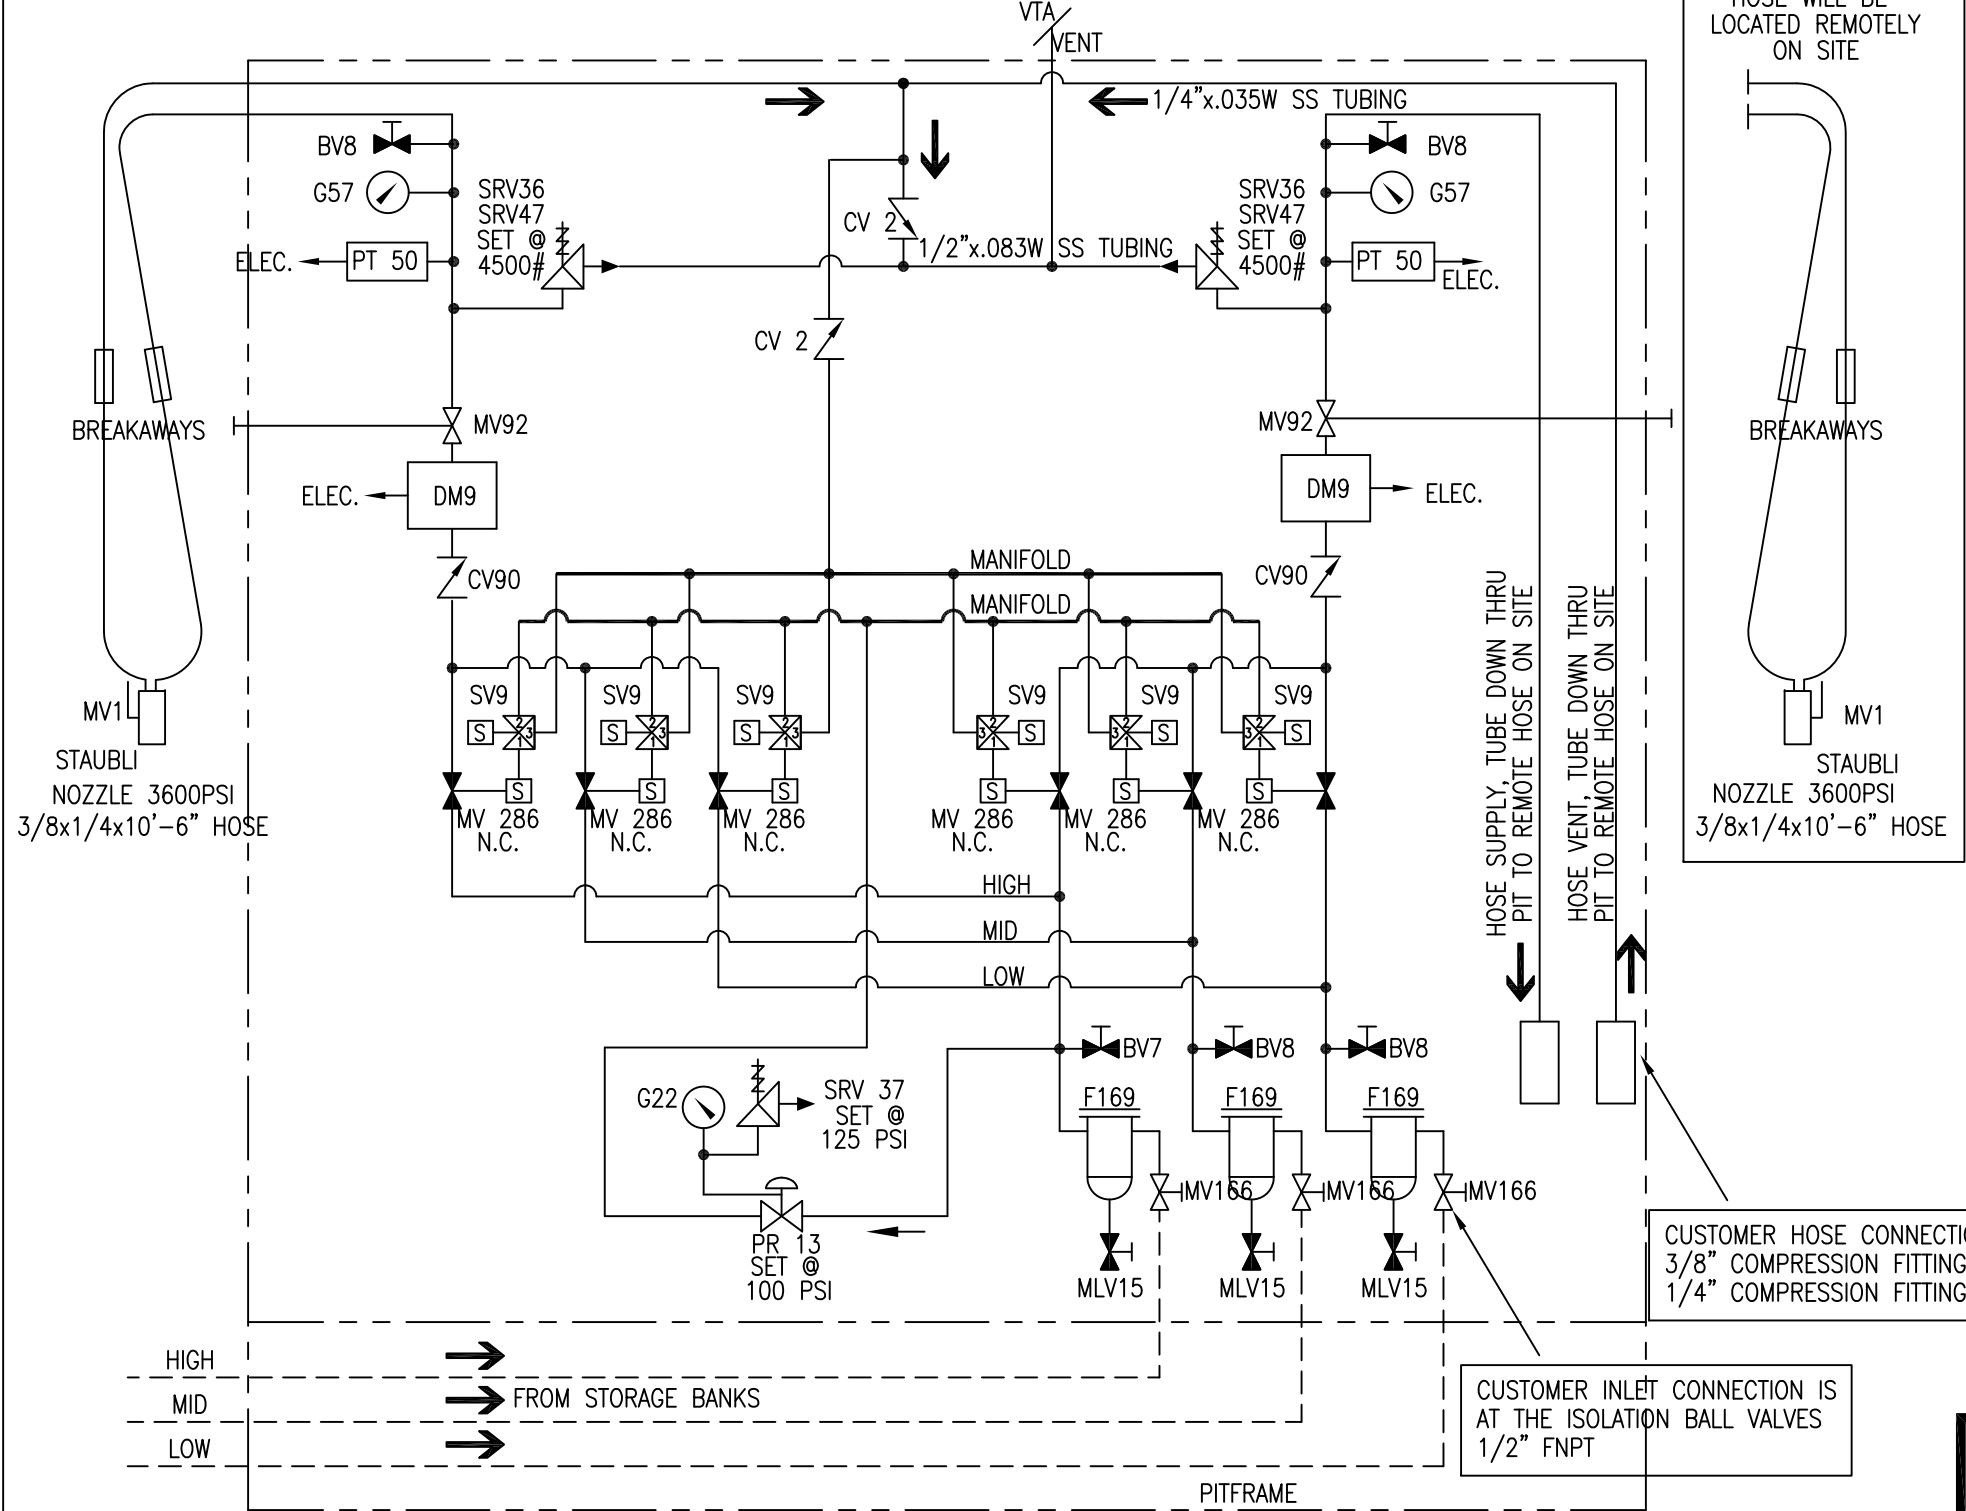

DESIGNATOR	PART NUMBER	DESCRIPTION
BV 7	330-07281	VALVE-PURGE 1/4 FNPT 6000#
BV 8	330-07312	VALVE-PURGE 7/16-20MSAE 6000# SS
CV 2	336-02419	VALVE-CHECK HOKE 1/4ML 6000# SS 2# CRACKING SPRING
CV 90	336-07319	VALVE-CHECK HOKE 1/2 FSAE (3/4-16FSAE/SAE-8) 6000#
DM 9	902-07240	METER-D CNG50 W/10' 4WIRE CABLE W/NO RFT, NO DISPLAY
F 169	772-07299	FILTER-FINITE SAE-8 JS2B GR4 COALESCING ELEMENT 5500#
G 22	741-07240	GAUGE-PRES 200#/B BM PM GF WIKA
G 57	741-07289	GAUGE-PRES 10,000#/B BM PM GF WIKA
MLV 15	330-07385	VALVE-NEEDLE 1/4 FNPT 6000# CS
MV 1	330-02488	VALVE-BALL WHITEY 1/4 6000# 3WAY 83SERIES
MV 92	334-07294	VALVE-BALL SVF 1/2 6000# W/LOCKING HANDLE (H766)
MV 166	334-07362	VALVE-BALL SVF 1/2 6000# W/LOCKING HANDLE (HBVE)
MV 286	334-07496	VALVE/ACT-ASSY SVF SAE-8 F.P. 6000# SS W/A2S-35-12-V-NC
PR 13	500-01674	REGULATOR-MECO 150#
PT 50	410-07282	TRANSDUCER-PRESSURE AST 0-6000# UL CL1 DIV1&2
SRV 36	330-02483	VALVE-RELIEF NURPO R3A 1/4MLxFML
SRV 37	331-04522	VALVE-RELIEF CIRCLE SEAL 125# 1/4
SRV 47	652-01845	SPRING-NUPRO RED 4000-5000#
SV 9	330-07243	VALVE-SOL 3WY 1/4 150# 120V NC BRS UL
--	700-07259	BREAKAWAY-INLINE SNAPTITE NON-RELIEVING (SUPPLY)
--	700-07260	BREAKAWAY-INLINE SNAPTITE RELEVING (VENT)
--	700-06460	NOZZLE-3600# STAUBLI CMV08 YELLOW
--	820-07251	HOSE WHIP ASSY-1/4x24" FACESEAL (137-05016)
--	820-07252	HOSE WHIP ASSY-3/8x24" FACESEAL (137-07230)
--	820-07313	HOSE ASSY-3/8x1/4x7'-6" FACESEAL (137-05469)

FOR ELECTRICAL SCHEMATIC SEE
"E45-00-008"

LEGEND	
BV	=BLEED (PURGE) VALVE
CV	=CHECK VALVE
DM	=MASS FLOW D-METER
F	=FILTER
G	=PRESSURE GAUGE
MV	=MANUAL BALL VALVE
PR	=PRESSURE REGULATOR
PT	=PRESSURE TRANSDUCER
SRV	=SAFETY RELIEF VALVE
SV	=SOLENOID VALVE
VTA	=VENT TO ATMOSPHERE

DISPENSER 2 OF 2 - REF A05-21-30974 FOR DISPENSER 1


REV	DATE/BY	DESCRIPTION	REV	DATE/BY	DESCRIPTION
B	11/2/12 HMR	ADDED DETAIL FOR THE REMOTE HOSE PER CUSTOMER REQUEST			
A	7/27/12 HMR	DISPENSER WILL NOT BE UPDATED, KEEP AS ORIGINALLY BUILT,SEE ECN#120614-001A			




ANGI ENERGY SYSTEMS
15 PLUMB STREET
MILTON, WI 53563
PH: 608-868-4626
FX: 608-868-2723

THIS DRAWING AND ALL INFORMATION THEREIN IS THE SOLE PROPERTY OF ANGI AND SHOULD NOT BE COPIED, REPRODUCED, OR SUBMITTED TO OTHERS WITHOUT WRITTEN AUTHORIZATION. ALL REPRODUCTIONS ARE SUBJECT TO RETURN ON DEMAND.

UNLESS OTHERWISE SPECIFIED		TITLE			
BREAK SHARP EDGES		2 HOSE, 2 METER, SERIES II W/ACTUATED BALL VALVES 3600 / 3600# HOSES, DISPENSER P & ID			
FRACTIONAL		CUSTOMER		PROJECT NO.	
TWO PLACE DECIMAL		PIONEER NATURAL GAS - BIVENS		30974	
THREE PLACE DECIMAL		SHEET	1/1	SCALE	NTS
ANGLES		DRAWN BY	HMR	DATE	7/27/12
		DRAWING NO.		REV.	
		A05-23-30974		B	

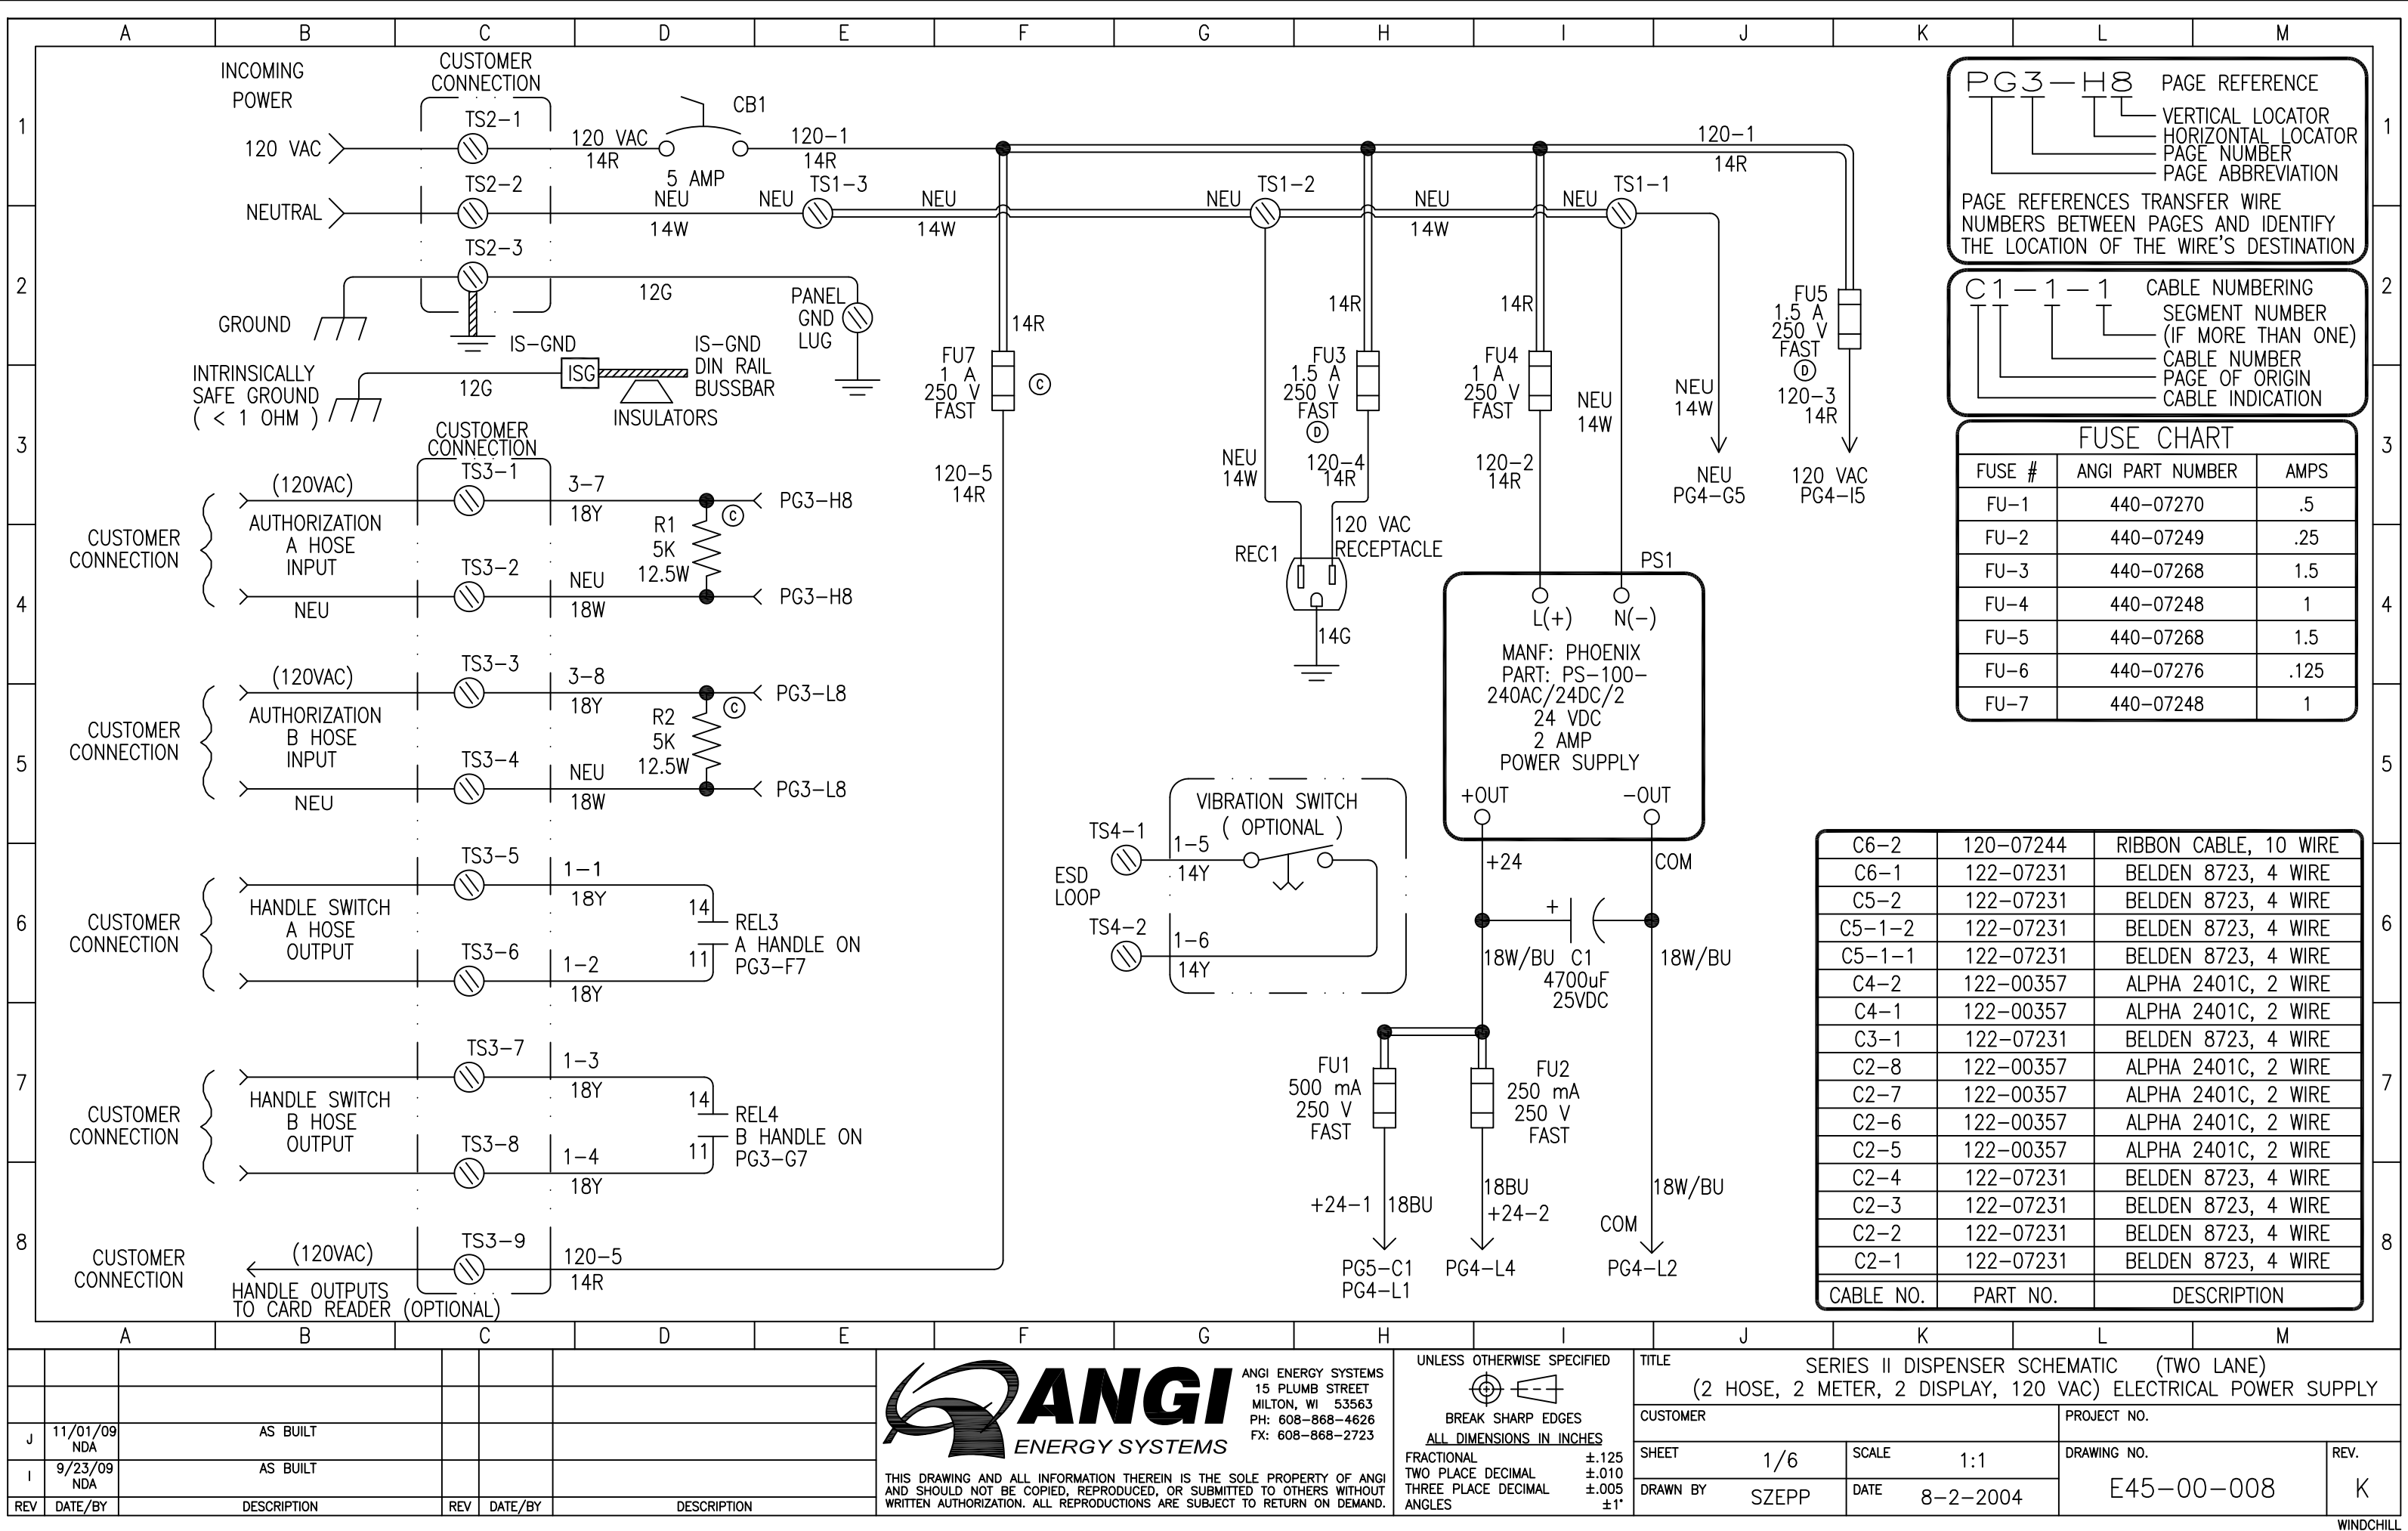

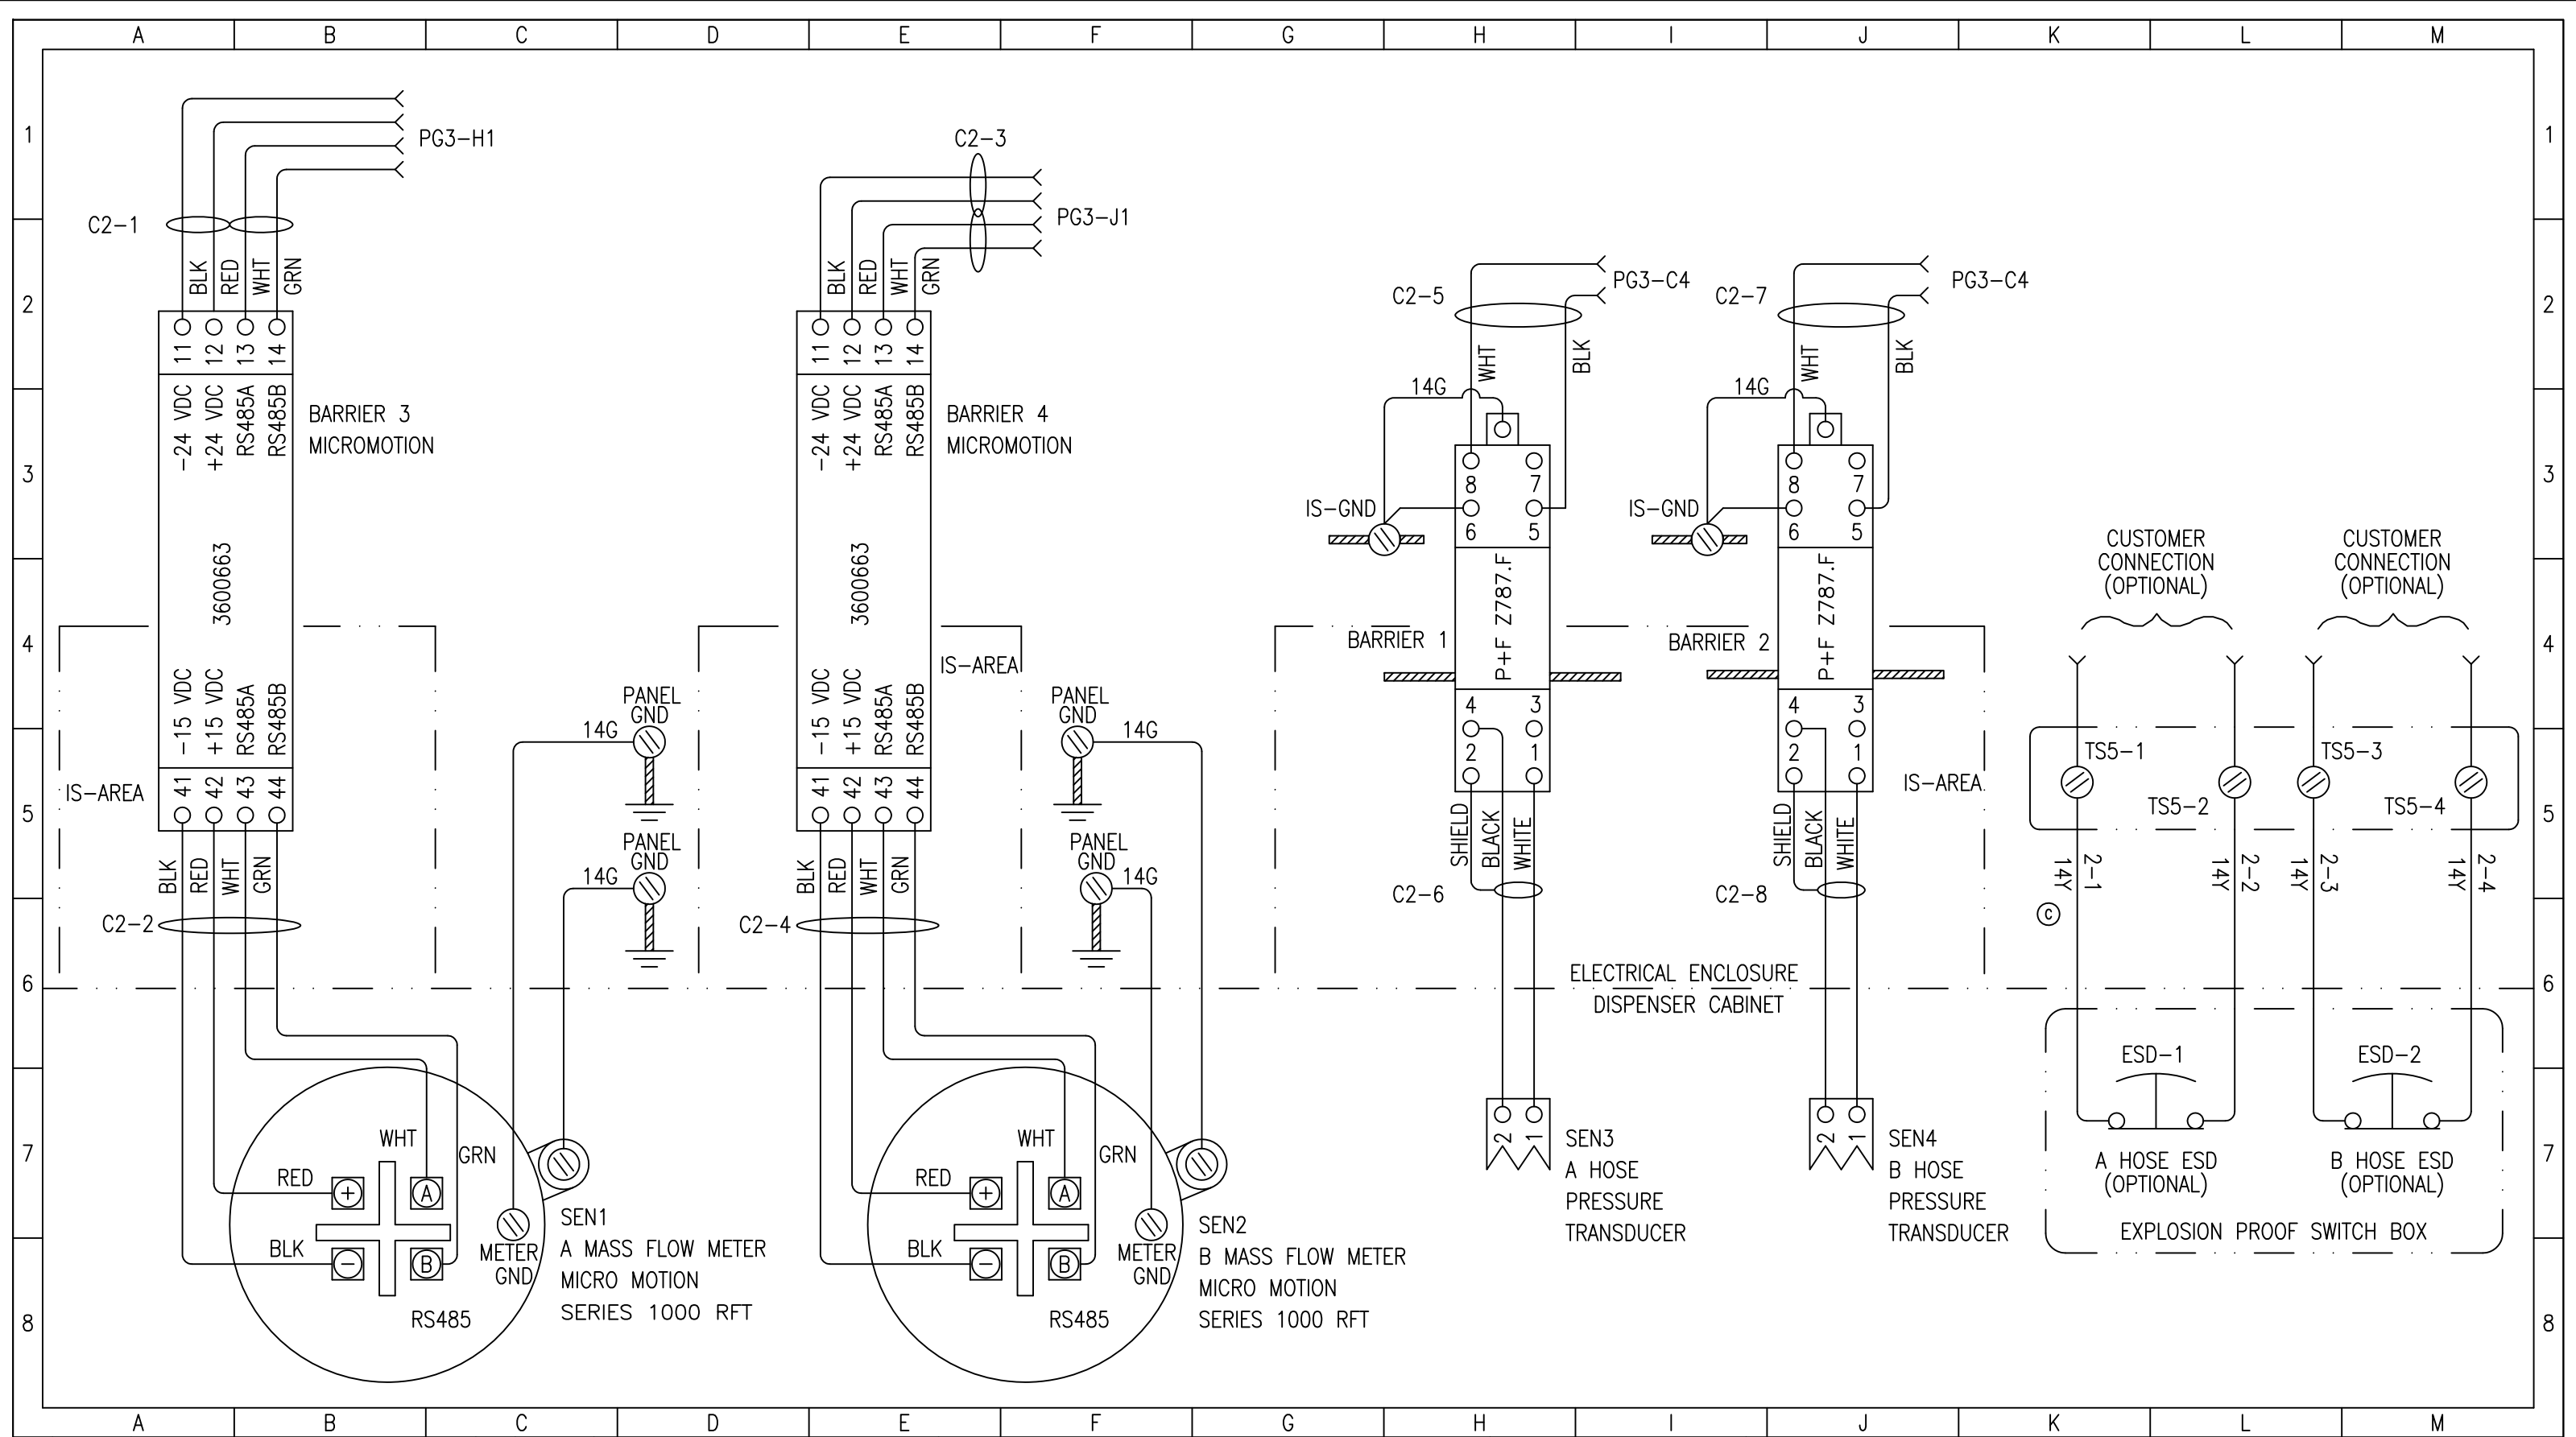


REV	DATE/BY	DESCRIPTION	REV	DATE/BY	DESCRIPTION
I	9/23/09 NDA	AS BUILT			



ANGI ENERGY SYSTEMS
15 PLUMB STREET
MILTON, WI 53563
PH: 608-868-4626
FX: 608-868-2723

THIS DRAWING AND ALL INFORMATION THEREIN IS THE SOLE PROPERTY OF ANGI AND SHOULD NOT BE COPIED, REPRODUCED, OR SUBMITTED TO OTHERS WITHOUT WRITTEN AUTHORIZATION. ALL REPRODUCTIONS ARE SUBJECT TO RETURN ON DEMAND.

 UNLESS OTHERWISE SPECIFIED




BREAK SHARP EDGES
ALL DIMENSIONS IN INCHES

FRACTIONAL	±.125
TWO PLACE DECIMAL	±.010
THREE PLACE DECIMAL	±.005
ANGLES	±1°

TITLE
SERIES II DISPENSER SCHEMATIC (TWO LANE)
(2 HOSE, 2 METER, 2 DISPLAY, 120 VAC) ELECTRICAL POWER SUPPLY

CUSTOMER		PROJECT NO.	
SHEET 2/6	SCALE 1:1	DRAWING NO. E45-00-008	REV. K
DRAWN BY SZEPP	DATE 8-2-2004		

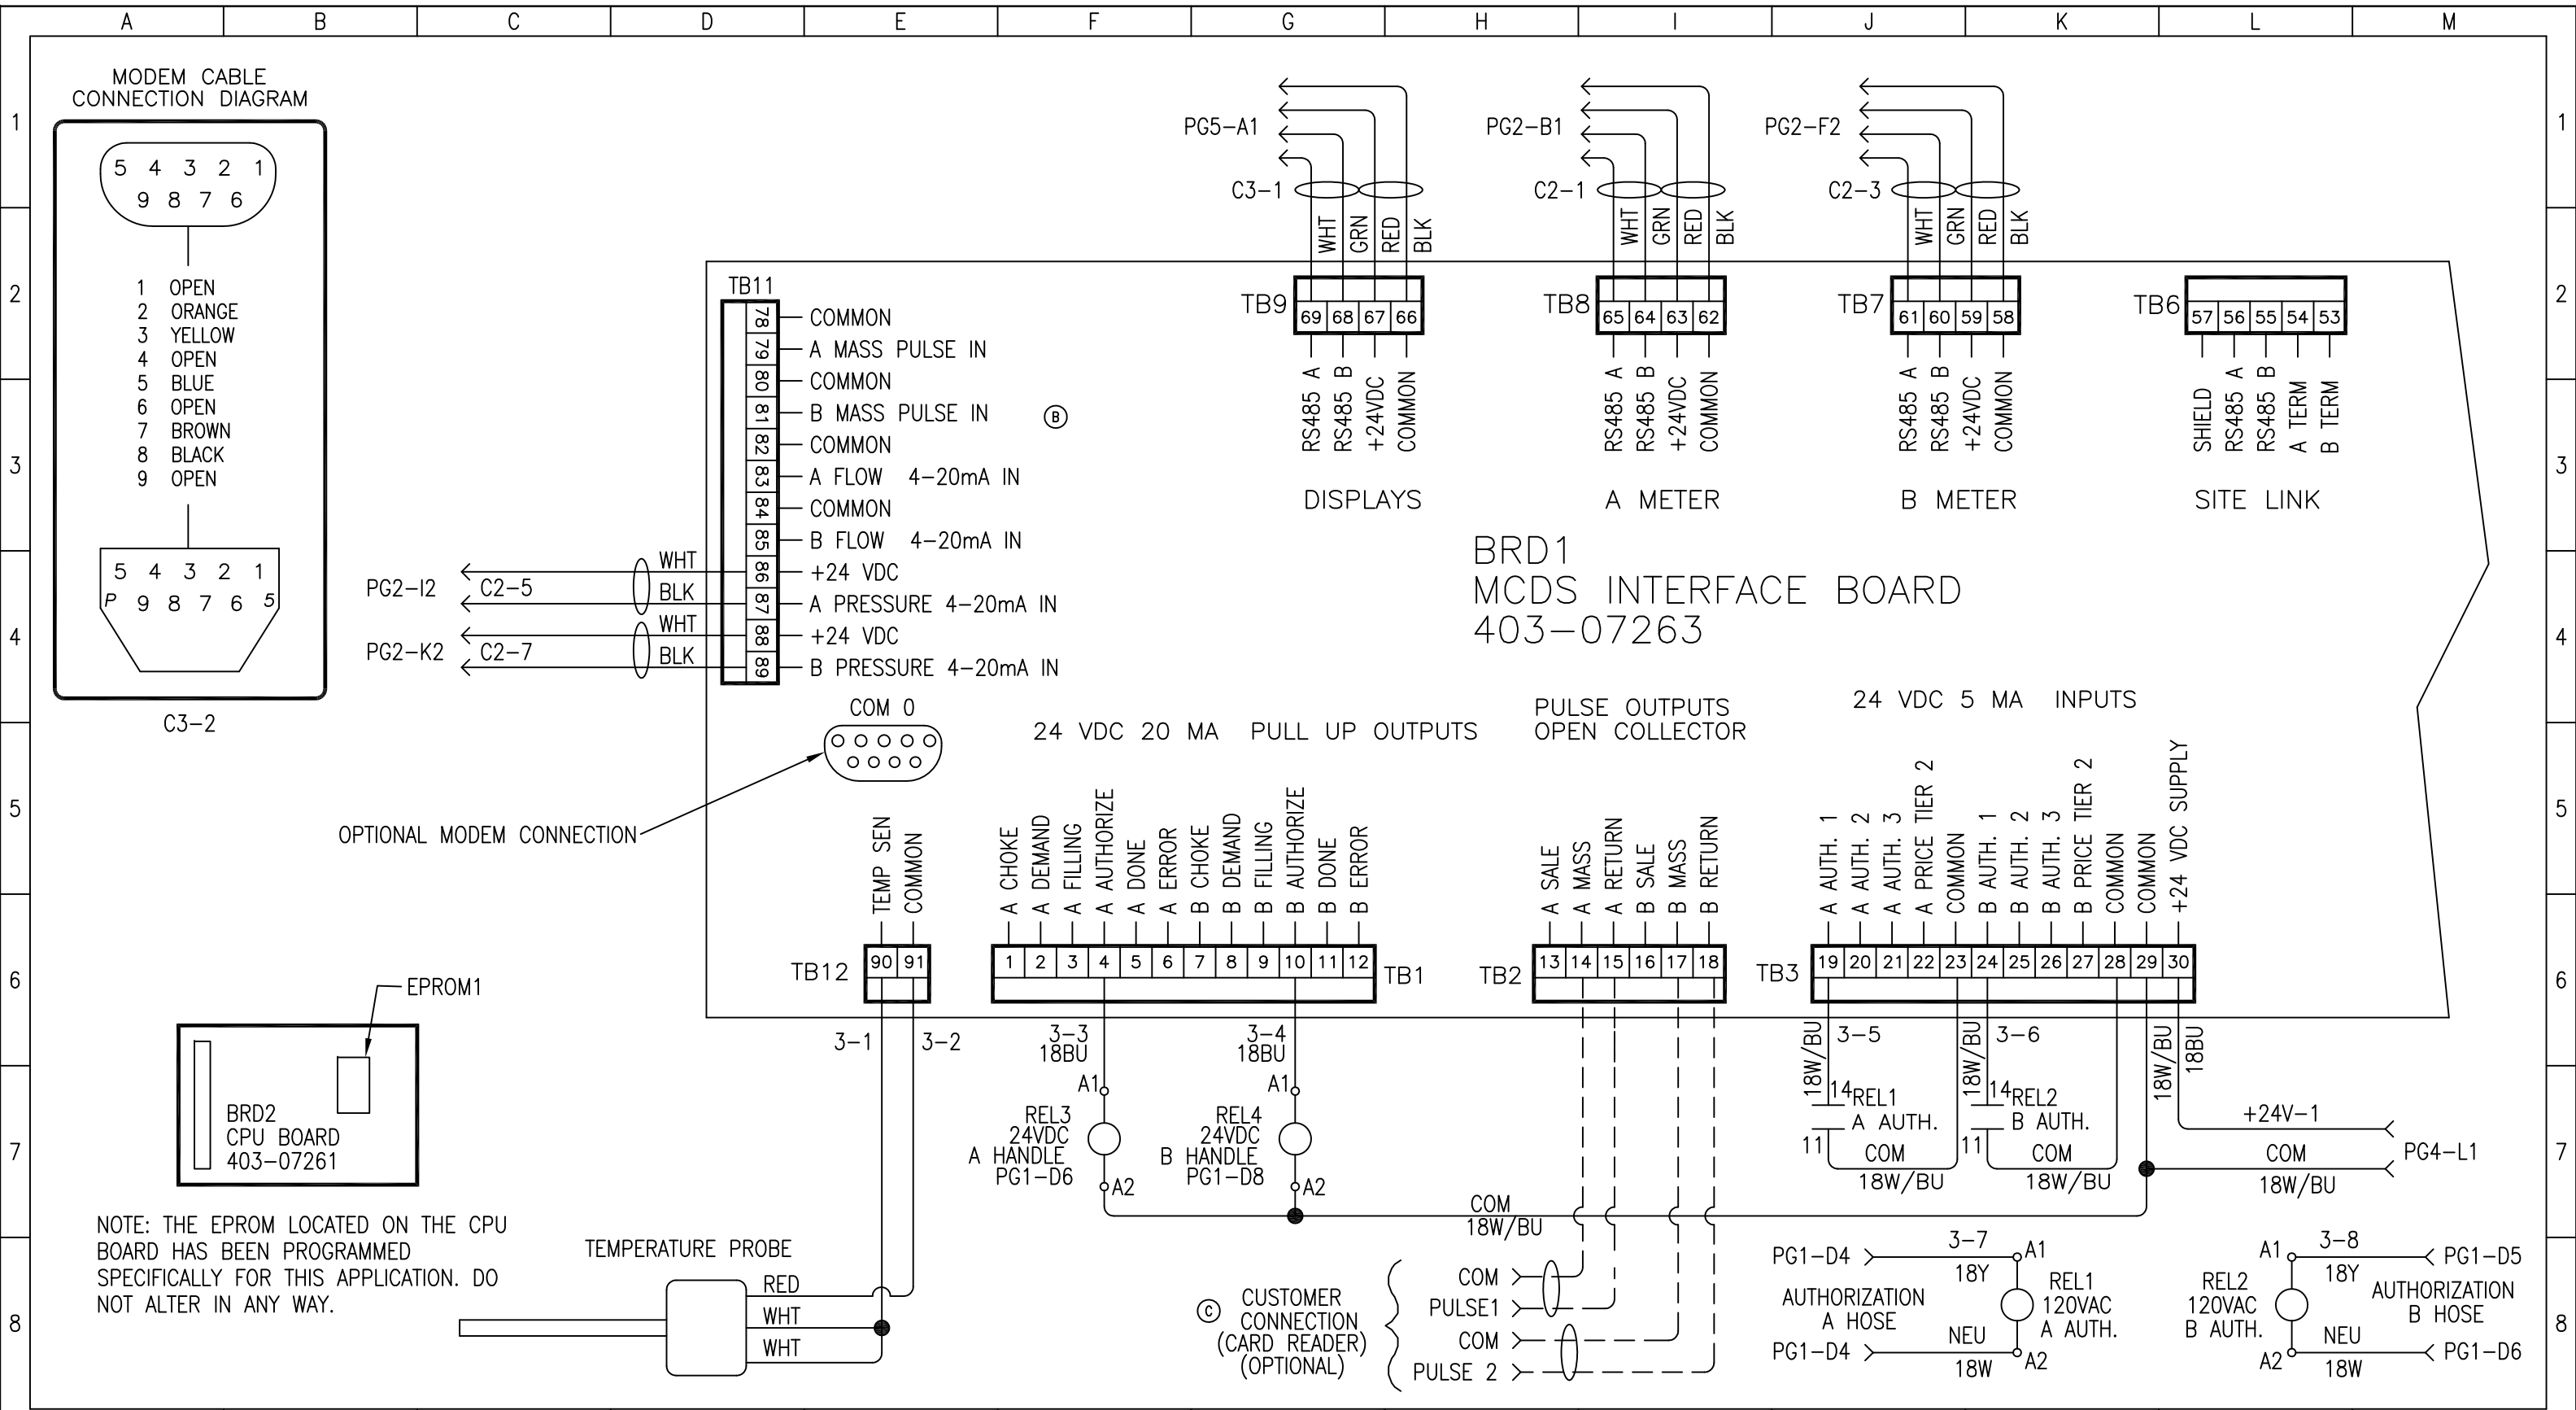


REV	DATE/BY	DESCRIPTION	REV	DATE/BY	DESCRIPTION
J	11/01/09 NDA	AS BUILT			
I	9/23/09 NDA	AS BUILT			



ANGI ENERGY SYSTEMS
15 PLUMB STREET
MILTON, WI 53563
PH: 608-868-4626
FX: 608-868-2723

THIS DRAWING AND ALL INFORMATION THEREIN IS THE SOLE PROPERTY OF ANGI AND SHOULD NOT BE COPIED, REPRODUCED, OR SUBMITTED TO OTHERS WITHOUT WRITTEN AUTHORIZATION. ALL REPRODUCTIONS ARE SUBJECT TO RETURN ON DEMAND.

 UNLESS OTHERWISE SPECIFIED




BREAK SHARP EDGES
ALL DIMENSIONS IN INCHES

FRACTIONAL	±.125
TWO PLACE DECIMAL	±.010
THREE PLACE DECIMAL	±.005
ANGLES	±1°

TITLE
SERIES II DISPENSER SCHEMATIC (TWO LANE)
(2 HOSE, 2 METER, 2 DISPLAY, 120 VAC) ELECTRICAL POWER SUPPLY

CUSTOMER		PROJECT NO.	
SHEET 3/6	SCALE 1:1	DRAWING NO. E45-00-008	REV. K
DRAWN BY SZEPP	DATE 8-2-2004		

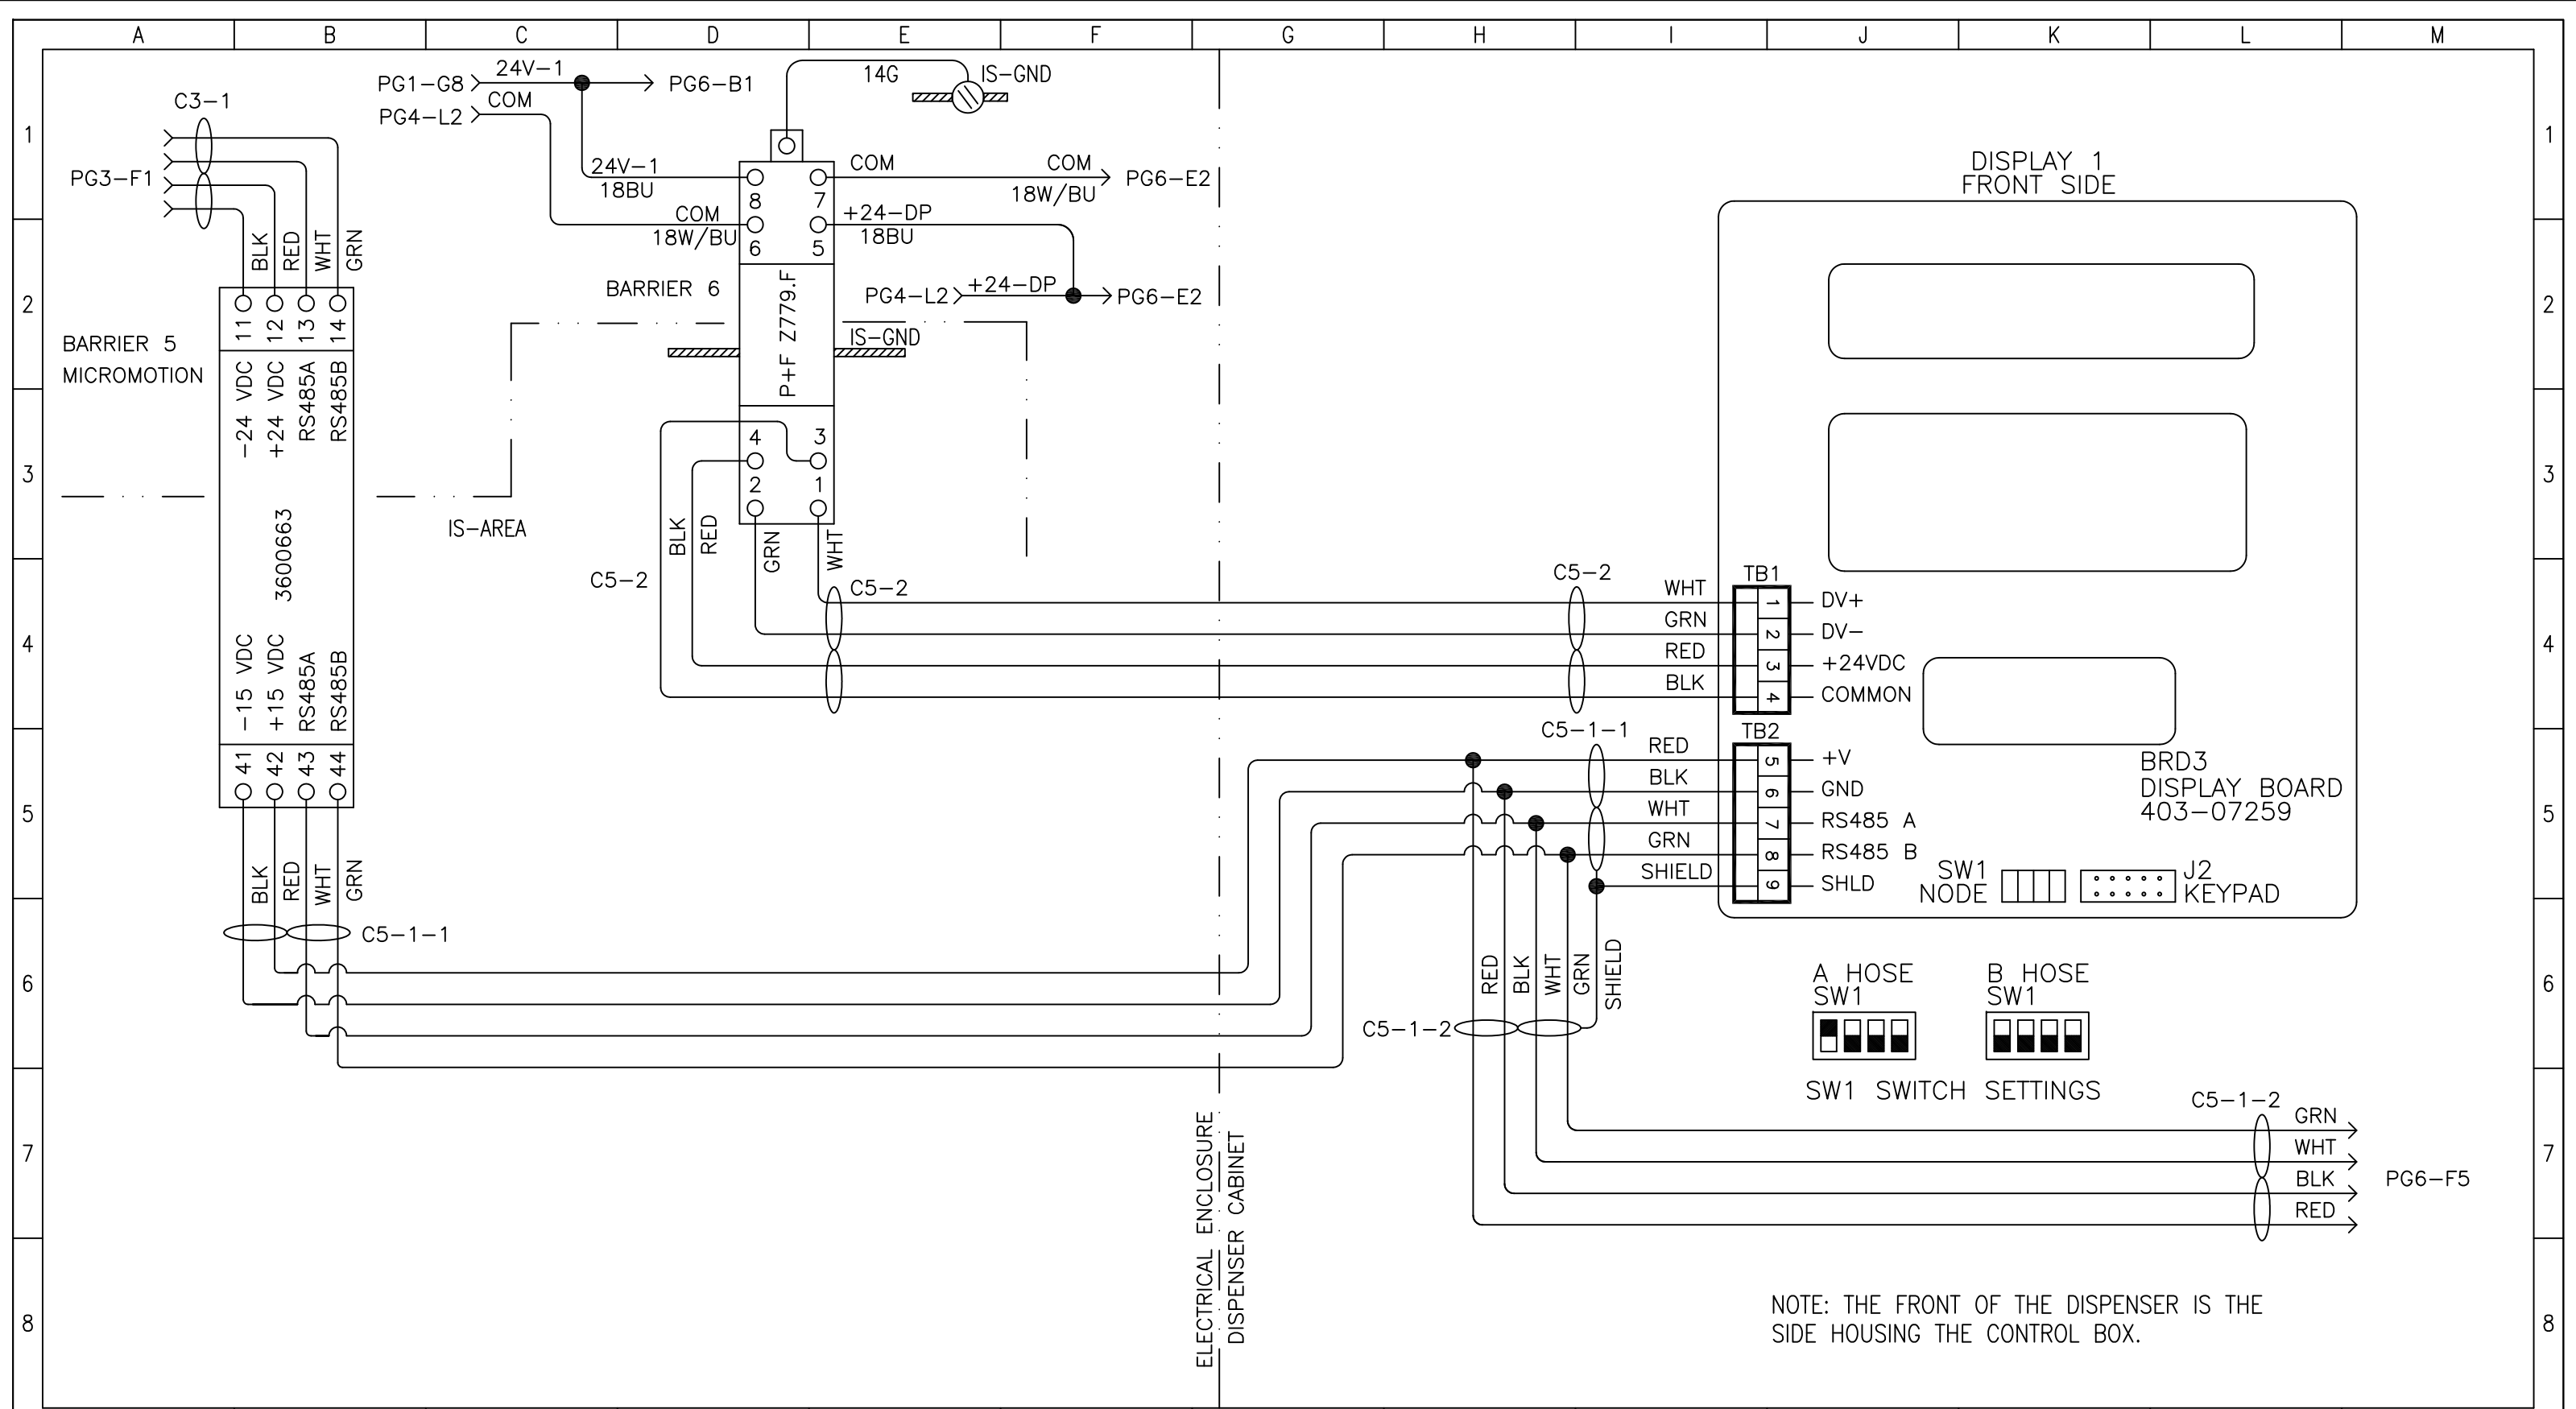


NOTE: THE FRONT OF THE DISPENSER IS THE SIDE HOUSING THE CONTROL BOX.

REV	DATE/BY	DESCRIPTION	REV	DATE/BY	DESCRIPTION
J	11/01/09 NDA	AS BUILT			
I	9/23/09 NDA	AS BUILT			



ANGI ENERGY SYSTEMS
15 PLUMB STREET
MILTON, WI 53563
PH: 608-868-4626
FX: 608-868-2723

 UNLESS OTHERWISE SPECIFIED




BREAK SHARP EDGES

ALL DIMENSIONS IN INCHES

FRACTIONAL	±.125
TWO PLACE DECIMAL	±.010
THREE PLACE DECIMAL	±.005
ANGLES	±1°

TITLE SERIES II DISPENSER SCHEMATIC (TWO LANE) (2 HOSE, 2 METER, 2 DISPLAY, 120 VAC) ELECTRICAL POWER SUPPLY	
CUSTOMER	
SHEET 5/6	SCALE 1:1
DRAWN BY SZEPP	DATE 8-2-2004
PROJECT NO. E45-00-008	
DRAWING NO. E45-00-008	
REV. K	

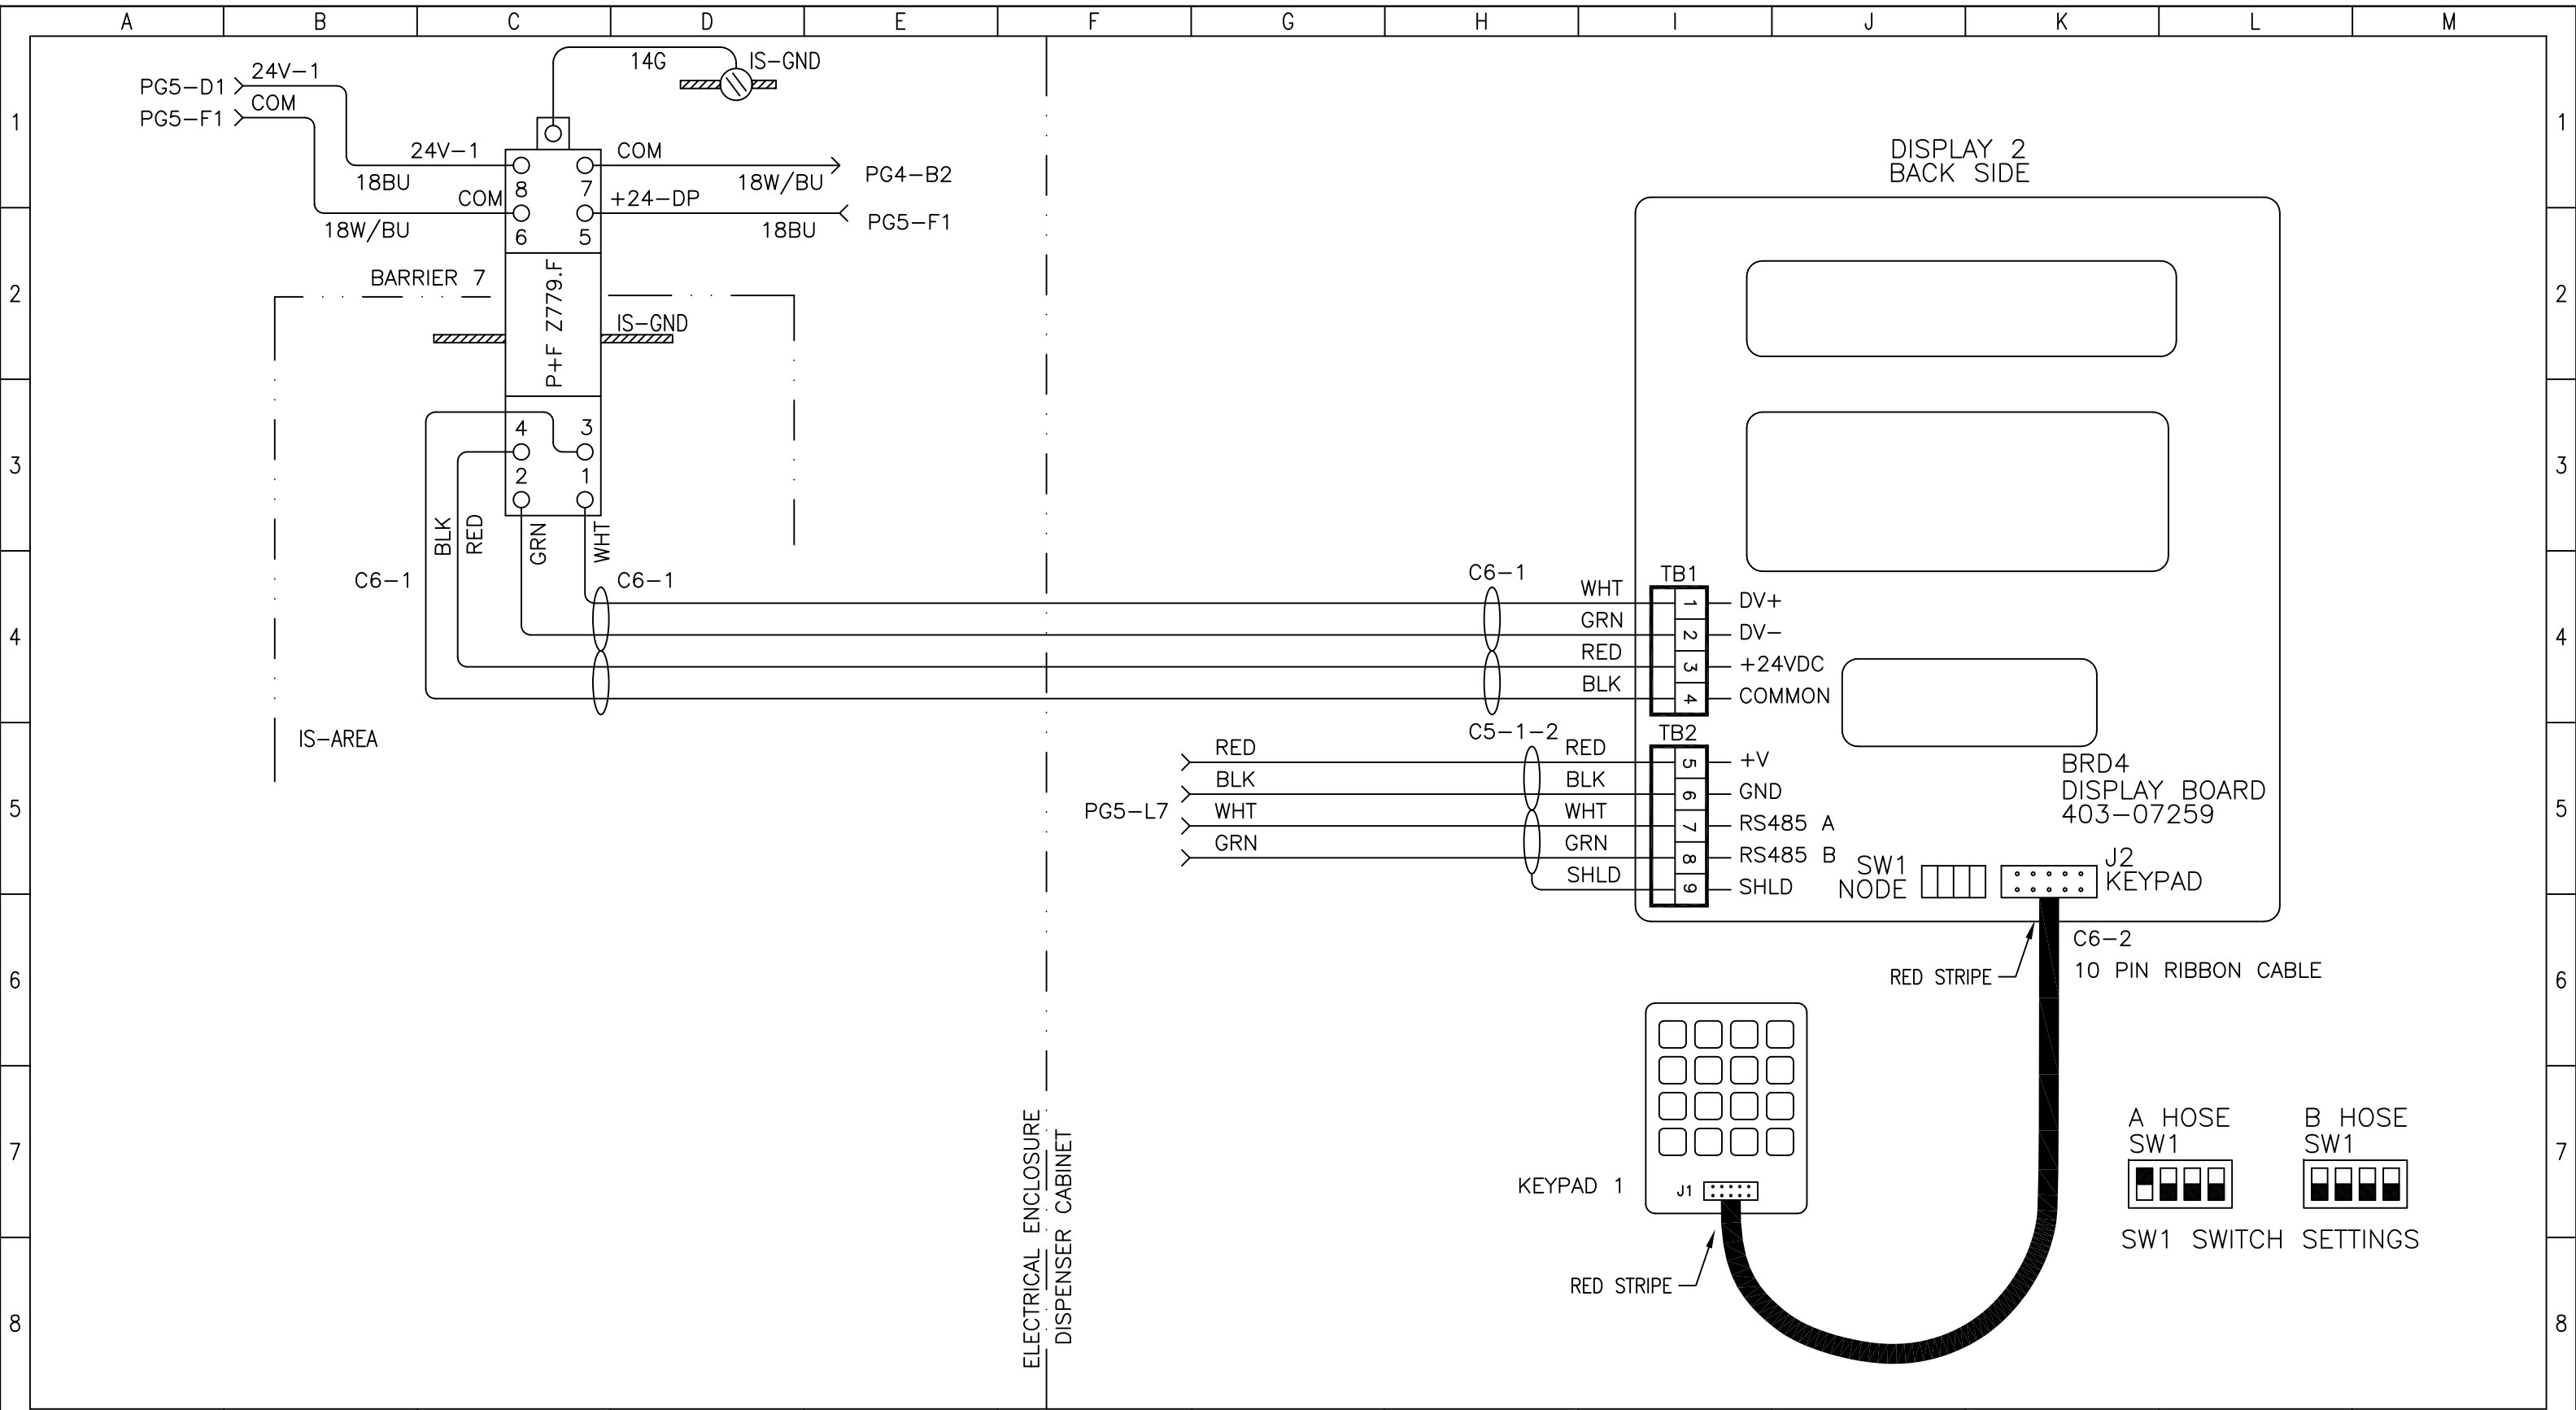


REV	DATE/BY	DESCRIPTION	REV	DATE/BY	DESCRIPTION
J	11/01/09 NDA	AS BUILT			
I	9/23/09 NDA	AS BUILT			



ANGI ENERGY SYSTEMS
15 PLUMB STREET
MILTON, WI 53563
PH: 608-868-4626
FX: 608-868-2723

 UNLESS OTHERWISE SPECIFIED



BREAK SHARP EDGES

ALL DIMENSIONS IN INCHES

FRACTIONAL	±.125
TWO PLACE DECIMAL	±.010
THREE PLACE DECIMAL	±.005
ANGLES	±1°

TITLE
SERIES II DISPENSER SCHEMATIC (TWO LANE)
(2 HOSE, 2 METER, 2 DISPLAY, 120 VAC) ELECTRICAL POWER SUPPLY

CUSTOMER		PROJECT NO.	
SHEET 6/6	SCALE 1:1	DRAWING NO. E45-00-008	REV. K
DRAWN BY SZEPP	DATE 8-2-2004		