




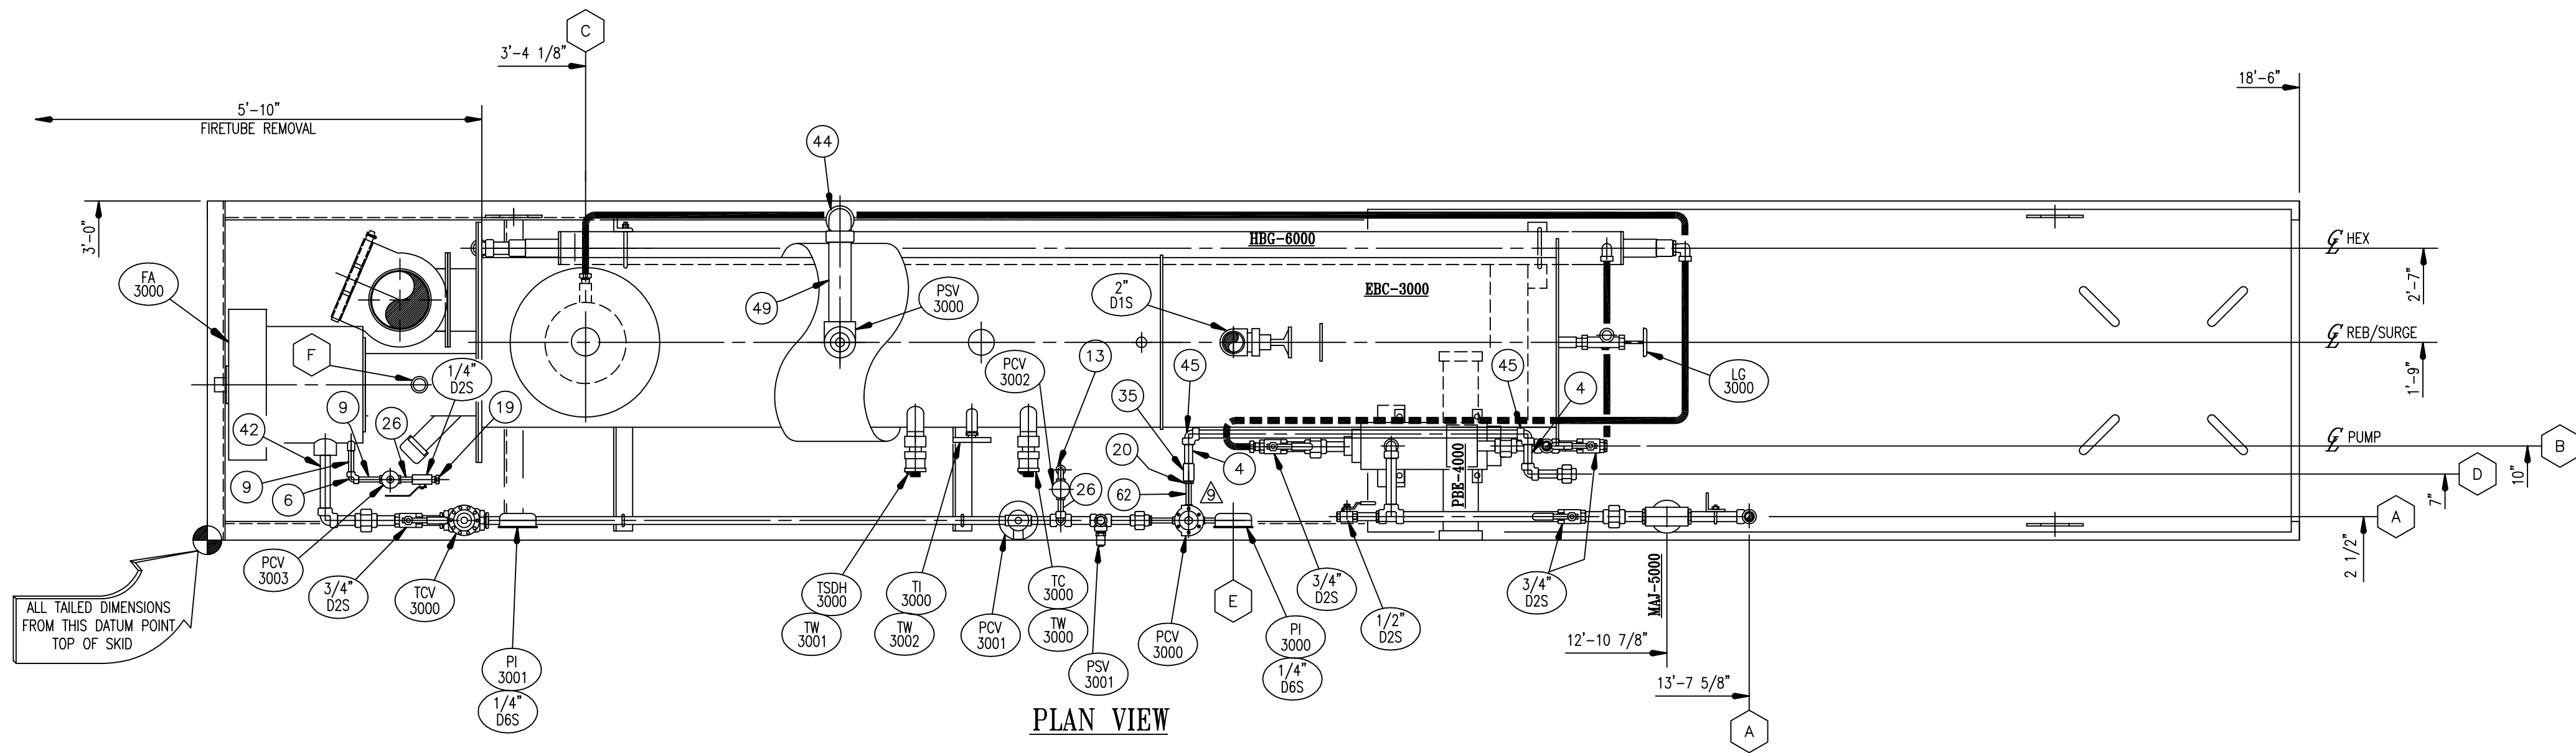


PLAN VIEW

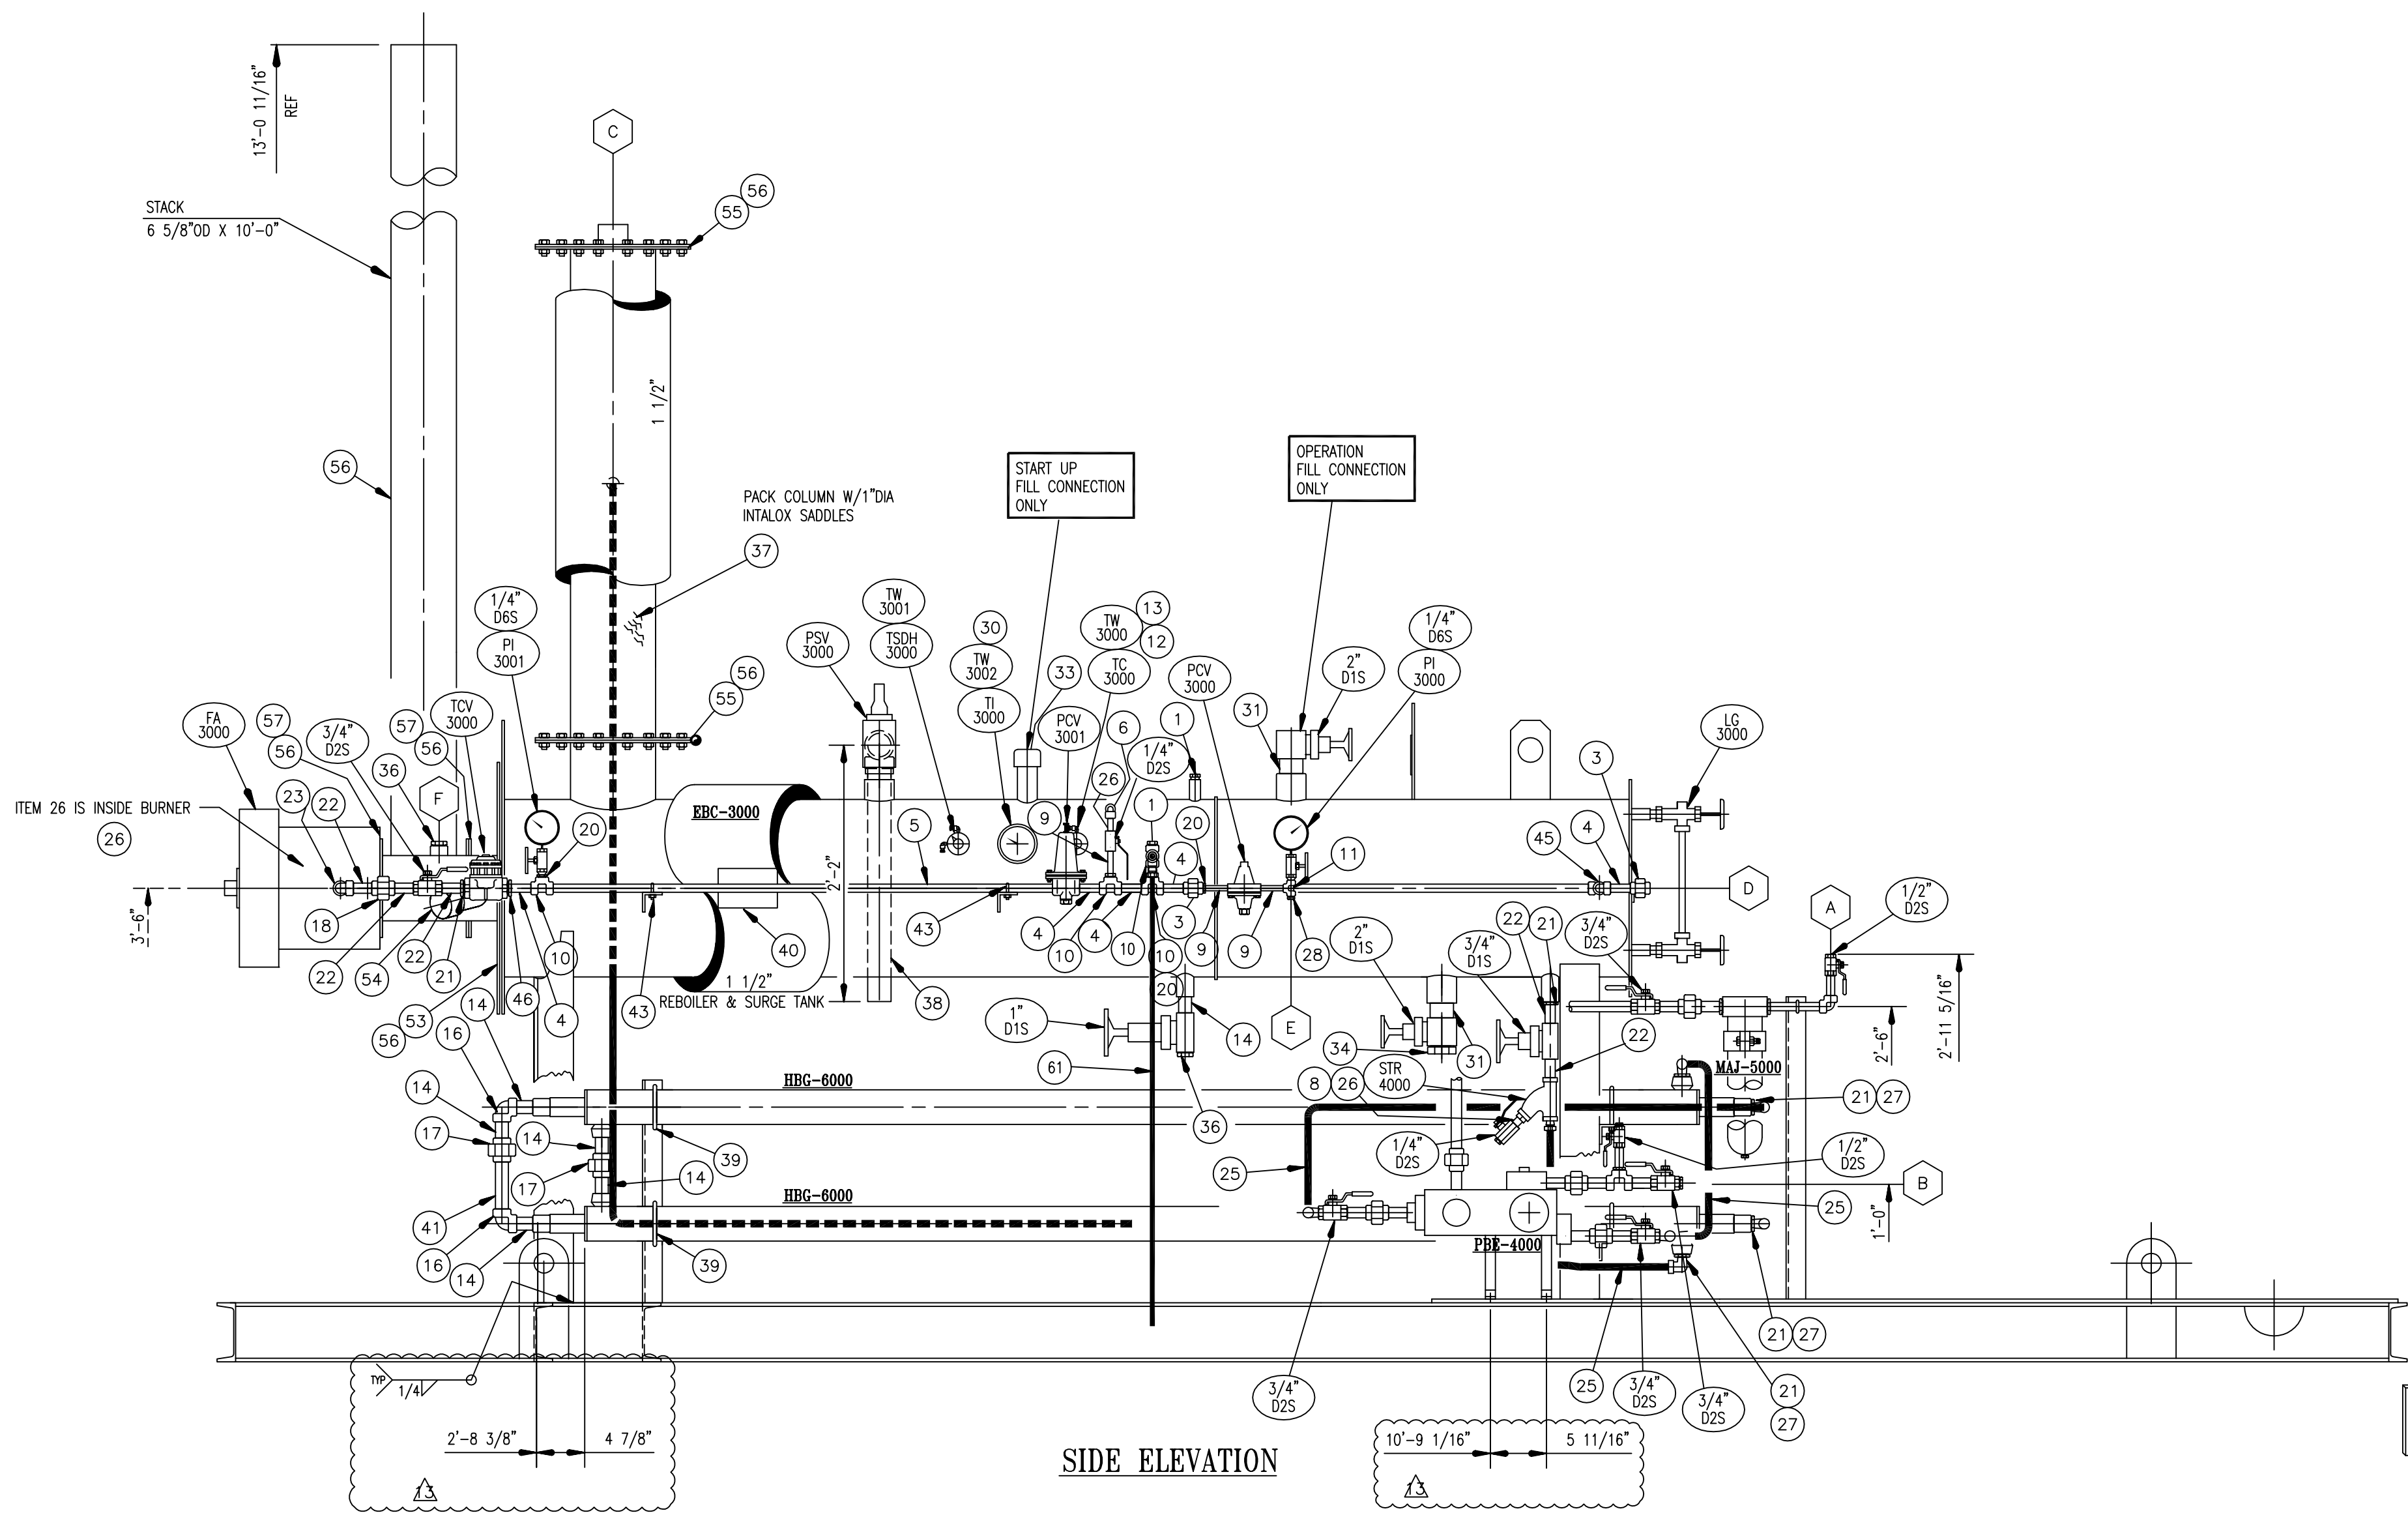

SIDE ELEVATION

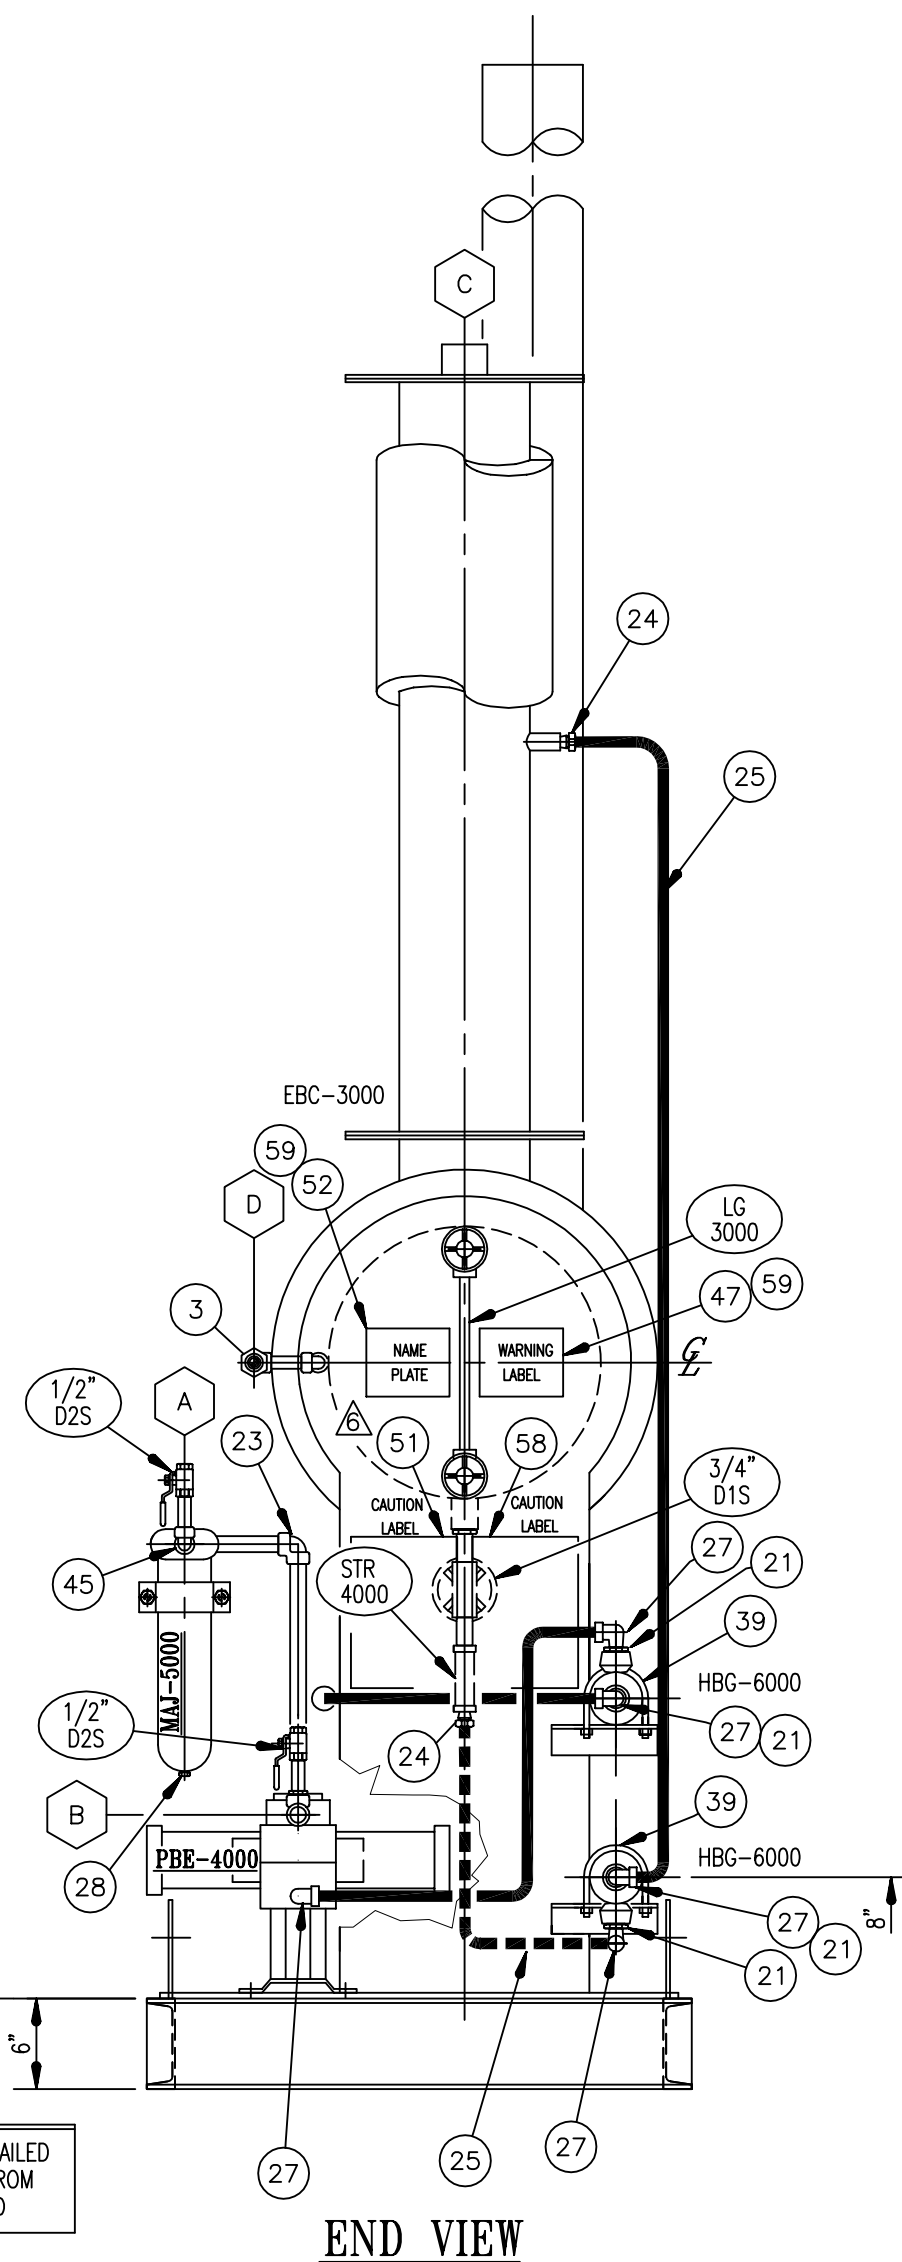

END VIEW

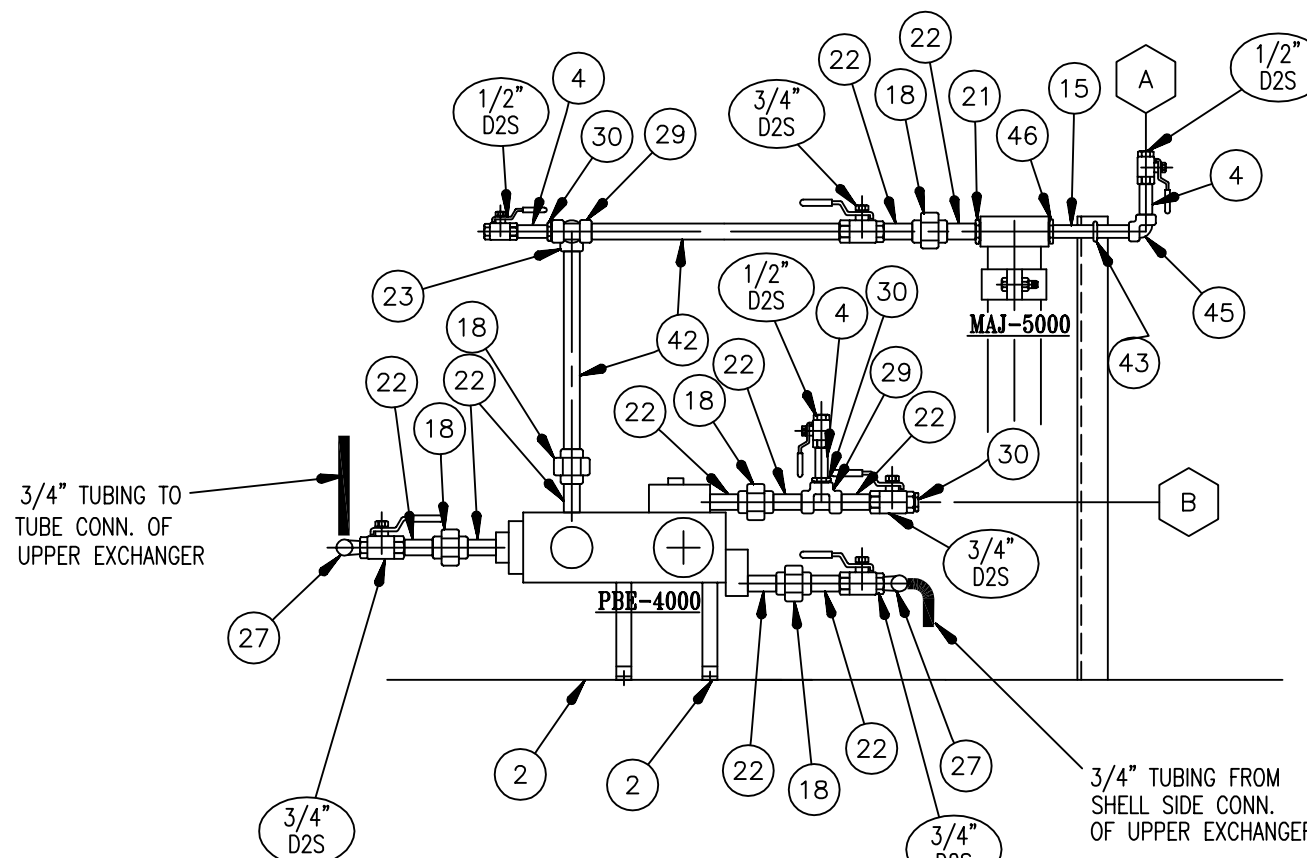

PBE-4000 HOOK-UP

SCHEDULE OF OPENINGS						
MARK	QTY	SERVICE	SIZE	RAT'G	TYPE	REMARKS
A	1	RICH GLYCOL INLET	1/2"	~	FNPT	FROM TOWER
B	1	LEAN GLYCOL OUTLET	1/2"	~	FNPT	TO TOWER
C	1	VAPOR OUTLET	2"	~	FNPT	
D	1	FUEL GAS INLET	1/2"	~	FNPT	
E	1	INSTURMENT GAS SUPPLY	1/4"	~	FNPT	TO TOWER
F	1	B-TEX CONNECTION (SPARE)	1"	~	FNPT	

- GENERAL NOTES:
GLYCOL RECONCENTRATOR ASSEMBLY UNLESS OTHERWISE NOTED.
- ALL GLYCOL AND H.P. GAS PIPING TO BE XH SMLS, SA53-B OR SA106-B.
 - ALL GLYCOL TUBING TO BE STEEL WITH STEEL FITTINGS.
 - INSTRUMENT AND L.P. FUEL PIPING TO BE SMLS XH SA106-B PIPE WITH 2000# FITTINGS.
 - SHOP TO REMOVE ALL BURRS AND ROUGH EDGES FROM SKID AND PIPE SUPPORTS AND ROUND CORNERS.
 - PACK REFLUX COLUMN WITH INTALOX SADDLES.
 - INSULATE REBOILER, SURGE TANK & REFLUX COLUMN WITH 1 1/2" THK. EASY-WRAP AND COVER WITH ALUMINUM JACKETING AND BAND WITH 1 1/2" WIDE GALVANIZED BANDS (OR EQUAL).
 - ALL STUDS, NUTS AND BOLTS TO BE BLACK.
 - ALL OPENINGS TO BE PLUGGED OR COVERED SECURELY.
 - TUBING AND PIPE 1 1/2" AND SMALLER TO BE BENT WHERE POSSIBLE.
 - PAINT: MECHANICAL CLEAN AND COAT WITH (1) COAT OF CAMERON STANDARD MESA TAN(3-5 MILS DFT).
 - DO NOT PAINT ALUMINUM JACKETING.
 - APPROX. WEIGHT EMPTY: 2300 LBS. OPERATING: 3,260 LBS.

13	1/24/19	RB	CL	CL	REVISED PER EWR 650360672	48830055	NAME PLATE BRACKET		GLYCOL RECON ASSEMBLY MODEL 90-200 SKID MOUNTED PN# 99560200	SCALE 1"=1'-0"	CHK'D BY J. J. J.	DATE 3/11/06	CURRENT DWG. DATE
12	7/19/13	DOC	RM	JN	REVISED PER SON ED060084-8	ED060083	SKID						
11	2/22/12	OC	TJW	RH	REVISED PER EGN 4504021	ED060082	REBOILER						
10	10/14/11	OC	JA	HB	TITLE BLOCK REVISION ONLY	ED060085	P&ID						
9	10/20/08	PE	TW	TW	REVISED PER ECO ED060084-9								
NO.	DATE	BY	CHK'D	APP'D	DESCRIPTION	DWG. NO.	DESCRIPTION	REFERENCE DRAWINGS	CUSTOMER	CAMERON STANDARD			