

- 1) AN OBSERVATION WINDOW IS PROVIDED FOR VISUAL INSPECTION OF ROTATING DESICCANT ROTOR.
- 2) ALL FILTERS TO BE EASILY REMOVABLE BY MEANS OF ACCESS PANELS, FOR CLEANING OR REPLACEMENT.
- 3) UNLESS OTHERWISE NOTED, PROVIDE 48" CLEARANCE AROUND THE ENTIRE UNIT FOR SERVICE. EXCEPTION: PROVIDE 48" CLEARANCE FOR ACCESS TO CONTROL PANEL ENCLOSURE.
- 4) UNIT IS SUITABLE FOR OUTDOOR INSTALLATION.
- 5) PROCESS SIDE OF UNIT AND ASSOCIATED DUCTWORK TO BE SINGLE WALL WELDED CONSTRUCTION, 3/4" POLYISOCYANURATE/POLYURETHANE INSULATION
- 6) REACTIVATION SIDE OF UNIT AND ASSOCIATED DUCTWORK TO BE INSULATED WITH 1" THICK RIGID BOARD FOIL FACED FIBERGLASS INSULATION. INSULATION FOIL FACE IS EXPOSED TO REACTIVATION AIR STREAM.
- 7) THE HEIGHT FROM THE BASE OF THE BRY-AIR SKID TO THE SUPPLY DISCONNECT SWITCH IS SHOWN ON THIS DRAWING. THE PARTY RESPONSIBLE FOR APPROVAL OF THESE DRAWINGS MUST VERIFY HEIGHT IS ACCEPTABLE WITH LOCAL CODES AND BUILDING AUTHORITIES. HEIGHT SHOWN DOES NOT TAKE INTO CONSIDERATION IF THE EQUIPMENT WILL BE INSTALLED ON A PAD OR PLATFORM.




PLAN VIEW




FRONT ELEVATION VIEW

ESTIMATED EQUIPMENT WEIGHT 4,500 LBS

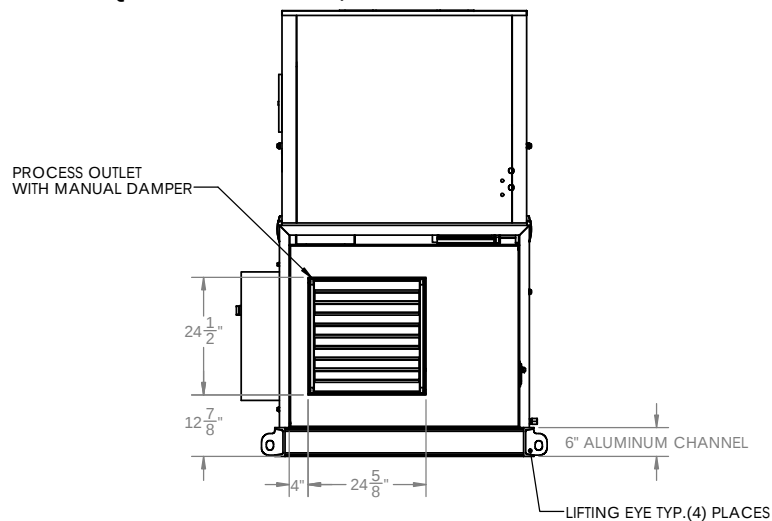


RIGHT ELEVATION VIEW


 BRY-AIR, INC. 10065 S. R. 37 W JUBURGH, OH 43074 (740) 965-2074 (740) 965-3470 www.BRY-AIR.com <i>Not Endorsed Goodwill Intangible Asset</i>	NAME DATE	TITLE UNIT OUTLINE	
	DRAWN RITC	9/5/17	
	CHECKED WR	WR	VFB-9-E-2100-DXA-EAH-HEPA
	UNLESS OTHERWISE SPECIFIED: ALL DIMENSIONS ARE FOR REFERENCE ONLY		
CUSTOMER: LUBRIZOL OILFIELD CHEMISTRY LLC LETTSDALE, PA	CUSTOMER # 4502802462	SIZE DWG. NO. D 217064-U001	
		SCALE: 1:20	REV SHEET 1 OF 2

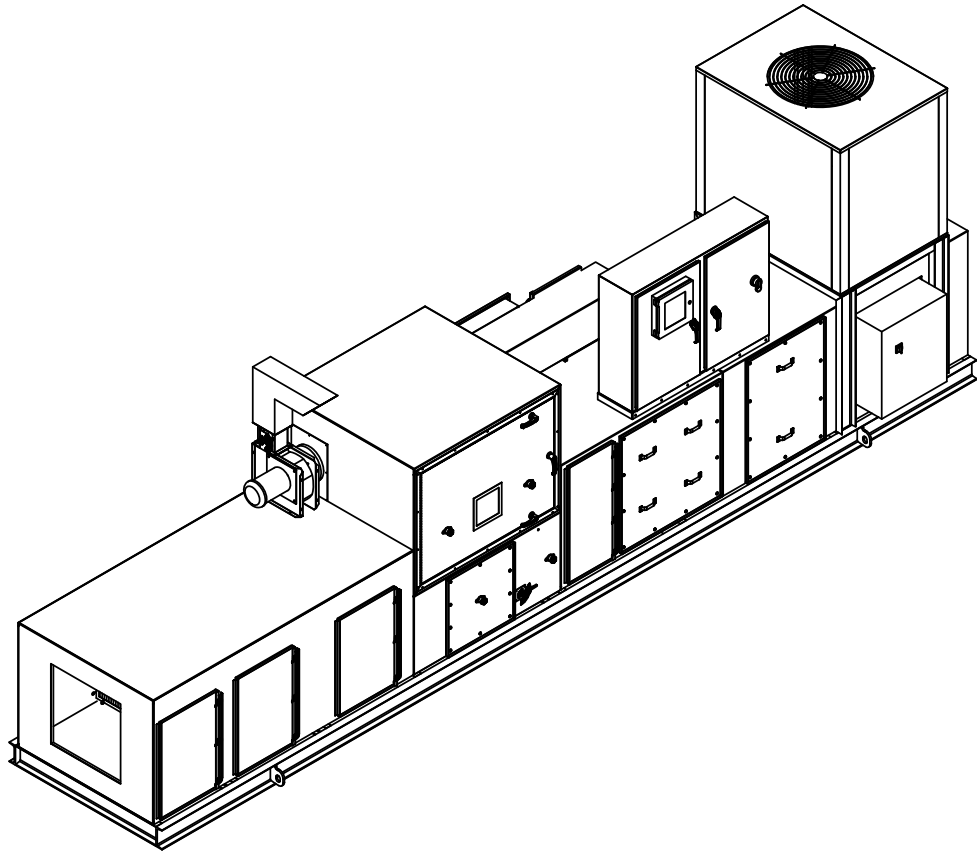

FRONT ISOMETRIC VIEW

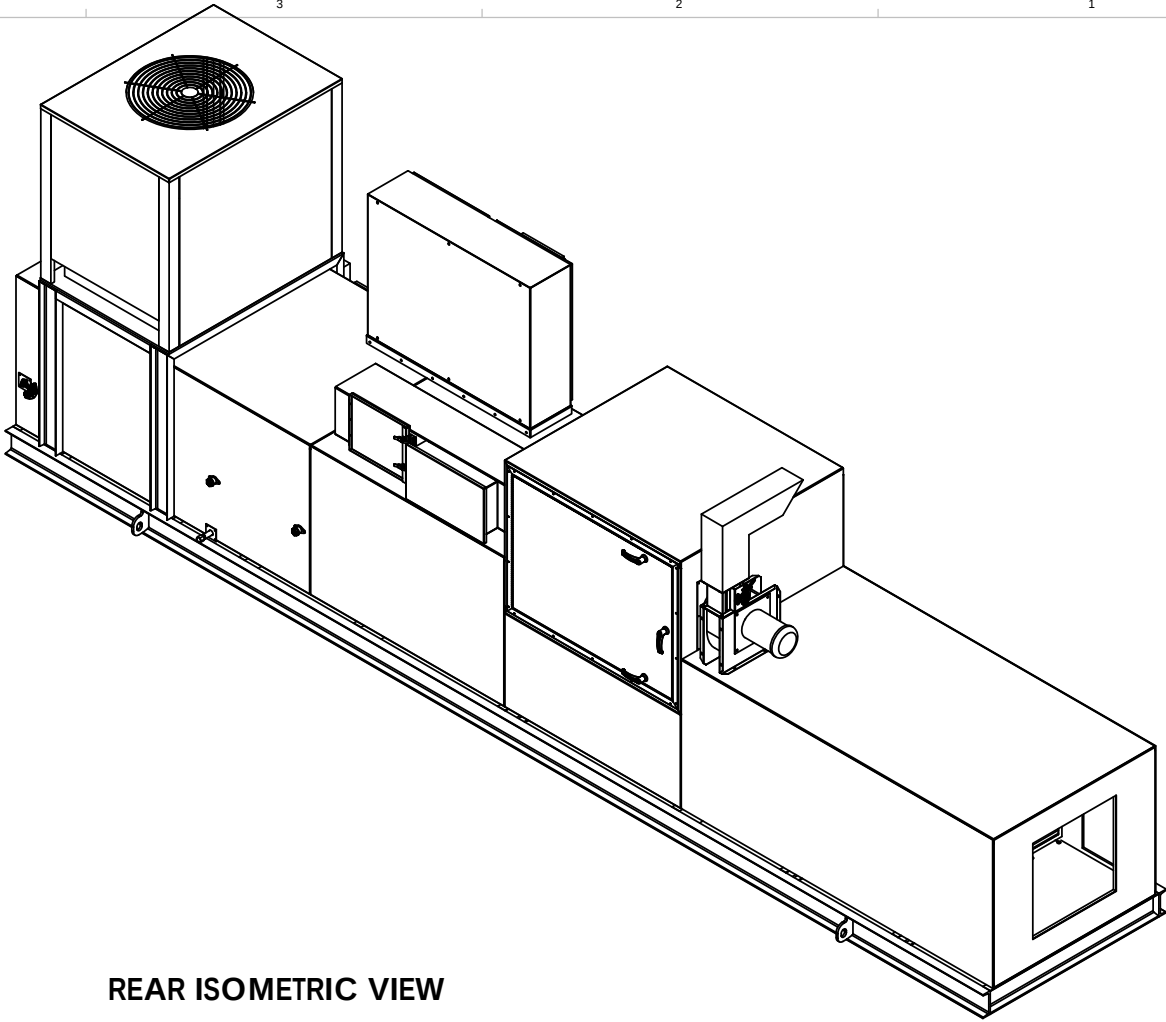

REAR ISOMETRIC VIEW

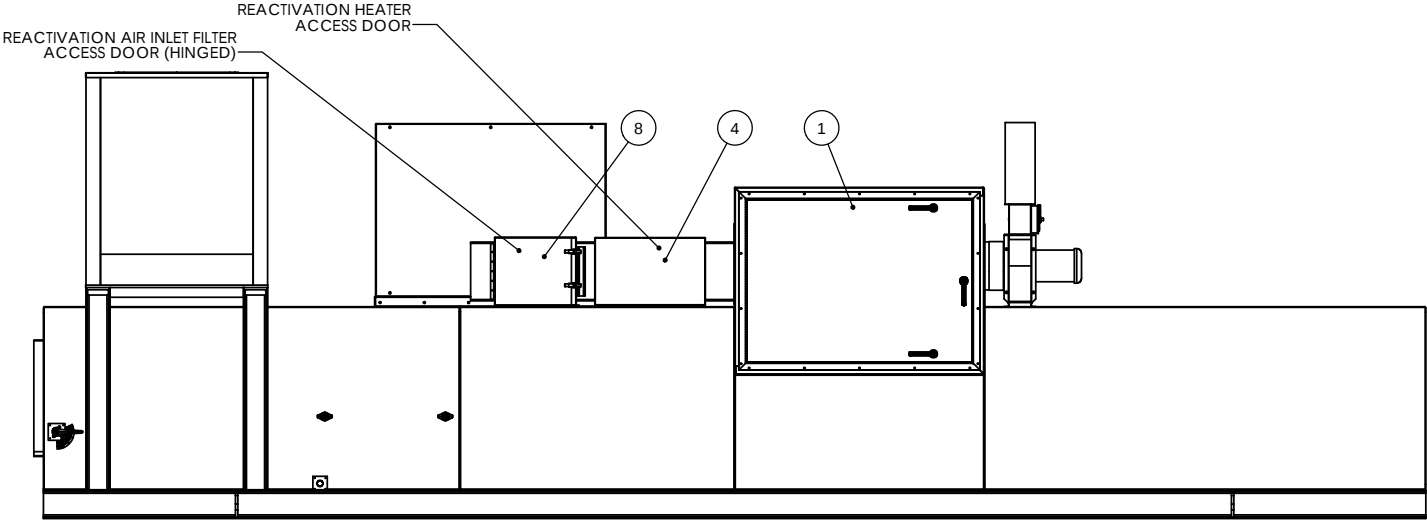

REAR ELEVATION VIEW



BRY-AIR, INC.
10793 ST. RT. 37 W.
SUNBURY, OH 43074
(740) 965-2974 p
(740) 965-5470 f
www.BRY-AIR.com

Best Environmental
Conditioning Solutions™

CUSTOMER:
LUBRIZOL OILFIELD CHEMISTRY, LLC
LETTSDALE, PA

DRAWN	NAME	DATE
RTIC		9/5/17
CHECKED	WR	WR
UNLESS OTHERWISE SPECIFIED: ALL DIMENSIONS ARE FOR REFERENCE ONLY		
CUSTOMER # 4502802462		

SIZE	DWG. NO.	REV
D	217064-U001	
SCALE: 1:20		SHEET 2 OF 2

TITLE:

UNIT OUTLINE

VFB-9-E-2100-DXA-EAH-HEPA