



INSTRUMENT WIRING

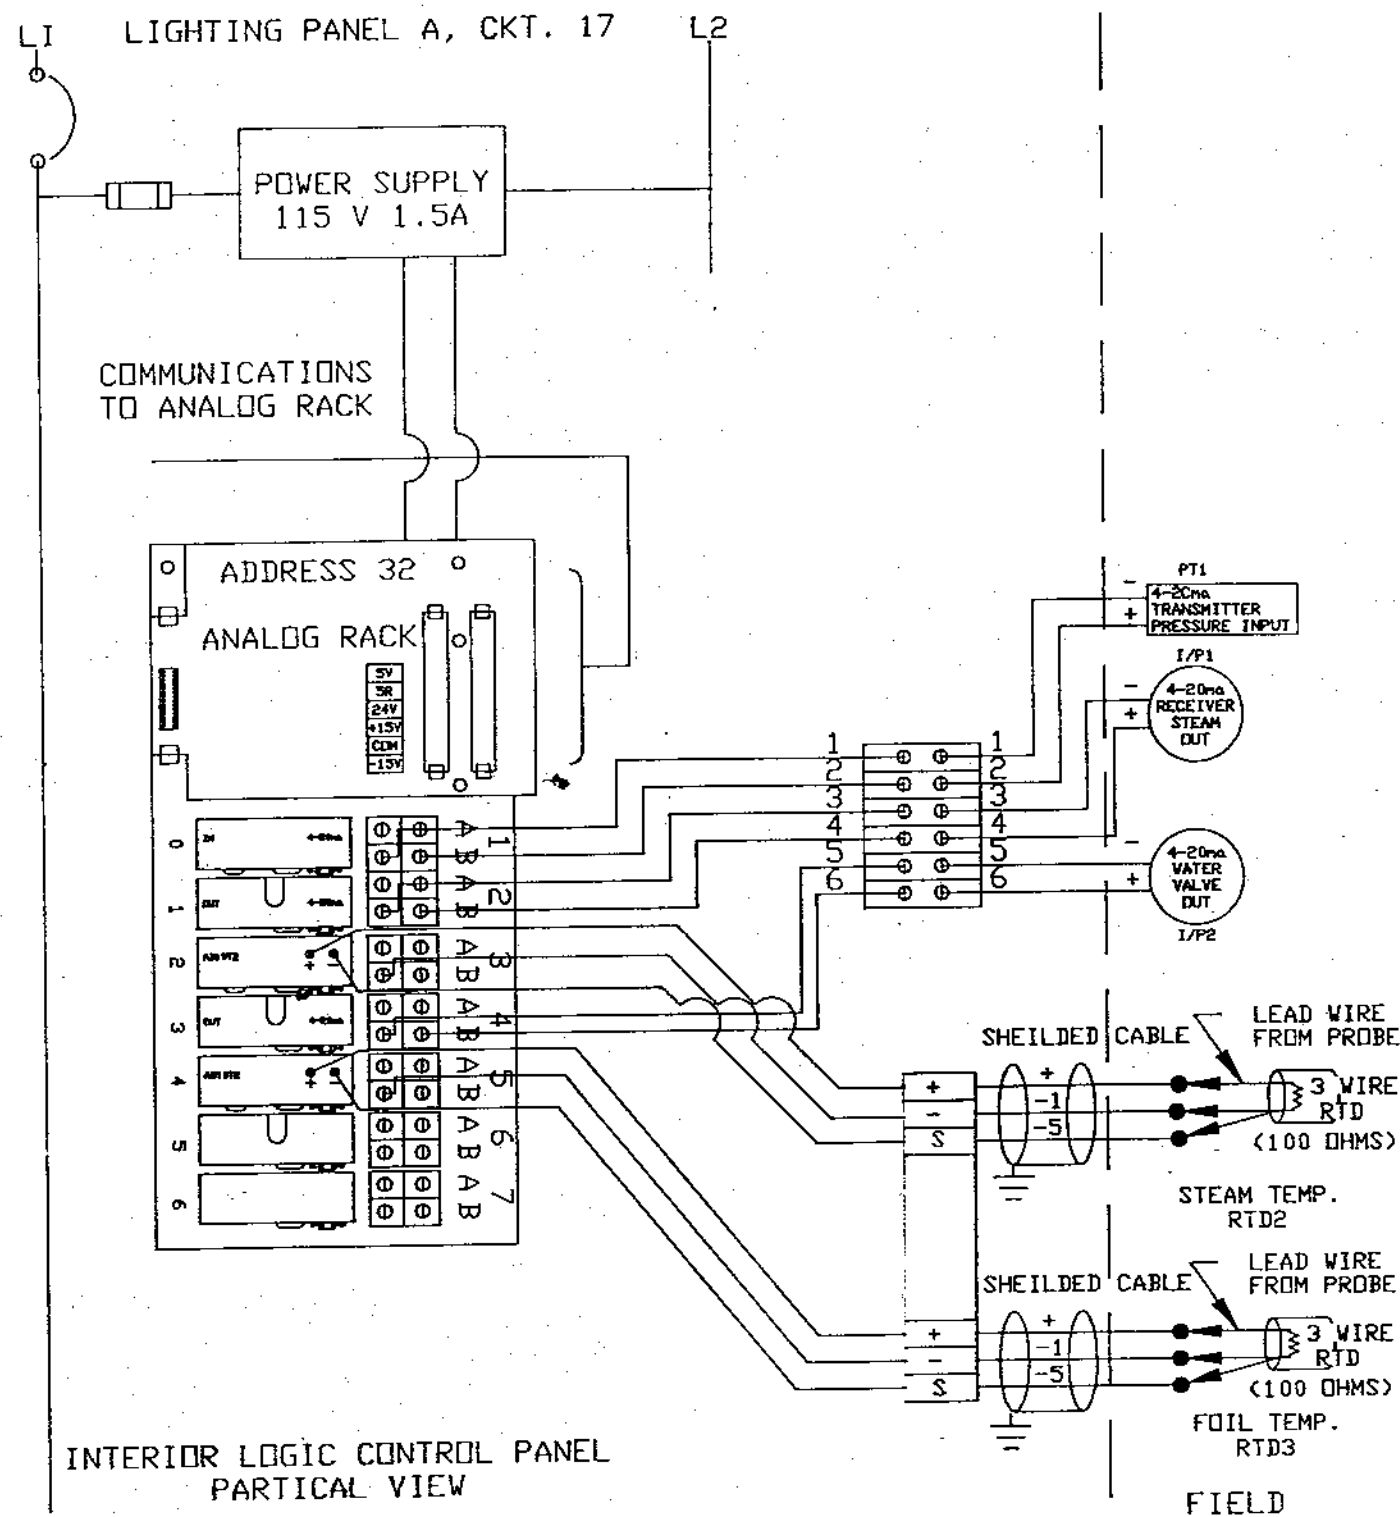

INSTRUMENT P & ID

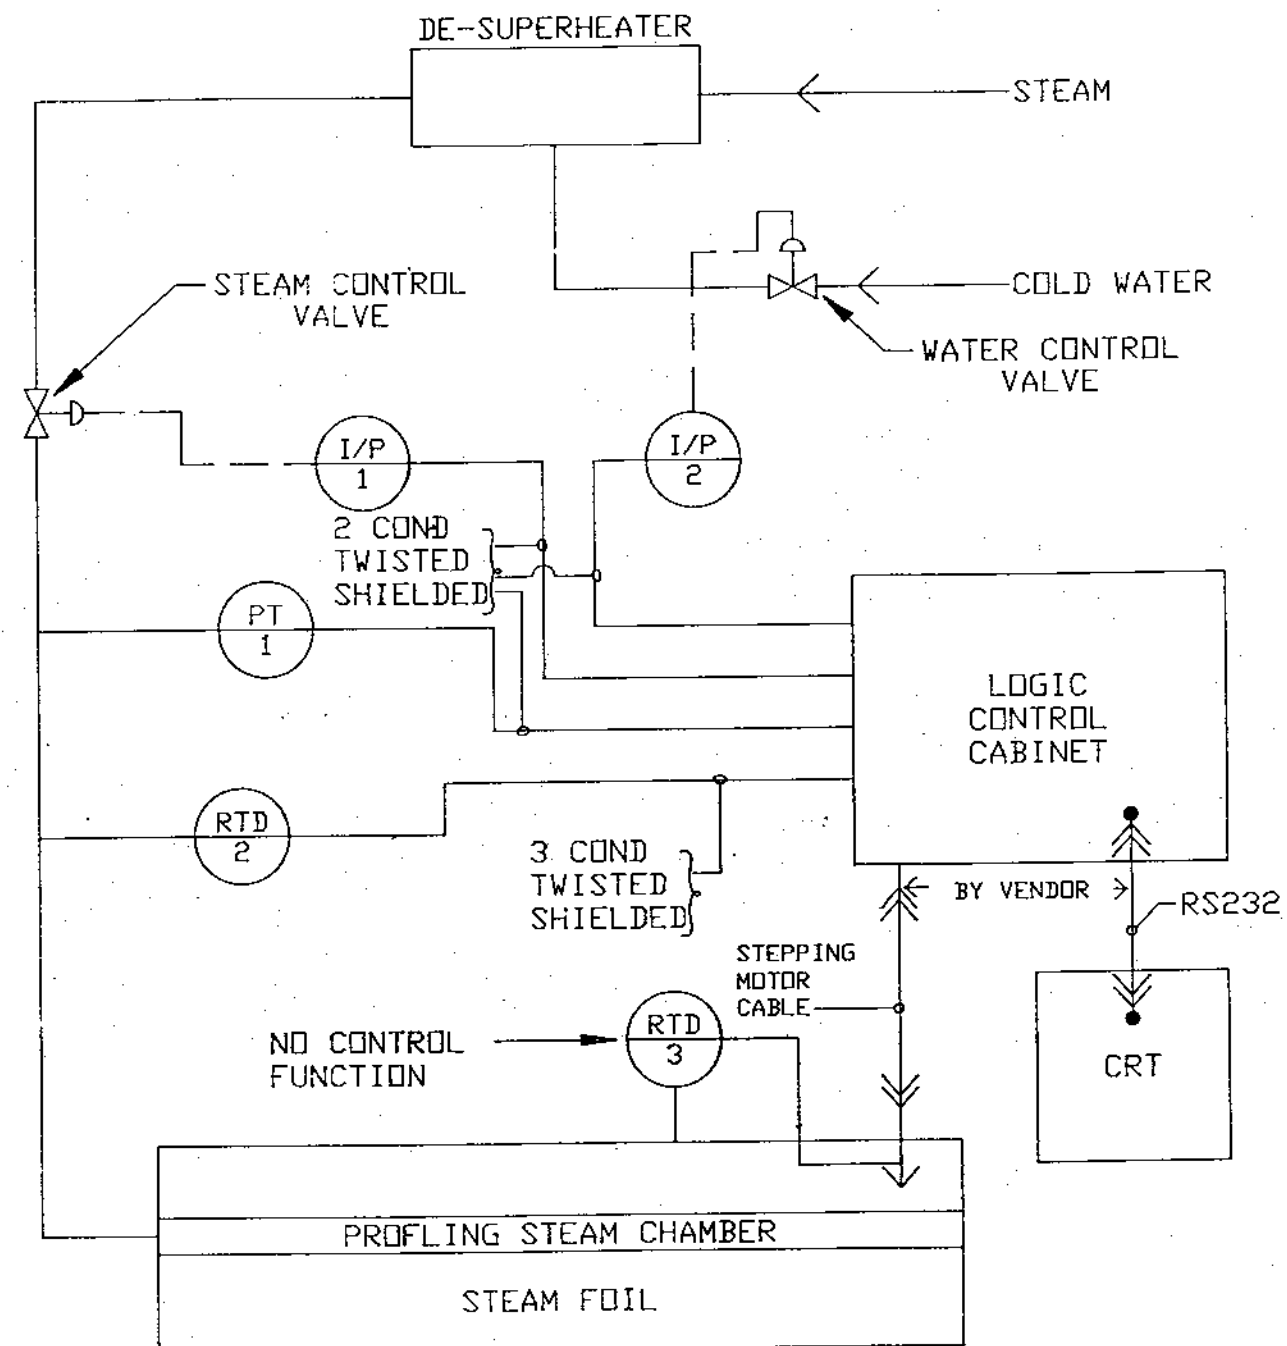

● AT OPERATORS PANEL
■ ON START DOOR

mead

LAURAL MILL
ENGINEERING
DEPARTMENT

Specialty Paper Division
South Lee Massachusetts 01260

XREF. DWG. NO. L08572 REV B
DESCRIPTION (THERMO ELECTRON) VO BOARDS
SF-3244A WIRING WITH ANALOGS

MTR. NO.
HP. FLA. SF.
RPM FRAME
VOLTS STR.SIZE/TYPE
MCC EQUIP. NO.
MCC NO.
MCC COMP. NO.
MCC SYSTEM NO.

ORIGIN DATE 6-7-91

REV. DATE
REV. LEVEL 1
DRWN. BY DH/CE APP. BY

SHT.-4 OF 4 THERMO ELECTRON STEAM BOX PROJECT #72
INSTRUMENT DIAGRAM

JOB NO. L10004 SHEET 3 OF 4